


**SHEET REFERENCE SCHEDULE**

SHEET NO.	DESCRIPTION
9	ARCHITECTURAL SECTIONS - TYPICAL CLASSROOM
11	ARCHITECTURAL SECTIONS - COVERED PASSAGE
12	DOOR & WINDOW DETAILS - TYPICAL
13	INTERIOR FINISH, DOOR & WINDOW SCHEDULES
14	MECHANICAL PLAN - SEE SHEET NO. 21
15	MECHANICAL PLAN - SEE SHEET NO. 21
16	MECHANICAL PLAN - SEE SHEET NO. 21
17	MECHANICAL PLAN - SEE SHEET NO. 21
18	MECHANICAL PLAN - SEE SHEET NO. 21
19	MECHANICAL PLAN - SEE SHEET NO. 21
20	MECHANICAL PLAN - SEE SHEET NO. 21
21	MECHANICAL PLAN - SEE SHEET NO. 21
22	MECHANICAL PLAN - SEE SHEET NO. 21
23	MECHANICAL PLAN - SEE SHEET NO. 21
24	MECHANICAL PLAN - SEE SHEET NO. 21
25	MECHANICAL PLAN - SEE SHEET NO. 21
26	MECHANICAL PLAN - SEE SHEET NO. 21
27	MECHANICAL PLAN - SEE SHEET NO. 21

**LEGEND & SYMBOLS USED**

DR.	DRINKING FOUNTAIN	EEU	FLOOR EXPANSION JOINT
WH.	WATER HEATER	CEU	CEILING EXPANSION JOINT
MT.	METAL TRAP	MT.	METAL TRAP
ST.	STAINLESS STEEL	MT.	METAL TRAP
SS.	SEMI-CIRCULAR SINK	MT.	METAL TRAP
LA.	LANDSCAPE	MT.	METAL TRAP
UB.	UNDERBELL	MT.	METAL TRAP
WC.	WATER CLOSET	MT.	METAL TRAP
WT.	WATER TANK	MT.	METAL TRAP
CT.	CURTAIN TRACK	MT.	METAL TRAP
FA.	FRESH AIR	MT.	METAL TRAP

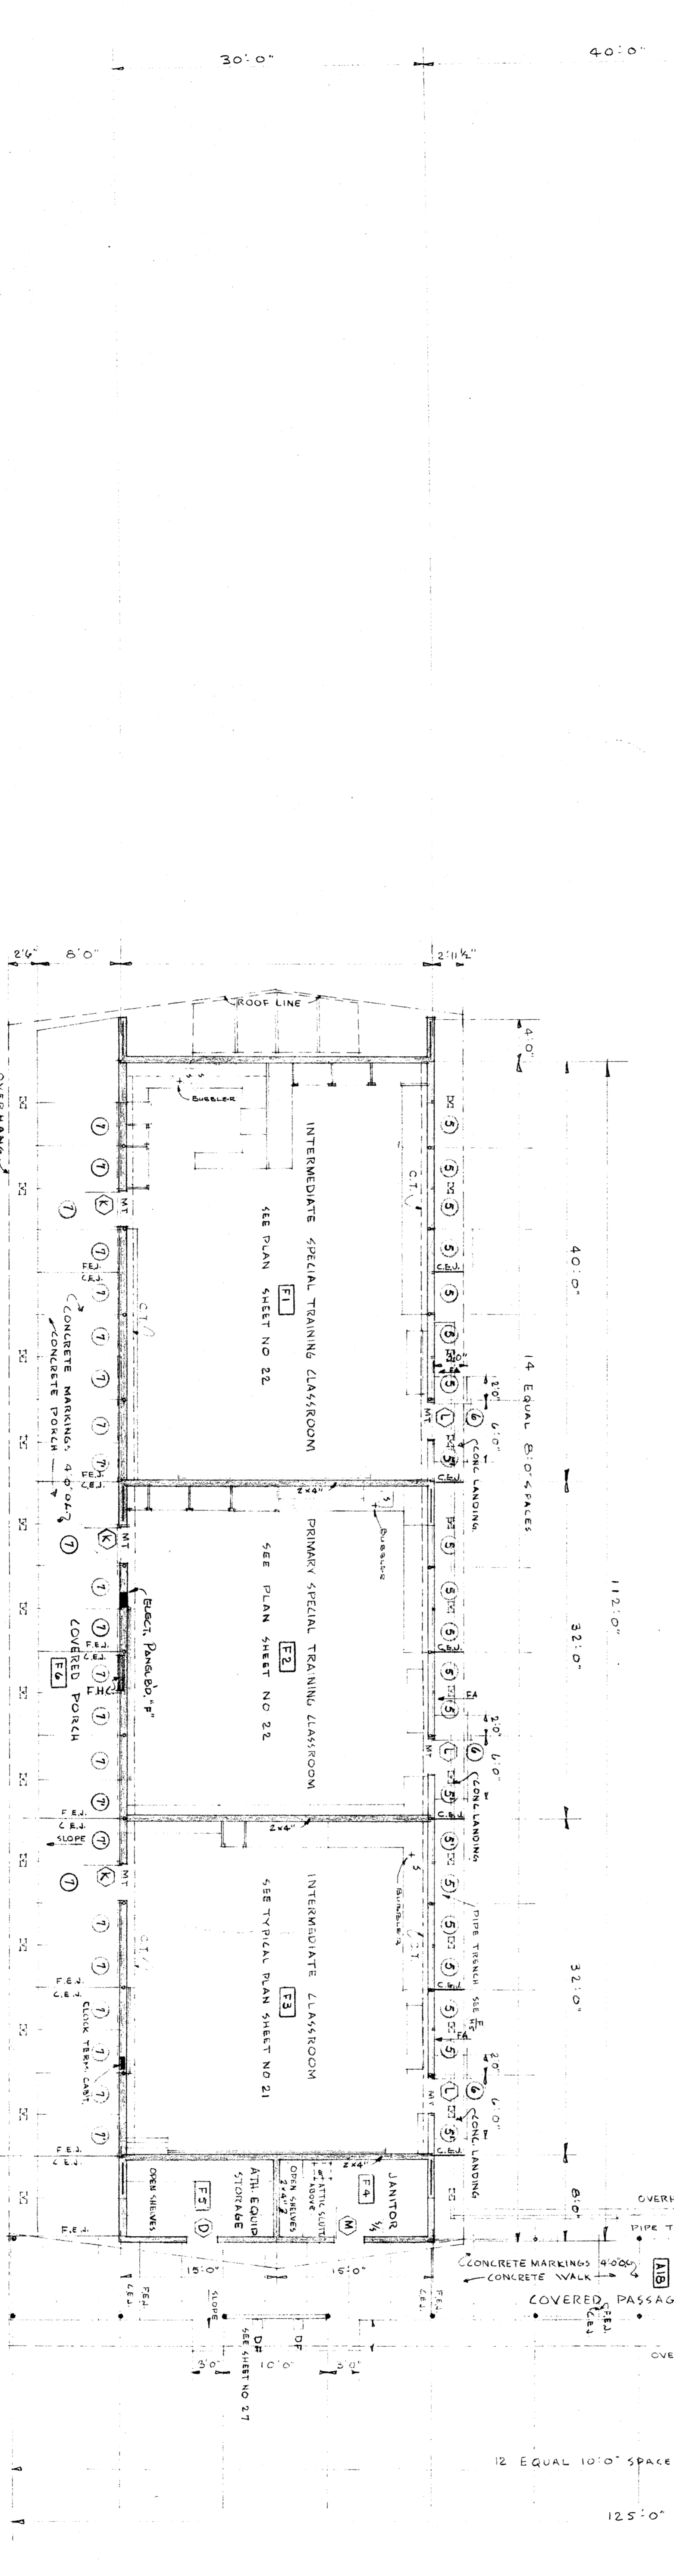

FLOOR PLAN UNITS "E" & "F"

<p>STAMP DIVISION OF ARCHITECTURE</p> <p>11832</p> <p>DATE: 10.8.53</p>	<p>ARCHITECTS</p> <p>WILBERT MICHAEL &amp; ASSOCIATES</p> <p>4000 RIVERSIDE DRIVE, SUITE 100, DALLAS, TEXAS</p>	<p>CLIENT</p> <p>BAKERFIELD CITY SCHOOL DISTRICT</p> <p>BAKERFIELD, KERN COUNTY, CALIFORNIA</p>	<p>DATE</p> <p>10.8.53</p>	<p>PROJECT</p> <p>FLOOR PLAN</p>	<p>DATE</p> <p>11.2.53</p>	<p>PROJECT</p> <p>UNITS "E" &amp; "F"</p>	<p>DATE</p> <p>11.2.53</p>	<p>PROJECT</p> <p>UNITS "E" &amp; "F"</p>
---	---	---	----------------------------	----------------------------------	----------------------------	---	----------------------------	---

