

18th STREET


● ELECTRICAL SHUT OFF
CUSTODIAL ROOM

● GAS SHUT OFF - NORTHWEST
AREA OF CAMPUS

● WATER SHUT OFF
EAST OF ROOM 10

● TOOLS - GAS LOCATED AT
MAIN SHUT OFF - WATER
IN CUSTODIAL ROOM

● FIRE ALARM PANEL - HEALTH
ROOM AT FRONT OFFICE

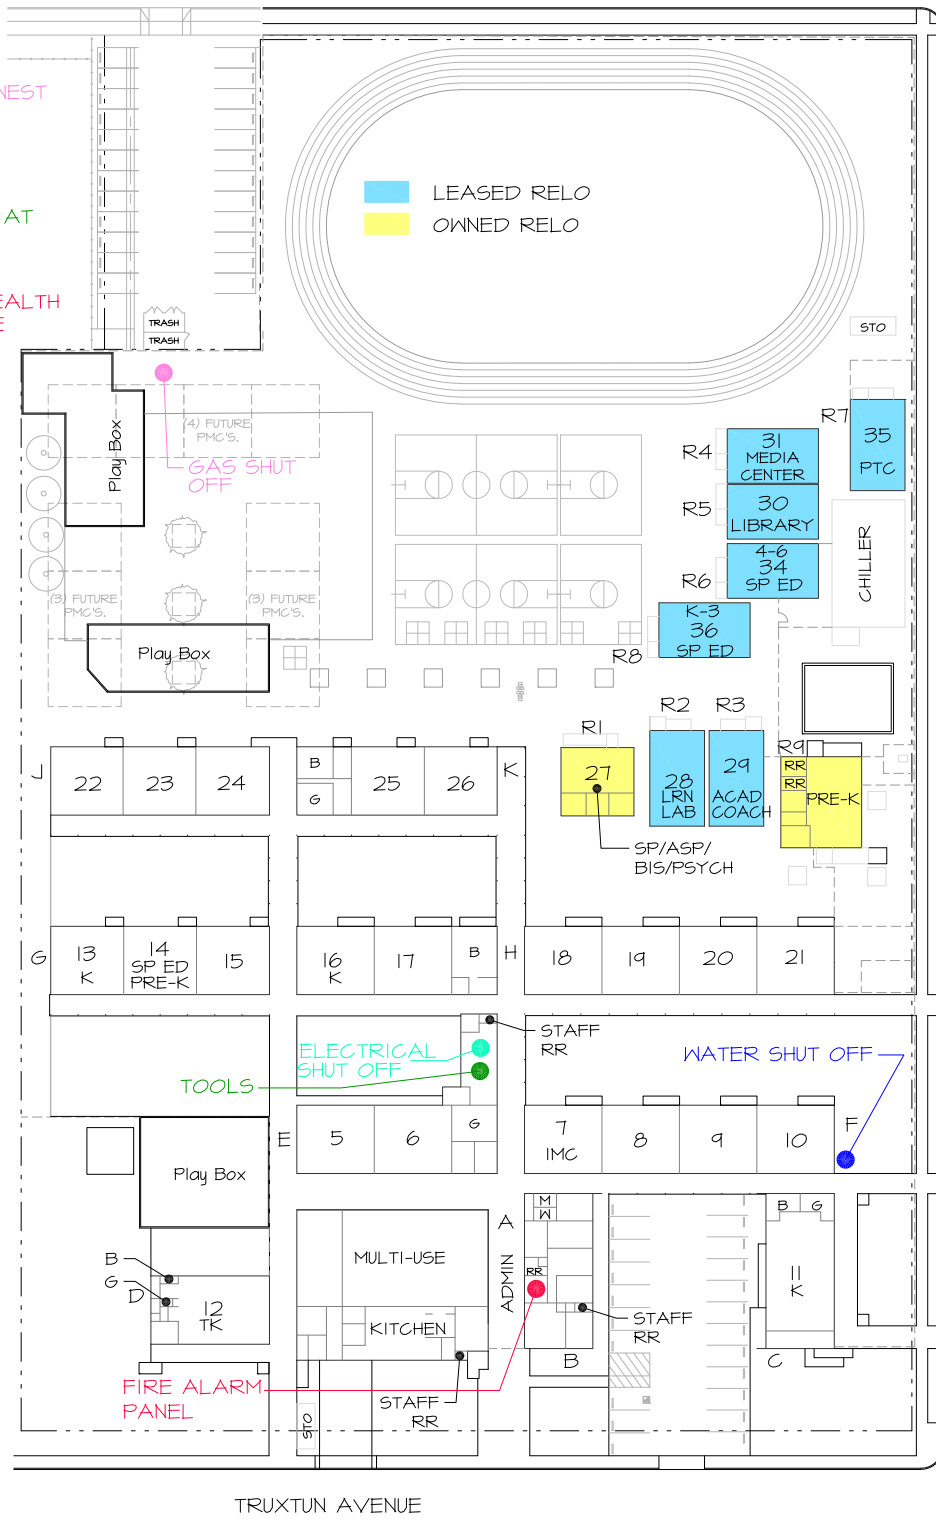

"A" STREET

TRUXTUN AVENUE

FRANKLIN ELEMENTARY
2400 TRUXTUN AVE.
631-5270

AREA = 222,750 SQ. FT.
OR 5.1 ACRES



SITE PLAN

10-18-24

SCALE: NTS