



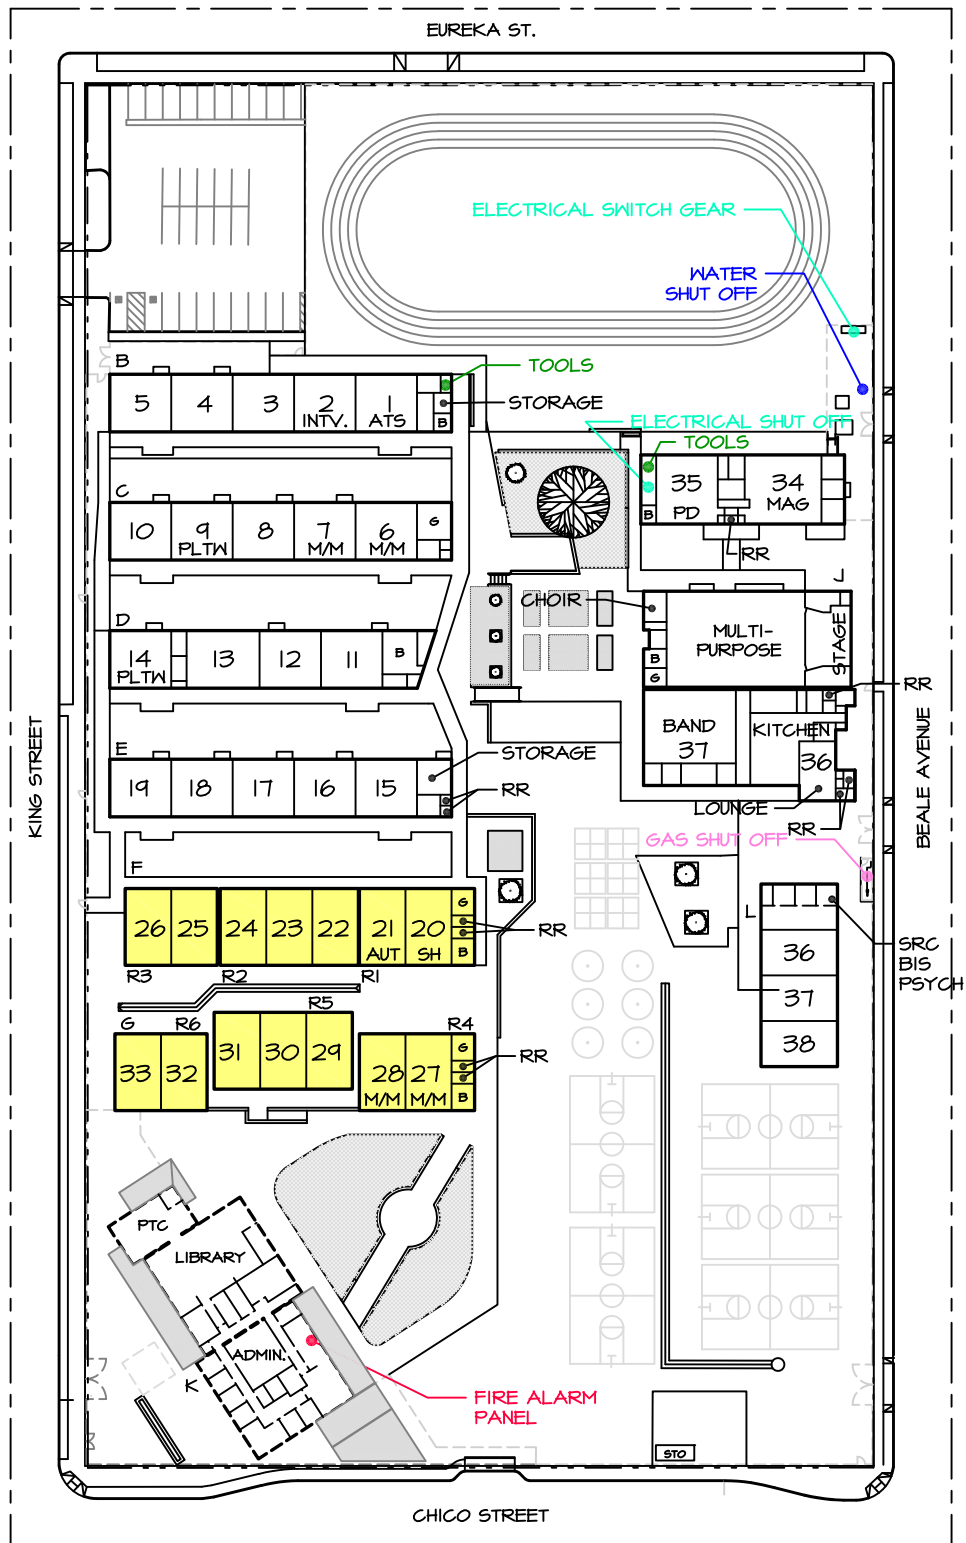

- ELECTRICAL SHUT OFF
CUSTODIAL ROOM WEST
OF ROOM 35
- GAS SHUT OFF
SOUTH OF KITCHEN
- WATER SHUT OFF
NORTHEAST OF ROOM 34
- TOOLS - GAS TOOL IN
CUSTODIAL ROOM BY 35
WATER TOOL IN CUSTODIAL
ROOM BY ROOM I
- FIRE ALARM PANEL

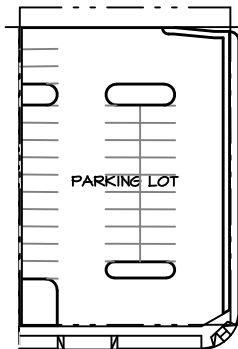

LINCOLN JUNIOR HIGH SCHOOL
815 EUREKA STREET
631-5950

AREA = 304,632 SQ. FT.
OR 7.0 ACRES

LEASED RELO
OWNED RELO



SITE PLAN

7-24-24

SCALE: 1"=100'