



**MECHANICAL PLAN - BUILDING J**  
SCALE: 3/16"=1'-0"

**MDC**  
MECHANICAL DESIGN CONCEPTS, INC.  
5500 Ming Ave, Suite 251 Bakersfield, CA 93309  
Tel #: (661) 397-2114 Fax #: (661) 397-2116  
Job: 09091

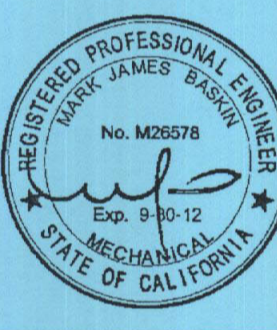


**MECHANICAL PLAN - BUILDING J**  
NEW MIDDLE / ELEMENTARY SCHOOL  
BAKERSFIELD CITY SCHOOL DISTRICT  
1300 BAKER STREET  
BAKERSFIELD CALIFORNIA 93305

APPENDIX I	ADD #1	DATE
M-11/J10R3	2010-12-14	2/14/2012
JOB NUMBER	2010-12-14	
APL # 8-01-1987	2010-12-14	
FILE # 15-15-03		

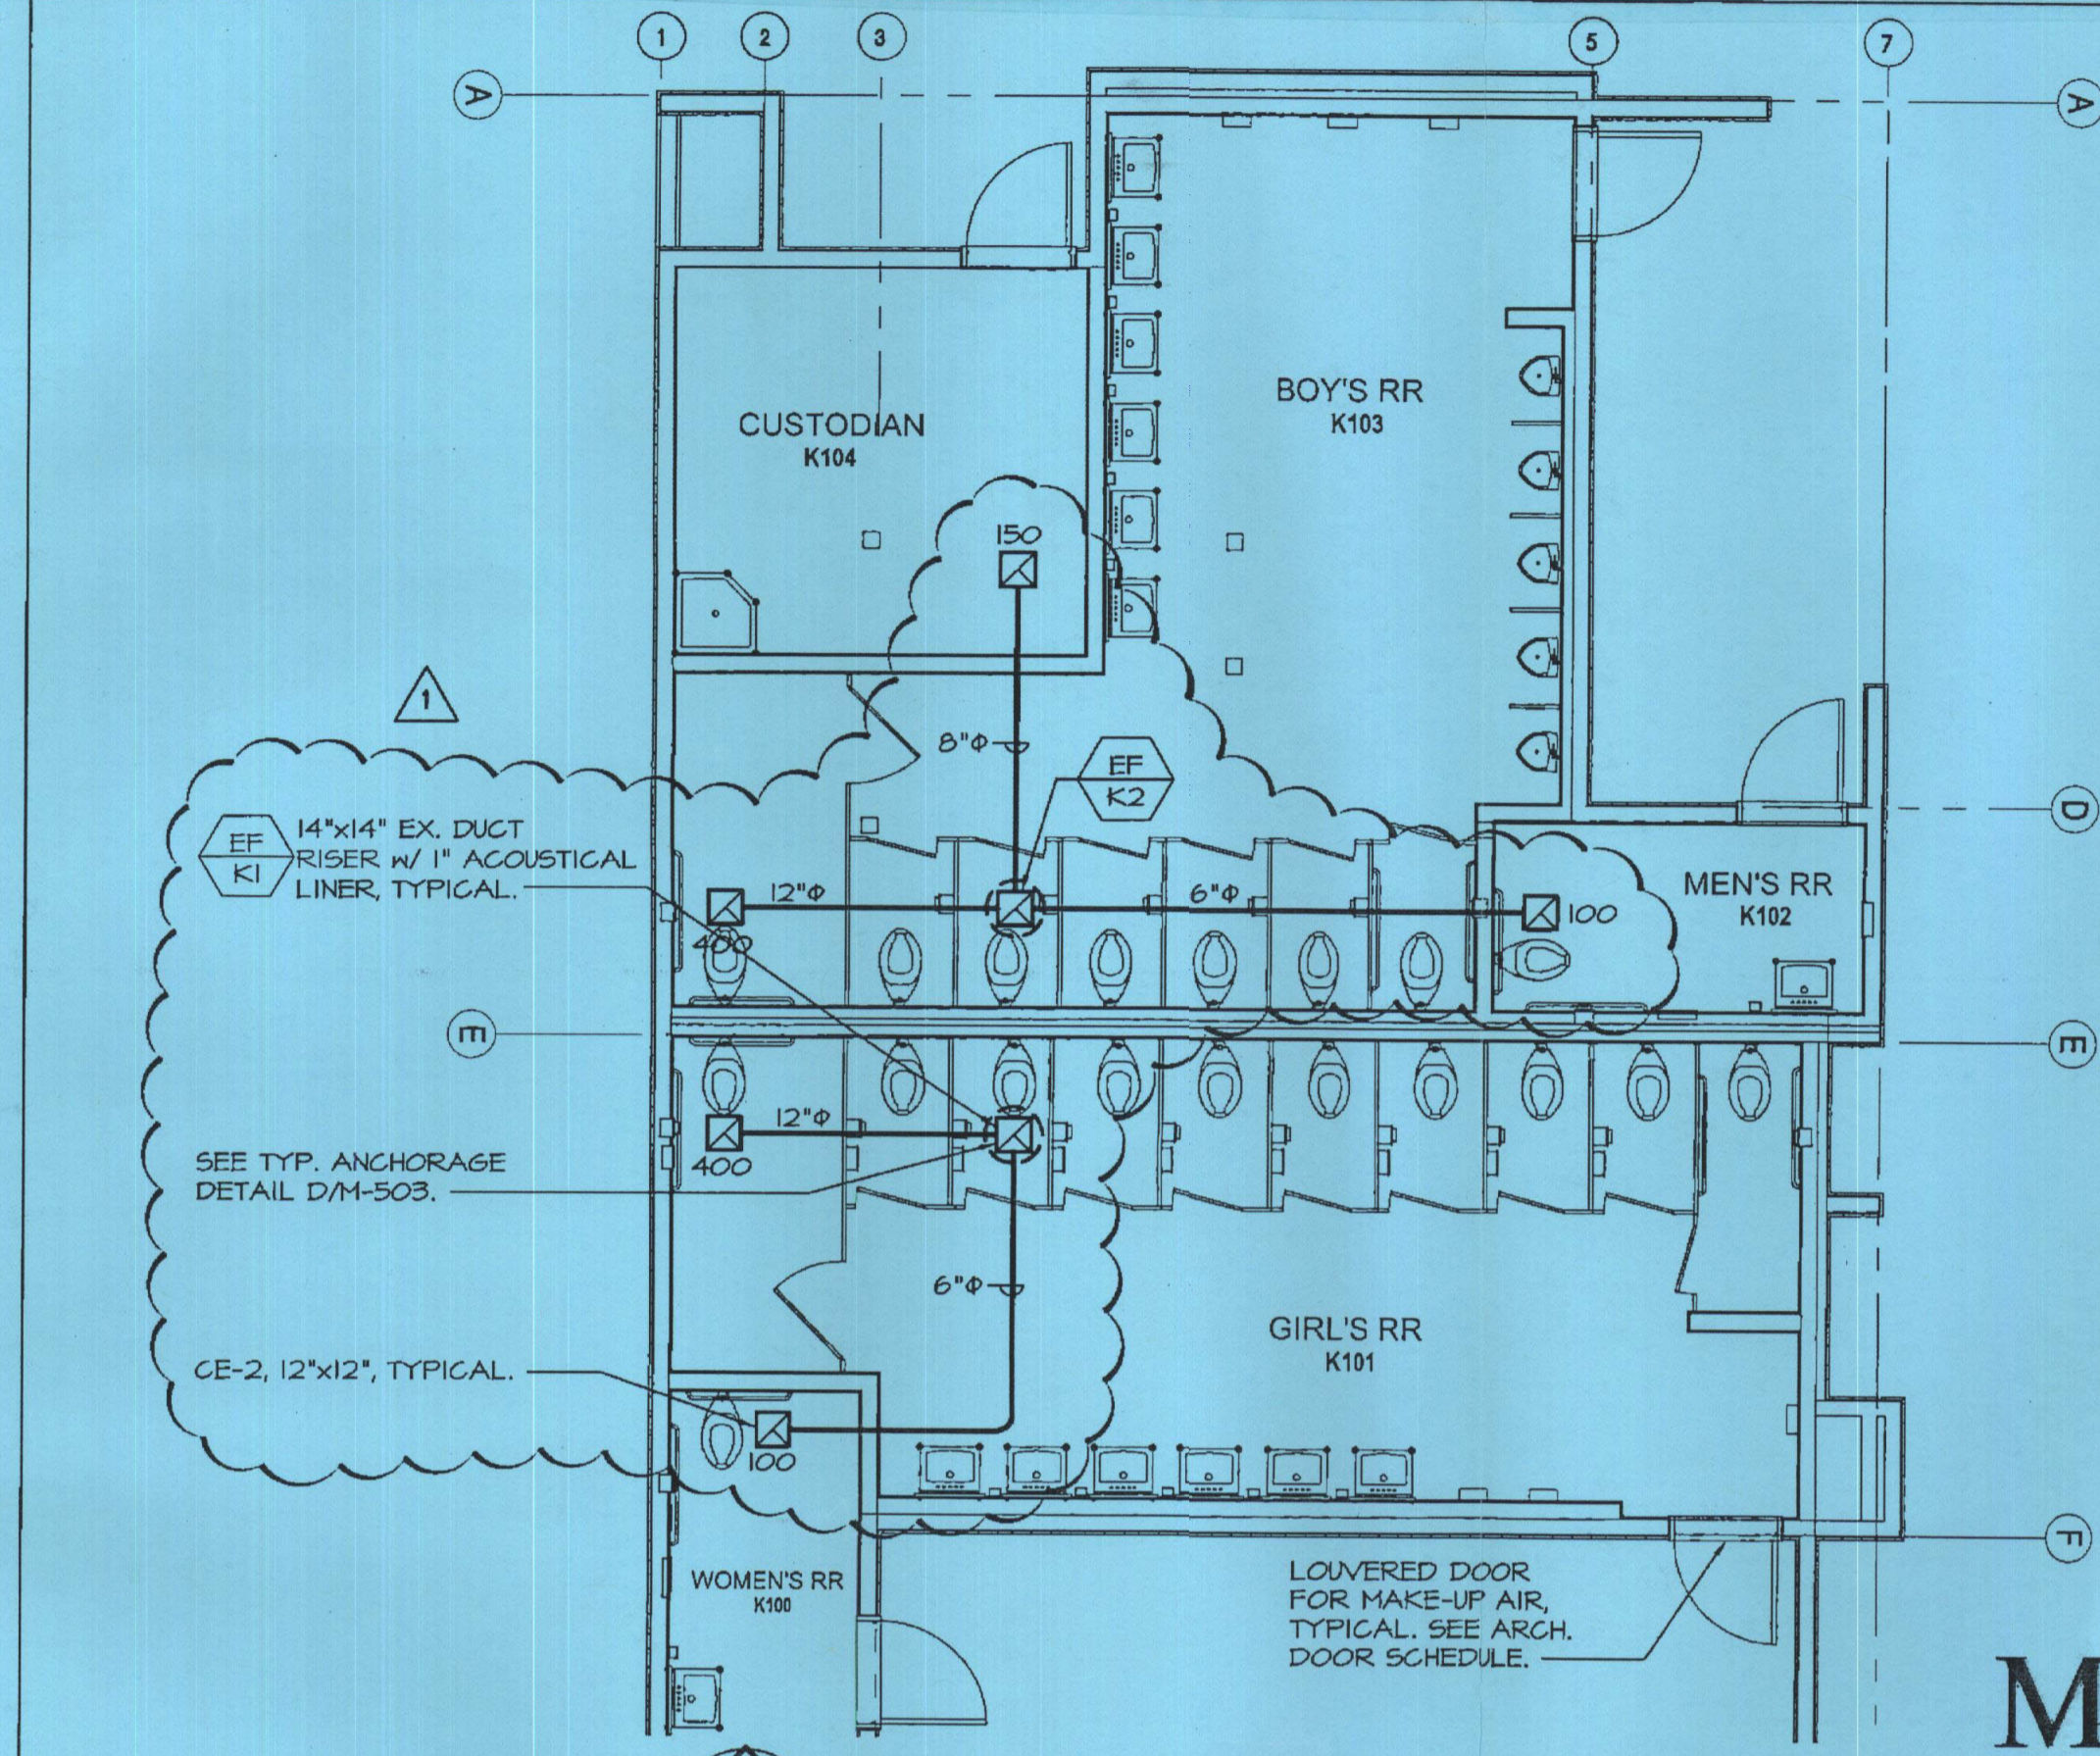


**MECHANICAL PLAN - BUILDING K**  
SCALE: 3/16"=1'-0"

**MDC**  
MECHANICAL DESIGN CONCEPTS, INC.  
5500 Ming Ave, Suite 251 Bakersfield, CA 93309  
Tel #: (661) 397-2114 Fax #: (661) 397-2116  
Job: 09091

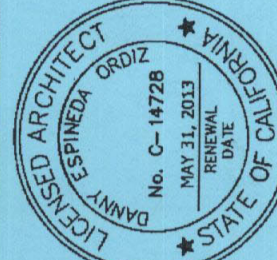


**MECHANICAL PLAN - BUILDING K**  
NEW MIDDLE / ELEMENTARY SCHOOL  
BAKERSFIELD CITY SCHOOL DISTRICT  
1300 BAKER STREET  
BAKERSFIELD CALIFORNIA 93305

APPENDIX I	ADD #1	DATE
M-11/J10R3	2010-12-14	2/14/2012
JOB NUMBER	2010-12-14	
APL # 8-01-1987	2010-12-14	
FILE # 15-15-03		

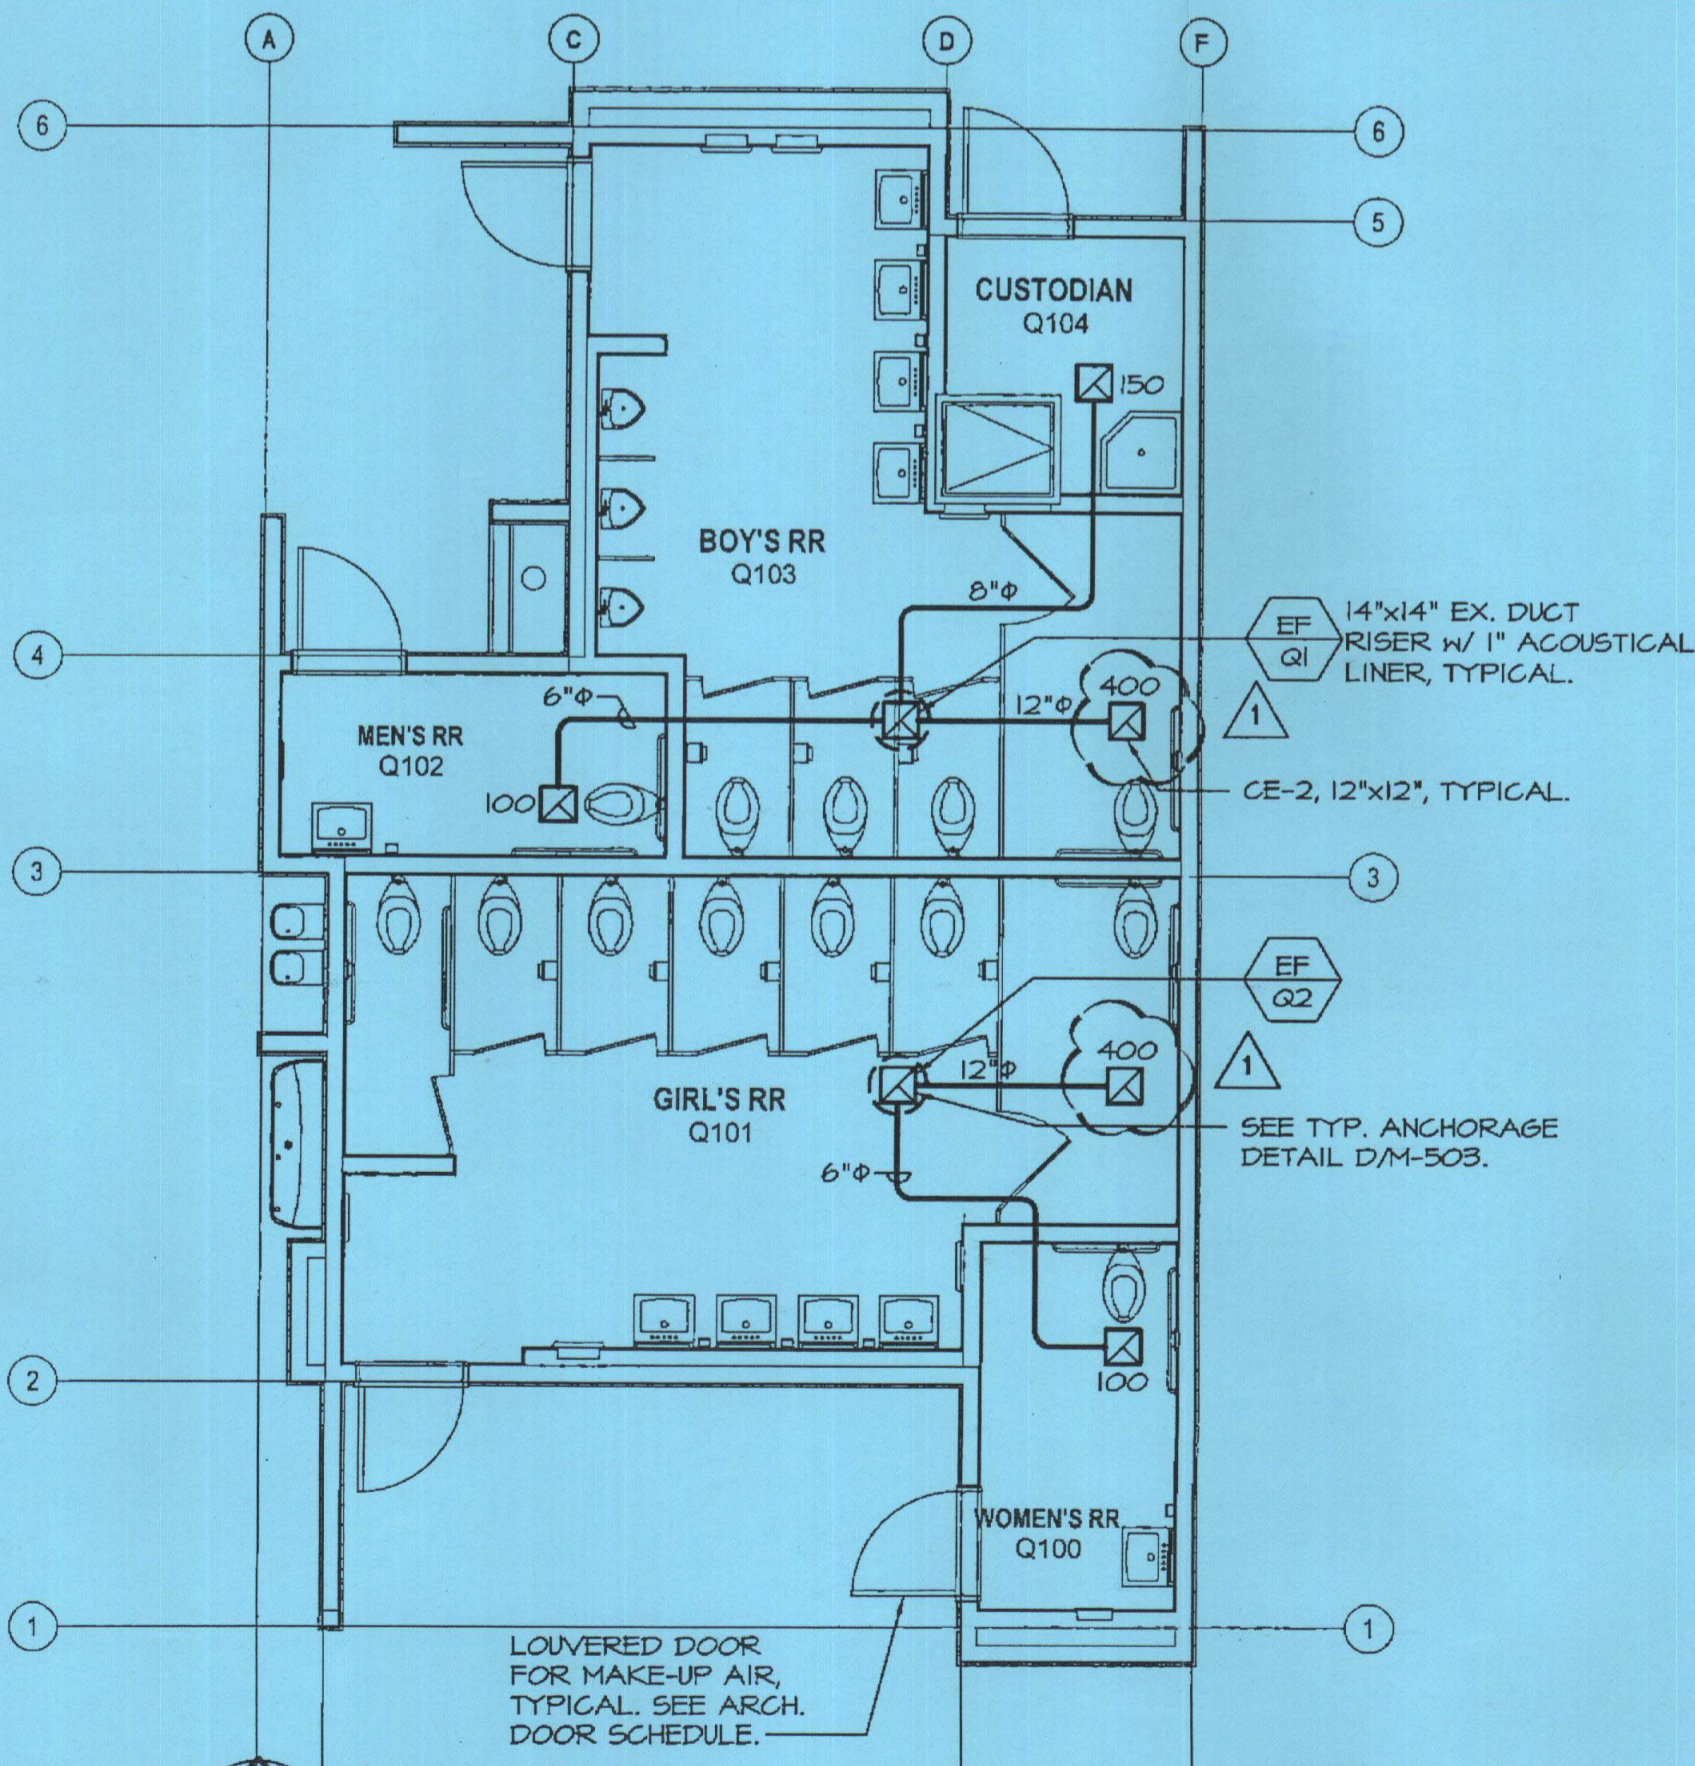


**MECHANICAL PLAN - BUILDING Q**  
SCALE: 3/16"=1'-0"

**MDC**  
MECHANICAL DESIGN CONCEPTS, INC.  
5500 Ming Ave, Suite 251 Bakersfield, CA 93309  
Tel #: (661) 397-2114 Fax #: (661) 397-2116  
Job: 09091

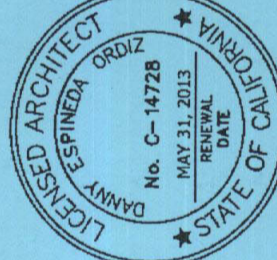



**BUILDING Q - EXHAUST FANS**  
NEW MIDDLE / ELEMENTARY SCHOOL  
BAKERSFIELD CITY SCHOOL DISTRICT  
1300 BAKER STREET  
BAKERSFIELD CALIFORNIA 93305

APPENDIX I	ADD #1	DATE
M-11/J10R2	2010-12-14	2/14/2012
JOB NUMBER	2010-12-14	
APL # 8-01-1987	2010-12-14	
FILE # 15-15-03		

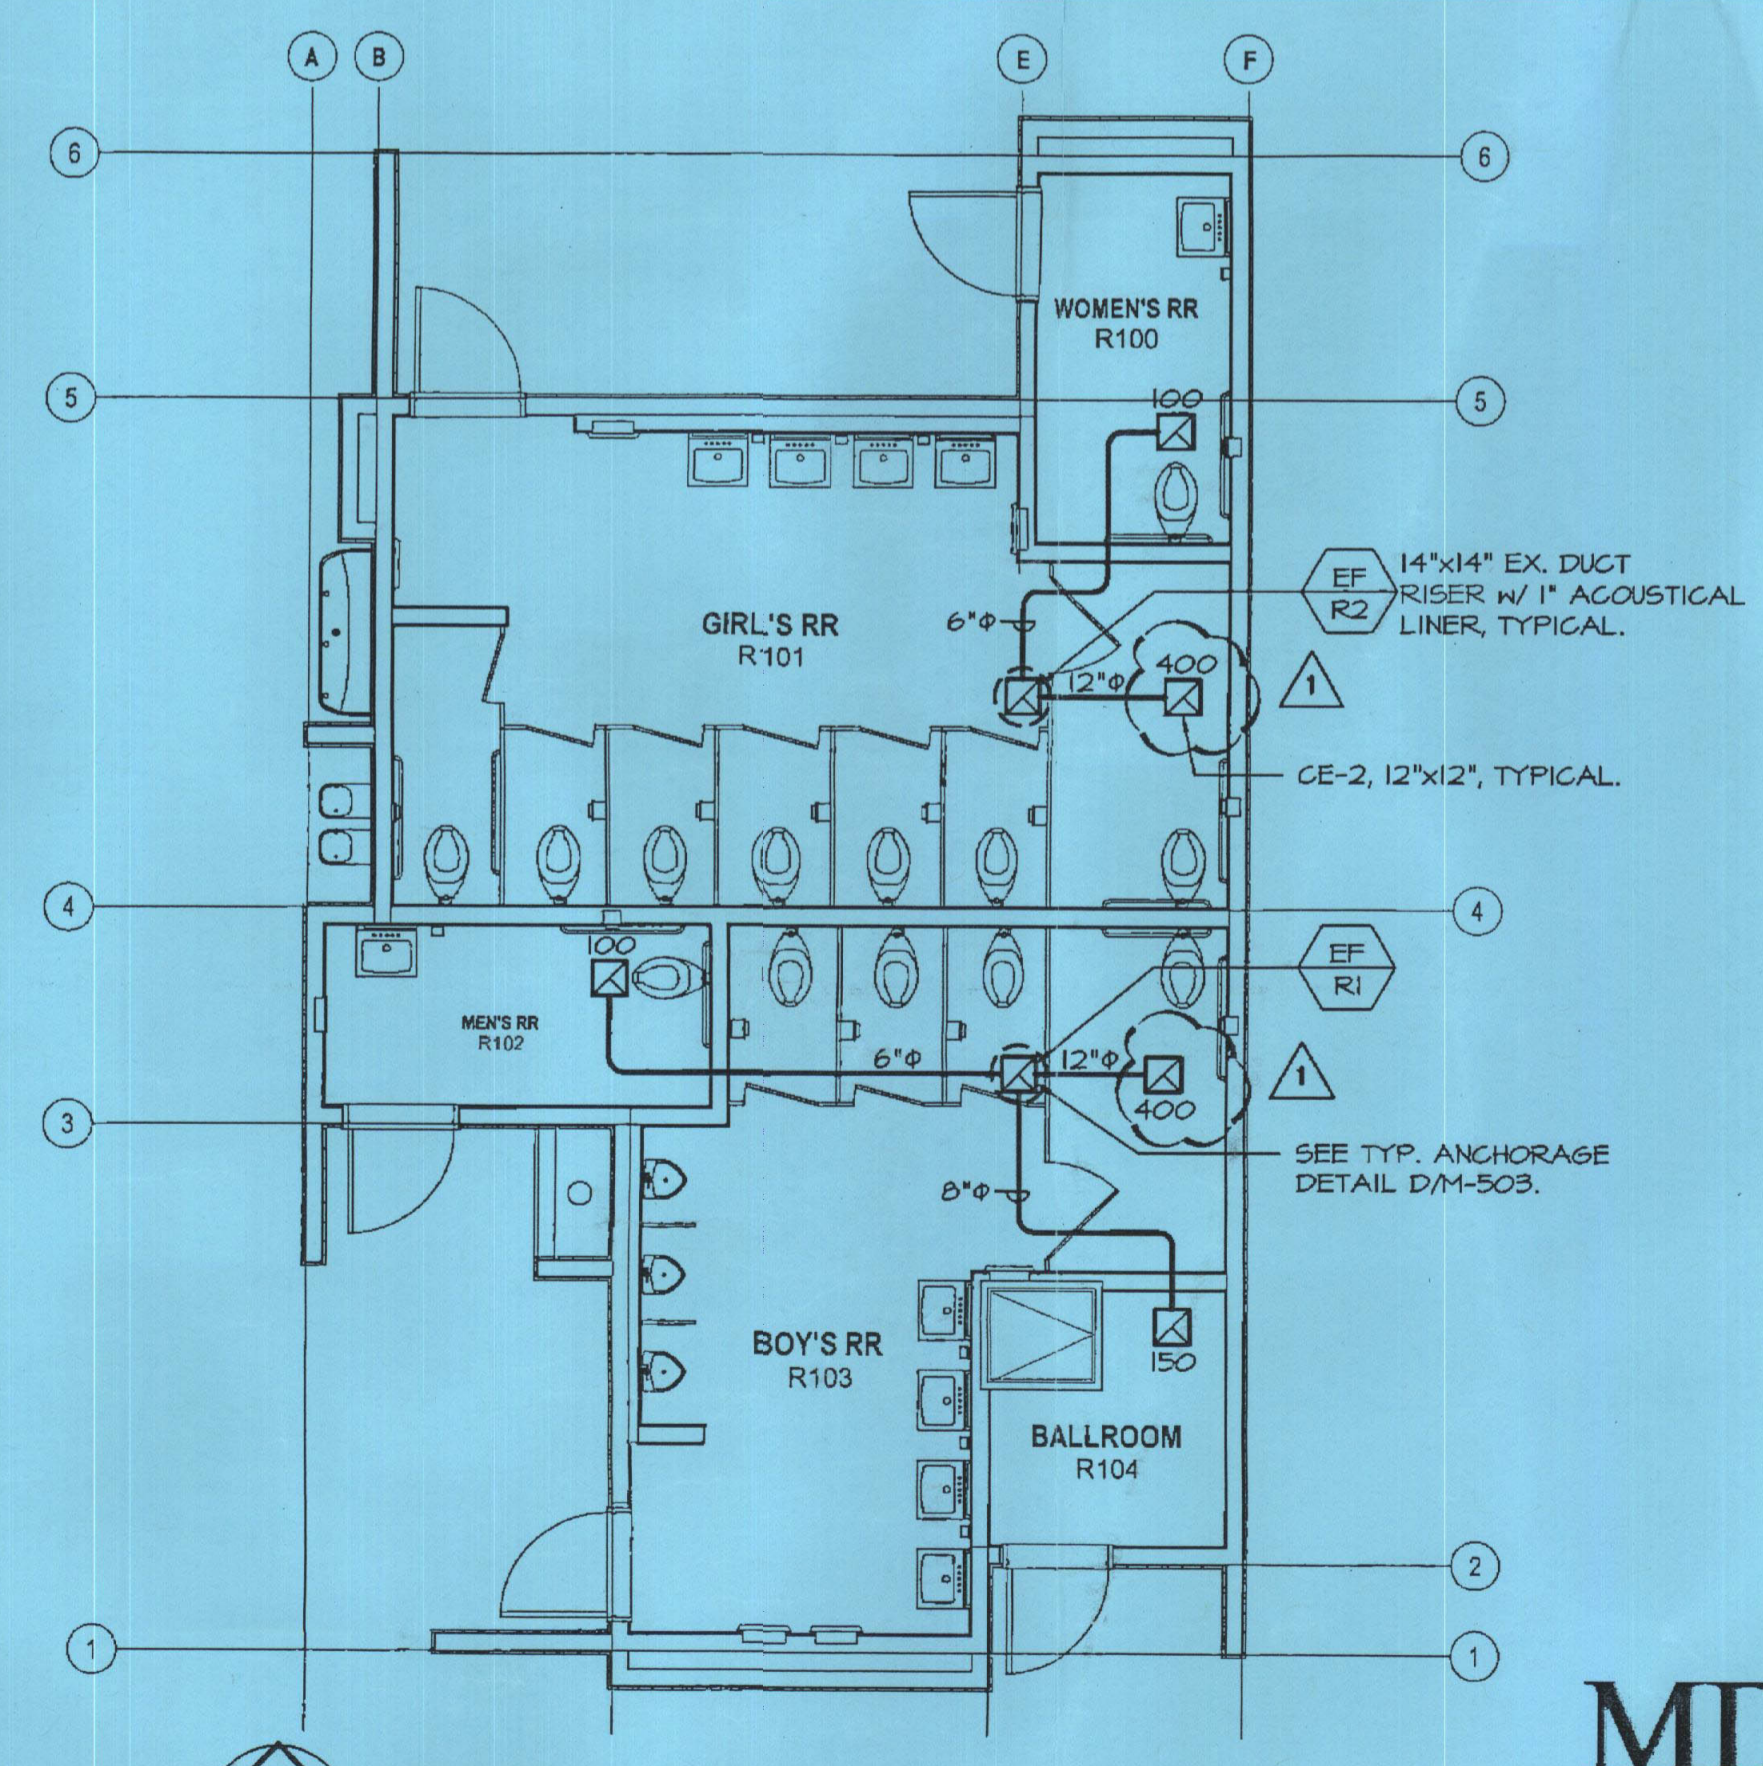

**MECHANICAL PLAN - BUILDING R**  
SCALE: 3/16"=1'-0"

**MDC**  
MECHANICAL DESIGN CONCEPTS, INC.  
5500 Ming Ave, Suite 251 Bakersfield, CA 93309  
Tel #: (661) 397-2114 Fax #: (661) 397-2116  
Job: 09091

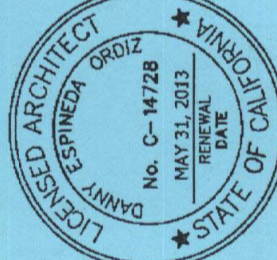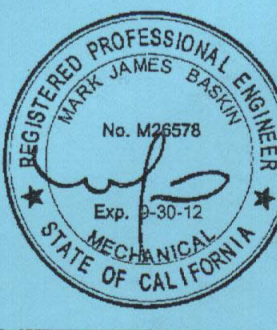

**BUILDING R - EXHAUST FANS**  
NEW MIDDLE / ELEMENTARY SCHOOL  
BAKERSFIELD CITY SCHOOL DISTRICT  
1300 BAKER STREET  
BAKERSFIELD CALIFORNIA 93305

APPENDIX I	ADD #1	DATE
M-11/J10R1	2010-12-14	2/14/2012
JOB NUMBER	2010-12-14	
APL # 8-01-1987	2010-12-14	
FILE # 15-15-03		