



PLUMBING FLOOR PLAN - BUILDING M
 SCALE: 1/8"=1'-0"
 • SEE "A" SHEETS FOR PIPE ROUTING.


REQUEST:
 Plumbing 4-8-12
 Sheet A121M and Sheet P121M, Rooms M106 and M110 show no floor drains.
 Sheet A122M show floor drains at these locations. Will floor drains be required at these locations?
ANSWER:
 Yes, floor drains are required.

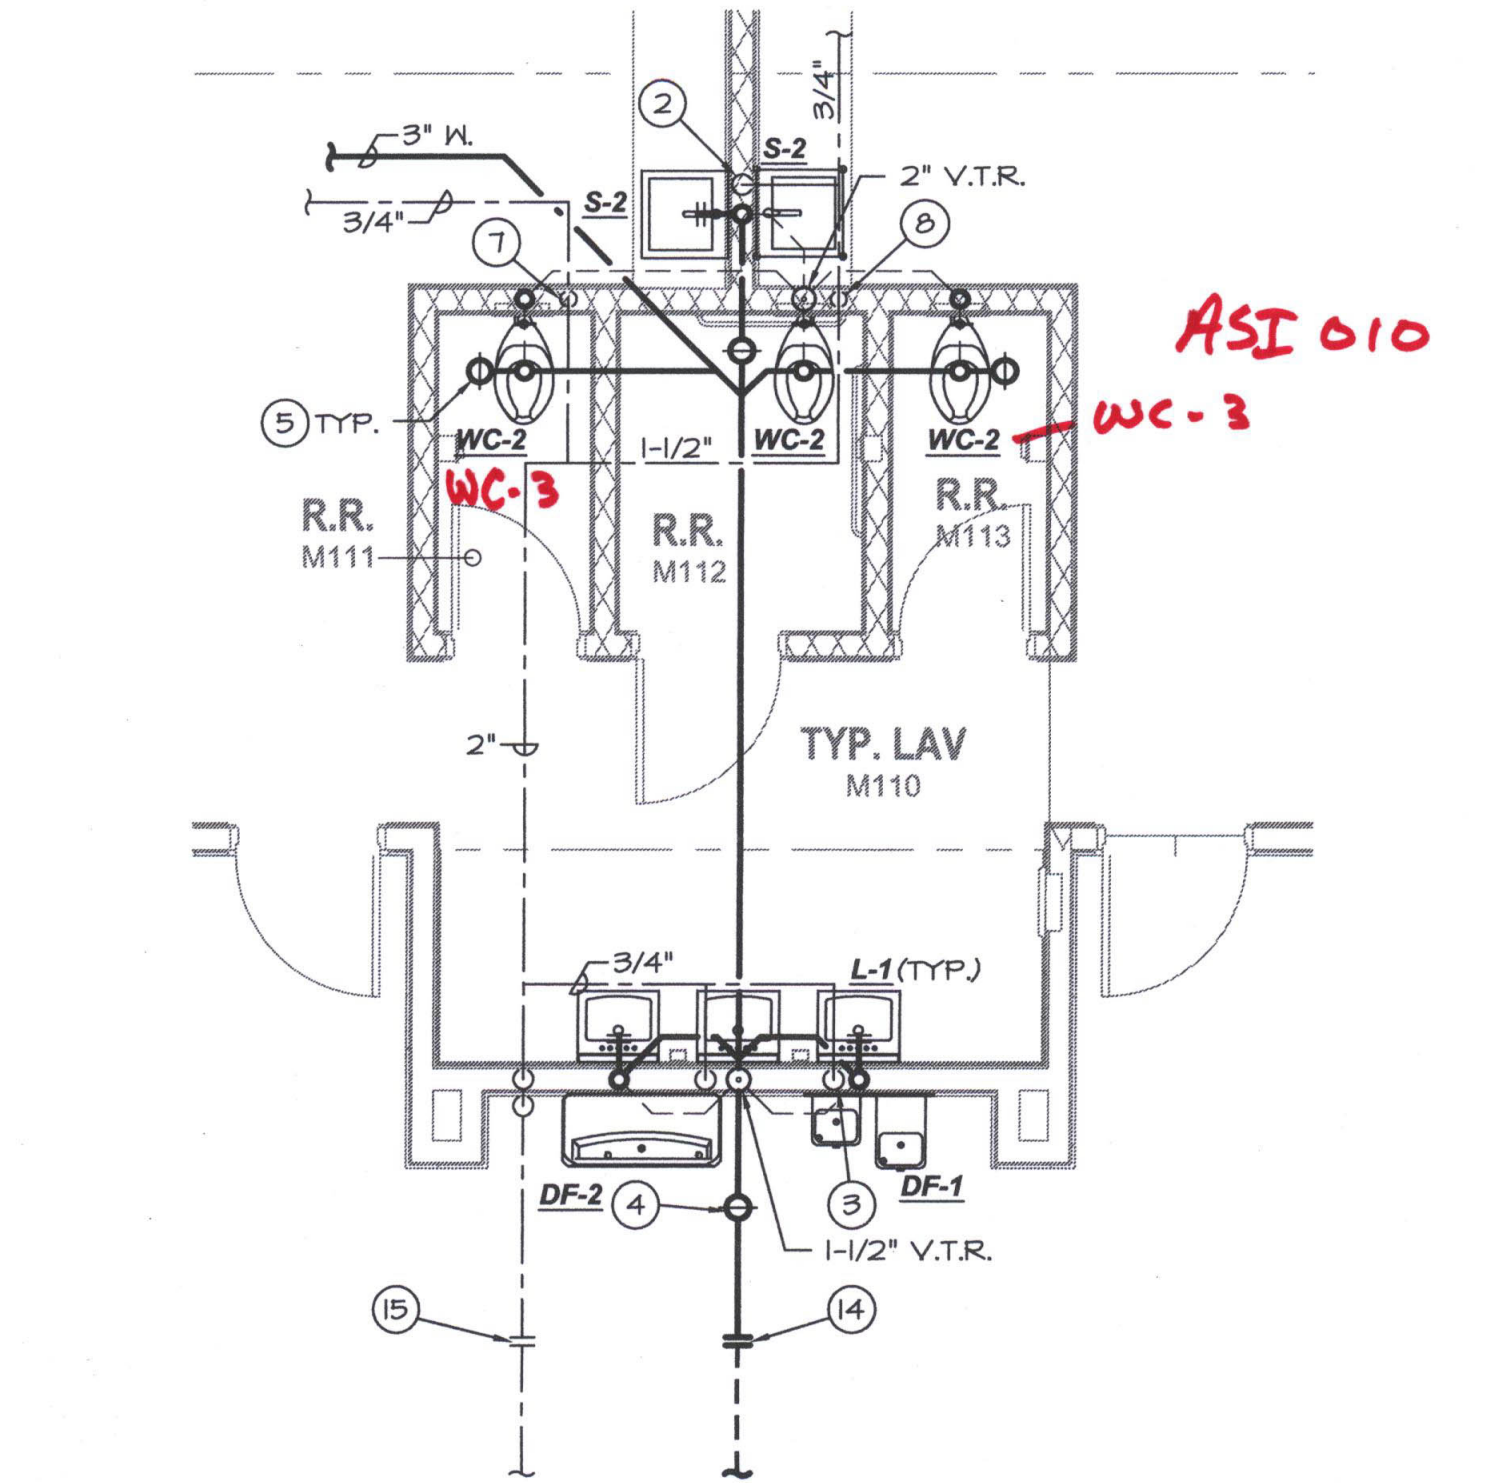

PARTIAL PLUMBING FLOOR PLAN (A)
 SCALE: 1/4"=1'-0"

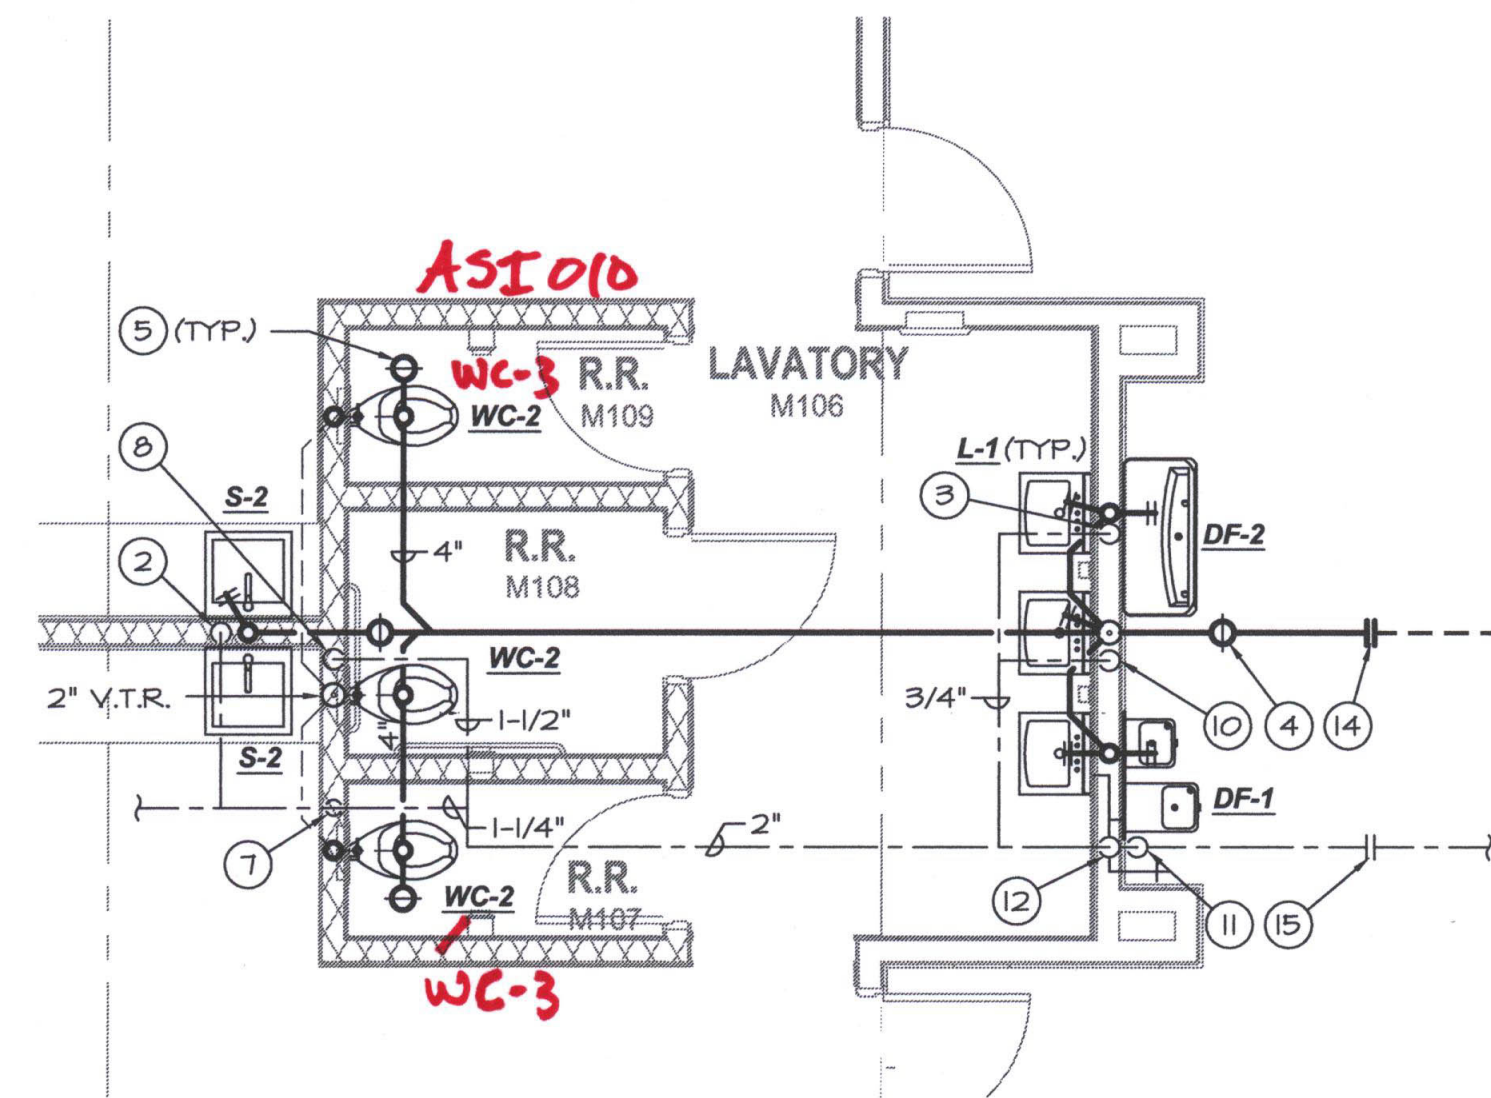

PARTIAL PLUMBING FLOOR PLAN (B)
 SCALE: 1/4"=1'-0"

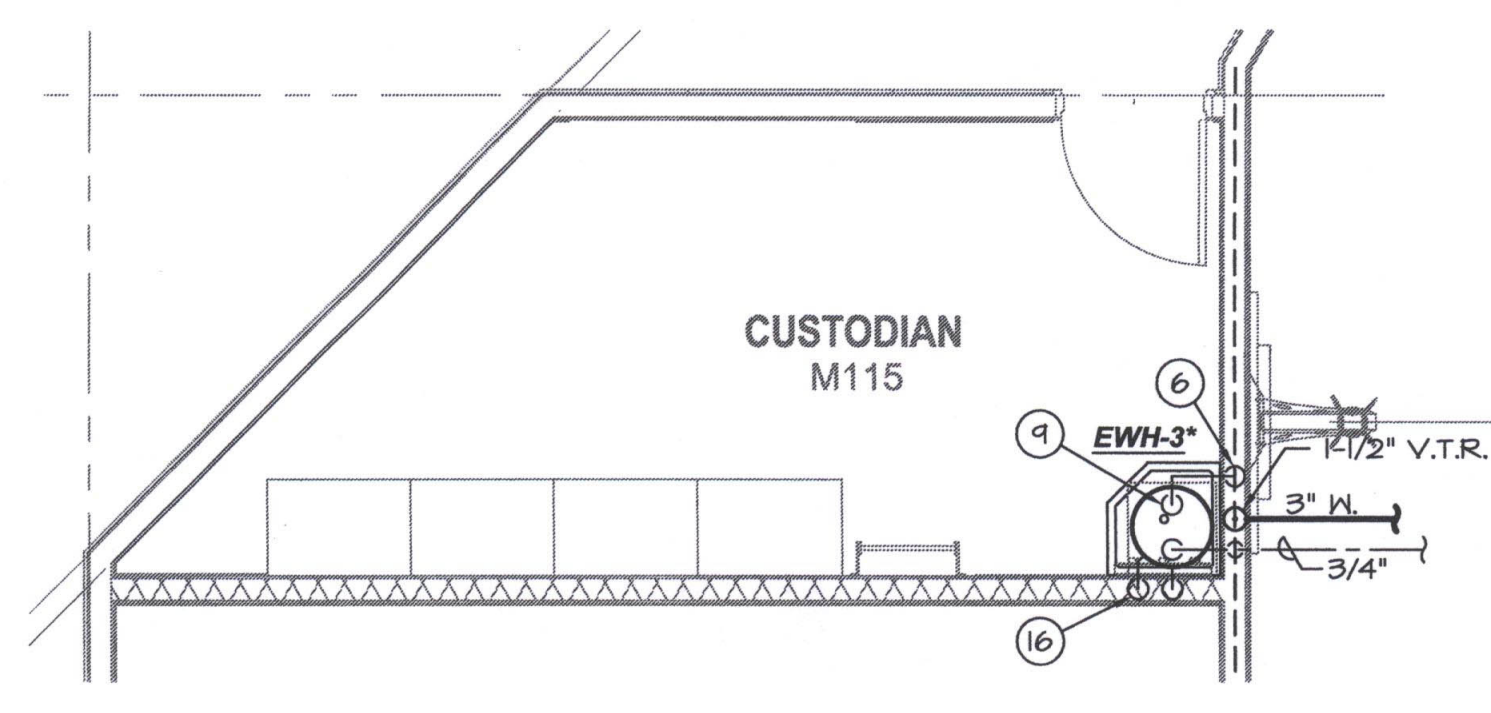


PARTIAL PLUMBING FLOOR PLAN (CUSTODIAN ROOM)
 SCALE: 1/4"=1'-0"
 • MOUNT PER DETAIL -P-121-


- PLUMBING KEYNOTES:**
- 3/4" C.W. down to H.B.
 - 3/4" C.W. down w/ 1/2" to each sink, 2" W., 2" W.C.O., 1 1/2" V.O.
 - 3/4" C.W. down w/ 1/2" to lav. and D.F., 2" W., 2" W.C.O., 1 1/2" V.O.
 - 4" 2-way C.O.T.G.
 - 4" F.C.O.
 - 3/4" C.W./H.W. down, 3" W., 3" W.C.O., 1 1/2" V.T.R.
 - 1 1/2" C.W. down w/ "Shokrolf", reduce to 1" @ flush valve.
 - 1 1/2" C.W. down to header w/ 1 1/2" to each W.C., "Shokrolf", reduce to 1" @ flush valve.
 - 3/4" C.W. to H.W. from E.W.H.
 - 1/2" C.W. down, 2" W., 2" W.C.O., 1 1/2" V.O. or V.T.R. (see plan).
 - 2" C.W. up to 12" above grade with gate valve, enter wall and rise.
 - 2" C.W. up to attic w/ 3/4" taps @ fixture height for H.B., lav. and D.F. not used.
 - P.O.C. 4" S.&W. to 5' out, see Civil plans for continuation.
 - P.O.C. 2" C.W. to 5' out, see Civil plans for continuation.
 - 1" secondary pan drain and 3/4" T.&P. relief down to spill @ M.S.
 - 3/4" trapped condensate drain down to pump.
 - 3/4" condensate drain down to sink tailpiece fitting.

Item #: Refer to Plumbing Drawings Sheet No. P-121M Partial Plumbing Floor Plans
 A & B:
 A: REVISE Plumbing in Rooms M106 and M110 to provide connections for Floor Drain per Drawing APR 07.1.

MDC
 MECHANICAL DESIGN CONCEPTS, INC.
 5500 Ming Ave, Suite 251 Bakersfield, CA 93309
 Tel #: (661) 397-2114 FAX #: (661) 397-2116
 Job: 09091

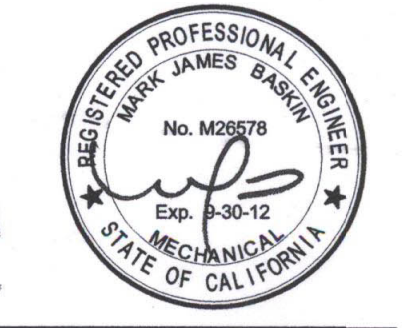

ORDIZ MELBY
 ARCHITECTS, INC.
 5500 MING AVENUE SUITE 280
 BAKERSFIELD, CALIFORNIA 93309
 TELEPHONE (661) 832-6256
 FACSIMILE (661) 832-4291

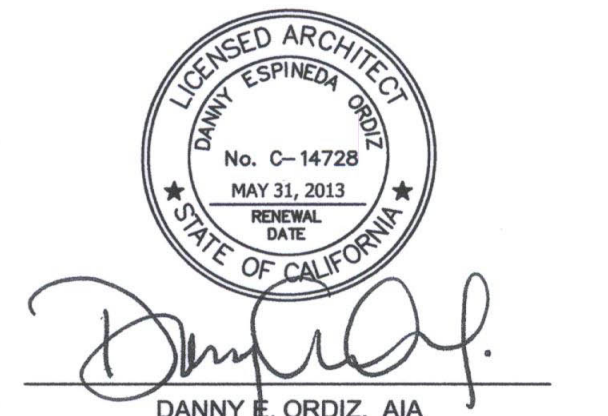

IDENTIFICATION STAMP
 DIVISION OF STATE ARCHITECT
 OFFICE OF REGULATION SERVICES
 APPL. #: 02-112027
 FILE #: 15-6
 AC. FILED BY SS
 DATE JAN 20 2012
 PTN # 63321-112

NEW ELEMENTARY SCHOOL
 9801 HIGHLAND KNOLLS DR
 BAKERSFIELD CALIFORNIA 93306

NEW MIDDLE SCHOOL
 4115 VINELAND ROAD
 BAKERSFIELD CALIFORNIA 93306

FOR:
BAKERSFIELD CITY SCHOOL DISTRICT
 1300 BAKER STREET
 BAKERSFIELD CALIFORNIA 93305

MARK	DATE	DESCRIPTION
△		
△		
△		
△		

JOB NUMBER: 200101244
 CAD DRAWING FILE:
 DRAWN BY: KW
 CHECKED BY: MB
 CHECK AND VERIFY ALL DIMENSIONS BEFORE PROCEEDING WITH THE WORK.
 REPORT DISCREPANCIES TO THE ARCHITECT.
 THE DRAWINGS, IDEAS, AND DESIGNS REPRESENTED ON THIS SHEET ARE THE PROPERTY OF THE ARCHITECT.
 COPYRIGHT © 2010
 ORDIZ-MELBY ARCHITECTS, INC. 2010

SHEET TITLE
PLUMBING FLOOR PLAN BUILDING M

SHEET IDENTIFICATION NUMBER
P-121M