

**ORDIZ MELBY**  
ARCHITECTS, INC.

5500 MING AVENUE SUITE 280  
BAKERSFIELD, CALIFORNIA 93309  
TELEPHONE (861) 832-5258  
FACSIMILE (861) 832-4291



*William J. Melby*  
DANNY E. ORDIZ, AIA  
ARCHITECT C-14,728

WILLIAM J. MELBY, AIA  
ARCHITECT C-16,835  
CONSULTANT


IDENTIFICATION STAMP  
DIVISION OF STATE ARCHITECT  
OFFICE OF REGULATION SERVICES  
APPL # - 02-112027  
FILE # - 15-6  
AC: *[Signature]* SS: *[Signature]*  
DATE: 1/16/12

NEW ELEMENTARY SCHOOL  
9801 HIGHLAND KNOLLS DR  
BAKERSFIELD  
CALIFORNIA  
93306

NEW MIDDLE SCHOOL  
4115 VINELAND ROAD  
BAKERSFIELD  
CALIFORNIA  
93306

FOR:

BAKERSFIELD CITY SCHOOL  
DISTRICT  
1300 BAKER STREET  
BAKERSFIELD  
CALIFORNIA  
93305

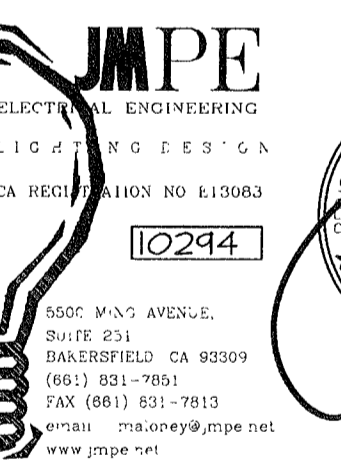

9801 HIGHLAND KNOLLS DR  
BAKERSFIELD, CA 93306  
9300 8th St  
BAKERSFIELD, CA 93305  
FAX (861) 832-7913  
www.jmpe.com

MARK DATE DESCRIPTION

△		
△		
△		
△		
△		

JOB NUMBER:  
20101244  
CAD DRAWING FILE:

DRAWN BY:  
AC  
CHECKED BY:  
PH

CHECK AND VERIFY ALL DIMENSIONS BEFORE  
PROCEEDING WITH THE WORK.  
REPORT DISCREPANCIES TO THE ARCHITECT.  
THE DRAWING, IDEAS, AND DESIGN  
REPRESENTED ON THIS SHEET ARE THE  
PROPERTY OF THE ARCHITECT


COPYRIGHT:  
ORDIZ MELBY ARCHITECTS, INC 2010

SHEET TITLE  
**SITE LIGHTING  
PHOTOMETRICS PLAN**


SHEET IDENTIFICATION NUMBER

**E-115**

SHEET OF

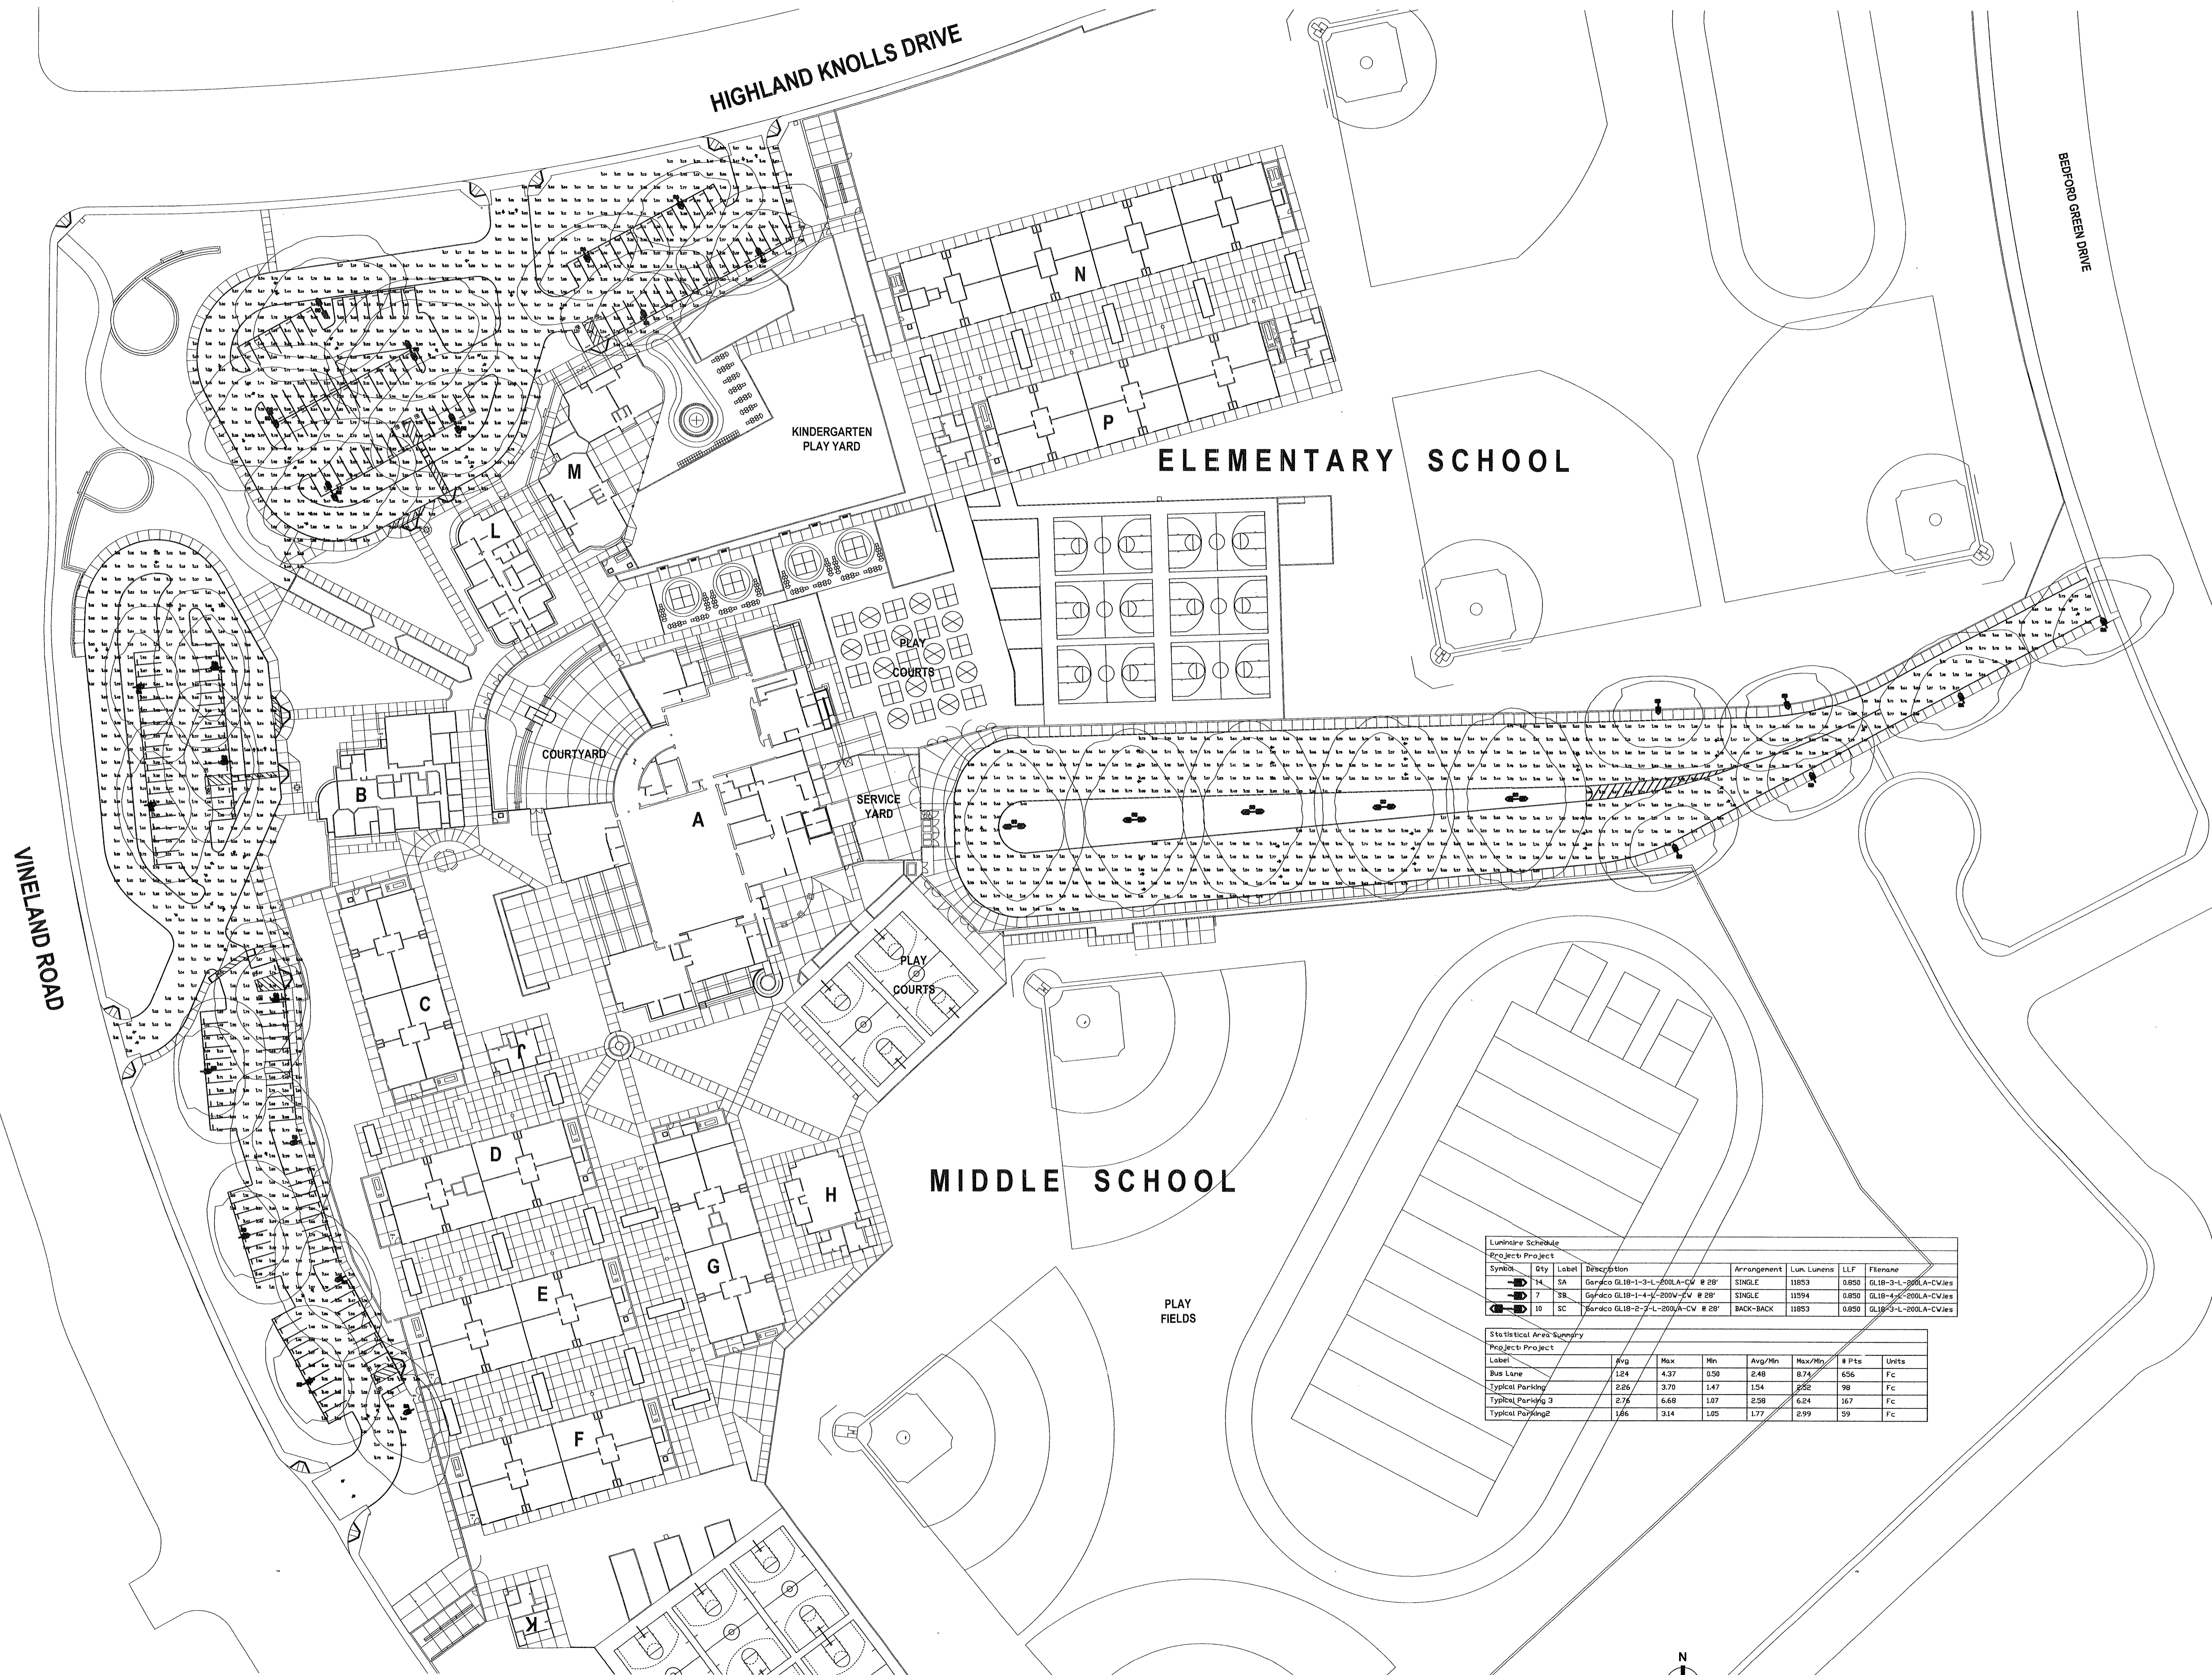

SITE LIGHTING PHOTOMETRICS PLAN

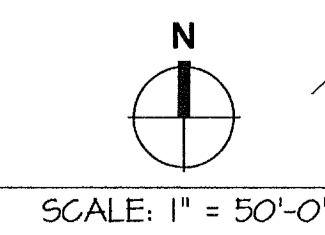

SCALE: 1" = 50'-0"

Luminaire Schedule							
Project	Project	Label	Description	Arrangement	Lum. Lumens	LLF	File name
14	SA	Garco GL18-1-3-L-200A-CW # 28"		SINGLE	11853	0.850	GL18-3-L-200A-CW.via
7	SB	Garco GL18-1-4-L-200A-CW # 28"		SINGLE	11594	0.850	GL18-4-L-200A-CW.via
10	SC	Garco GL18-2-3-L-200A-CW # 28"		BACK-BACK	11853	0.850	GL18-3-L-200A-CW.via

Statistical Area Summary									
Project	Project	Label	Avg	Max	Min	Avg/Ftn	Max/Ftn	# Pts	Units
Bus Lane			1.24	4.37	0.50	2.48	8.74	656	Fc
Typical Parking 1			2.26	3.70	1.47	1.54	2.52	98	Fc
Typical Parking 3			2.75	6.68	1.07	2.08	6.24	167	Fc
Typical Parking 2			1.65	3.14	1.05	1.77	2.99	39	Fc

JMPE\JOB\10244\DATE\12-28-11.AC