


MECHANICAL KEYNOTES:

1. VRF heat pump on level platform. See detail G/M-503.
2. Extend pipes thru platform to below roof. See detail H/M-503.
3. Cooling only condensing unit on level platform. See detail E/M-503.
4. Energy recovery ventilator on manufactured sloped roof curb. See detail Q/M-503.
5. Transition outside air and exhaust ducts within curb space to 14" x 14" and extend to below roof.
6. Sewer vent location. See sheet P-121L.
7. Outside air intake.

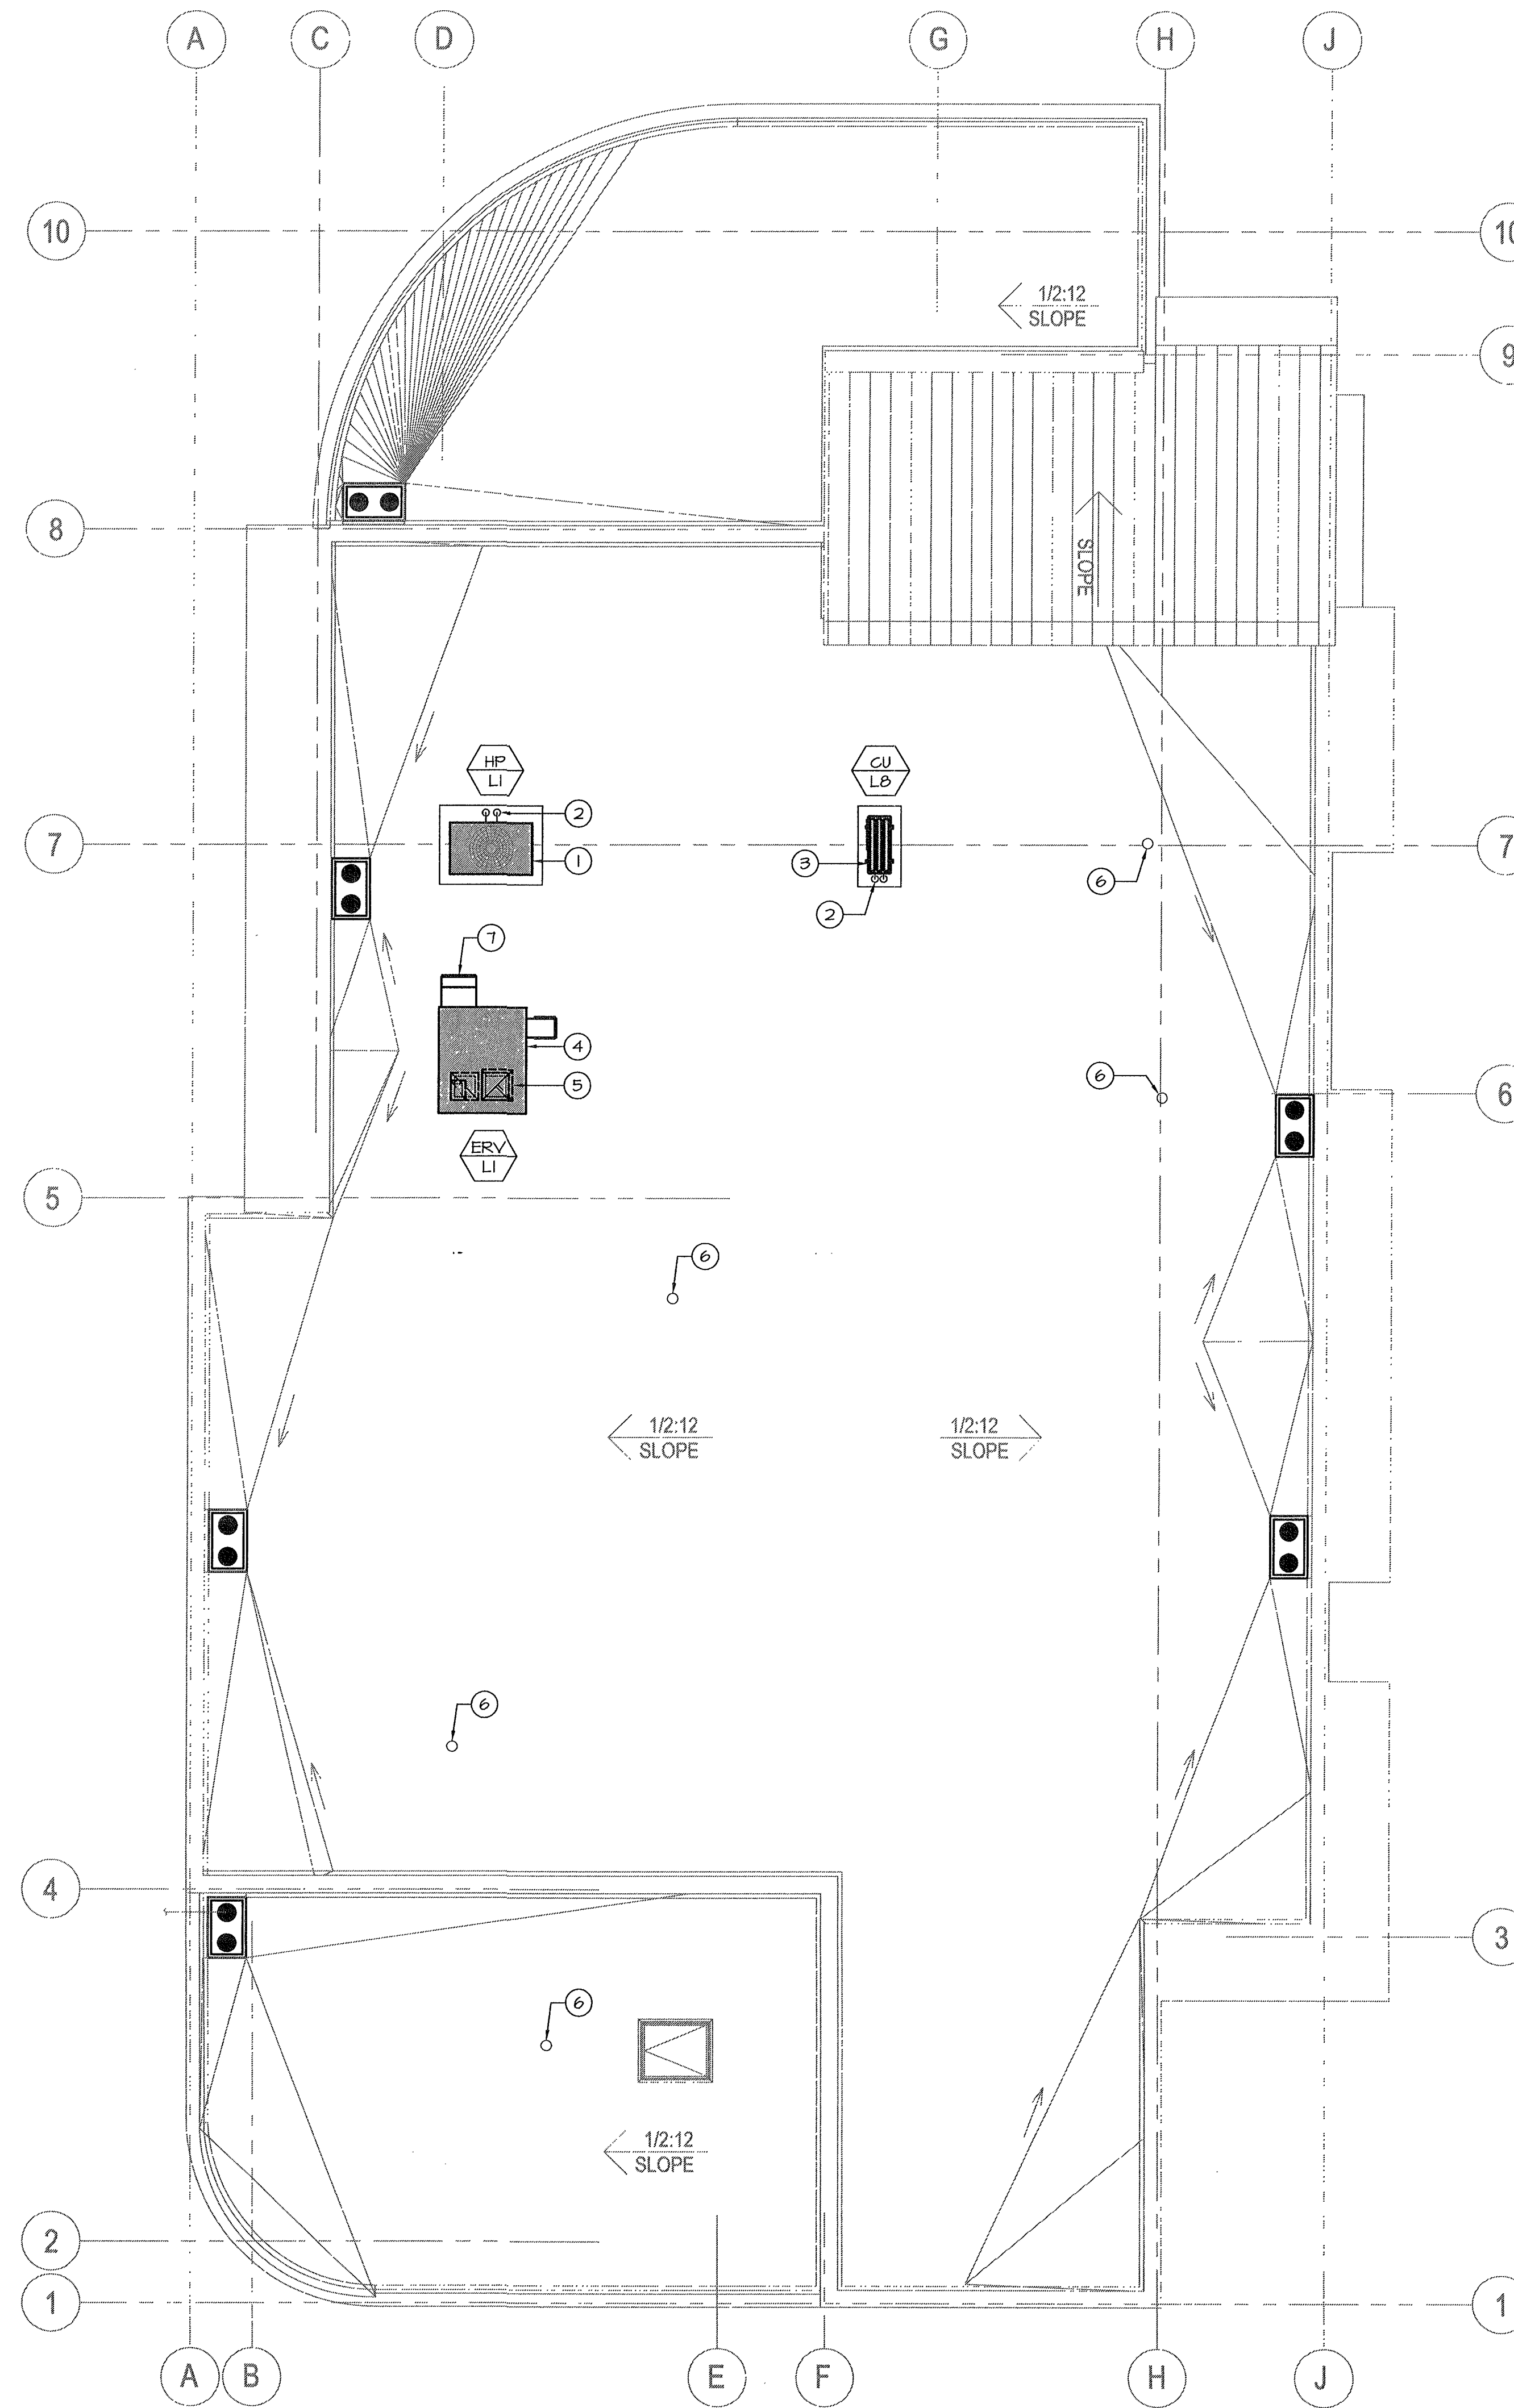

MECHANICAL ROOF PLAN
SCALE: 3/16"=1'-0"

ORDIZ MELBY
ARCHITECTS, INC.
5500 MING AVENUE SUITE 280
BAKERSFIELD, CALIFORNIA 93309
TELEPHONE (661) 832-5256
FACSIMILE (661) 832-4291

REGISTERED ARCHITECT
No. C-14728
MAY 31, 2013
RENEWAL DATE
STATE OF CALIFORNIA
Danny E. Ordiz
DANNY E. ORDIZ, AIA
ARCHITECT C-14,728
WILLIAM J. MELBY, AIA
ARCHITECT C-16,835

IDENTIFICATION STAMP
DIVISION OF STATE ARCHITECT
OFFICE OF REGULATION SERVICES
APPL. #02-112027
FILE #: 15-6
AC _____
DATE JAN 20 2012
PTN # 63321-112

NEW ELEMENTARY SCHOOL
9801 HIGHLAND KNOLLS DR
BAKERSFIELD CALIFORNIA 93306
NEW MIDDLE SCHOOL
4115 VINELAND ROAD
BAKERSFIELD CALIFORNIA 93306
FOR:
BAKERSFIELD CITY SCHOOL DISTRICT
1300 BAKER STREET
BAKERSFIELD CALIFORNIA 93305

MARK	DATE	DESCRIPTION
△		
△		
△		
△		

JOB NUMBER: 20010244
CAD DRAWING FILE:
DRAWN BY: KW
CHECKED BY: MB
CHECK AND VERIFY ALL DIMENSIONS BEFORE PROCEEDING WITH THE WORK.
REPORT DISCREPANCIES TO THE ARCHITECT.
THE DRAWINGS, IDEAS, AND DESIGN REPRESENTED ON THIS SHEET ARE THE PROPERTY OF THE ARCHITECT.
COPYRIGHT: ORDIZ-MELBY ARCHITECTS, INC. 2010
SHEET TITLE: MECHANICAL ROOF PLAN - BUILDING L
SHEET IDENTIFICATION NUMBER: M-141L

MDC
MECHANICAL DESIGN CONCEPTS, INC.
5500 Ming Ave, Suite 251 Bakersfield, CA 93309
Tel #: (661) 397-2114 FAX #: (661) 397-2116
Job: 09091 Pjt: 1-11-12

REGISTERED PROFESSIONAL ENGINEER
No. 50289
10/10/12
MECHANICAL
STATE OF CALIFORNIA