


**ORDIZ  
MELBY**  
ARCHITECTS, INC.

5500 MING AVENUE SUITE 280  
BAKERSFIELD, CALIFORNIA 93309  
TELEPHONE (661) 832-5258  
FACSIMILE (661) 832-4291





*Dannye Ordiz*  
DANNYE ORDIZ, AIA  
ARCHITECT C-14,728  
WILLIAM J MELBY, AIA  
ARCHITECT C-16,835  
CONSULTANT

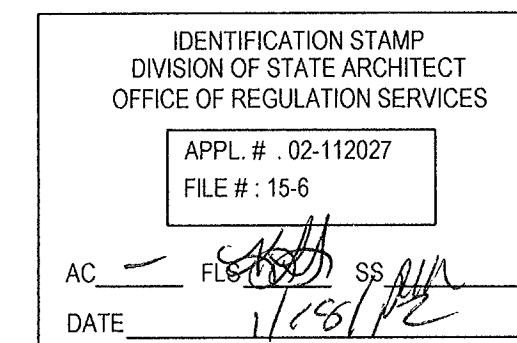

NEW ELEMENTARY SCHOOL  
9801 HIGHLAND KNOLLS DR  
BAKERSFIELD  
CALIFORNIA  
93306

NEW MIDDLE SCHOOL  
4115 VINELAND ROAD  
BAKERSFIELD  
CALIFORNIA  
93306

FOR:  
BAKERSFIELD CITY SCHOOL  
DISTRICT  
1300 BAKER STREET  
BAKERSFIELD  
CALIFORNIA  
93305

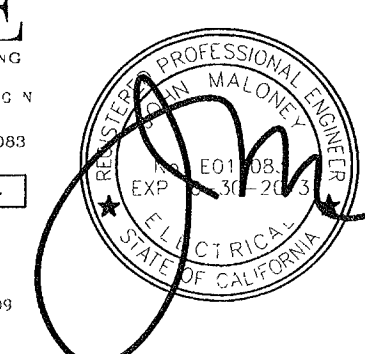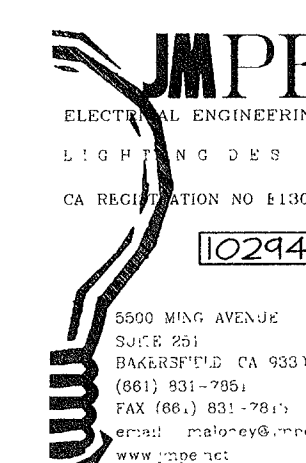

MARK	DATE	DESCRIPTION


JOB NUMBER  
20101244  
CAD DRAWING FILE

DRAWN BY  
AC  
CHECKED BY  
PH

CHECK AND VERIFY ALL DIMENSIONS BEFORE  
PROCEEDING WITH THE WORK.  
REPORT DISCREPANCIES TO THE ARCHITECT

THE DRAWINGS, IDEAS, AND DESIGNS  
REPRESENTED ON THIS SHEET ARE THE  
PROPERTY OF THE ARCHITECT

COPYRIGHT  
ORDIZ MELBY ARCHITECTS, INC. 2010

SHEET TITLE  
**ELECTRICAL PLAN  
BUILDING F**


SHEET IDENTIFICATION NUMBER

**E-121F**


SHEET OF

**ELECTRICAL PLAN NOTES**

- REFER TO ELECTRICAL SINGLE LINE DIAGRAM, SHEET E-001 AND ELECTRICAL SITE PLAN SHEET E-111 FOR FEEDER REQUIREMENTS.
- VERIFY ELEVATION OF SPLASH WITH CABINET INSTALLER. RECEPTACLES SHALL BE ABOVE SPLASH WHERE THIS SYMBOL IS SHOWN, TYPICAL.
- PROVIDE THREE 3/4" CONDUITS SPARE STUBBED INTO ACCESSIBLE ATTIC SPACE.
- PROVIDE #6 CU GROUND TO TELEPHONE BACKBOARD. CONNECT TO GROUND BUS PROVIDED BY OTHERS.
- SEE DETAIL 'C', SHEET E-002 FOR TVSS RECEPTACLE LOCATIONS, TYPICAL. PROVIDE SURGE SUPPRESSOR RECEPTACLES HUBBELL #HBL52625A. PROVIDE (2) #12 GROUNDS, ONE FOR MECHANICAL BOND, ONE FOR RECEPTACLES. REFER TO ARCHITECTURAL DRAWINGS FOR EXACT LOCATIONS.

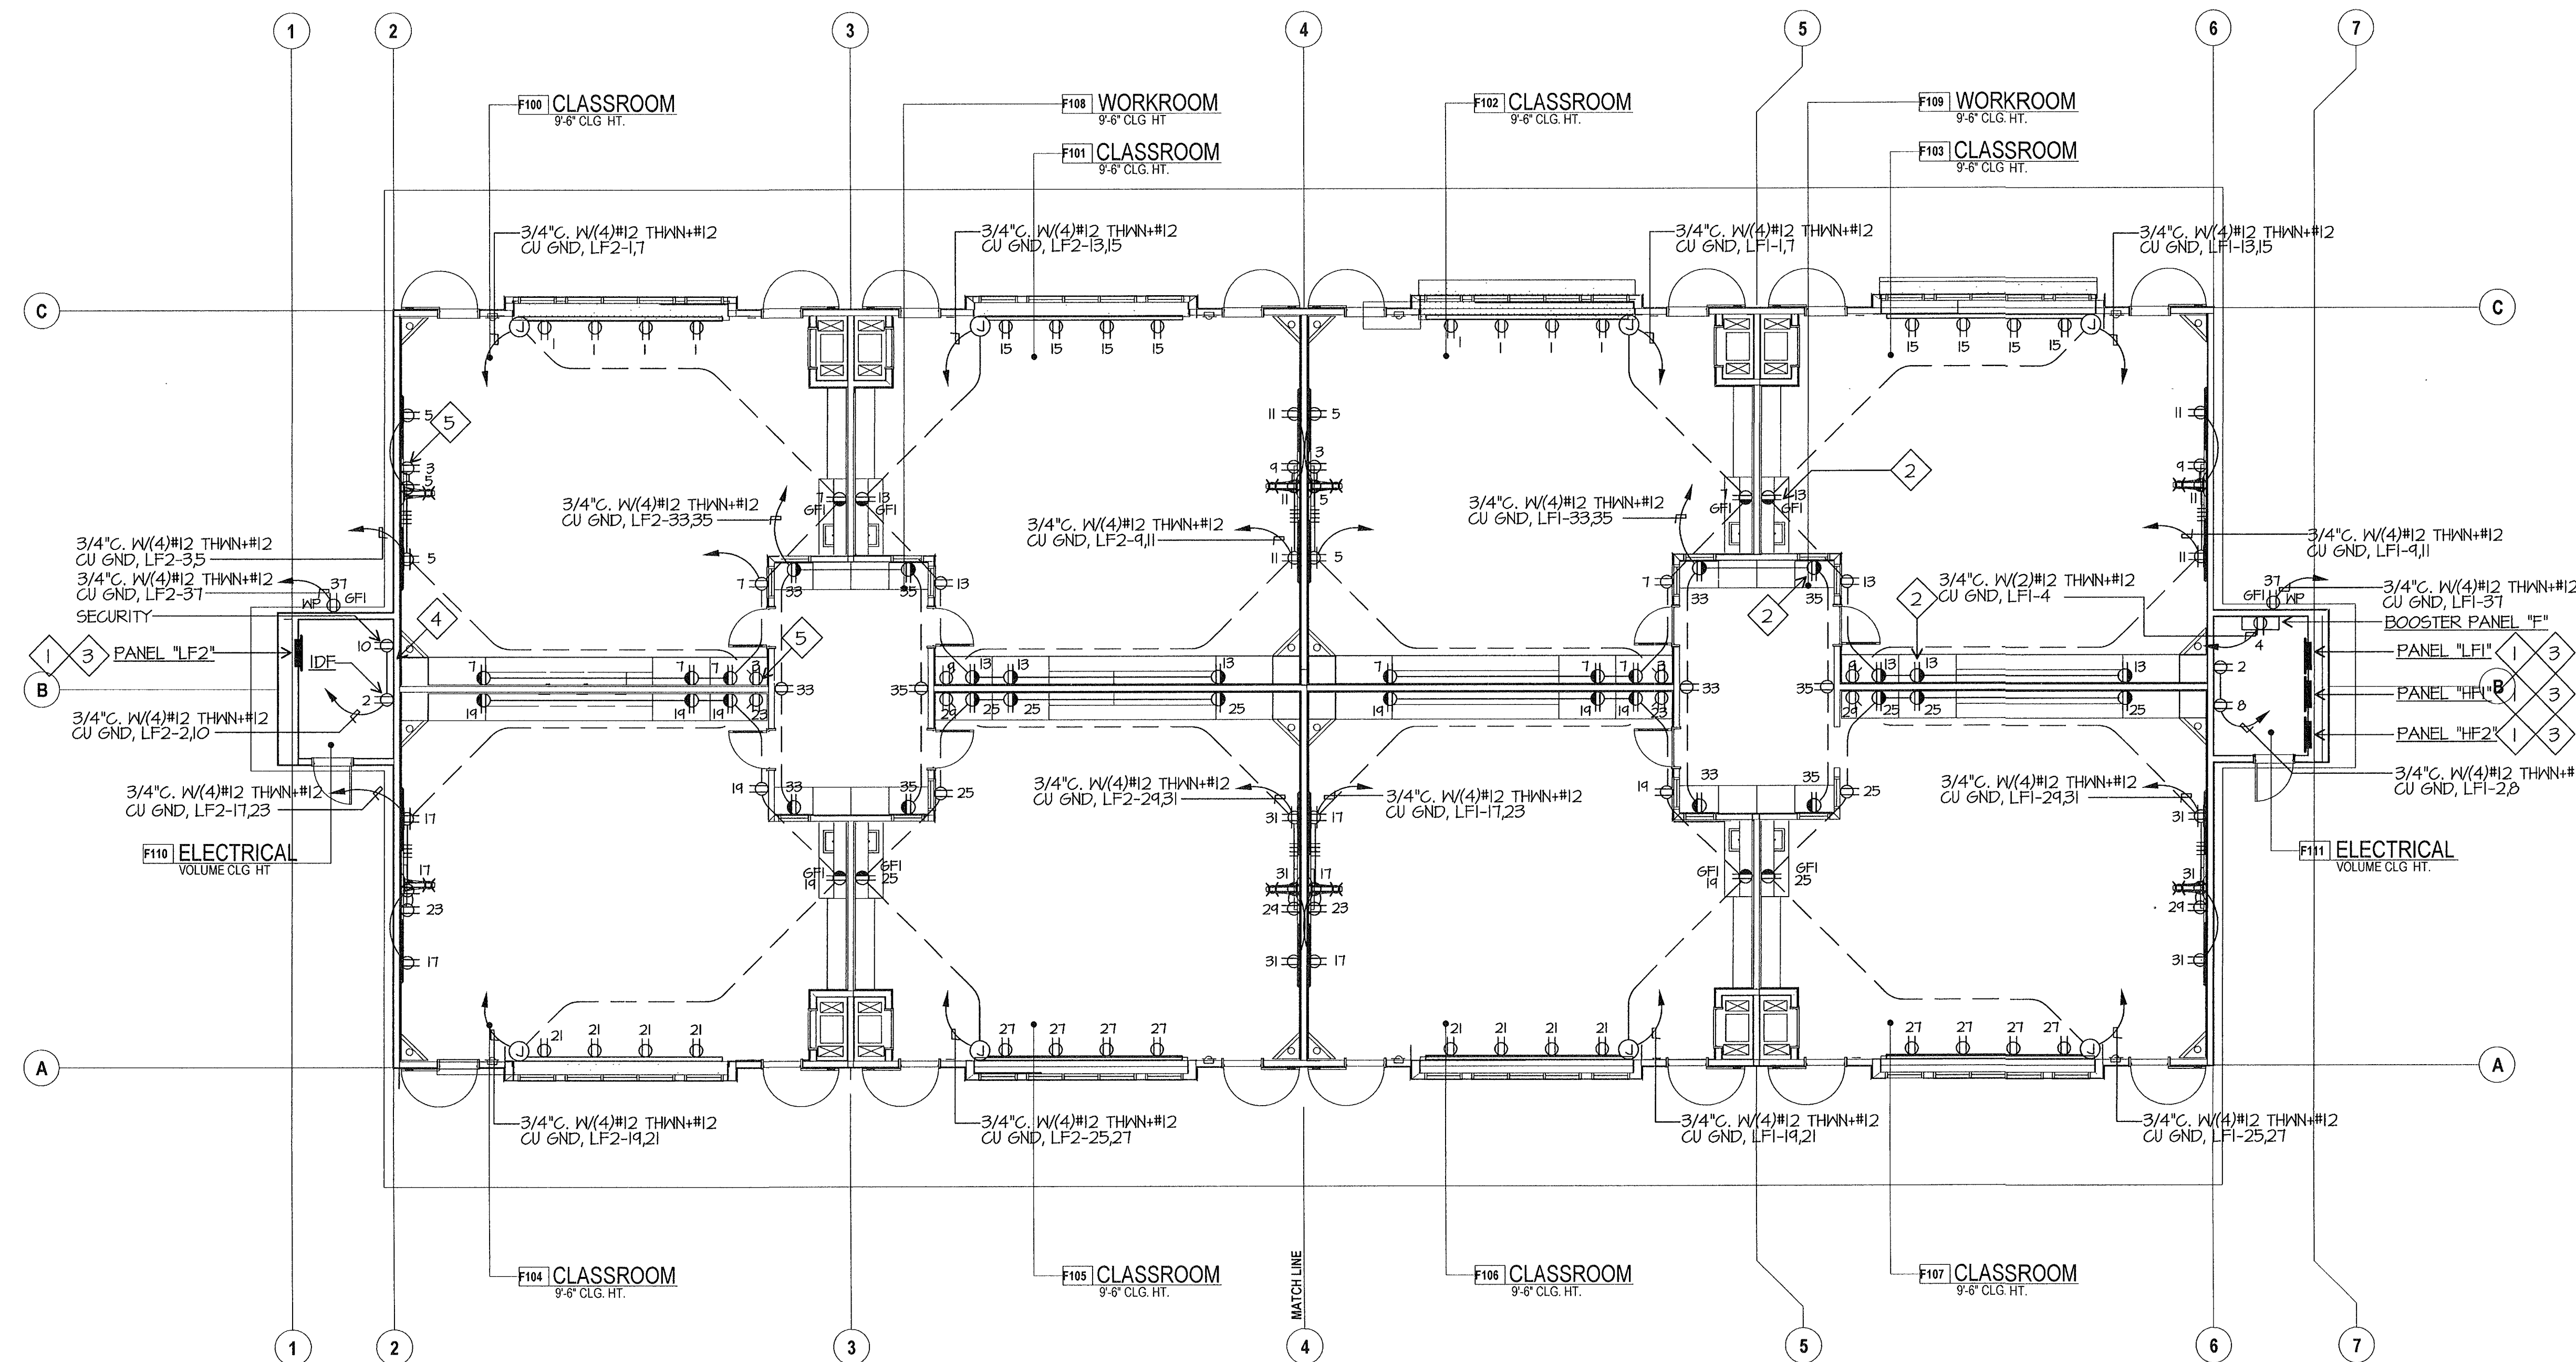

ELECTRICAL PLAN BUILDING F

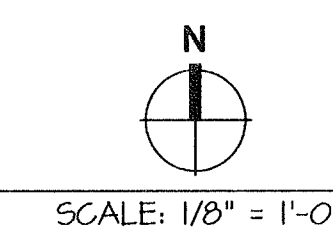

I:\PEL\08110244\DATE\12-22-11 AC