


IDENTIFICATION STAMP  
DIVISION OF STATE ARCHITECT  
OFFICE OF REGULATION SERVICES  
APPL # : 02-112027  
FILE # : 15-6  
AC: [Signature] FS: [Signature] SS: [Signature]  
DATE: JAN 20 2012

NEW ELEMENTARY SCHOOL  
9801 HIGHLAND KNOLLS DR  
BAKERSFIELD  
CALIFORNIA  
93306

NEW MIDDLE SCHOOL  
4115 VINELAND ROAD  
BAKERSFIELD  
CALIFORNIA  
93306

FOR:  
BAKERSFIELD CITY SCHOOL  
DISTRICT  
1300 BAKER STREET  
BAKERSFIELD  
CALIFORNIA  
93305

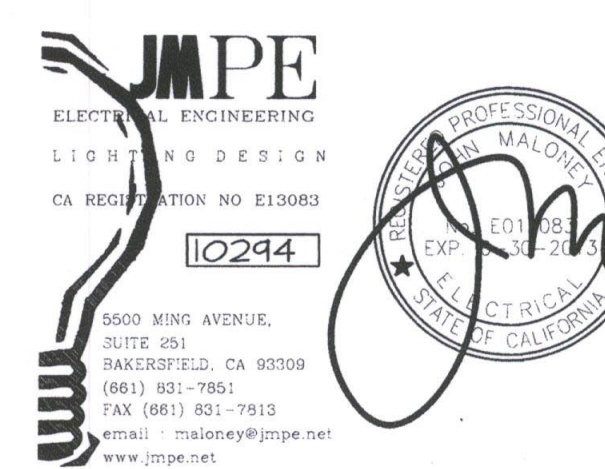

MARK	DATE	DESCRIPTION

△		
△		
△		
△		

JOB NUMBER:  
20101244  
CAD DRAWING FILE:

DRAWN BY:  
AC  
CHECKED BY:  
PH

CHECK AND VERIFY ALL DIMENSIONS BEFORE  
PROCEEDING WITH THE WORK.  
REPORT DISCREPANCIES TO THE ARCHITECT.

THE DRAWINGS, IDEAS, AND DESIGNS  
REPRESENTED ON THIS SHEET ARE THE  
PROPERTY OF THE ARCHITECT.

COPYRIGHT  
ORDIZ-MELBY ARCHITECTS, INC. 2010

SHEET TITLE  
**LIGHTING PLAN**  
**BUILDING H**

SHEET IDENTIFICATION NUMBER  
**E-132H**

SHEET OF

**LIGHTING PLAN NOTES**


- 1 EMERGENCY EXTERIOR FIXTURES SHALL HAVE EQUIPMENT GROUNDING CONDUCTOR, NEUTRAL, SWITCHED HOT AND HOT TYPICAL.
- 2 600V 18 PAIR SHIELDED CABLE FOR DIMMING, TYPICAL.
- 3 AT WALLS ABLE TO RESIST THE PASSAGE OF SMOKE, CAULK ALL PENETRATIONS.

LINE TYPE	WALL TYPE
---	SMOKE SEPARATION


REQUEST:  
RDM Electric - 10/16/12  
Reference Sheets E016 & E-132H  
The Light Fixture Schedule calls out for the Type D light fixture to be 55W. It calls out for the Type D1 light fixture to be 35W, which is typical for restrooms. The Electrical Plan for Building H shows (5) Type D light fixtures to be installed in Room H106, but shows them to be 35W. Should the (5) light fixtures shown in Room H106 be Type D1 and not Type D? Please advise.

ANSWER:  
John Maloney - J.M.P.E. - 11/2/12  
Type D1 is 35 Watts and mounted over mirrors  
Type D is 55 Watts and ceiling mounted  
Type D1 is a 1 lamp fixture  
Type D2 is a 2 lamp fixture


RFI 185

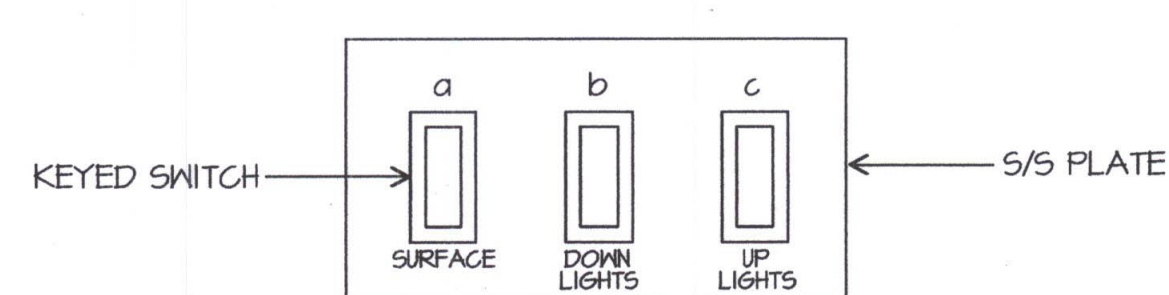

SWITCHBANK DETAIL (A)

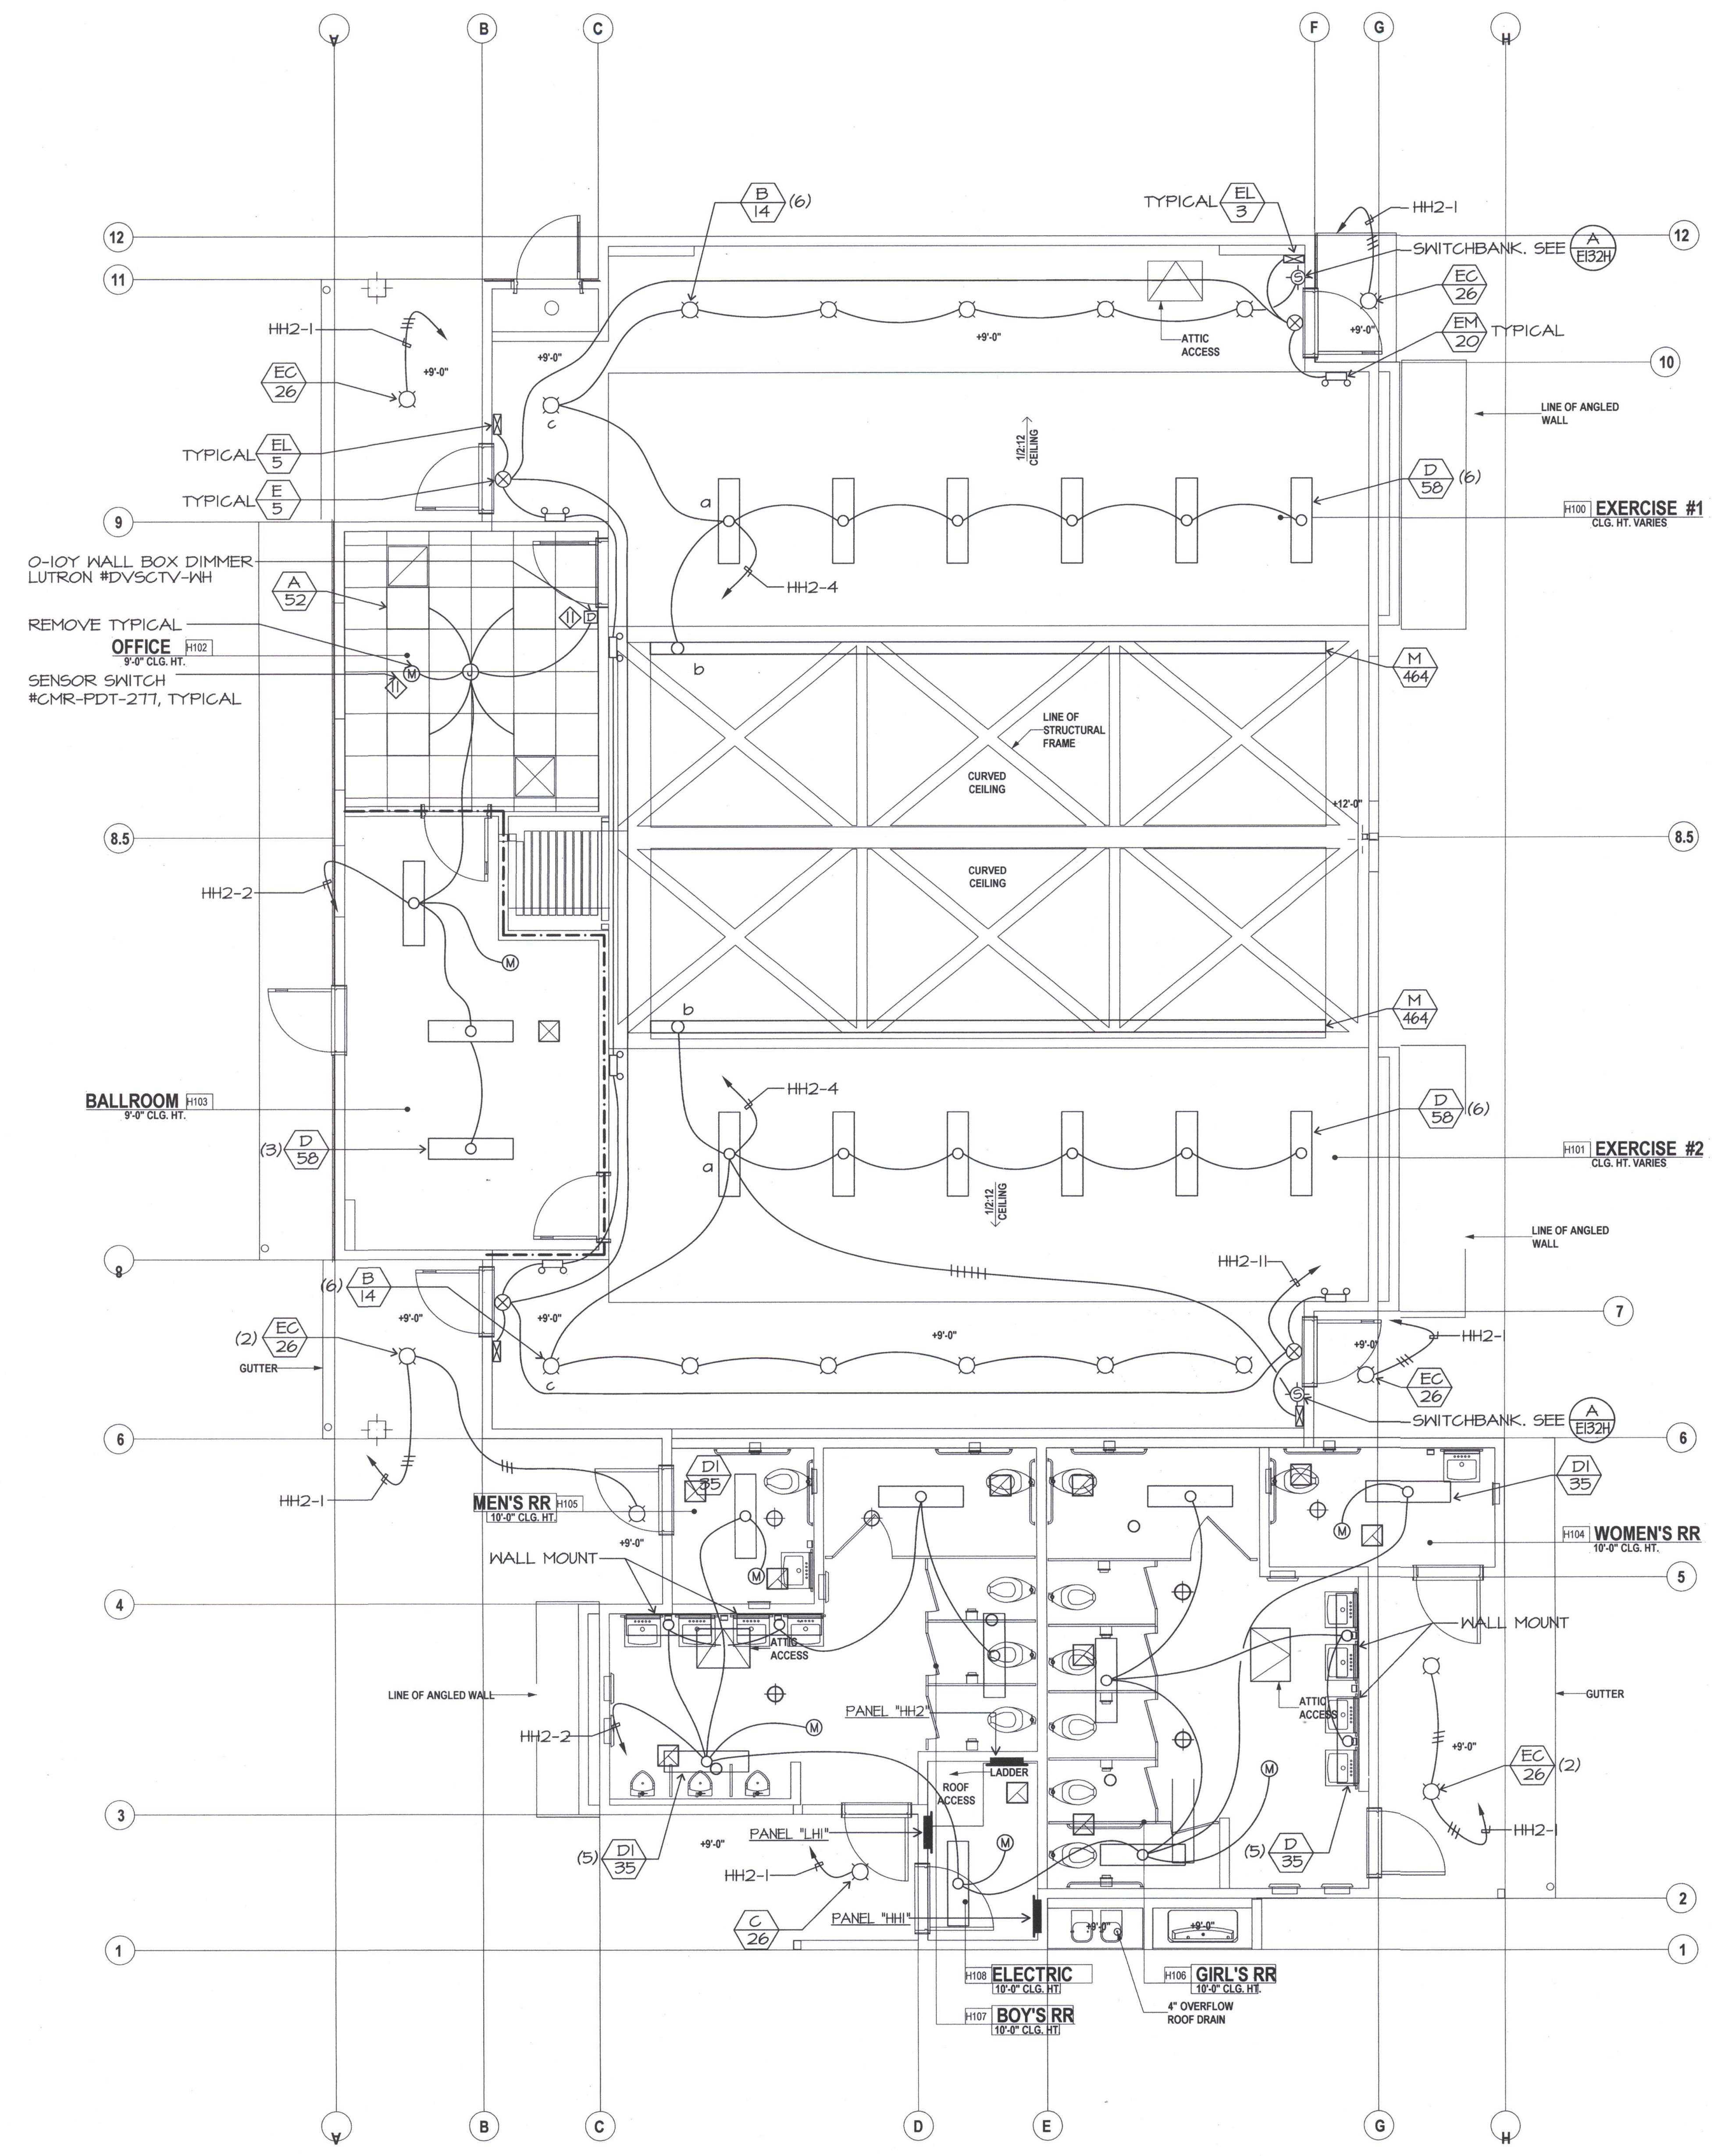

LIGHTING PLAN BUILDING H

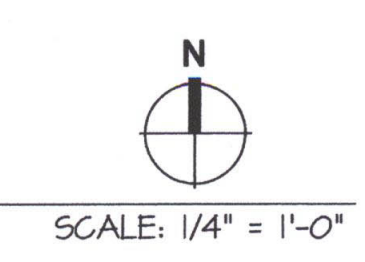

TEL: 805-102-9440 DATE: 12-21-11 AC