


NEW ELEMENTARY SCHOOL
9801 HIGHLAND KNOLLS DR
BAKERSFIELD
CALIFORNIA
93306

NEW MIDDLE SCHOOL
4115 VINELAND ROAD
BAKERSFIELD
CALIFORNIA
93306

FOR:
BAKERSFIELD CITY SCHOOL DISTRICT
1300 BAKER STREET
BAKERSFIELD
CALIFORNIA
93305

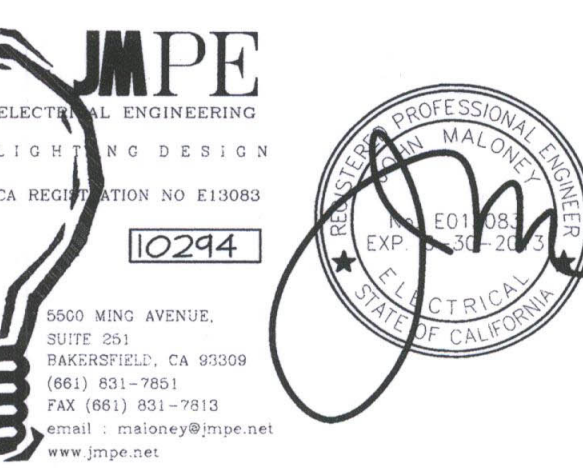

MARK	DATE	DESCRIPTION

JOB NUMBER: 20101244
CAD DRAWING FILE:

DRAWN BY: AC
CHECKED BY: PH

CHECK AND VERIFY ALL DIMENSIONS BEFORE PROCEEDING WITH THE WORK. REPORT DISCREPANCIES TO THE ARCHITECT.

THE DRAWINGS, IDEAS, AND DESIGNS REPRESENTED ON THIS SHEET ARE THE PROPERTY OF THE ARCHITECT.





COPYRIGHT: ORDIZ-MELBY ARCHITECTS, INC. 2010

SHEET TITLE
ELECTRICAL PLAN BUILDING J,K,Q,R

SHEET IDENTIFICATION NUMBER

E-121J,K,Q,R

SHEET OF

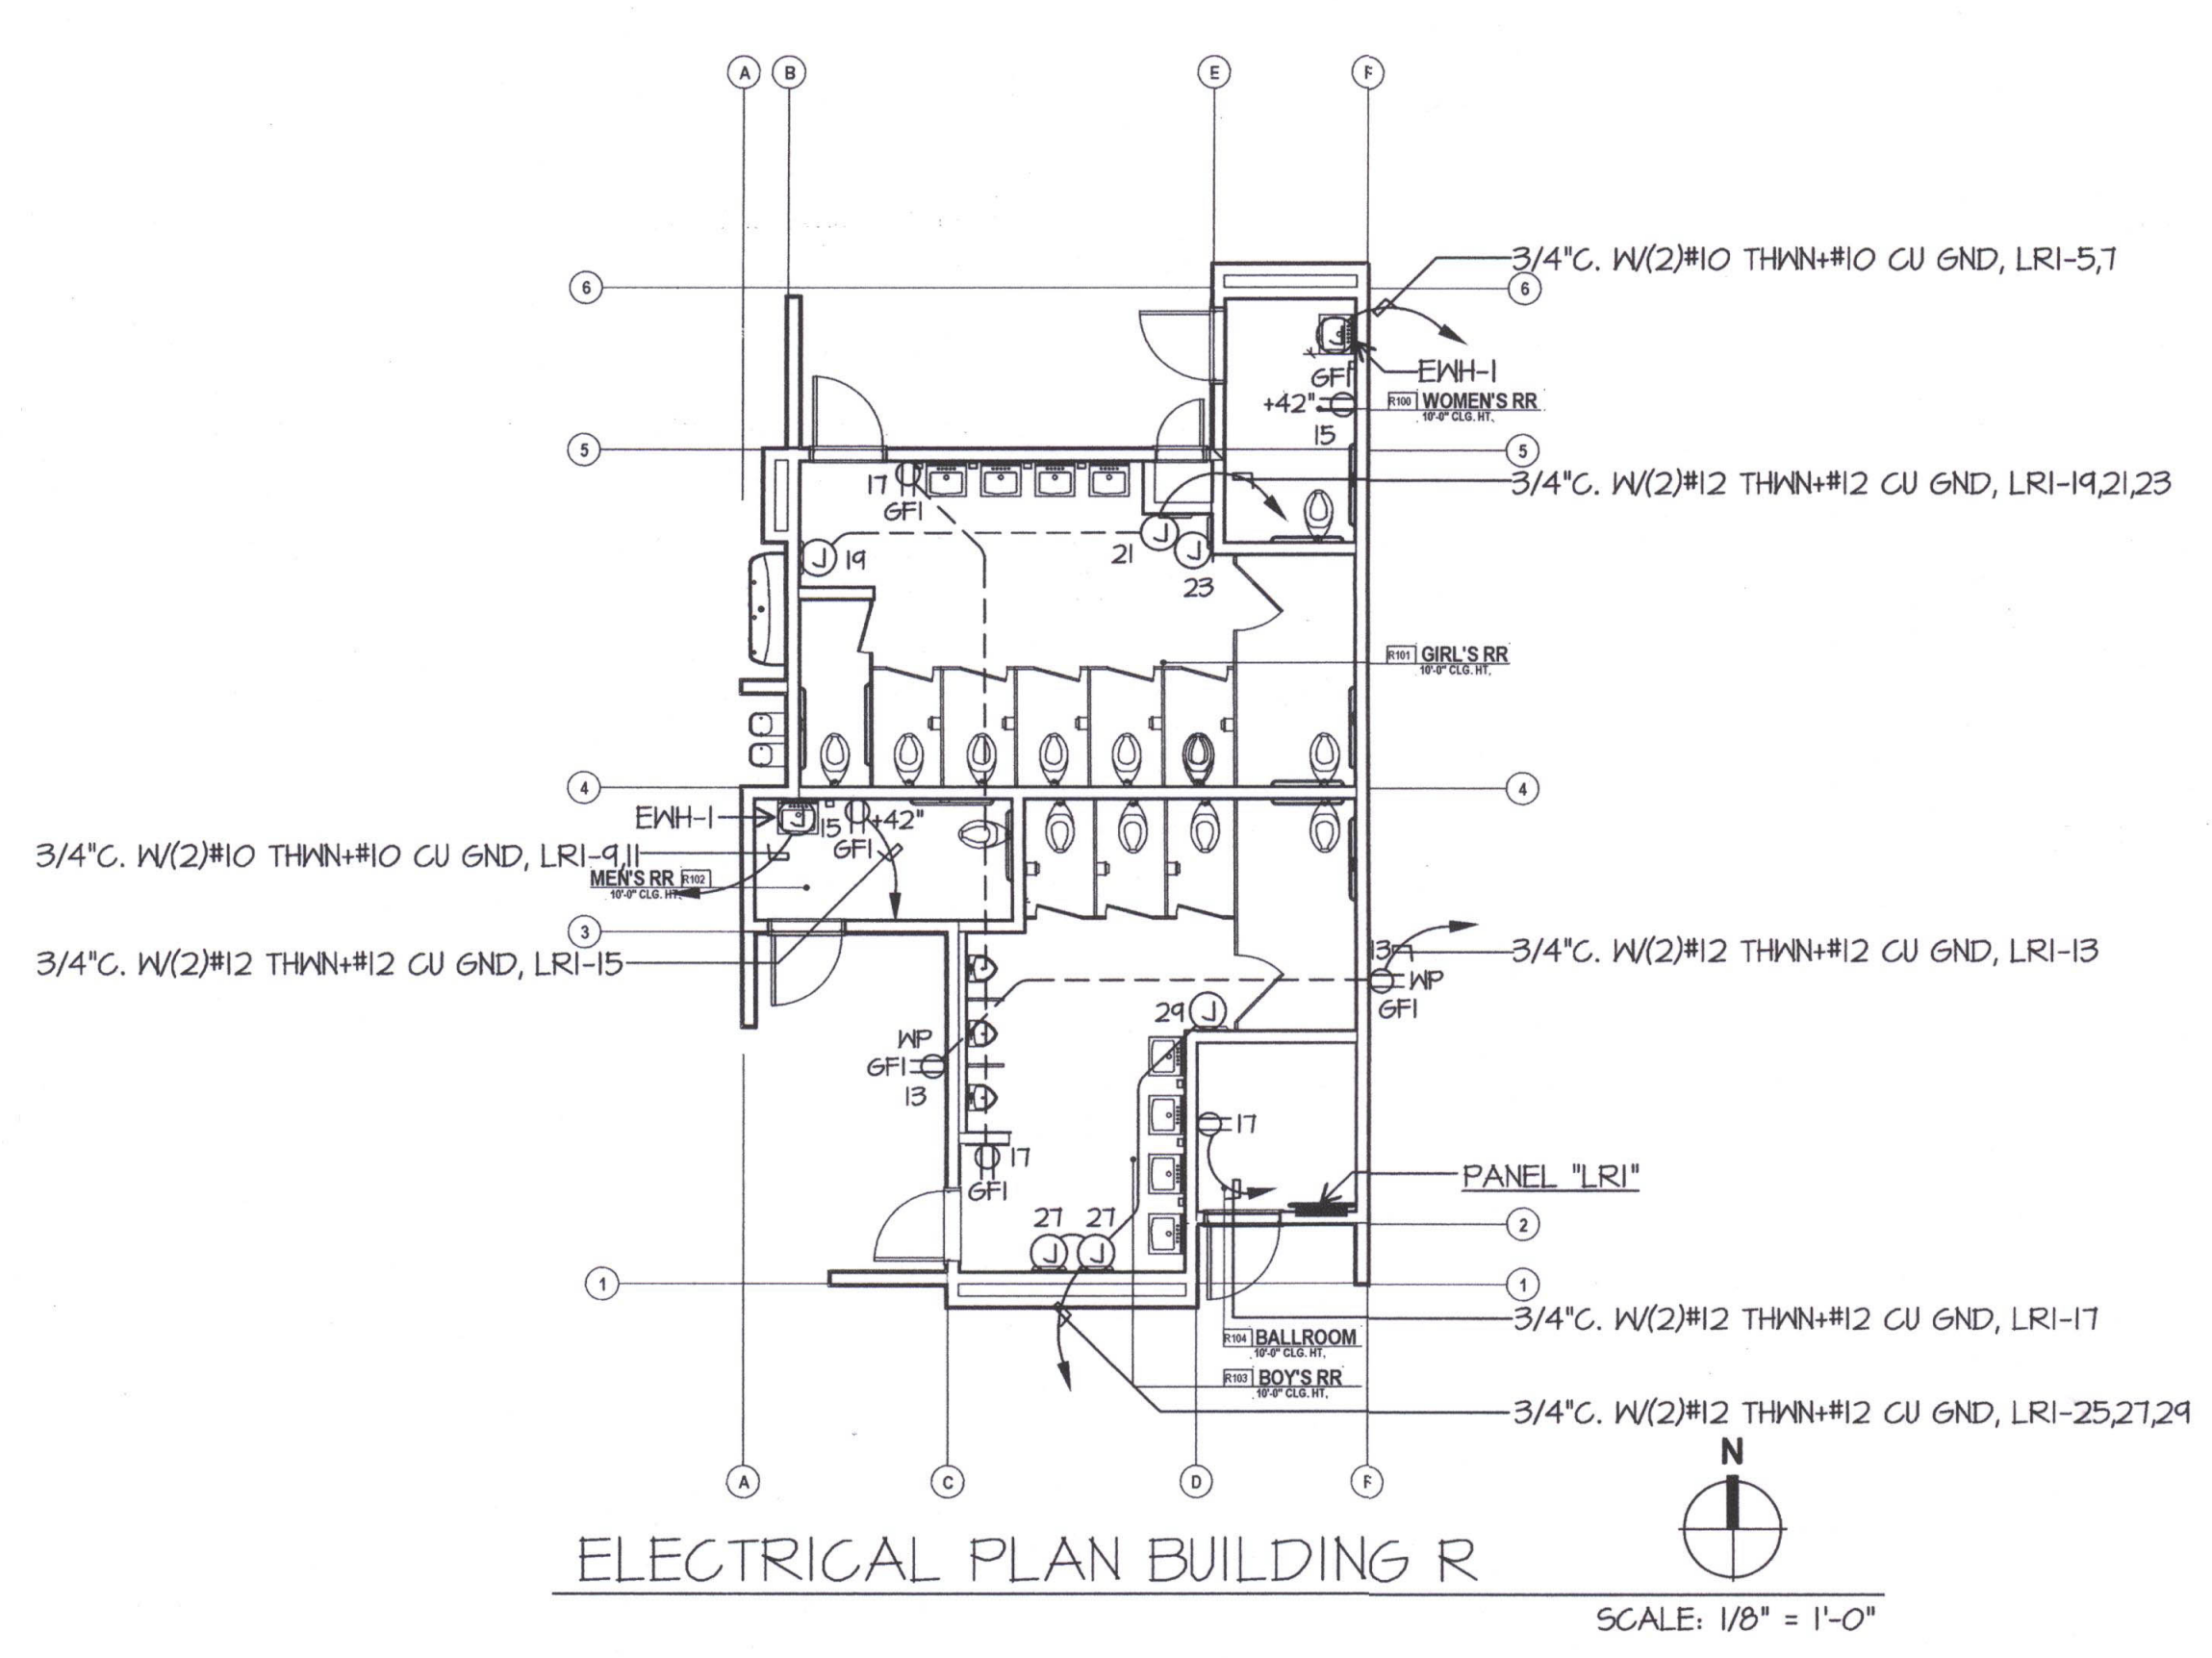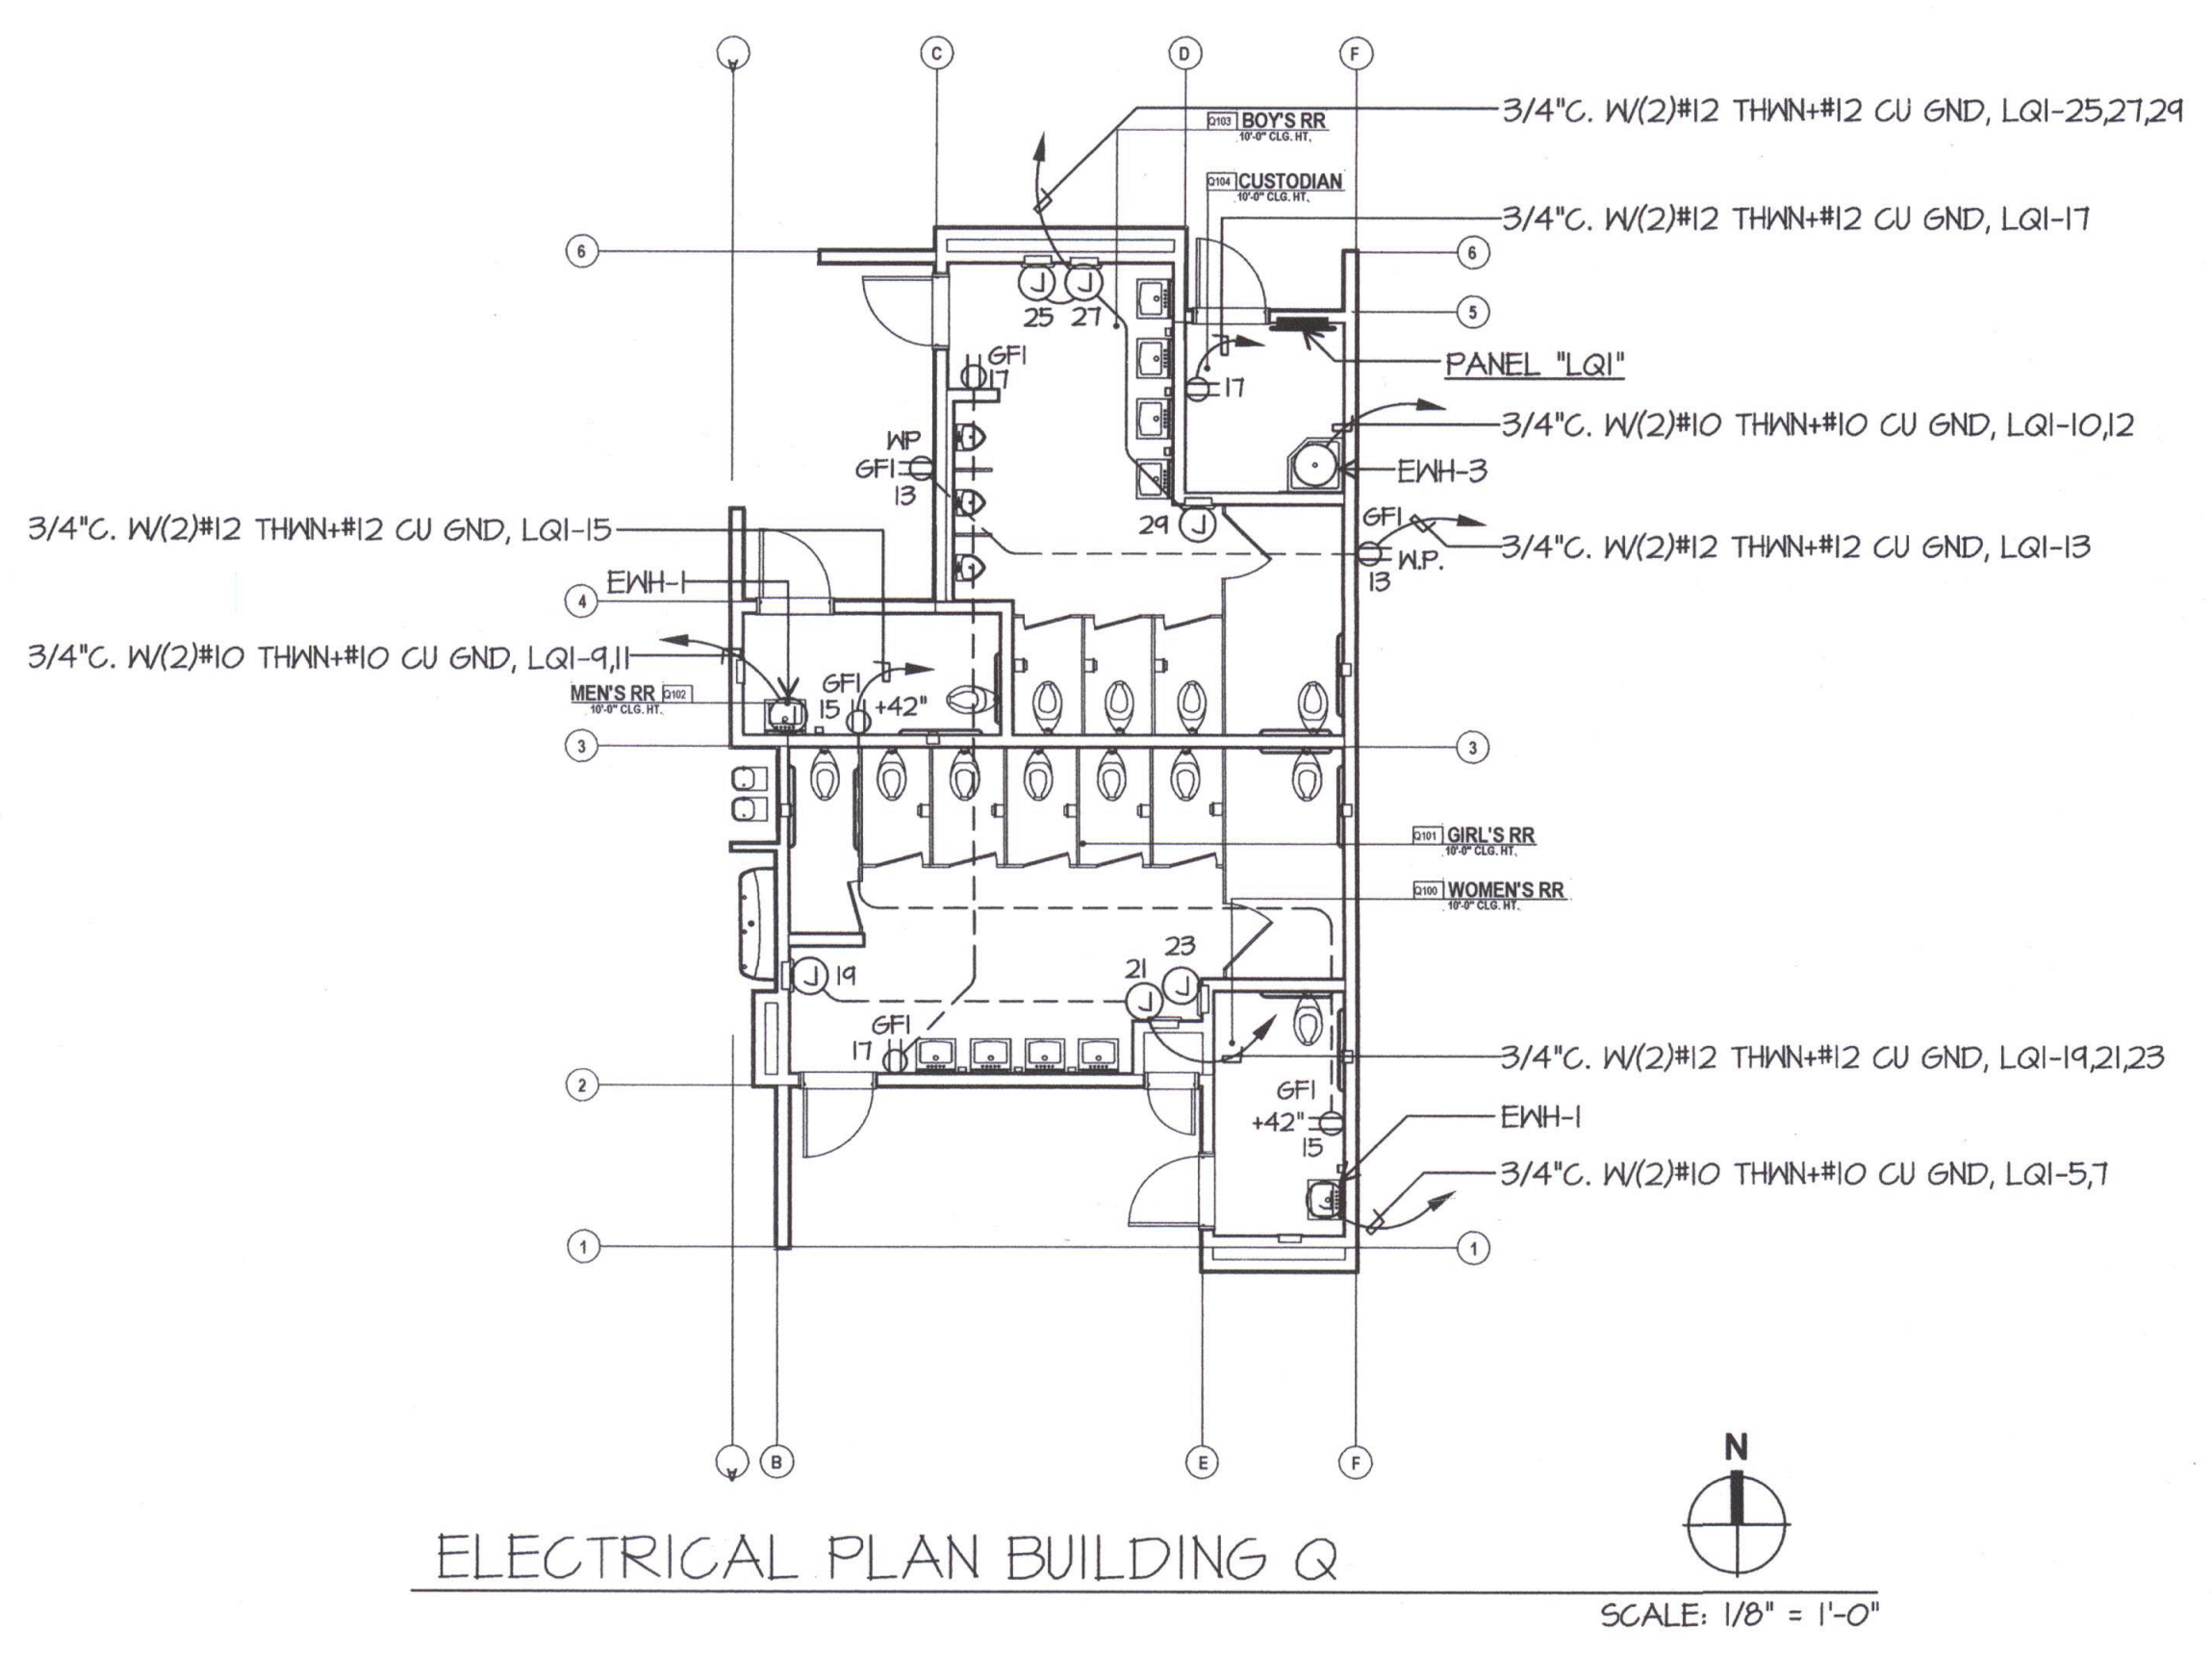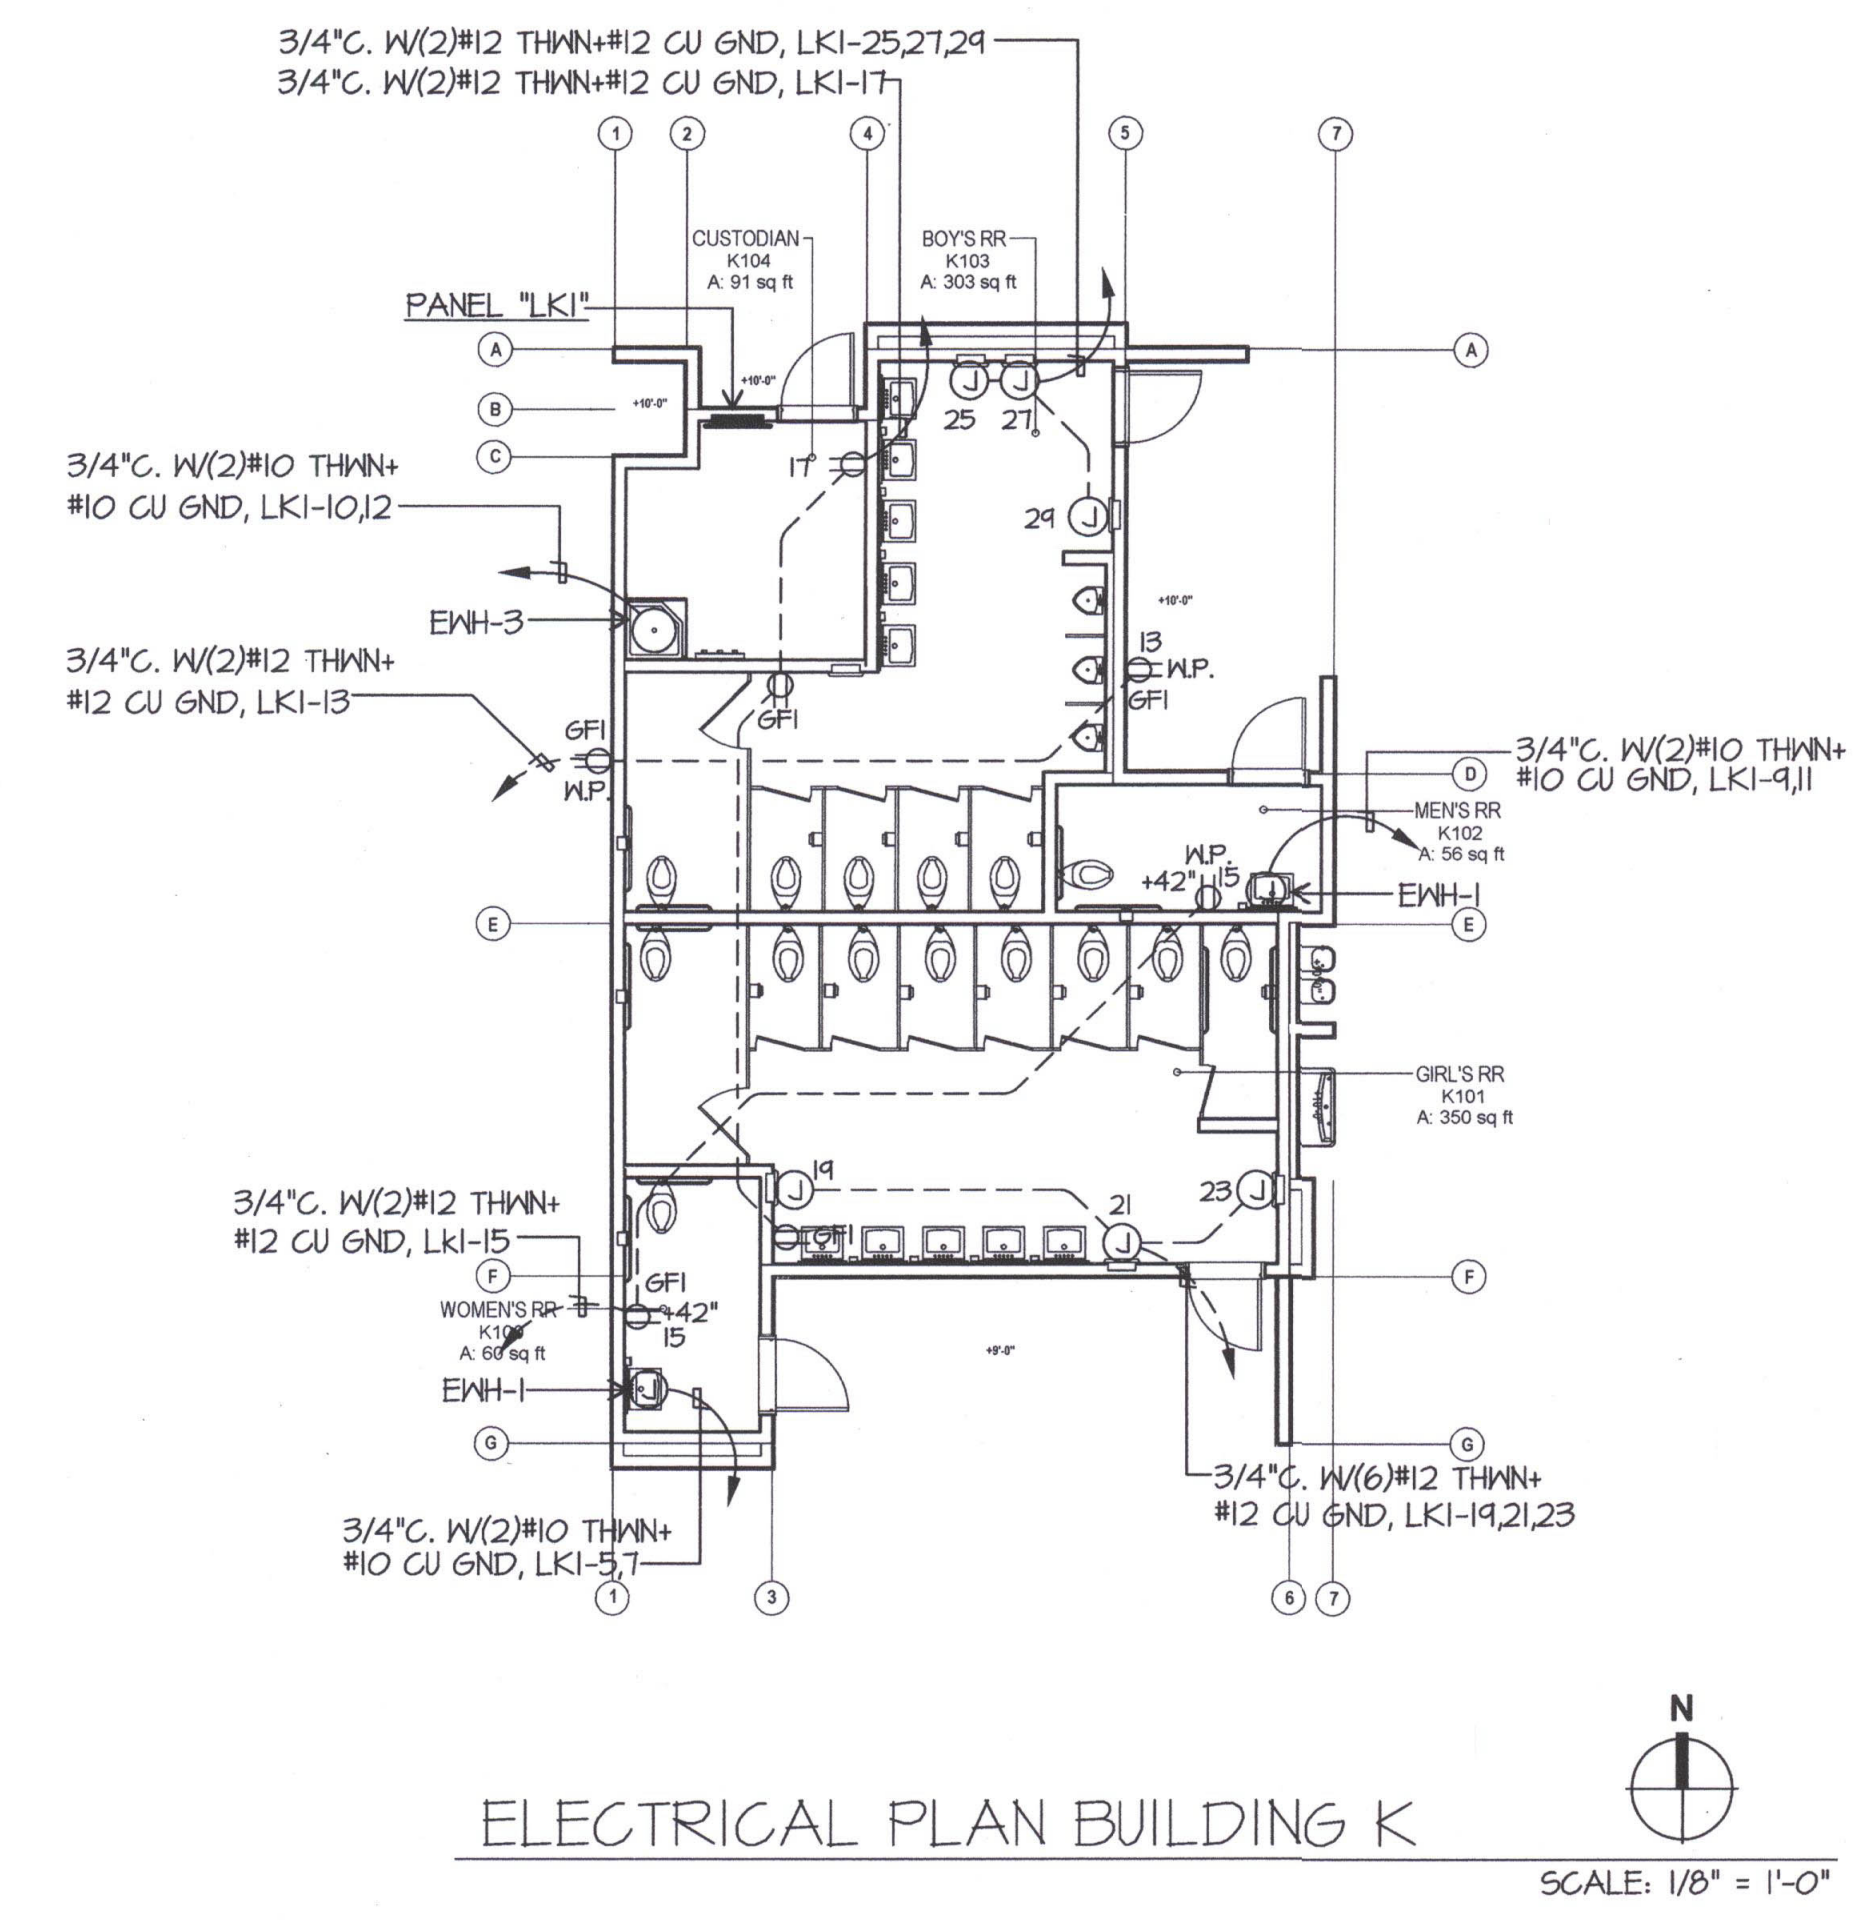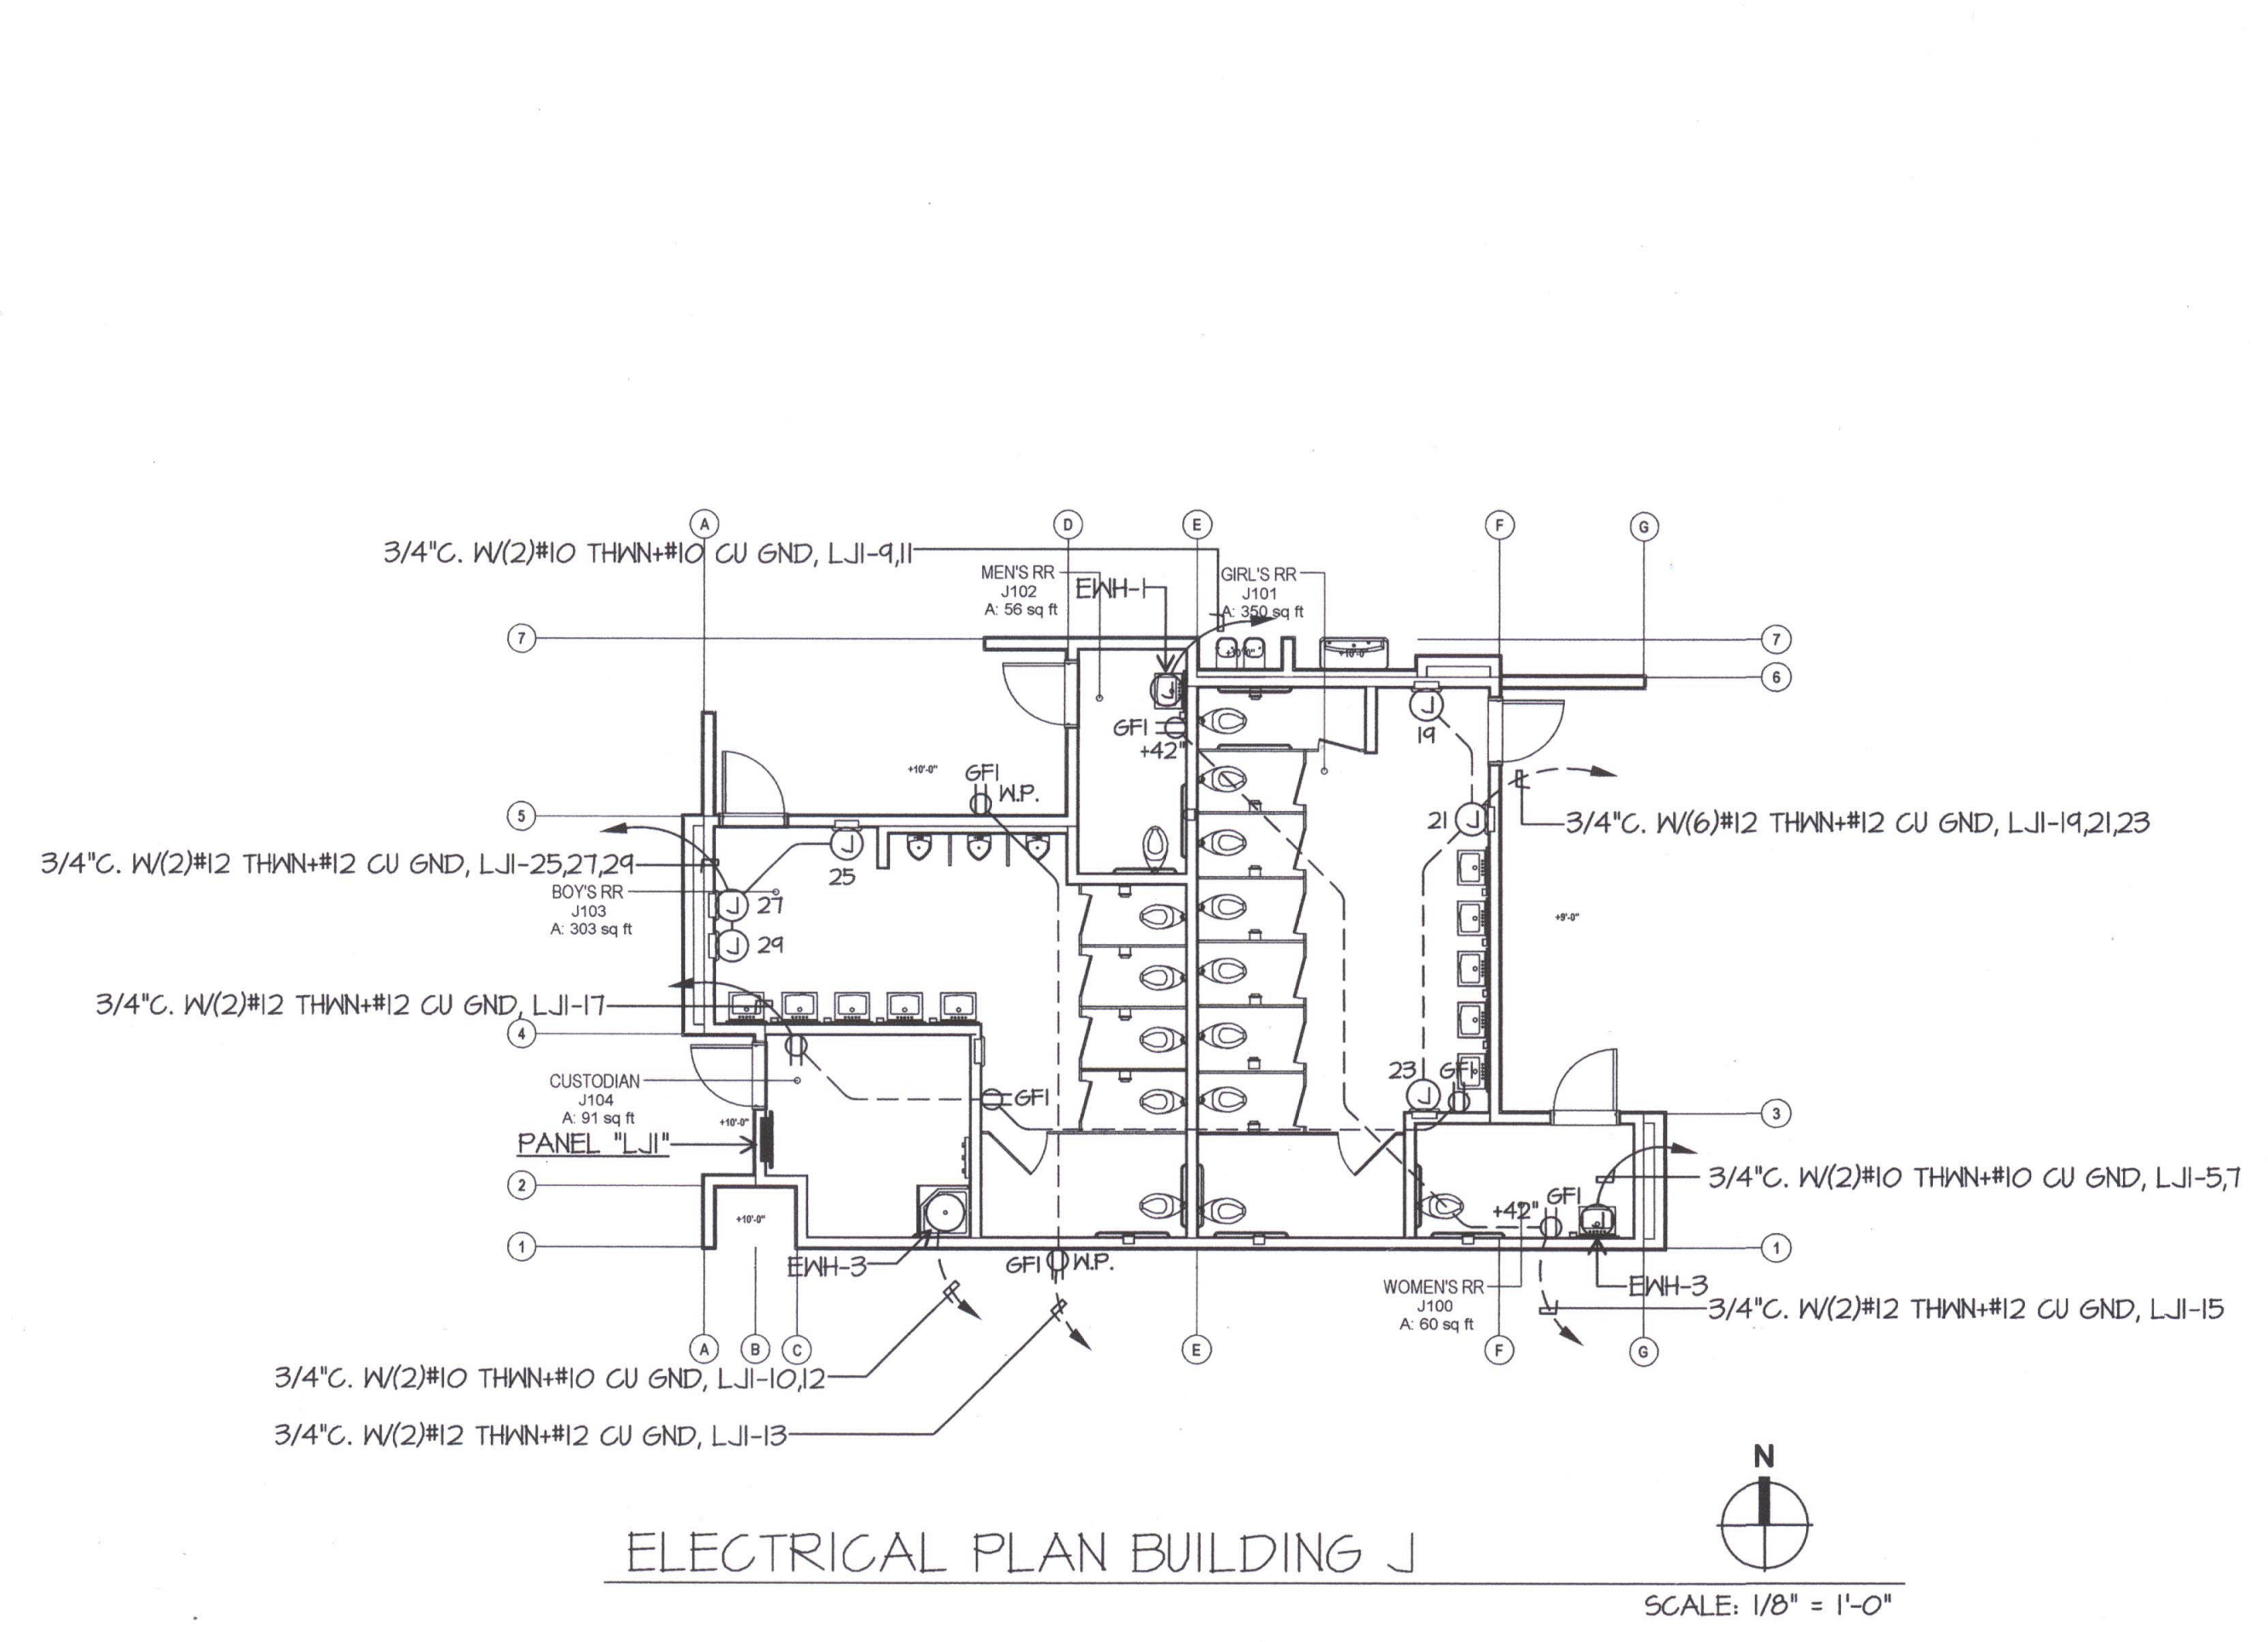

Item #33: Refer to Electrical Drawing E-121J,K,Q,R
ADD A. Delete sheet E-121J,K,Q,R. Replace with revised sheet E-R121J,K,Q,R as attached.
No. 2