

**ORDIZ  
MELBY**  
ARCHITECTS, INC.

5500 MING AVENUE SUITE 280  
BAKERSFIELD, CALIFORNIA 93309  
TELEPHONE (805) 832-5258  
FACSIMILE (805) 832-4291




*Dan E. Ordiz*  
DANN E. ORDIZ, AIA  
ARCHITECT C-14,728  
WILLIAM J. MELBY, AIA  
ARCHITECT C-16,835  
CONSULTANT

IDENTIFICATION STAMP  
DIVISION OF STATE ARCHITECT  
OFFICE OF REGULATION SERVICES  
APPL # : 02-112027  
FILE # : 15-6  
AC: [Signature] SS: [Signature]  
DATE: 1/18/12

NEW ELEMENTARY SCHOOL  
9801 HIGHLAND KNOLLS DR  
BAKERSFIELD  
CALIFORNIA  
93306

NEW MIDDLE SCHOOL  
4115 VINELAND ROAD  
BAKERSFIELD  
CALIFORNIA  
93306

FOR:  
BAKERSFIELD CITY SCHOOL  
DISTRICT  
1300 BAKER STREET  
BAKERSFIELD  
CALIFORNIA  
93305

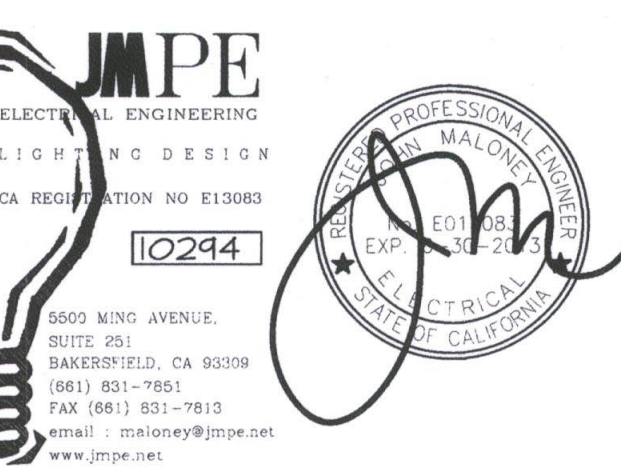

MARK DATE DESCRIPTION

△		
△		
△		
△		

JOB NUMBER:  
20101244  
CAD DRAWING FILE:

DRAWN BY:  
AC  
CHECKED BY:  
PH

CHECK AND VERIFY ALL DIMENSIONS BEFORE  
PROCEEDING WITH THE WORK.  
REPORT DISCREPANCIES TO THE ARCHITECT.  
THE DRAWINGS, IDEAS, AND DESIGNS  
REPRESENTED ON THIS SHEET ARE THE  
PROPERTY OF THE ARCHITECT.


COPYRIGHT  
ORDIZ-MELBY ARCHITECTS, INC. 2010

SHEET TITLE  
**ELECTRICAL MECHANICAL  
PLAN BUILDING J,K,Q,R**


SHEET IDENTIFICATION NUMBER

**E-122J,K,Q,R**


SHEET OF

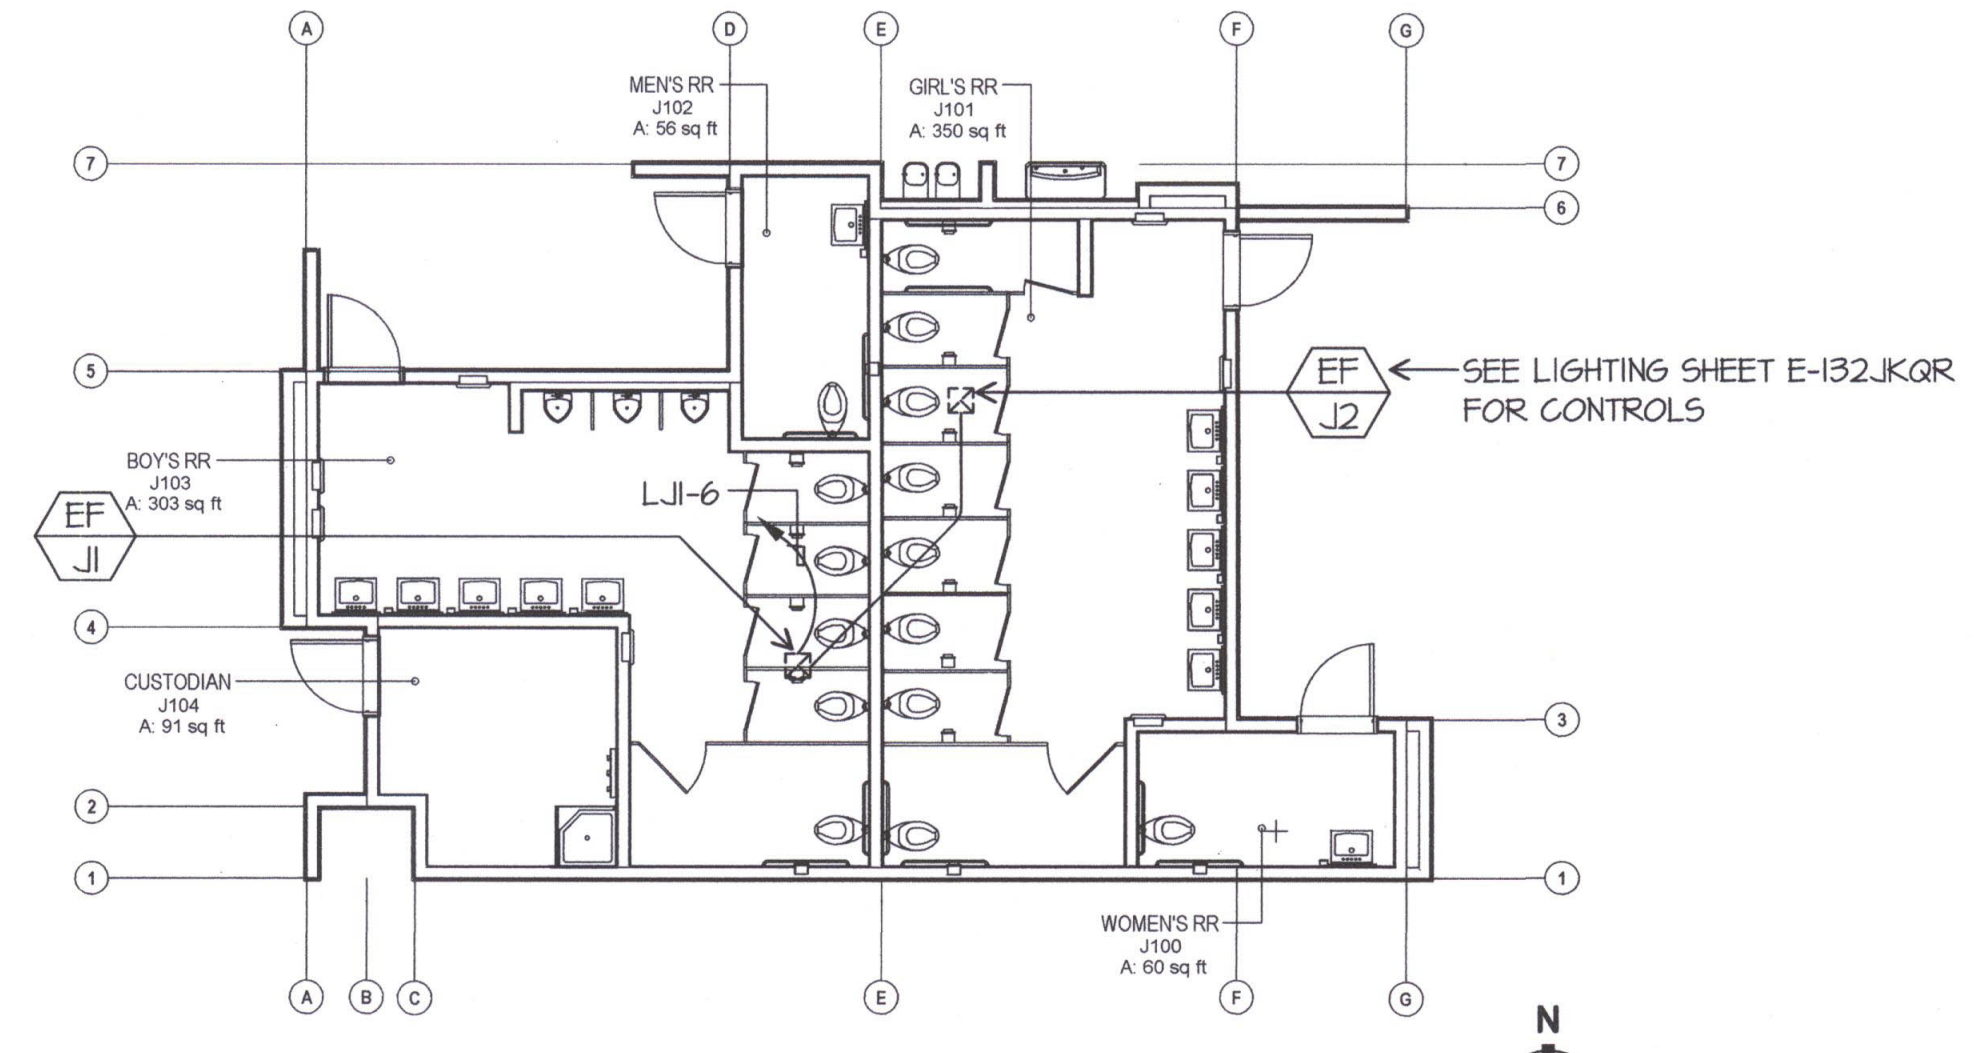


ELECTRICAL MECHANICAL PLAN BUILDING J  
SCALE: 1/8" = 1'-0"

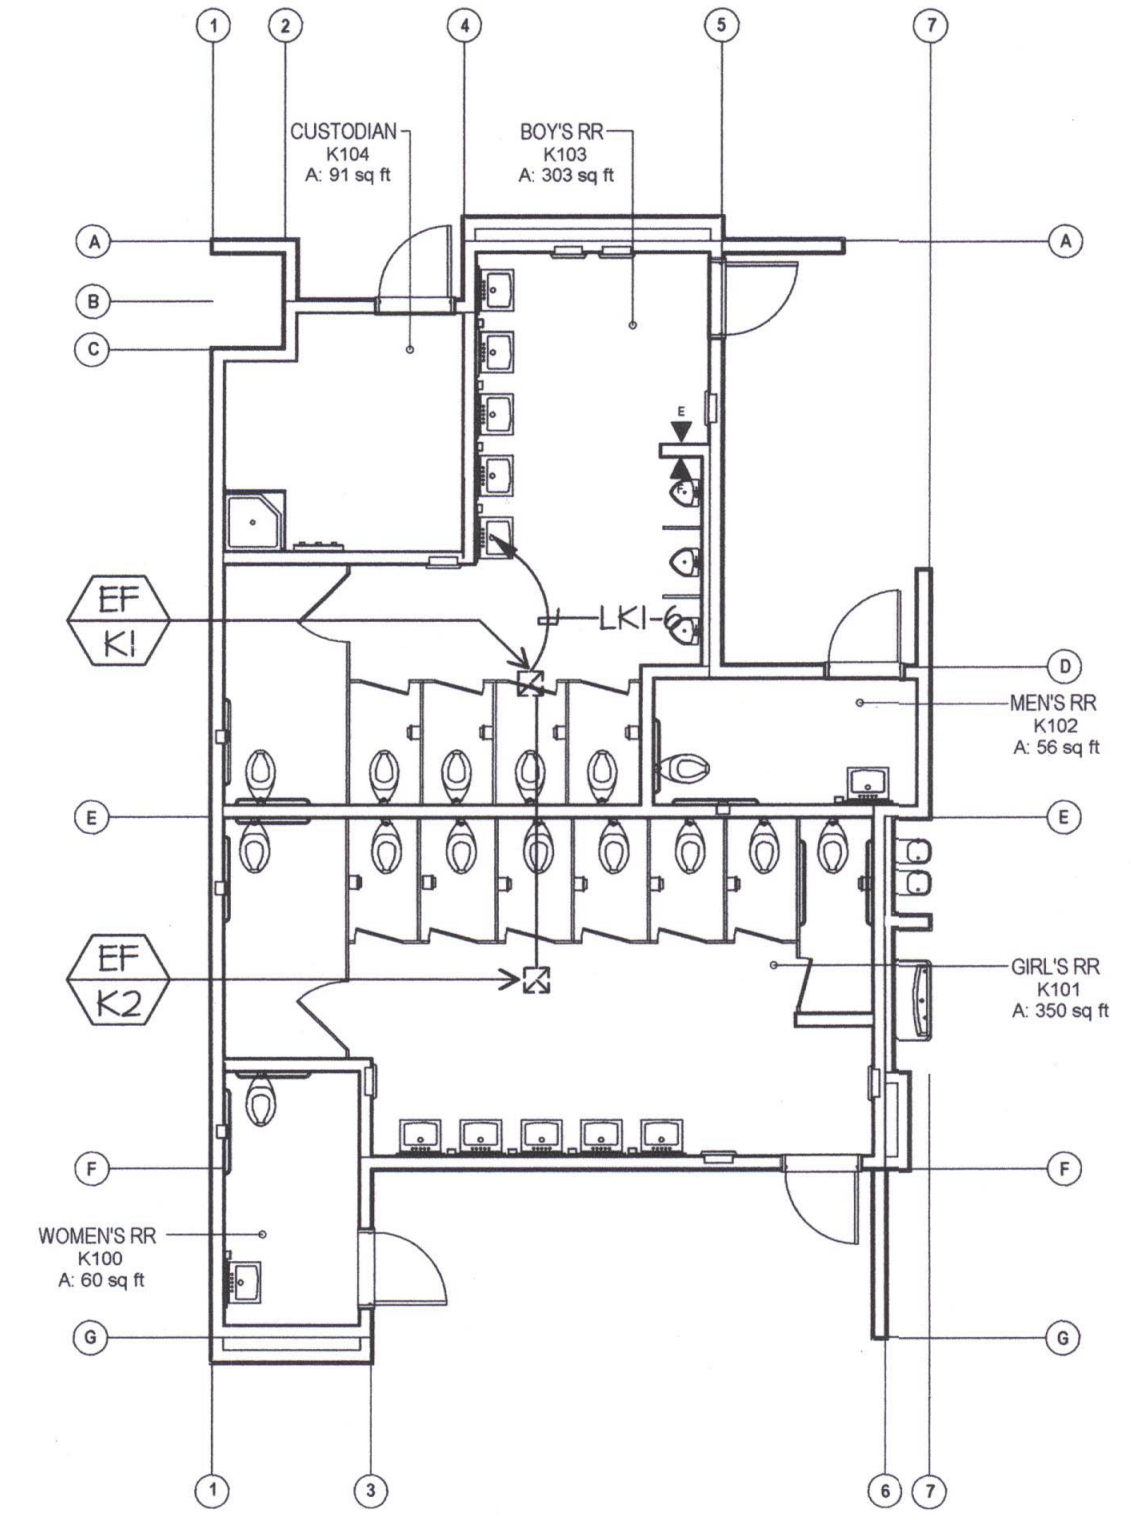

ELECTRICAL MECHANICAL PLAN BUILDING K  
SCALE: 1/8" = 1'-0"

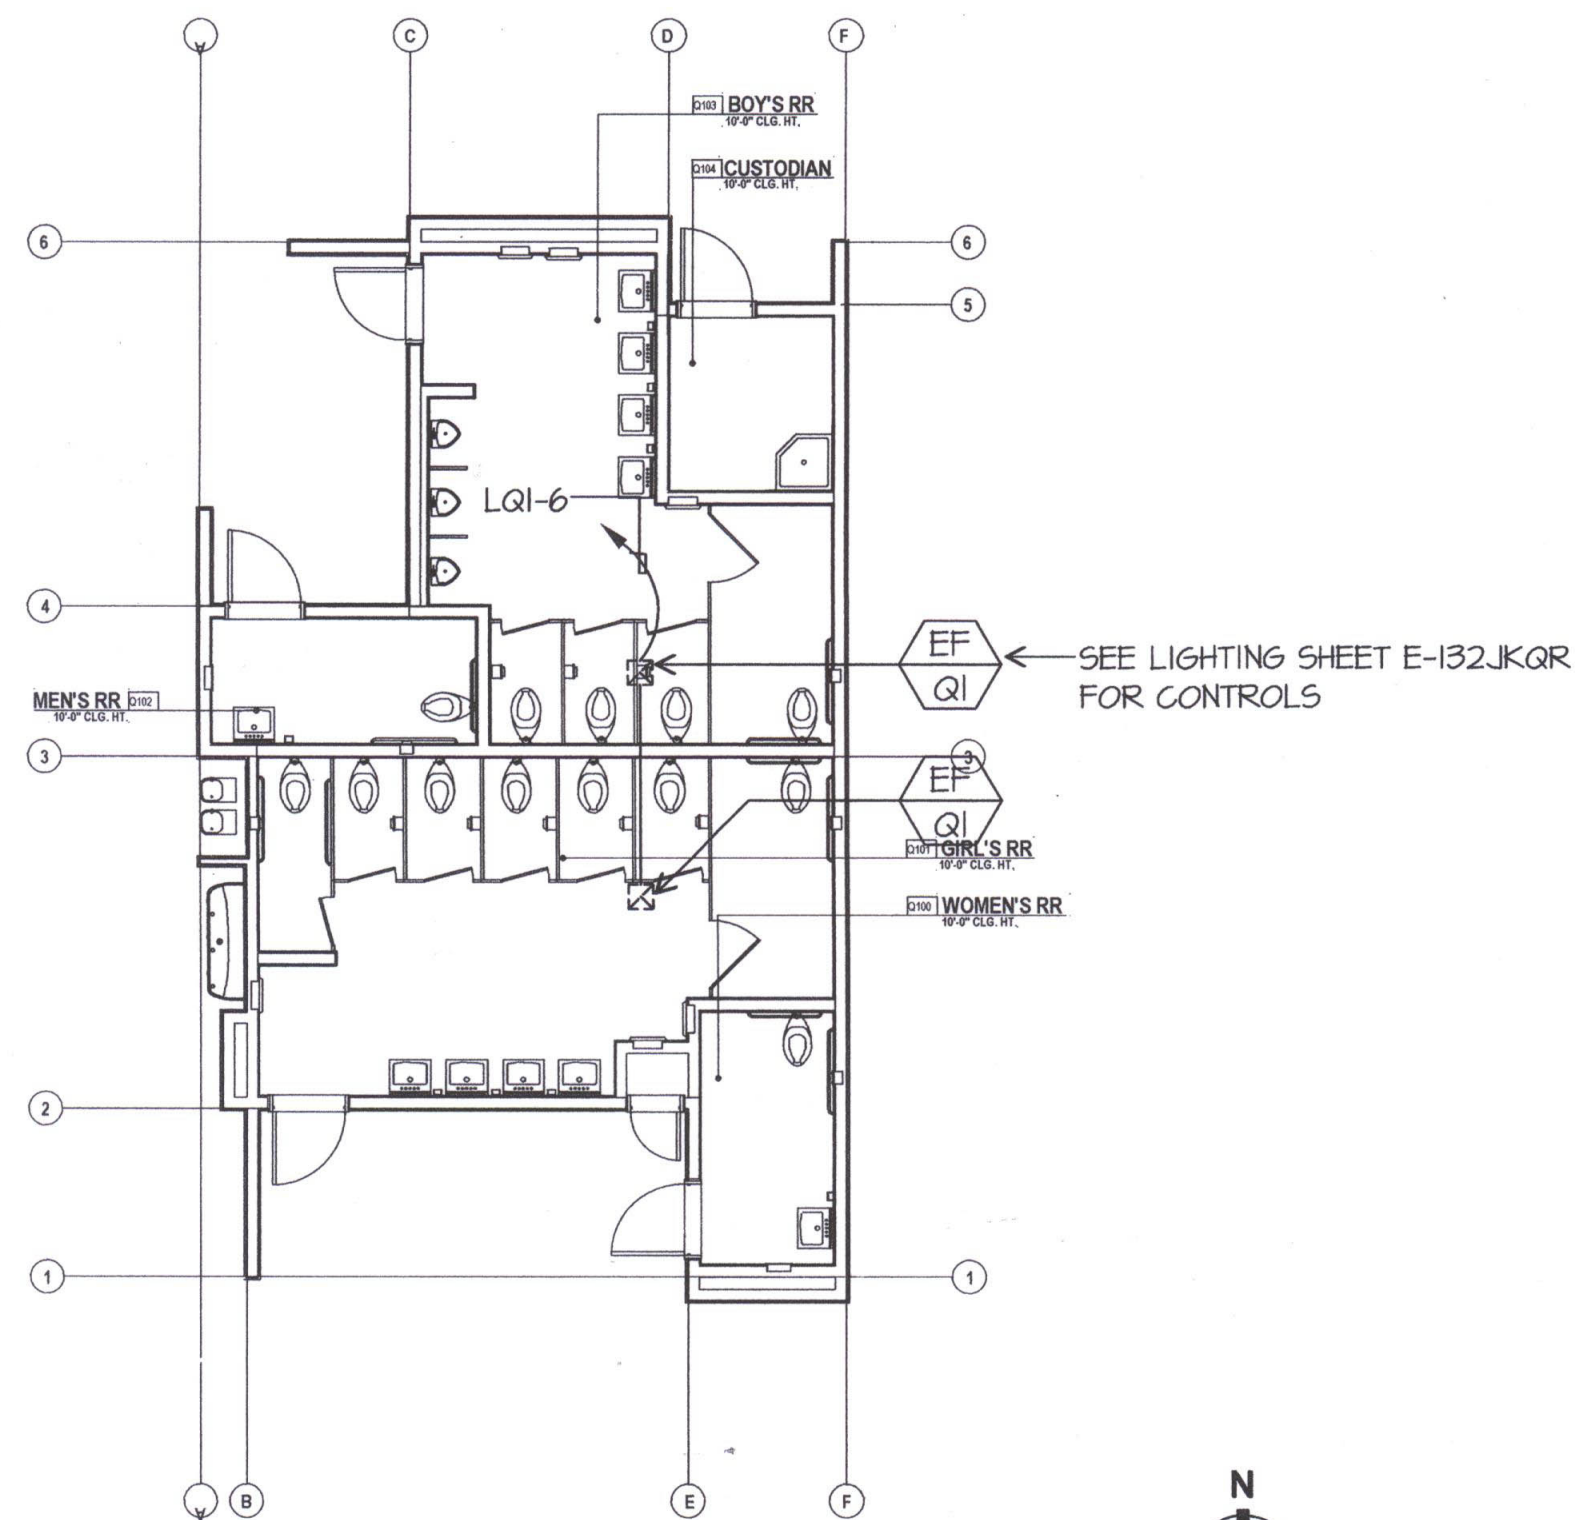

ELECTRICAL MECHANICAL PLAN BUILDING Q  
SCALE: 1/8" = 1'-0"

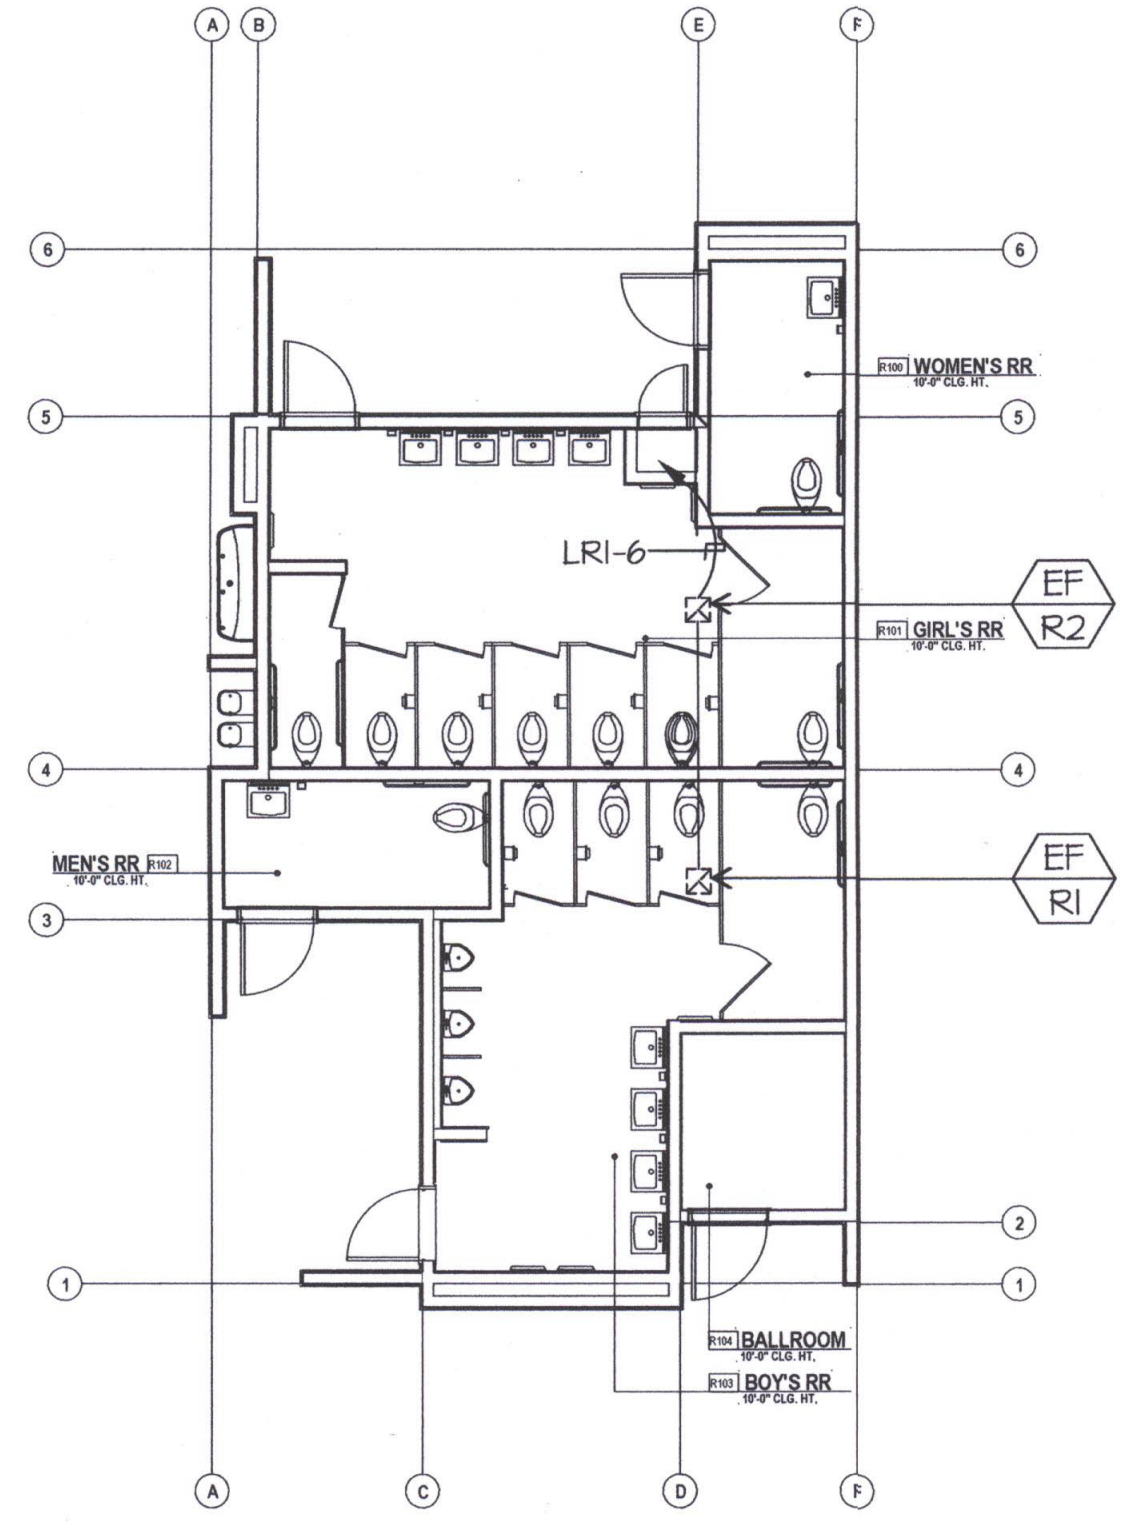

ELECTRICAL MECHANICAL PLAN BUILDING R  
SCALE: 1/8" = 1'-0"

Item #34: Refer to Electrical Drawing E-122J,K,Q,R  
A. Delete sheet E-122J,K,Q,R. Replace with revised sheet E-R122J,K,Q,R as attached.

TEL: 805-832-5258 FAX: 805-832-4291