

ORDIZ MELBY ARCHITECTS, INC.

5500 MING AVENUE SUITE 280
BAKERSFIELD, CALIFORNIA 93309
TELEPHONE (861) 832-5268
FACSIMILE (861) 832-4291



DANNY E. ORDIZ, AIA
ARCHITECT C-14,728
WILLIAM J. MELBY, AIA
ARCHITECT C-16,835
CONSULTANT


IDENTIFICATION STAMP
DIVISION OF STATE ARCHITECT
OFFICE OF REGULATION SERVICES
APPL. # 02-112827
FILE # 15-6
AC _____ FLS _____ SS _____
DATE _____
PTN # 63321-112

NEW ELEMENTARY SCHOOL
9801 HIGHLAND KNOLLS DR
BAKERSFIELD
CALIFORNIA
93306

NEW MIDDLE SCHOOL
4115 VINELAND ROAD
BAKERSFIELD
CALIFORNIA
93306

FOR:

BAKERSFIELD CITY SCHOOL DISTRICT
1300 BAKER STREET
BAKERSFIELD
CALIFORNIA
93305

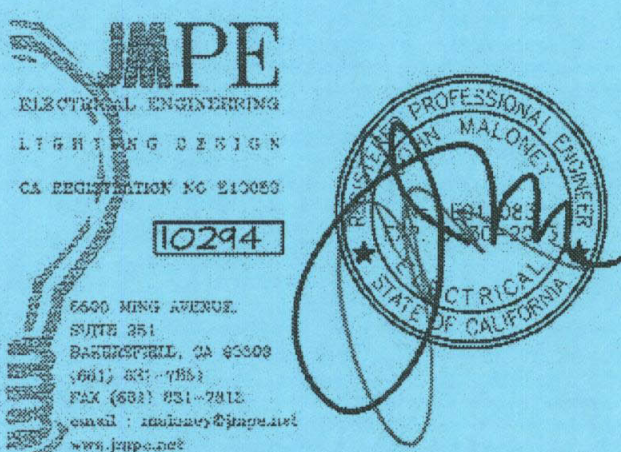

MARK DATE DESCRIPTION

MARK	DATE	DESCRIPTION
△	2-7-12	REVISION REPLACE SHEET
△		
△		
△		

JOB NUMBER: 20101244
CAD DRAWING FILE: #P11244-BLDG JK (RESTROOM MID)-REV.ph
DRAWN BY: AC
CHECKED BY: PH

CHECK AND VERIFY ALL DIMENSIONS BEFORE PROCEEDING WITH THE WORK. REPORT DISCREPANCIES TO THE ARCHITECT.
THE DRAWINGS, IDEAS, AND DESIGNS REPRESENTED ON THIS SHEET ARE THE PROPERTY OF THE ARCHITECT.


COPYRIGHT: ORDIZMELBY ARCHITECTS, INC. 2010
SHEET TITLE

ELECTRICAL MECHANICAL PLAN BUILDING J,K,Q,R


SHEET IDENTIFICATION NUMBER

E-R122J,K,Q,R


SHEET OF

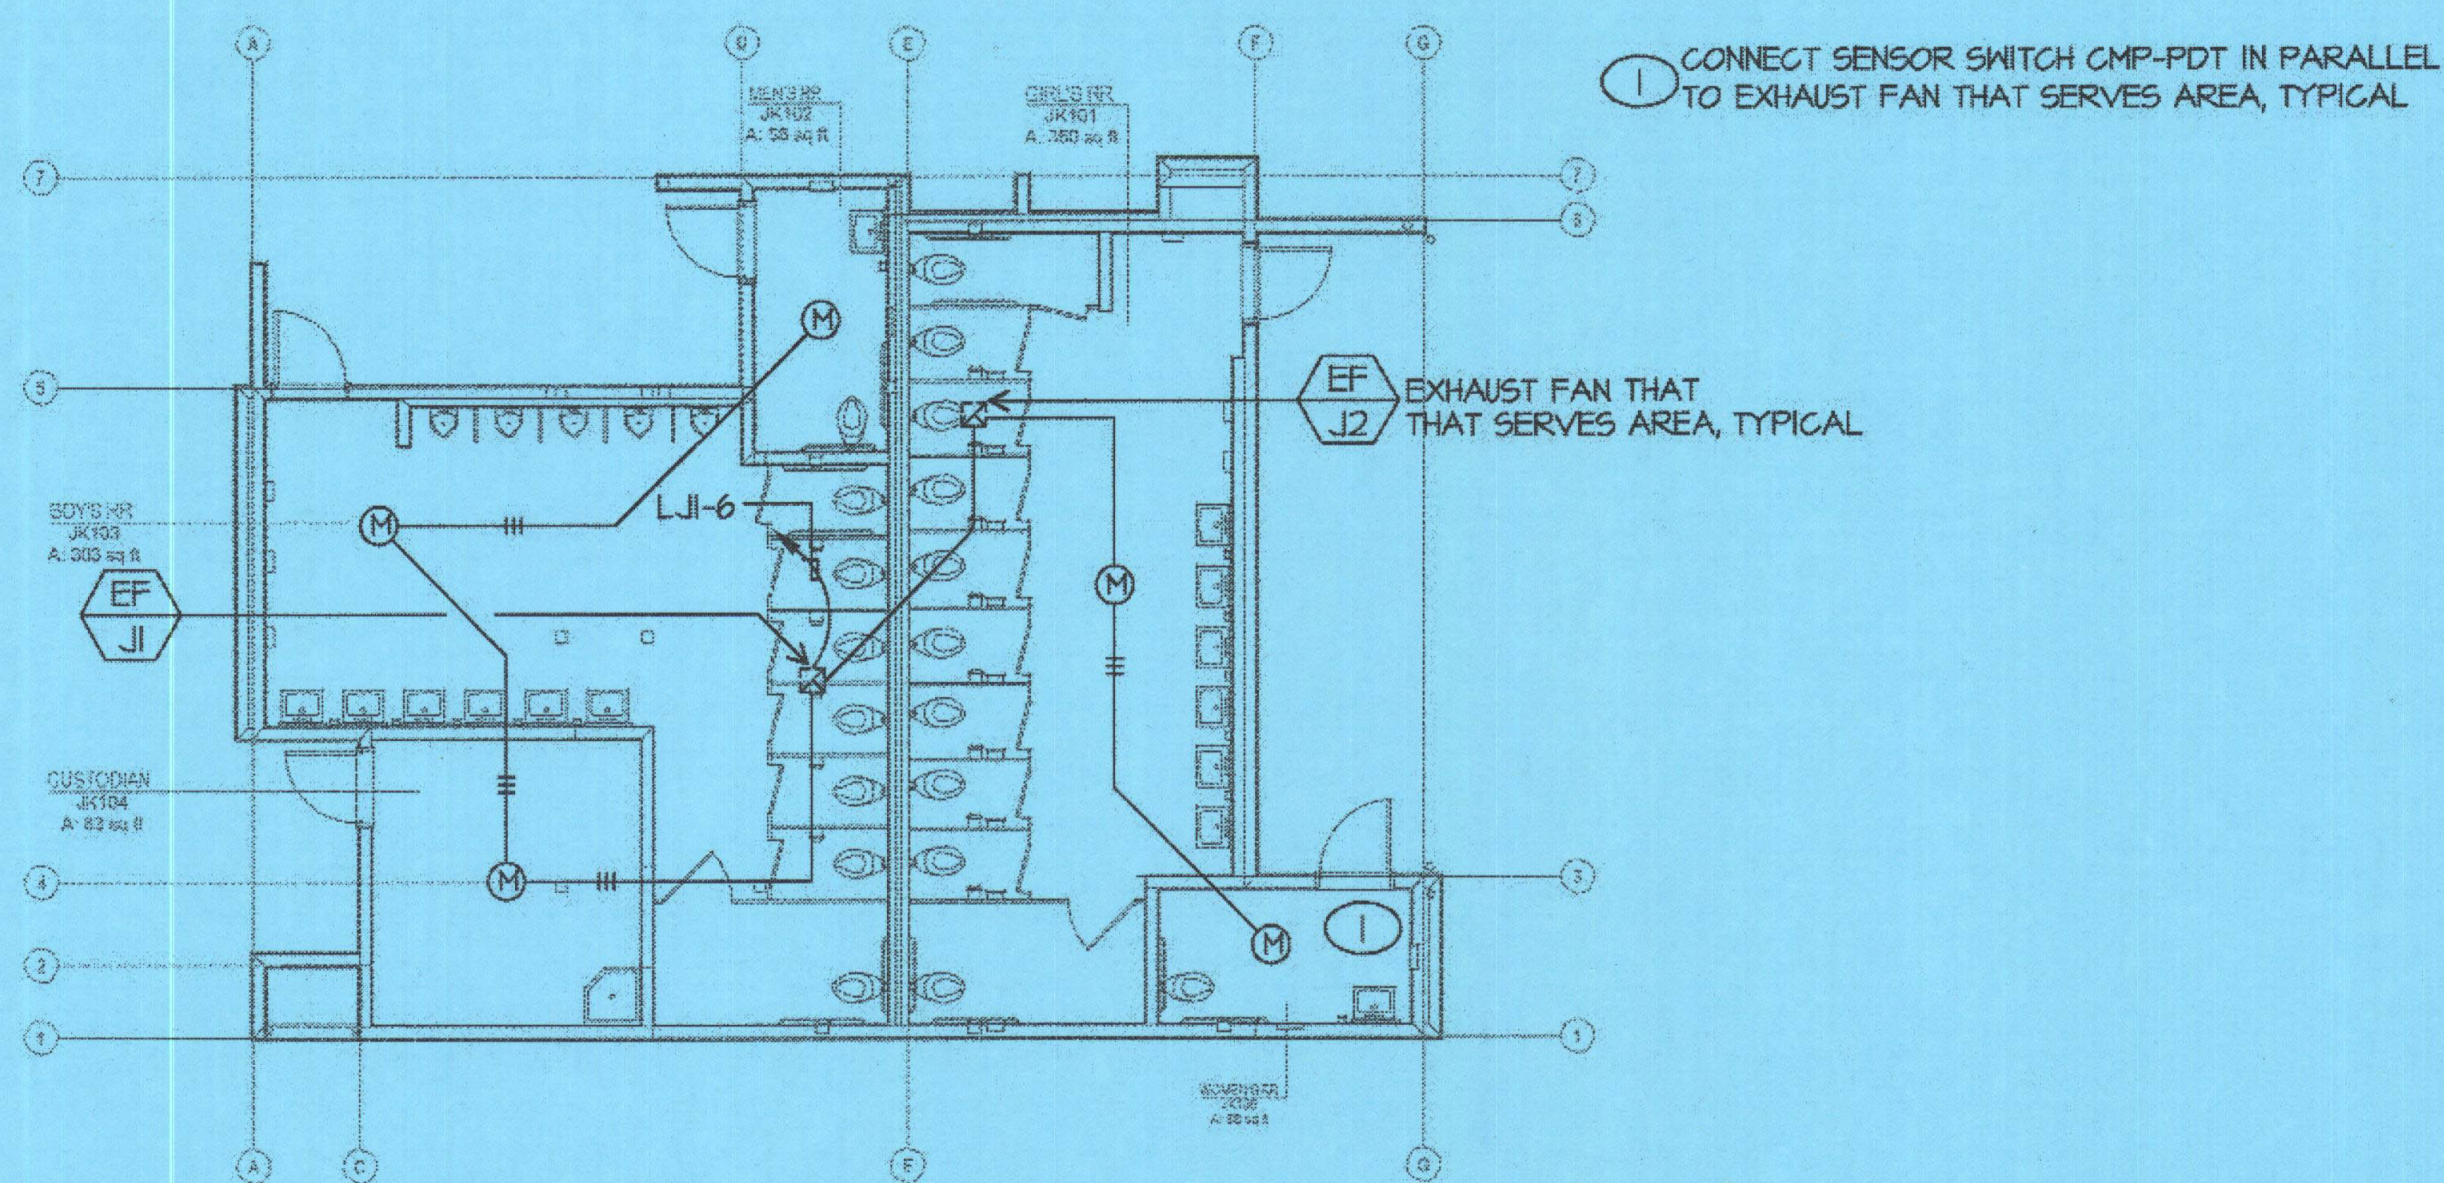


ELECTRICAL MECHANICAL PLAN BUILDING J
SCALE: 1/8" = 1'-0"

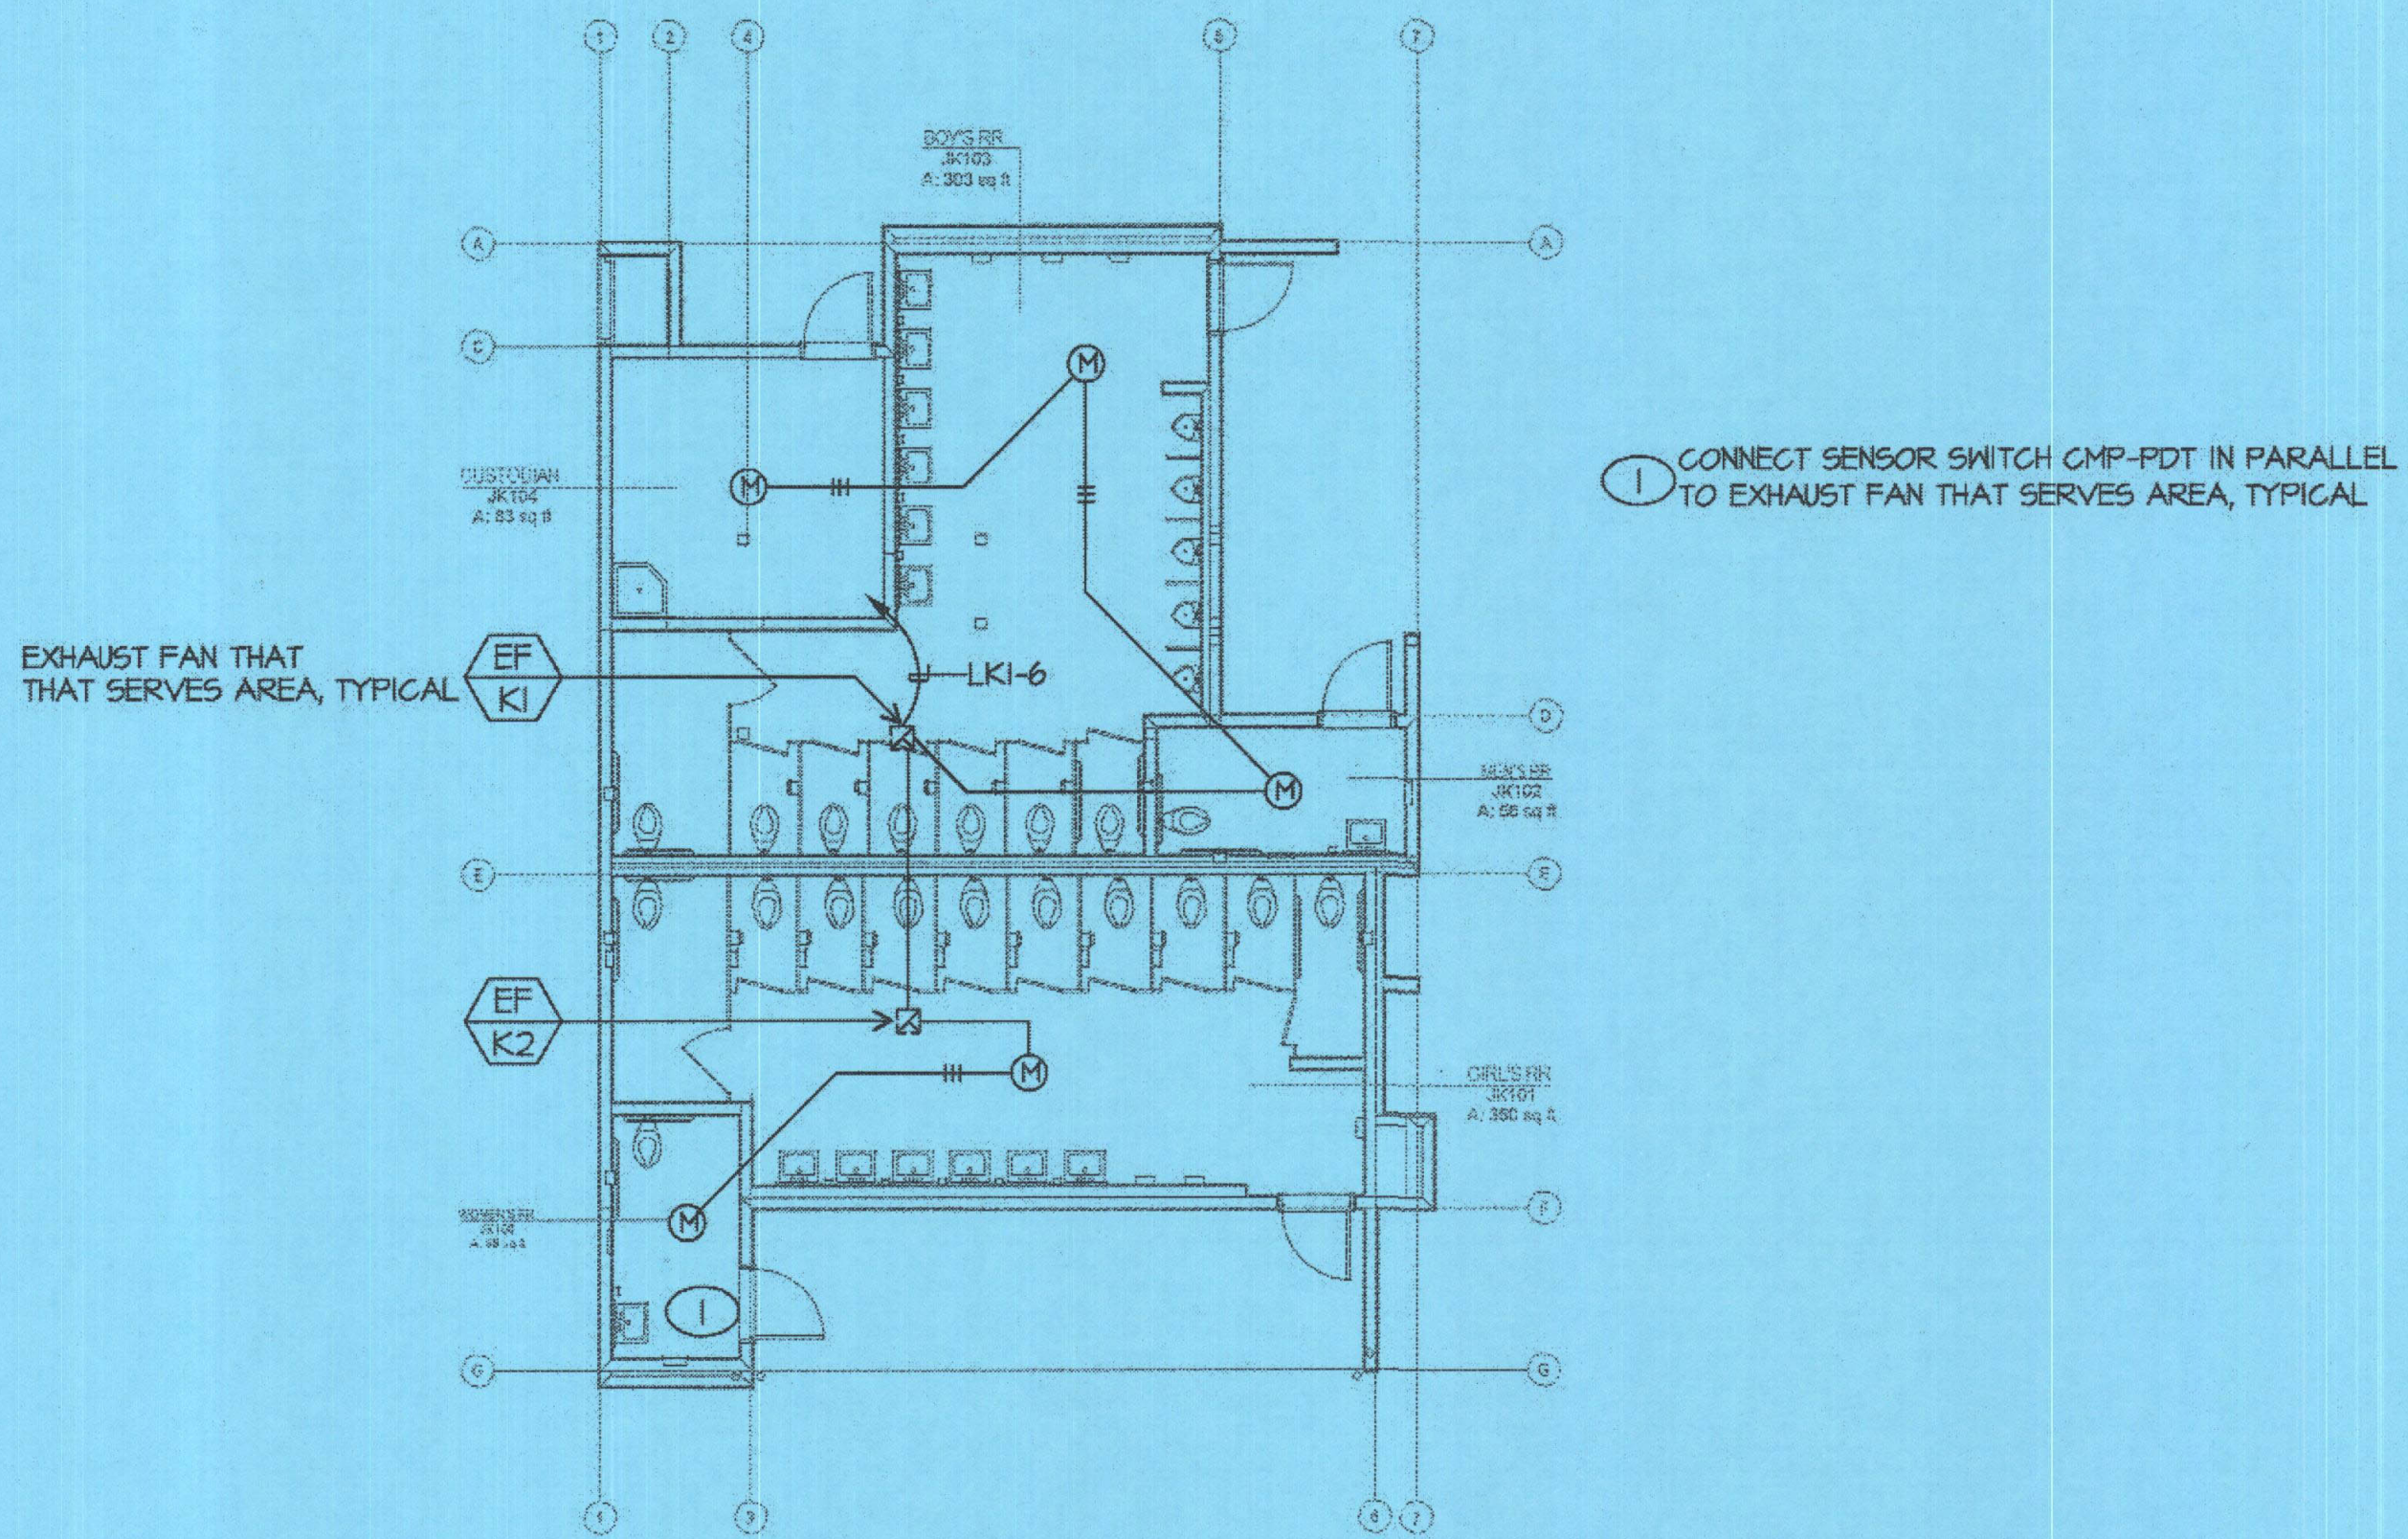

ELECTRICAL MECHANICAL PLAN BUILDING K
SCALE: 1/8" = 1'-0"

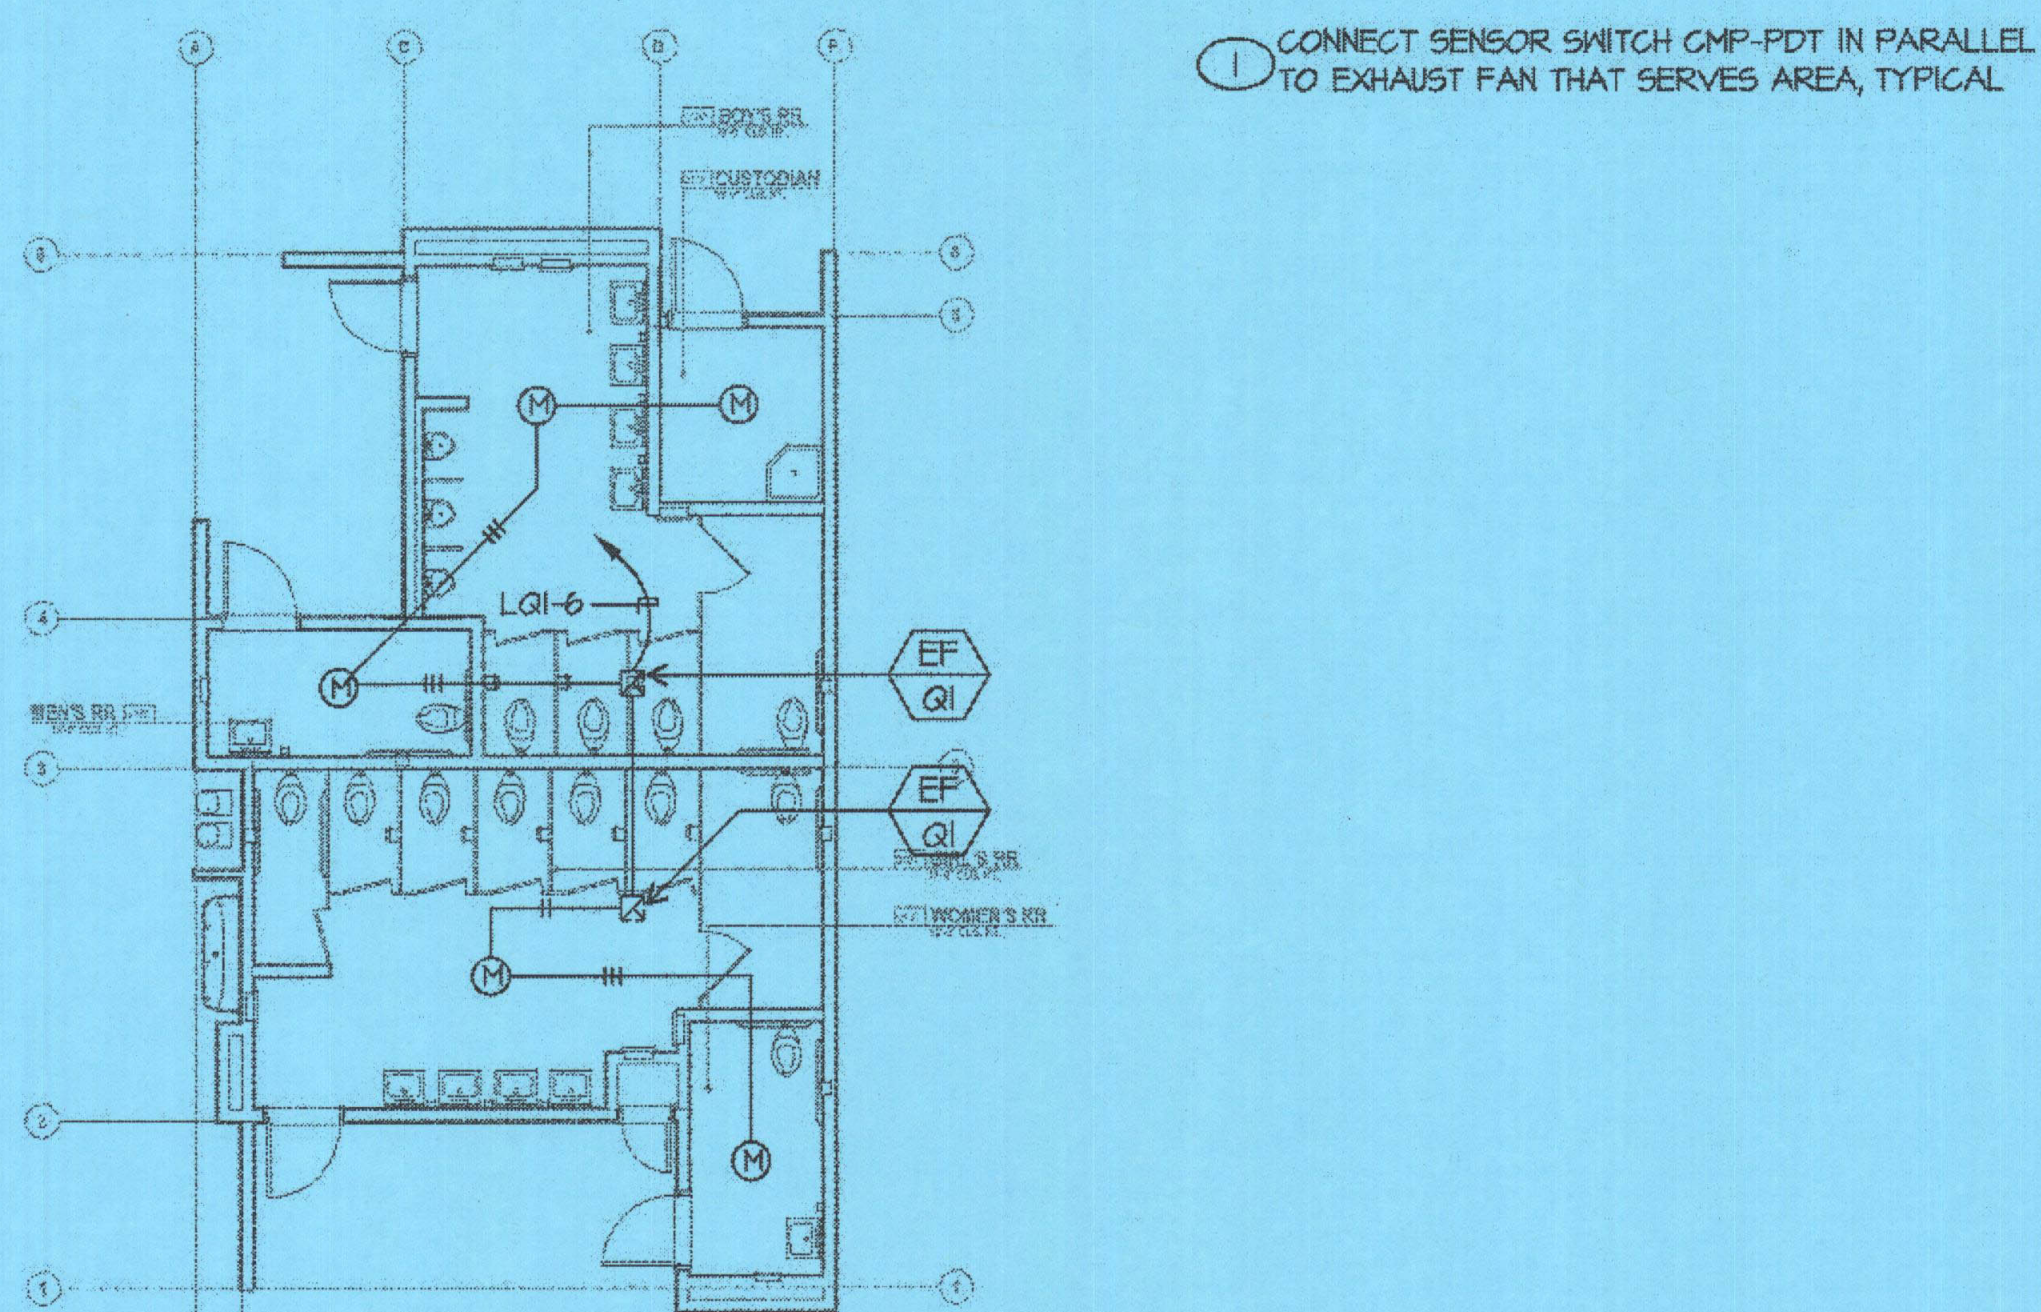

ELECTRICAL MECHANICAL PLAN BUILDING Q
SCALE: 1/8" = 1'-0"

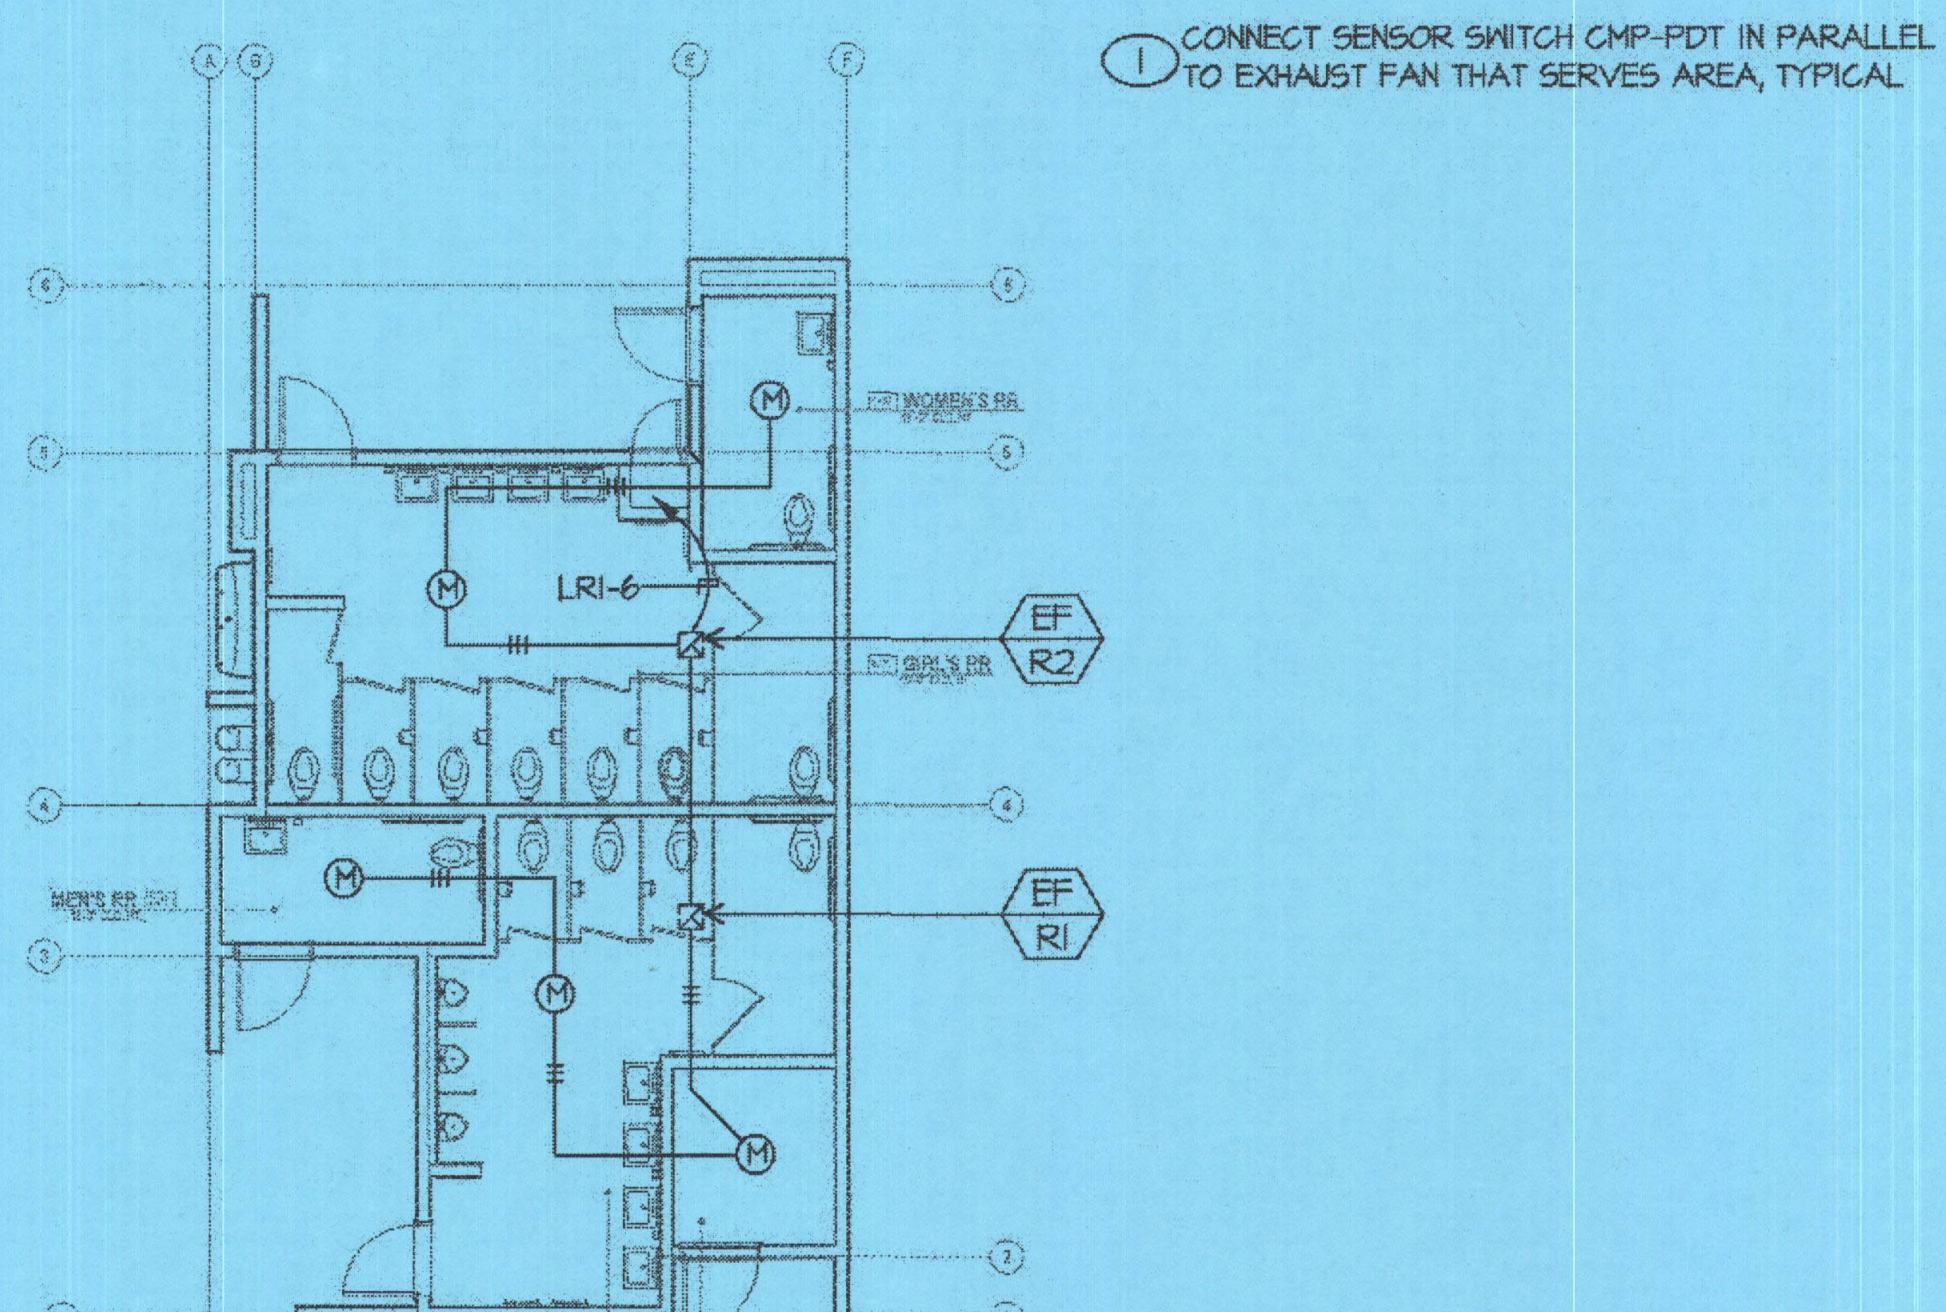

ELECTRICAL MECHANICAL PLAN BUILDING R
SCALE: 1/8" = 1'-0"