


NEW ELEMENTARY SCHOOL  
9801 HIGHLAND KNOLLS DR  
BAKERSFIELD  
CALIFORNIA  
93306

NEW MIDDLE SCHOOL  
4115 VINELAND ROAD  
BAKERSFIELD  
CALIFORNIA  
93306

FOR:  
BAKERSFIELD CITY SCHOOL  
DISTRICT  
1300 BAKER STREET  
BAKERSFIELD  
CALIFORNIA  
93305

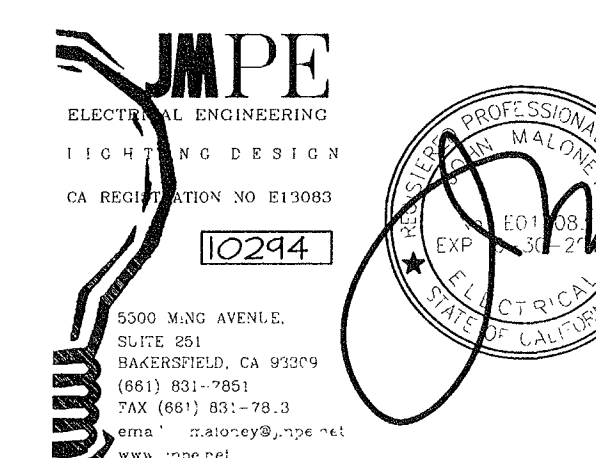


MARK	DATE	DESCRIPTION
△		
△		
△		
△		



JOB NUMBER:  
20101244  
CAD DRAWING FILE:  
DRAWN BY:  
AC  
CHECKED BY:  
PH  
CHECK AND VERIFY ALL DIMENSIONS BEFORE  
PROCEEDING WITH THE WORK.  
REPORT DISCREPANCIES TO THE ARCHITECT.  
THE DRAWINGS, IDEAS, AND DESIGNS  
REPRESENTED ON THIS SHEET ARE THE  
PROPERTY OF THE ARCHITECT.  
COPYRIGHT  
ORDIZ MELBY ARCHITECTS, INC 2010

SHEET TITLE  
**ELECTRICAL MECHANICAL  
PLAN BUILDING L**


SHEET IDENTIFICATION NUMBER  
**E-122L**  
SHEET OF

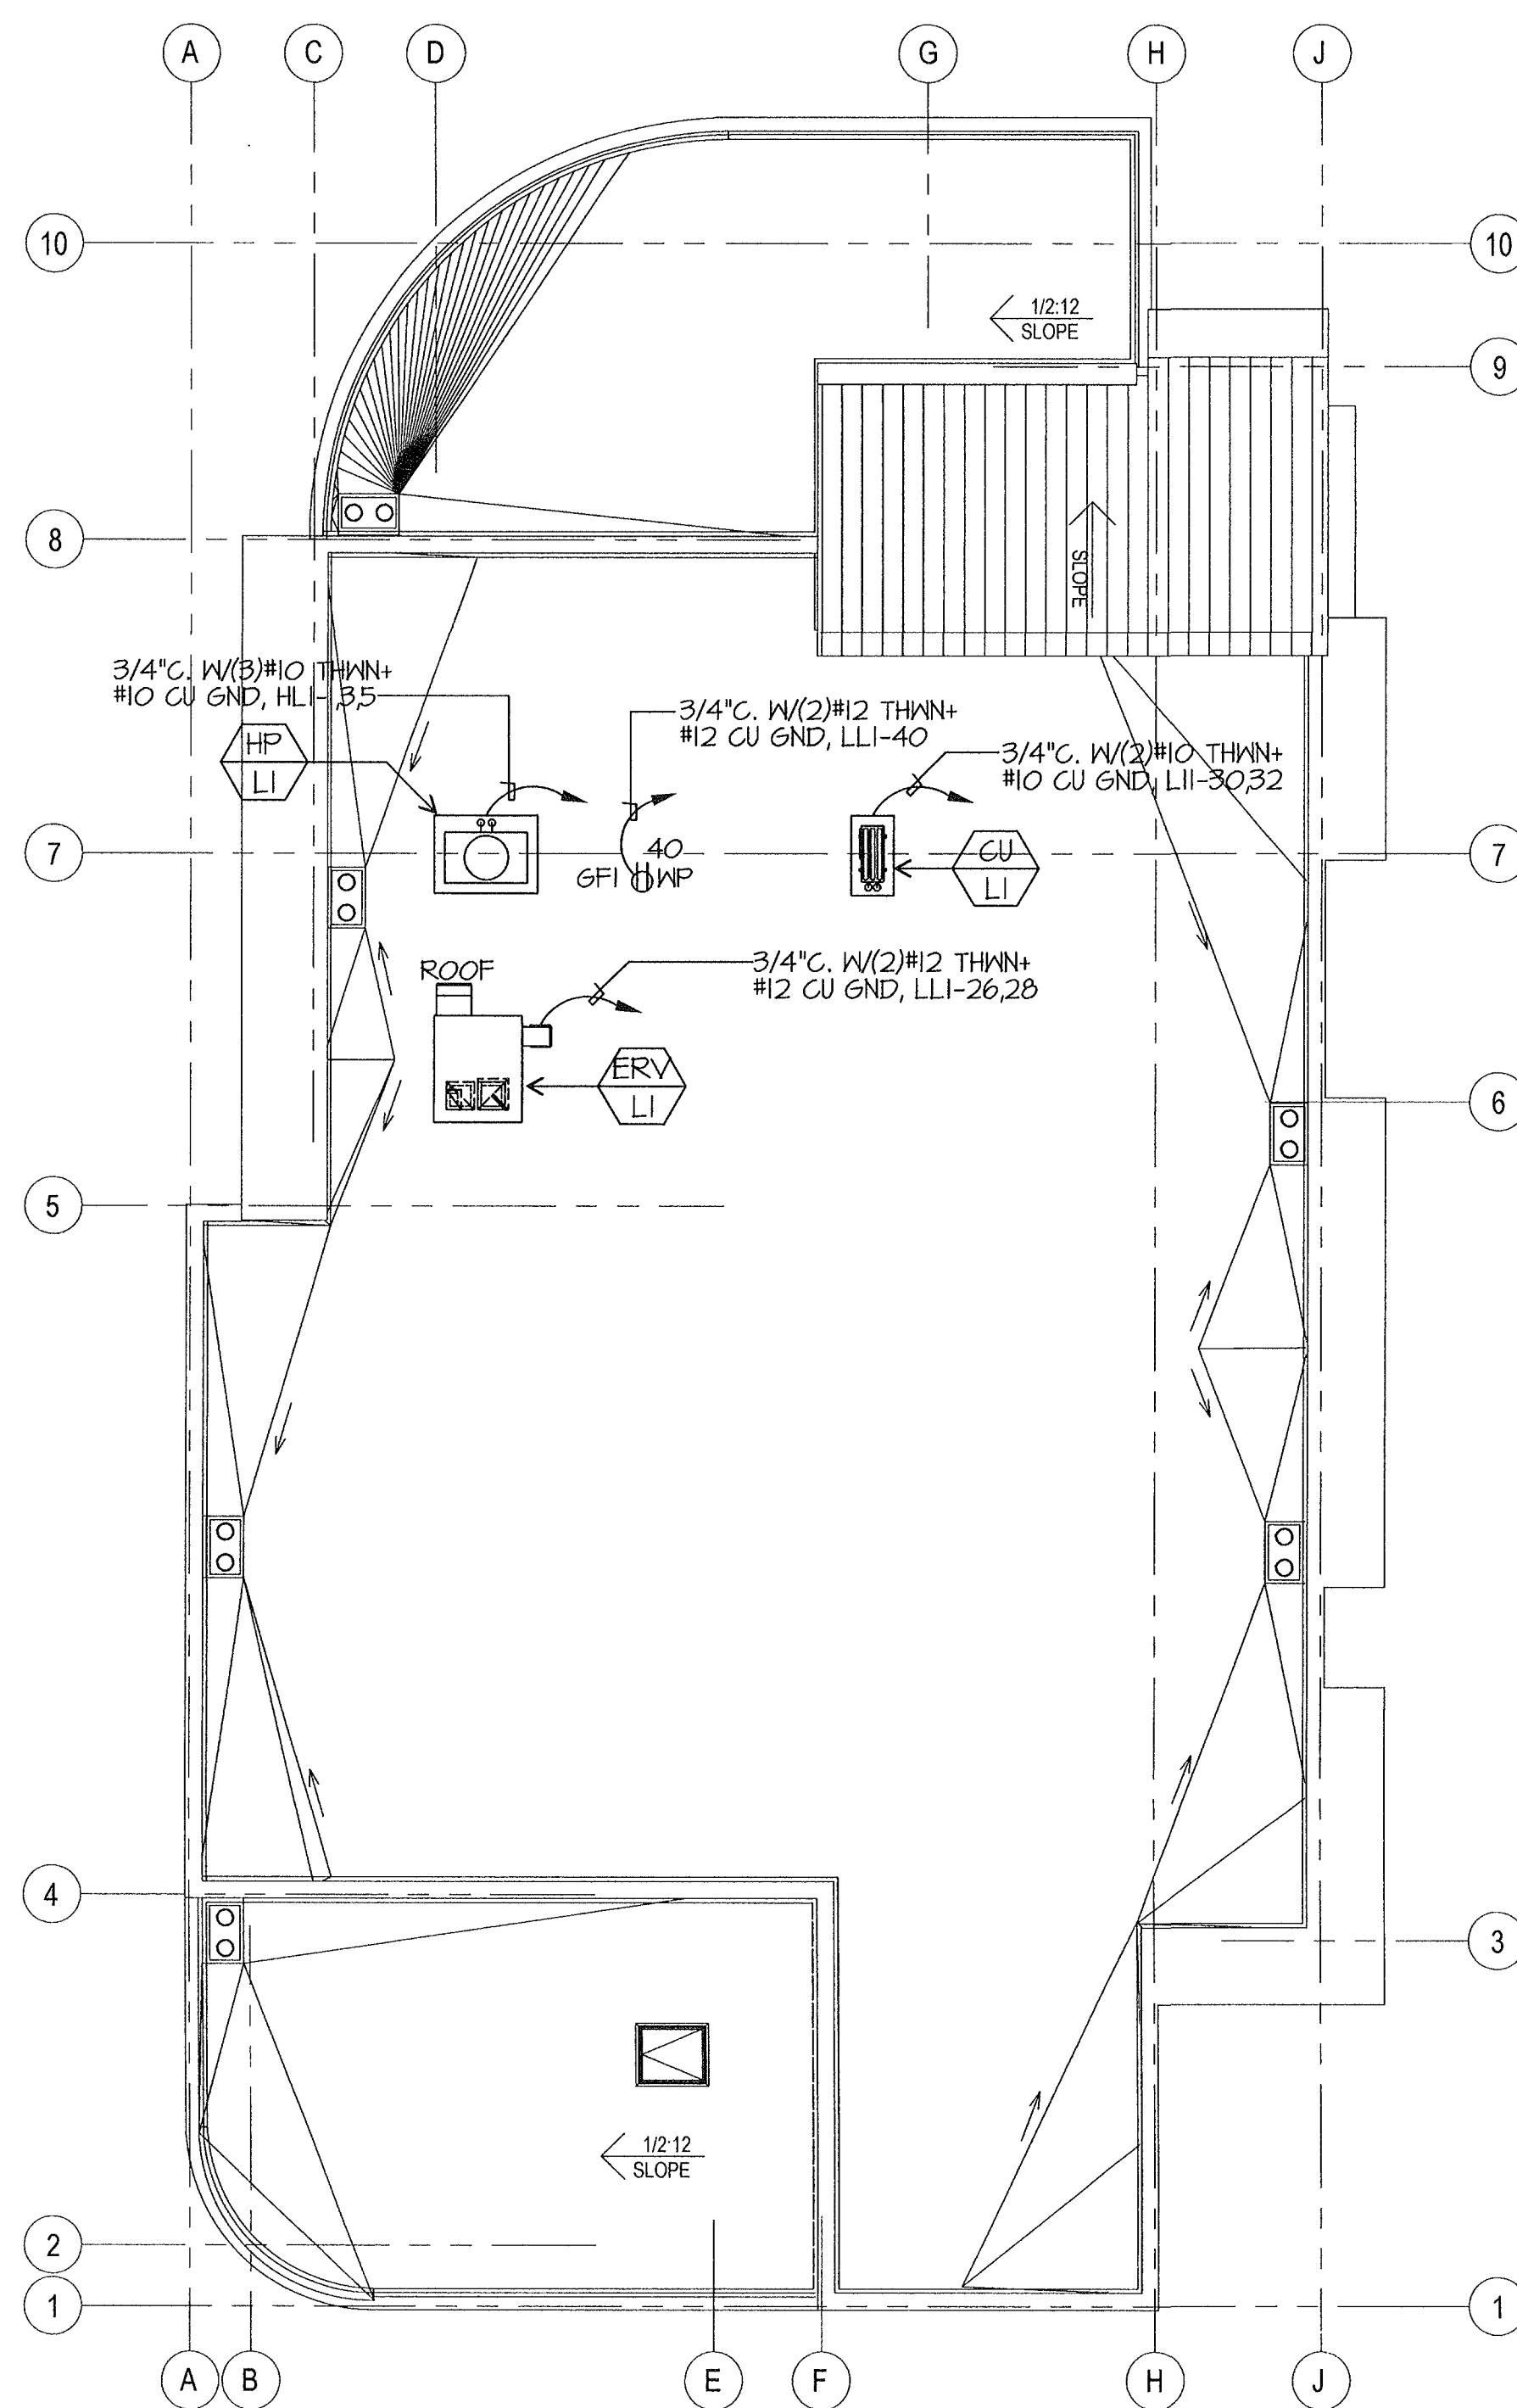

MECHANICAL ROOF PLAN BUILDING L

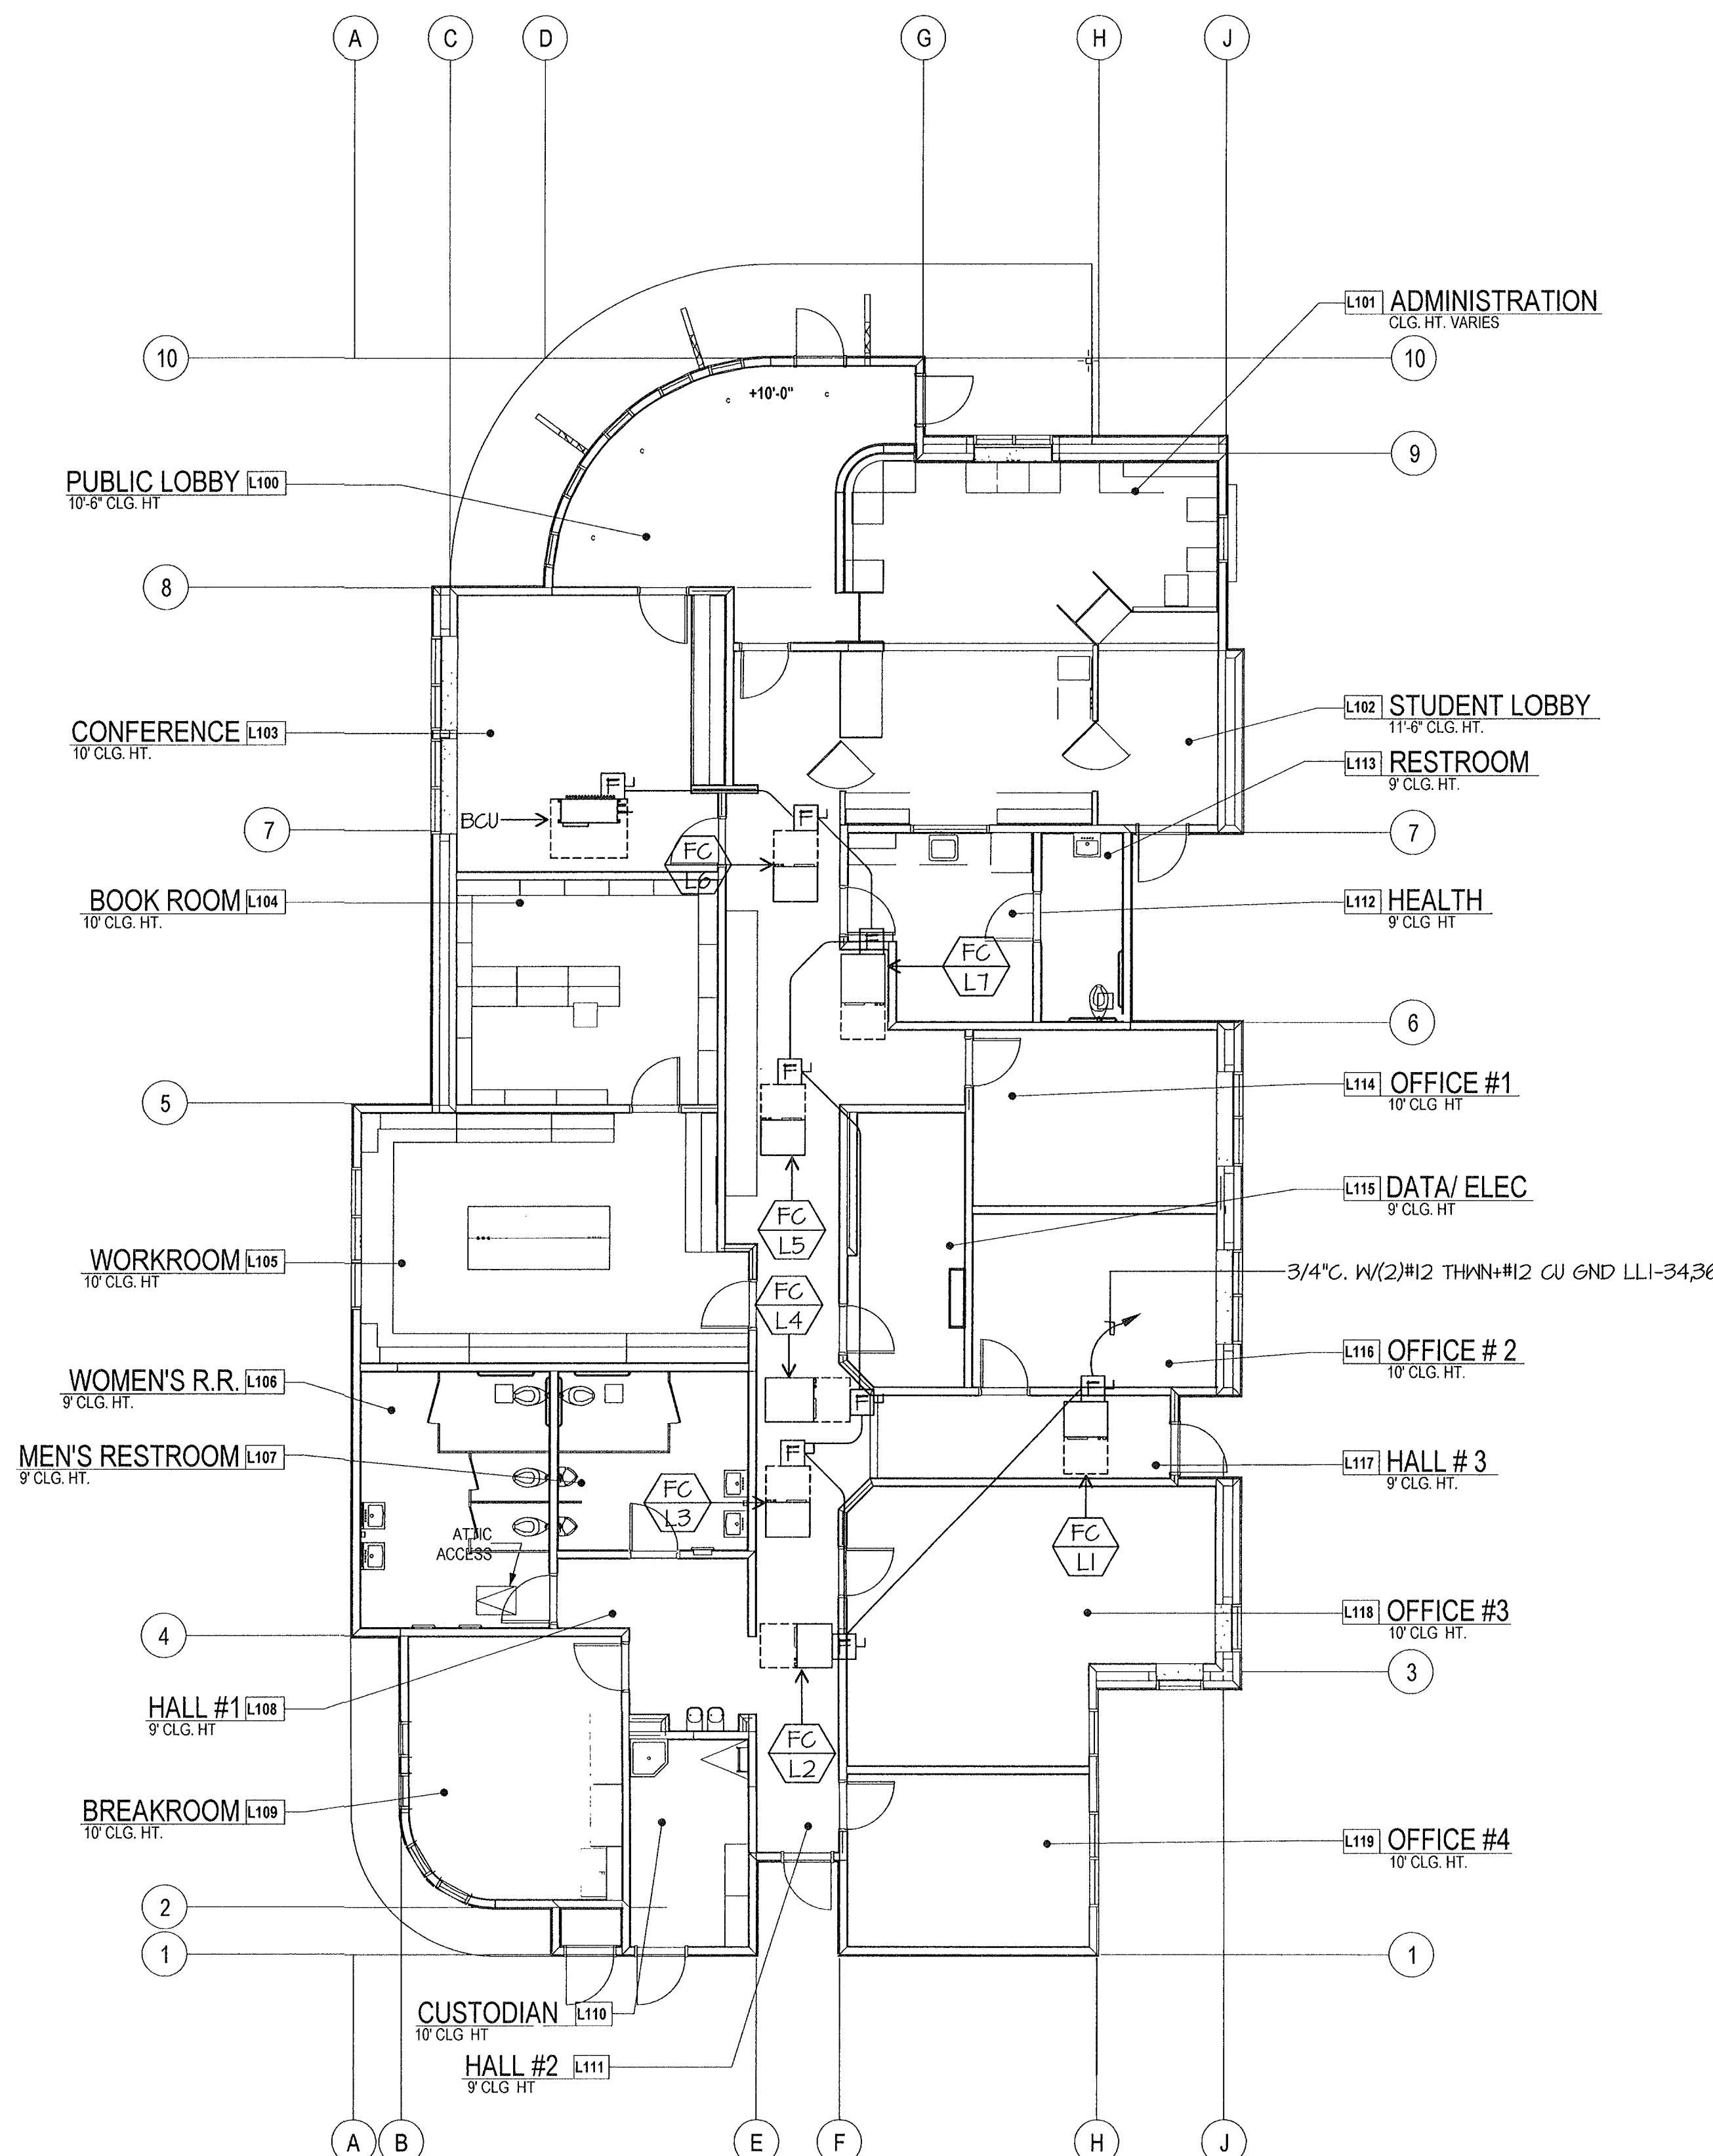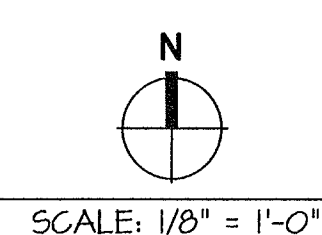

ELECTRICAL MECHANICAL PLAN BUILDING L

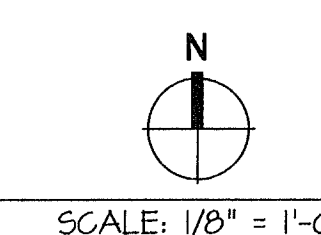

\*P:\EL0244\0244.DWG DATE: 12-20-11 AC