


3" SCHEDULE 40 P.V.C.
C.H. TO METER
LOCATION (SEE A/1.0)

ROUTE AROUND (B)
VAULTS, DRAINS, ETC.

1/4" S.O.V. IN YD. BOX
FOR FILL PORTABLES
(SEE C/MP-1.0)

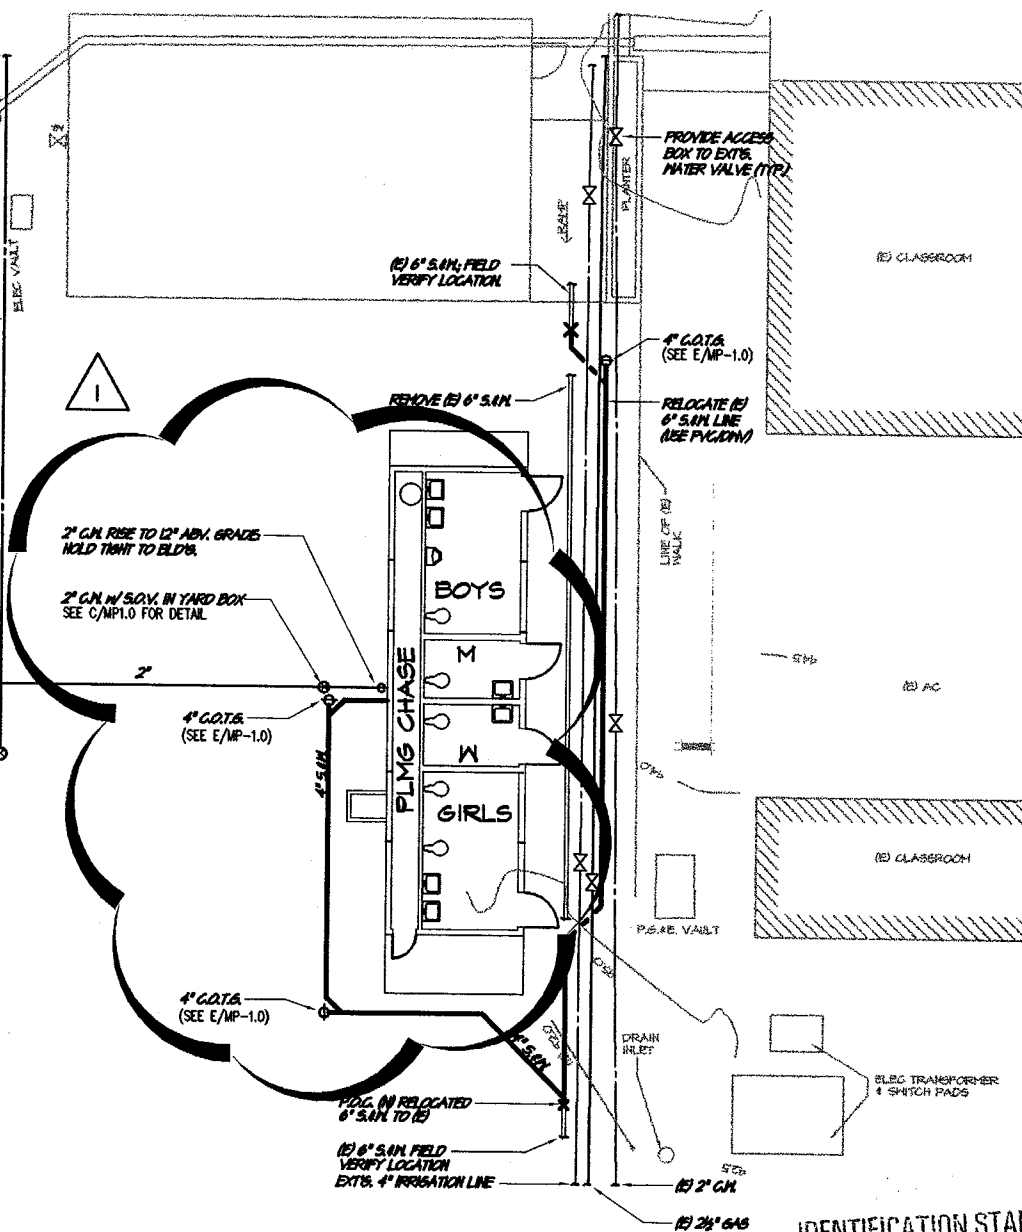


PARTIAL PLUMBING SITE PLAN

1/16"=1'-0"

IDENTIFICATION STAMP
DIV. OF THE STATE ARCHITECT

APP03-104224

AC DD FLS EV SS Mc
DATE JAN 27 2005

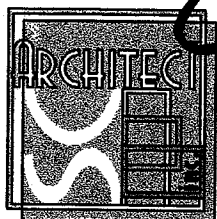

BOI L STR-66T
BAKERSFIELD, CA 93301
PH: (661) 327-1632
FAX: (661) 327-2339



CHANGE ORDER # 03

RESTROOM BUILDING
RELOCATABLE CLASSROOMS

BAKERSFIELD CITY SCHOOL DISTRICT
BAKERSFIELD, KERN COUNTY, CALIFORNIA

JOB NO: 976.3	DATE: 02/10/04
APPL#: 03-104224	FILE#: 15-6
DWG NO: 10	