
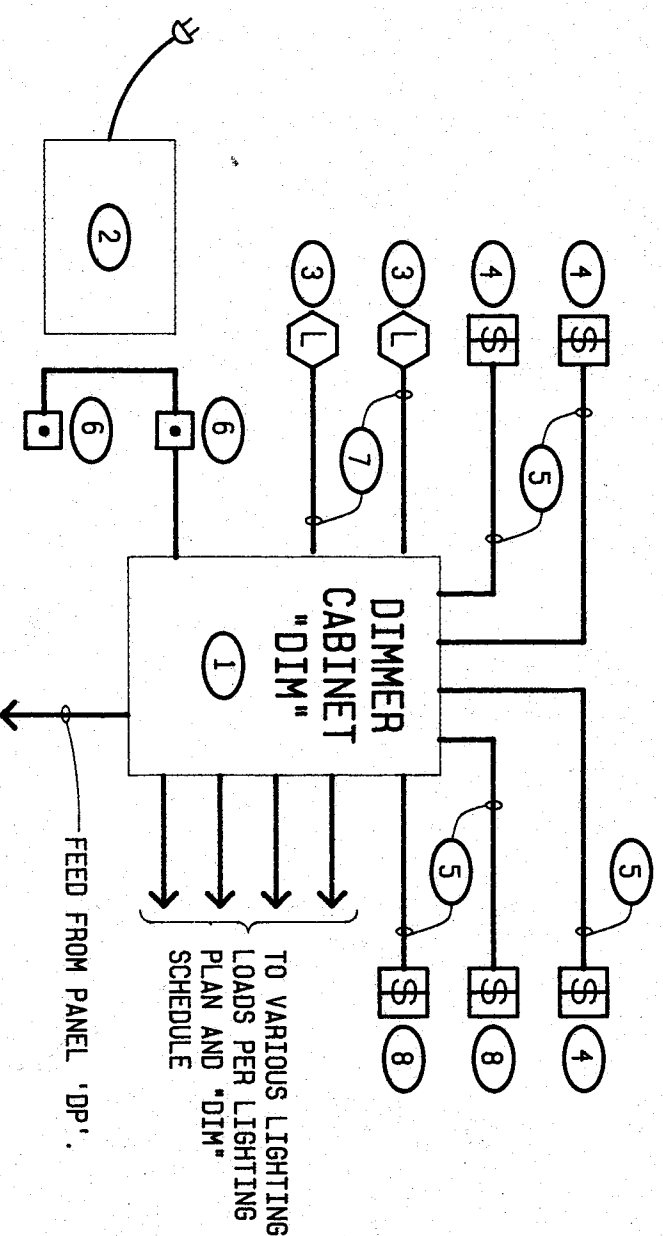


[illegible]

DINNER CABINET "DIM" SCHEDULE				
P.L.N ACT NO.	DESTINATION	MIDDLE TYPE	ASSIGNED LOUIS WANTS / PRICE X1 / \$2	
1	STAGE TRACK LIGHTS	P.L-DU-1	450	
2	STAGE TRACK LIGHTS	450		
3	STAGE TRACK LIGHTS	450		
4	STAGE TRACK LIGHTS	450		
5	STAGE TRACK LIGHTS	P.L-DU-1	450	
6	STAGE TRACK LIGHTS	450		
7	STAGE TRACK LIGHTS	450		
8	STAGE TRACK LIGHTS	450		
9	DOWNLIGHTS ABOVE STAGE (FRONT ROW)	P.L-DU-1		
10	DOWNLIGHTS ABOVE STAGE (SECOND ROW)		1500	
11	DOWNLIGHTS ABOVE STAGE (LAST 3 ROWS)		1500	
12	DOWNLIGHTS ABOVE STAGE (LAST 3 ROWS)		1500	
13	"HOUSE" DOWNLIGHTS (OUTSIDE ROW)	P.L-DU-1	1300	
14	"HOUSE" DOWNLIGHTS (CENTER ROW)	1050		
15	"HOUSE" DOWNLIGHTS (OUTSIDE ROW)	1300		
16	FLOOR POCKETS		1800	
17	FLOOR POCKETS		500	
18		P.L-DU-1 (NON-DIM)		
19	FLUORESCENT LIGHTS ABOVE STAGE		1155	
20	FLUORESCENT LIGHTS ABOVE STAGE		1155	
21				
22				
23				
24				

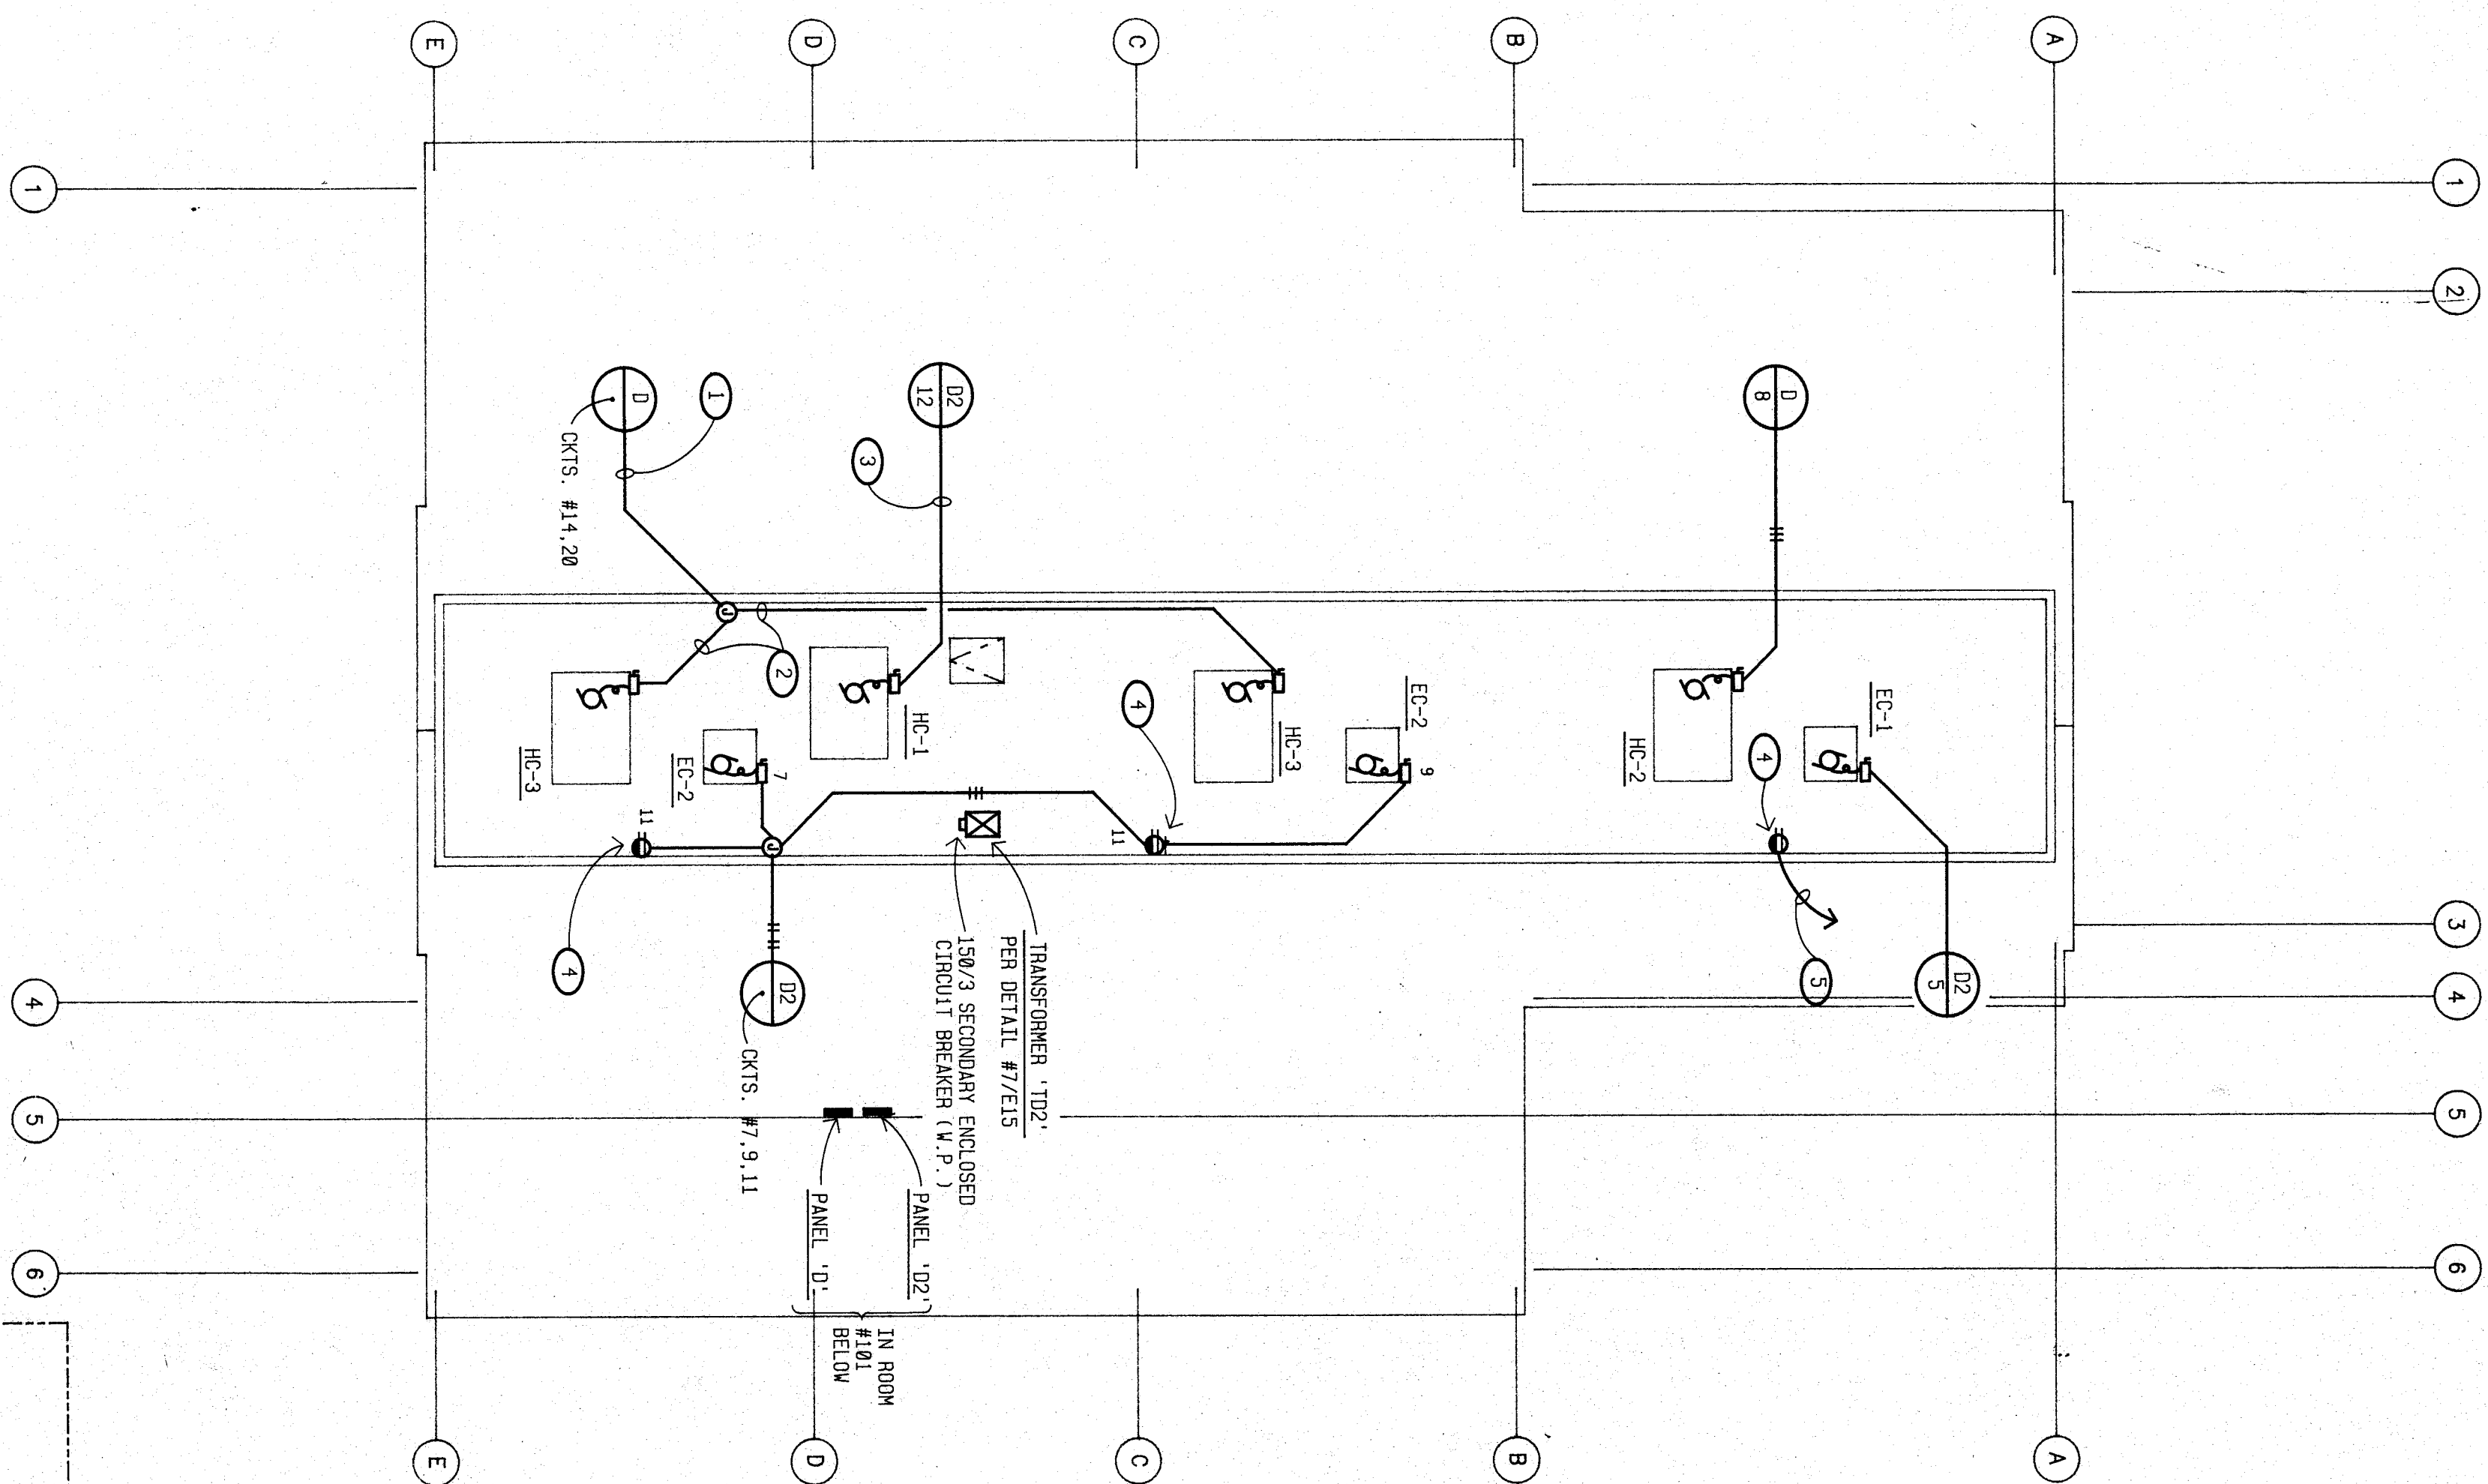


KINDERGARTEN CLASSROOM ROOF ELECTRICAL PLAN

1/8" = 1'-0"

NOTES (THIS SHEET ONLY):

- 1 3/4" C - 6 #10 + 1 #10 END (THIN-CU)
- 2 3/4" C - 3 #10 + 1 #10 END (THIN-CU)
- 3 3/4" C - 2 #10 + 1 #10 END (THIN-CU)
- 4 WETTERPORE 6 F.C.I., DUPLEX RECEPTACLE ON ROOF. SOLDER JOINT OF MECHANICAL WELL & 2"4" ABOVE ROOF
- 5 CONNECT TO 120V PLUG CIRCUIT BELOW

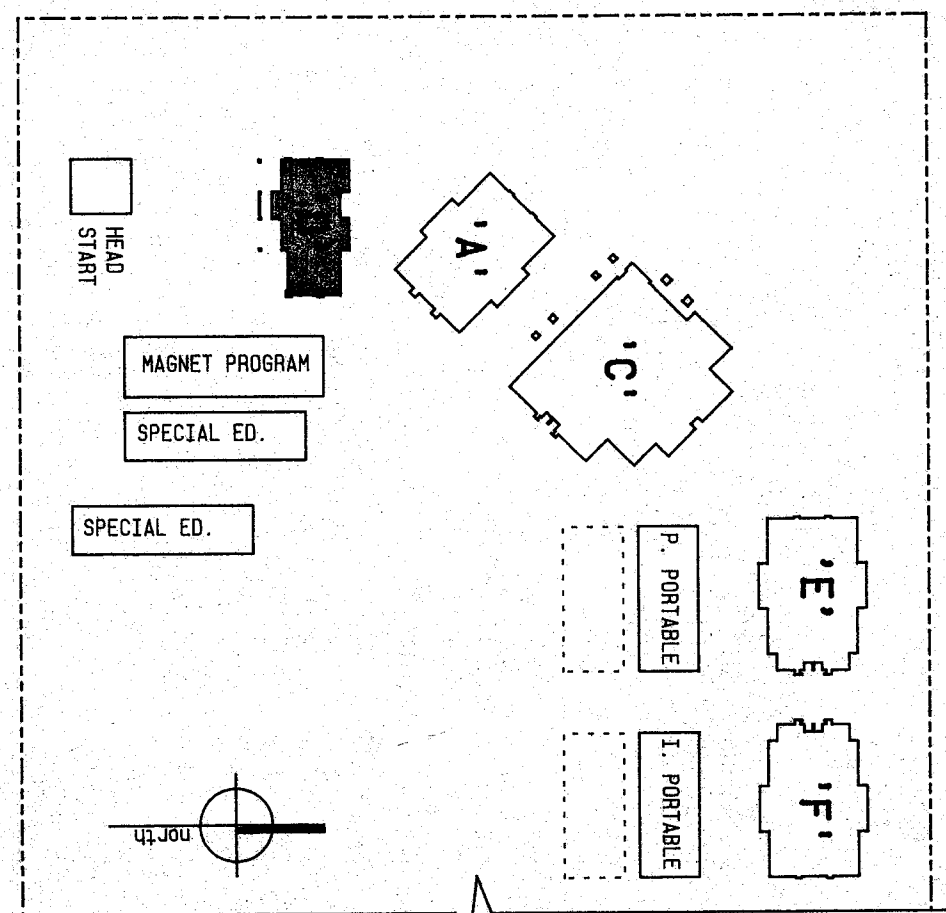


KEY PLAN

APPROVALS

RECEIVED
FEB 10 1997
OFFICE OF THE STATE ARCHITECT
ACCESS COMPLIANCE SECTION


APPROVAL: _____
 59132 MAR 11 1963
 RECEIVED: _____
 MAR 8 1963

TELETYPE UNIT, C. A. 111, 112, 113, 927,

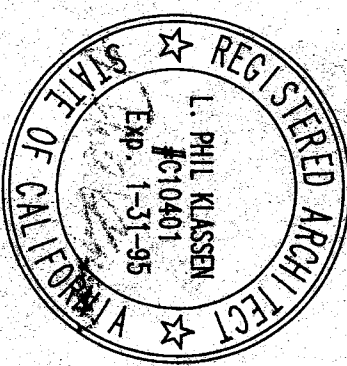[illegible]

Architecture
Planning
Construction
2021 Westwind Drive
Bakersfield, CA 93301
(805) 327-0875
(805) 327-5933 Fax


**KLASSEN
CORPORATION**

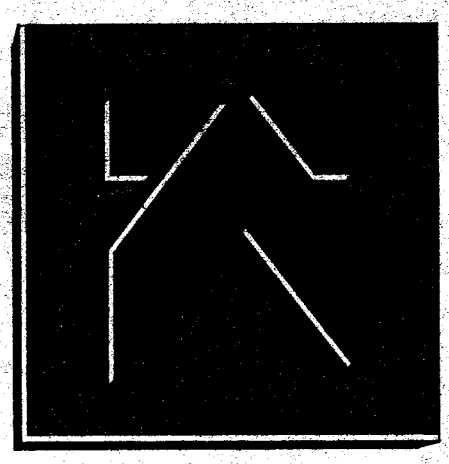

BAKERSFIELD CITY SCHOOL DISTRICT
MESA MARIN ELEMENTARY SCHOOL

BAKERSFIELD, CA.

Sheet title:
KINDERGARTEN CLASSROOM ROOF ELECTRICAL
PLAN, BUILDING 'D' & DIMMING SYSTEM
DIAGRAM.

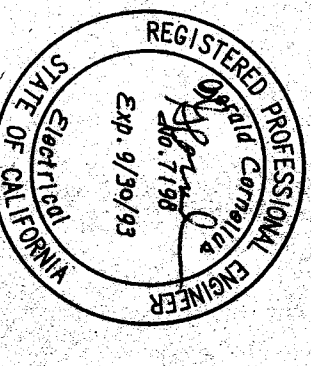

Date:	
Issued for:	

Sheet: _____
E. 13
Sheet of: 17
Date: _____