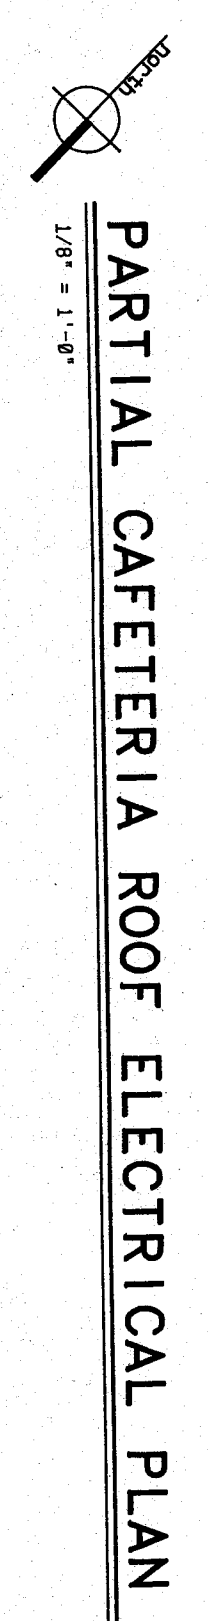
 

$$10^{-1} T = .8/T$$

$$\underline{\underline{.03-.1 = .07}}$$

- NOTES (THIS SHEET ONLY):



APPROVALS

OFFICE OF THE STATE ARCHITECT

ACCESS COMPLIANCE SECTION

MAR 19 8 00 AM '72

any deviation of this plan does not constitute preparation for omission or deviation from the plan.

Applicable regulations:
Reviewed by _____

INVENTION OF A NEW METHOD

Department of General Services
Office of the State Architect

PORTION

APR 11 1963

Structural Safety Section
Appl. # A59162

Rechecked By 19A16A

**KLASSEN
CORPORATION**

Architecture
Planning
Construction

2021 Westwind Drive
Bakersfield, CA 93335
(805) 327-0875
(805) 327-5933 Fax

BAKERSFIELD CITY SCHOOL DISTRICT
MESA MARIN ELEMENTARY SCHOOL

BAKERSFIELD, CA.

Sheet title:
CAFETERIA POWER PLAN, BUILDING 'C'

Date:	Issued for:
-------	-------------

Date:		Revisions:
10-94	A	R8 BUILTS
Drawn by:	R.T.S.	

Job no.: 1223
Dgn. file:
Sheet:
E.3
Sheet of: 17
Date: