


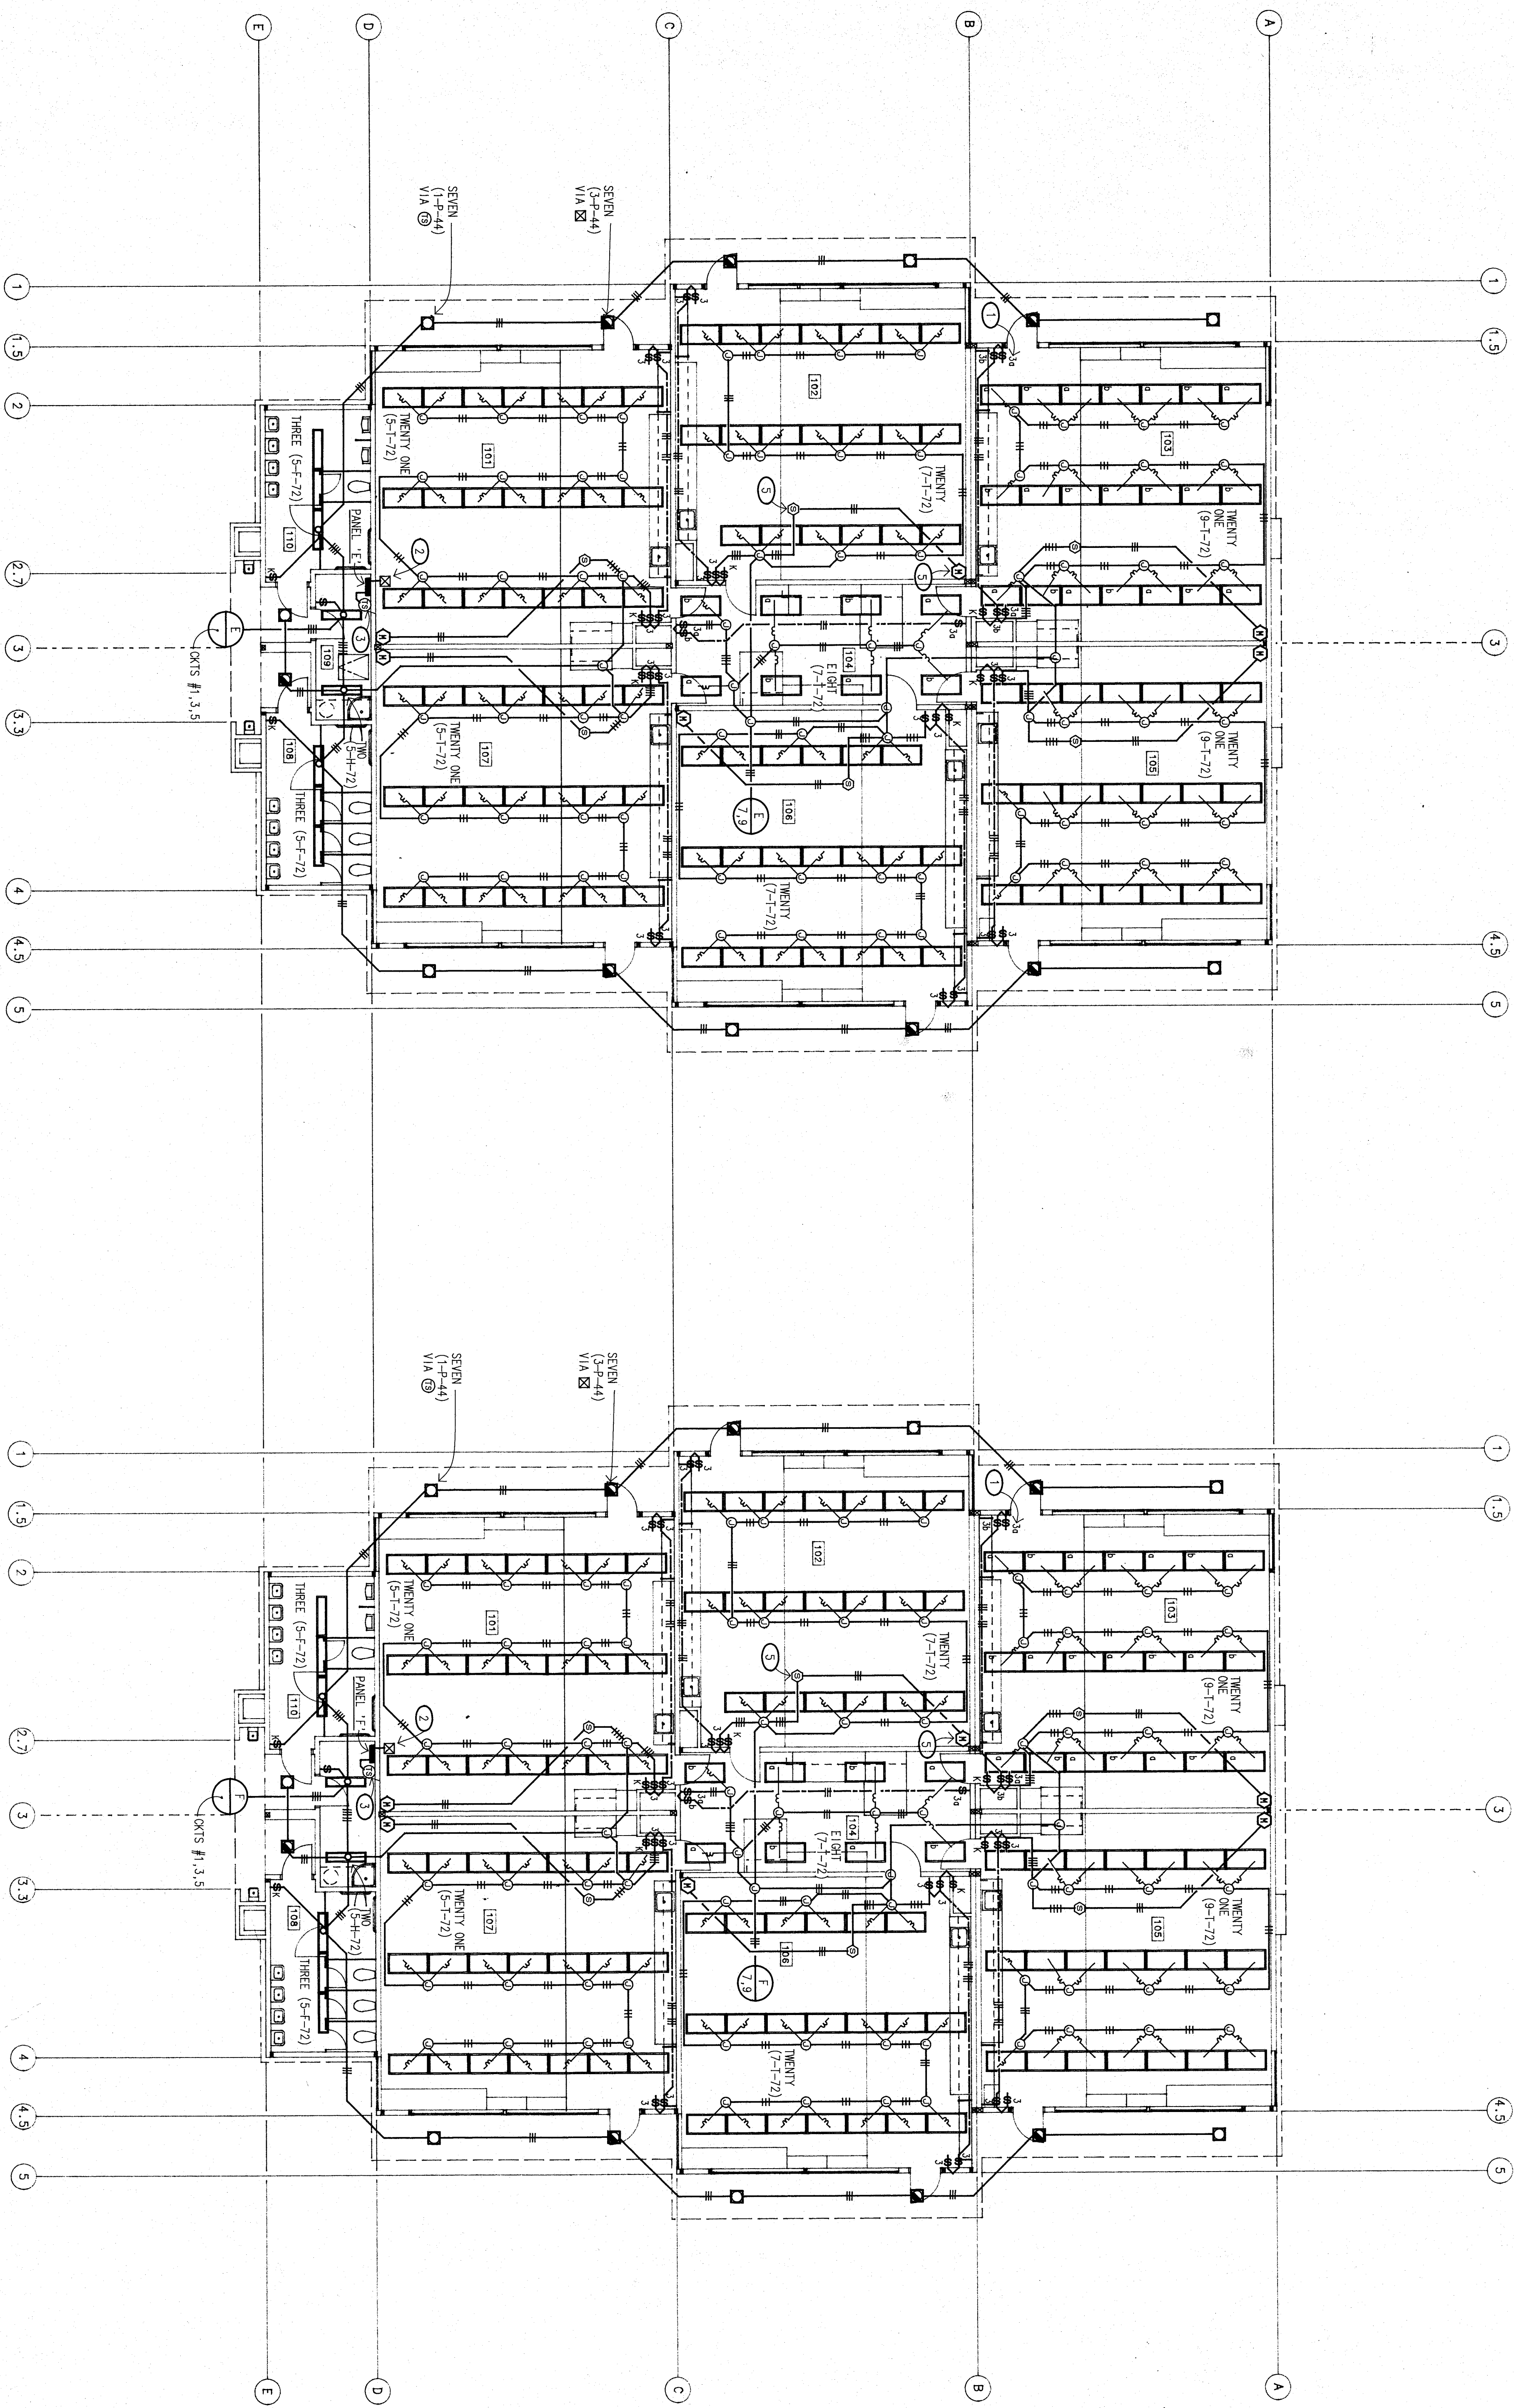

1. TYPICAL SWITCHING ARRANGEMENT OF CLASSROOM LIGHTS
2. PROVIDE PHOTO CONTROL ON ROOF TO CONTROL LIGHTS ON CIRCUIT #1/3 (E/F/5) $1/2/5 = 3 \times 2 = \text{PHOTO CONTROL}$
3. PROVIDE THERMOSTAT AND WIRING (PER SPEC.) TO CONTROL LIGHTS ON CIRCUIT #1/1 (E/F/1)
4. LOWER CASE LETTER DENOTES CONTROLLING SWITCH, TYPICAL.
REFER TO OCCUPANCY SENSOR WIRING DIAGRAM, DETAIL #1/2 FOR WIRING OF OCCUPANCY SENSOR SYSTEM.

[illegible]

BAKERSFIELD CITY SCHOOL DISTRICT MESA MARIN ELEMENTARY SCHOOL	
Sheet title: INTERMEDIATE AND INTERMEDIATE/PRIMARY CLASSROOM LIGHTING PLANS, BUILDINGS 'E & F'	BAKERSFIELD, CA.

KLASSEN CORPORATION
Architecture
Planning
Construction
2021 Westwind Drive
Westminster, CA 93601
(805) 327-0875
(805) 327-5933 Fax