



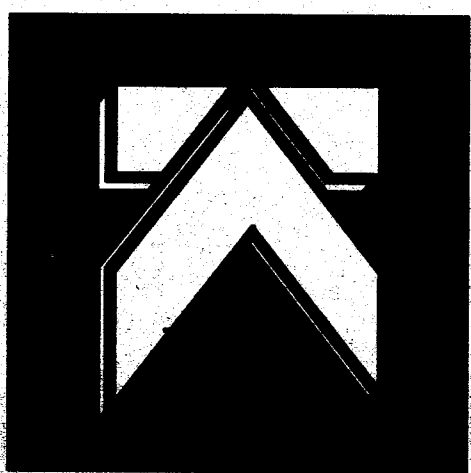

KLASSEN CORPORATION
ARCHITECTURE
PLANNING
DESIGN
CONSTRUCTION
2021 Westfield Drive
Bakersfield, CA 93301
(805) 327-0875

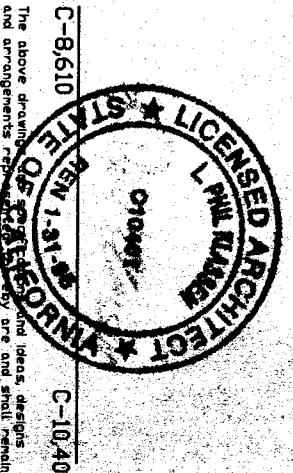


THIS DOCUMENT IS THE PROPERTY OF KLASSEN CORPORATION. IT IS TO BE USED ONLY FOR THE PROJECT AND SITE SPECIFICALLY IDENTIFIED HEREON. IT IS NOT TO BE REPRODUCED, COPIED, OR TRANSMITTED IN ANY FORM OR BY ANY MEANS, ELECTRONIC OR MECHANICAL, INCLUDING PHOTOCOPYING, RECORDING, OR BY ANY INFORMATION STORAGE AND RETRIEVAL SYSTEM, WITHOUT THE WRITTEN PERMISSION OF KLASSEN CORPORATION.

BAKERSFIELD CITY SCHOOL DISTRICT
MESA MARIN ELEMENTARY SCHOOL
BAKERSFIELD, CALIFORNIA


Sheet title:
CLASSROOM BUILDINGS 'E' & 'F'
PLUMBING PLANS

DATE: Issued For:
REVISIONS:
BY: JLB
DATE: 11/11/14
CHECKED BY: JLB
DATE: 11/11/14
DRAWN BY: JLB
DATE: 11/11/14
JOB NO: 1403
SHEET: P-4
DATE: 11/11/14


DATE: Issued For:
REVISIONS:
BY: JLB
DATE: 11/11/14
CHECKED BY: JLB
DATE: 11/11/14
DRAWN BY: JLB
DATE: 11/11/14
JOB NO: 1403
SHEET: P-4
DATE: 11/11/14

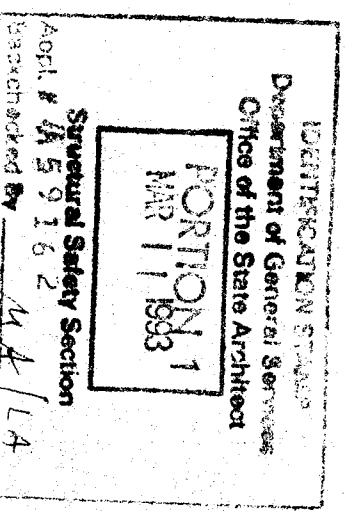

OFFICE OF THE STATE ARCHITECT
ADDRESS COMPLIANCE SECTION
1515 L Street, Suite 100
Sacramento, CA 95811-53
Reviewed By: JLB

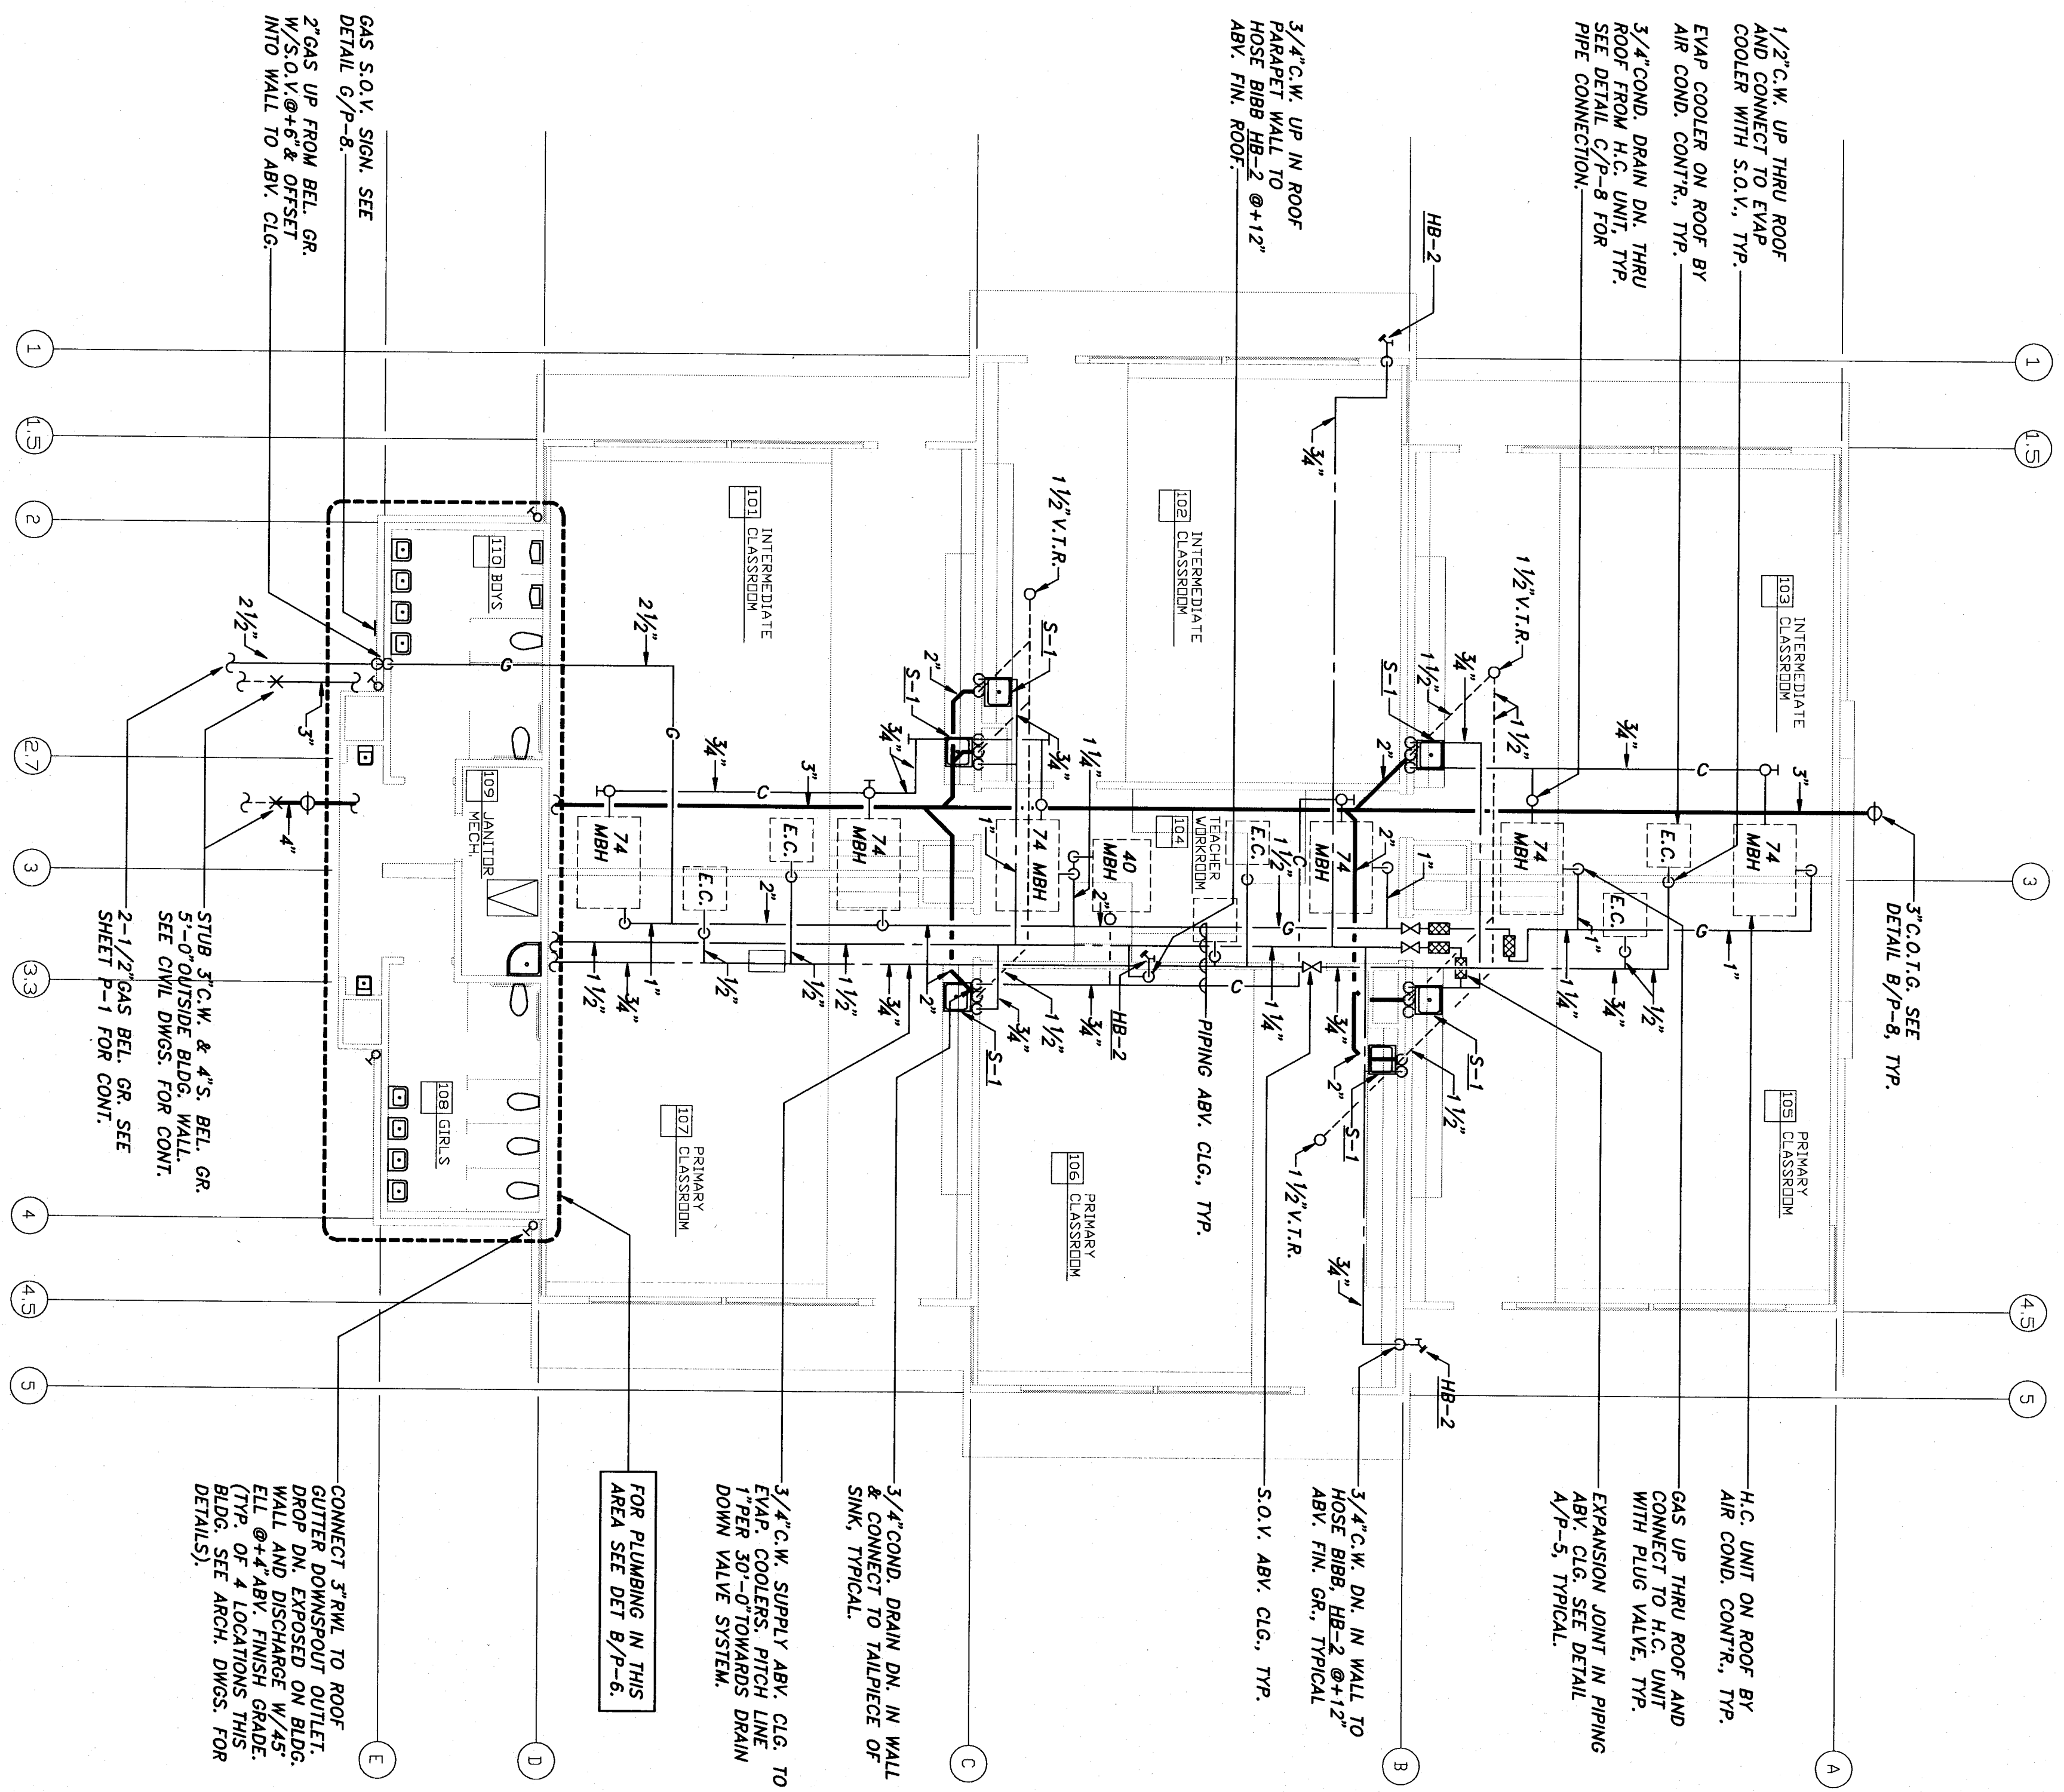

INTERMEDIATE/PRIMARY CLASSROOM PLUMBING PLAN 'F'

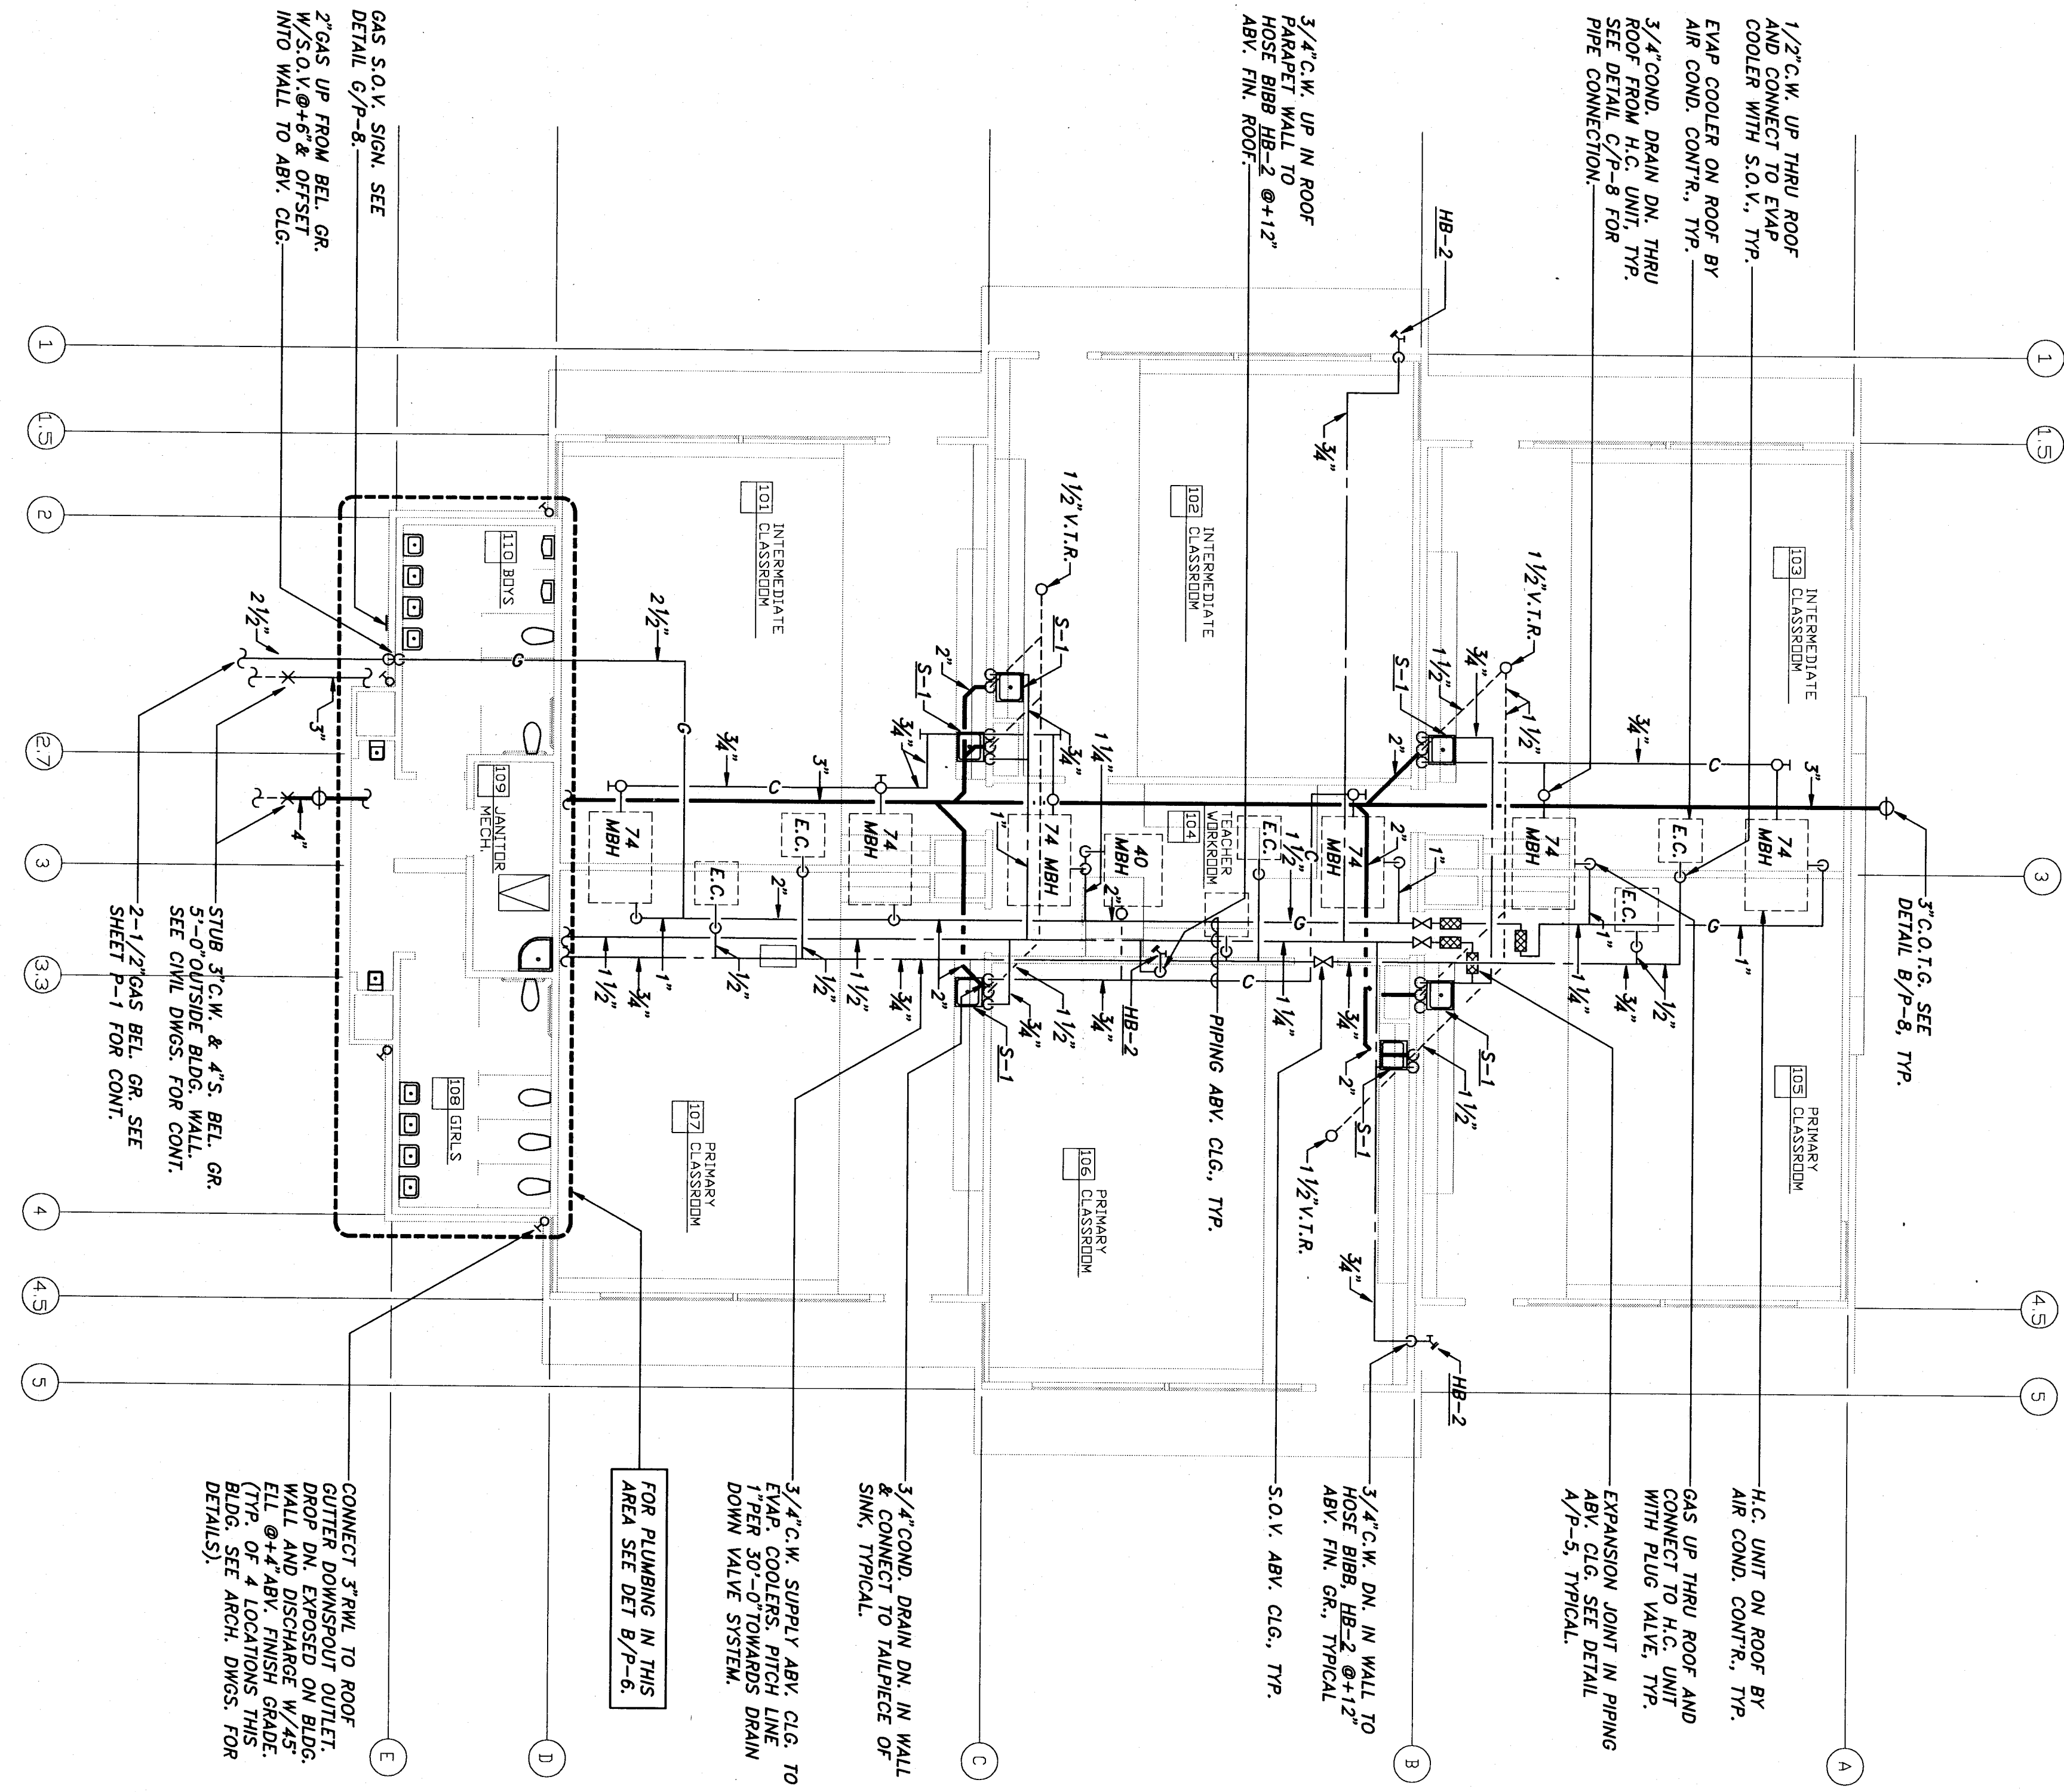

INTERMEDIATE CLASSROOM PLUMBING PLAN 'E'