



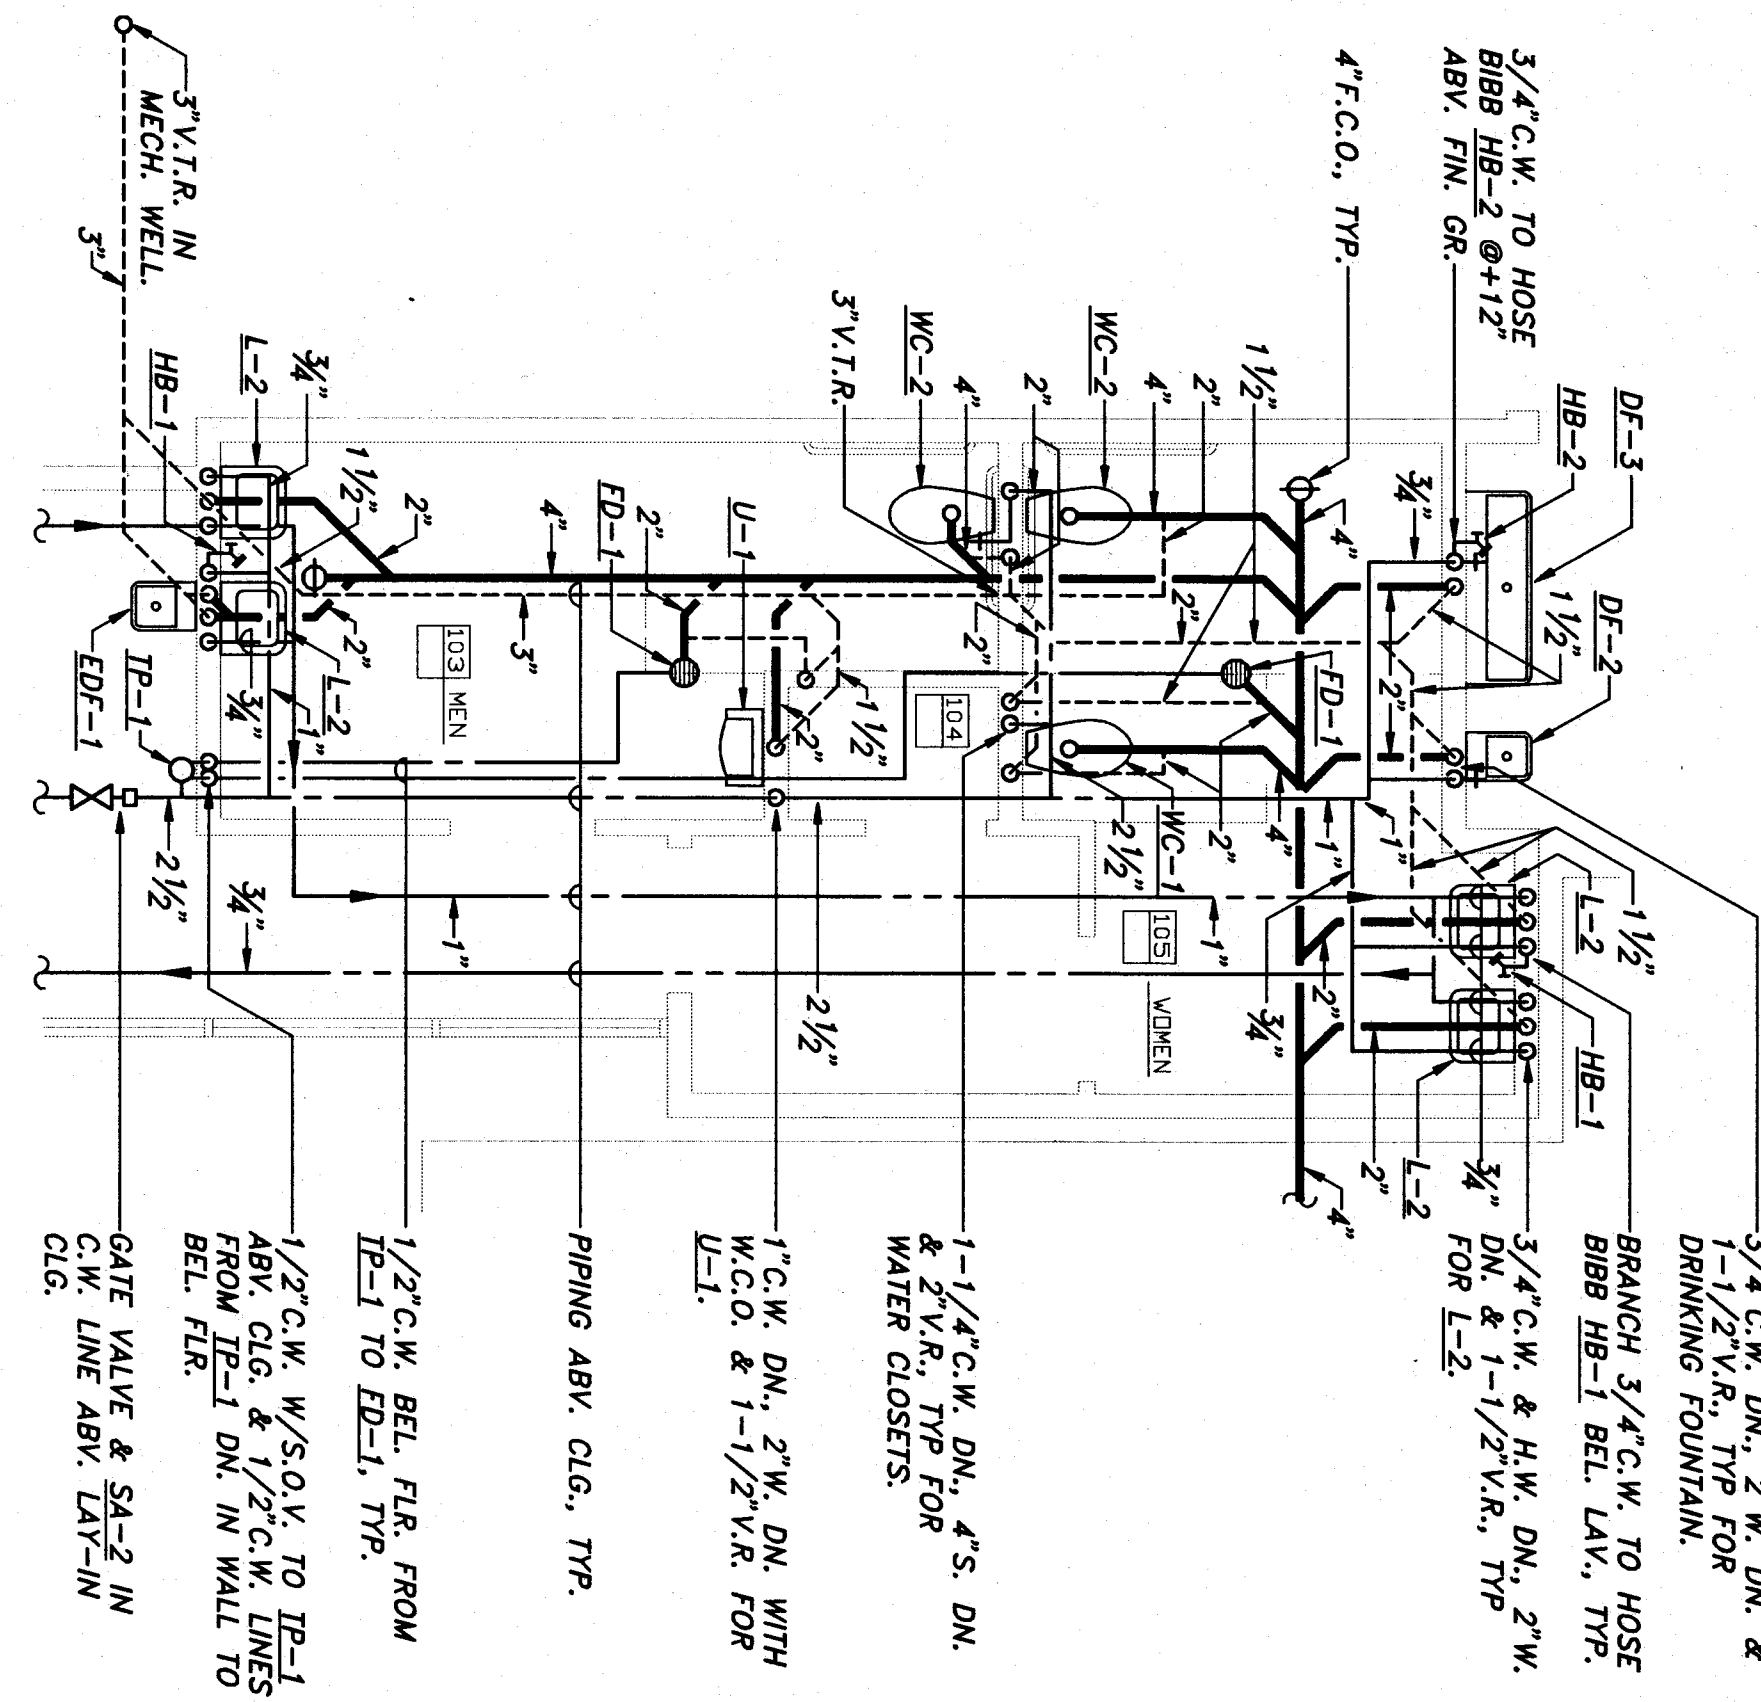

DETAILED PLUMBING PLAN - BLDG. "C"

SCALE 1/4"=1'-0"


P-6

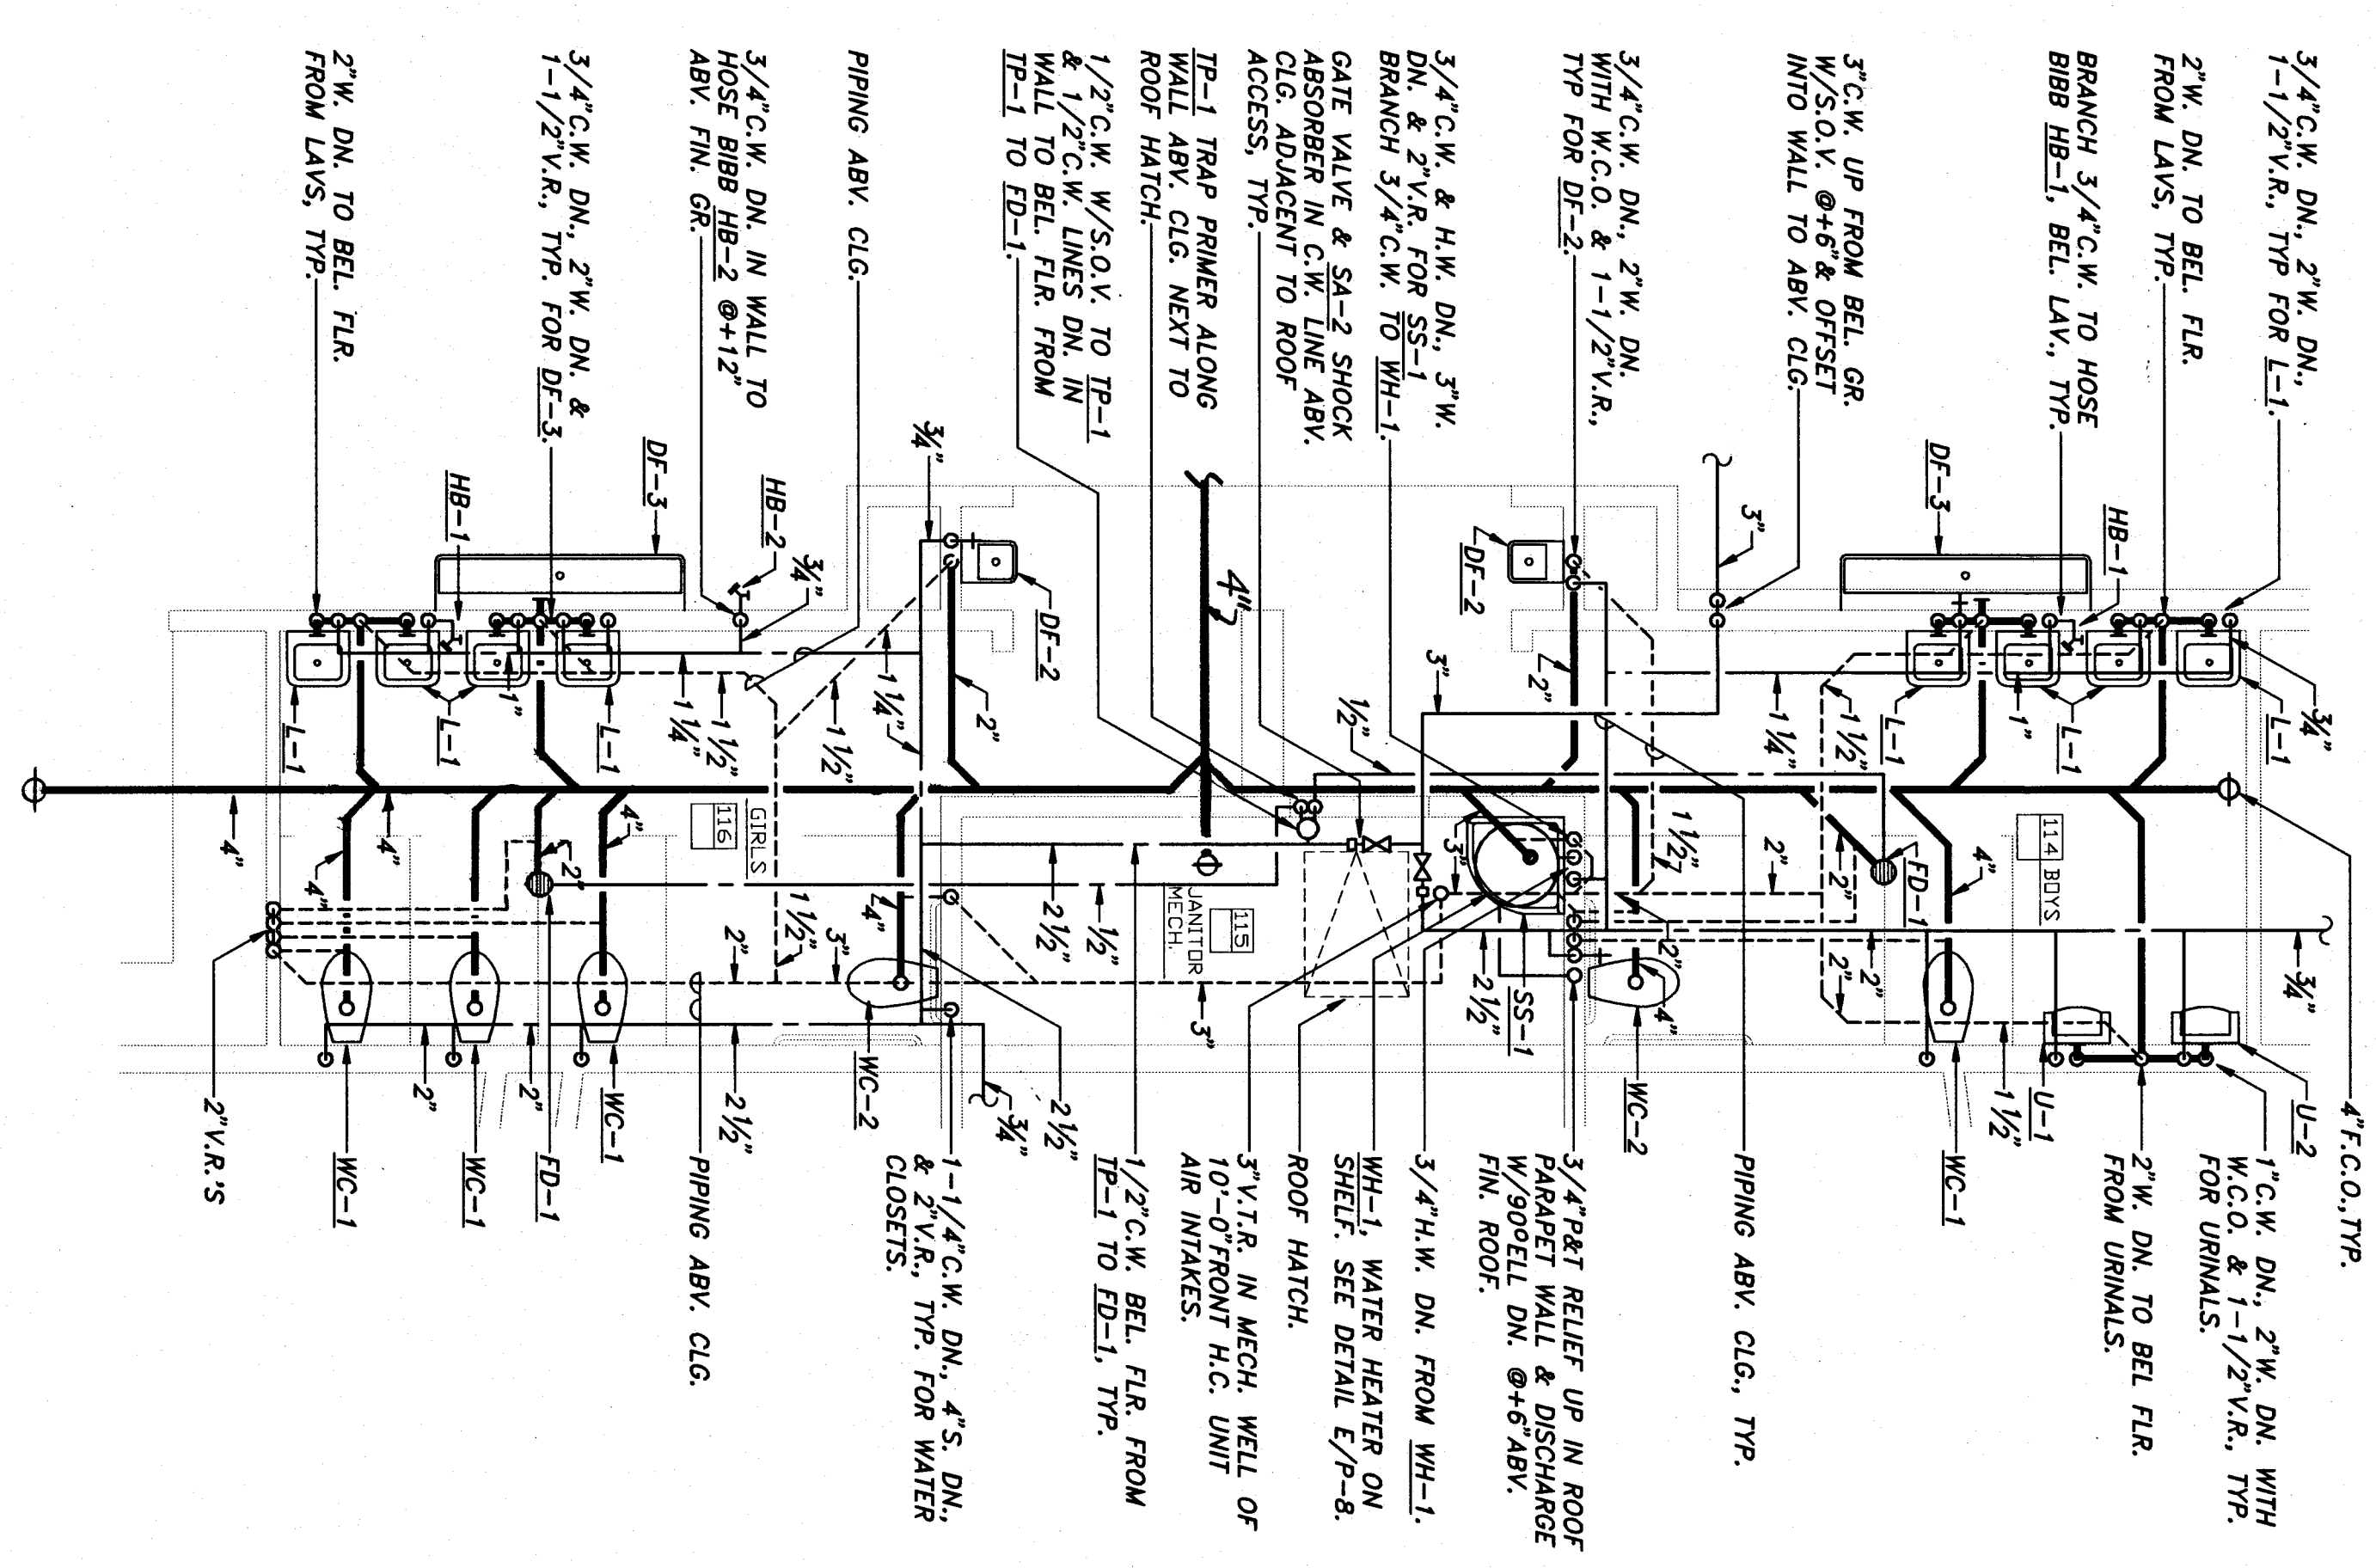

DETAILED PLUMBING PLAN - BLDG. "C"

SCALE 1/4"=1'-0"


P-6

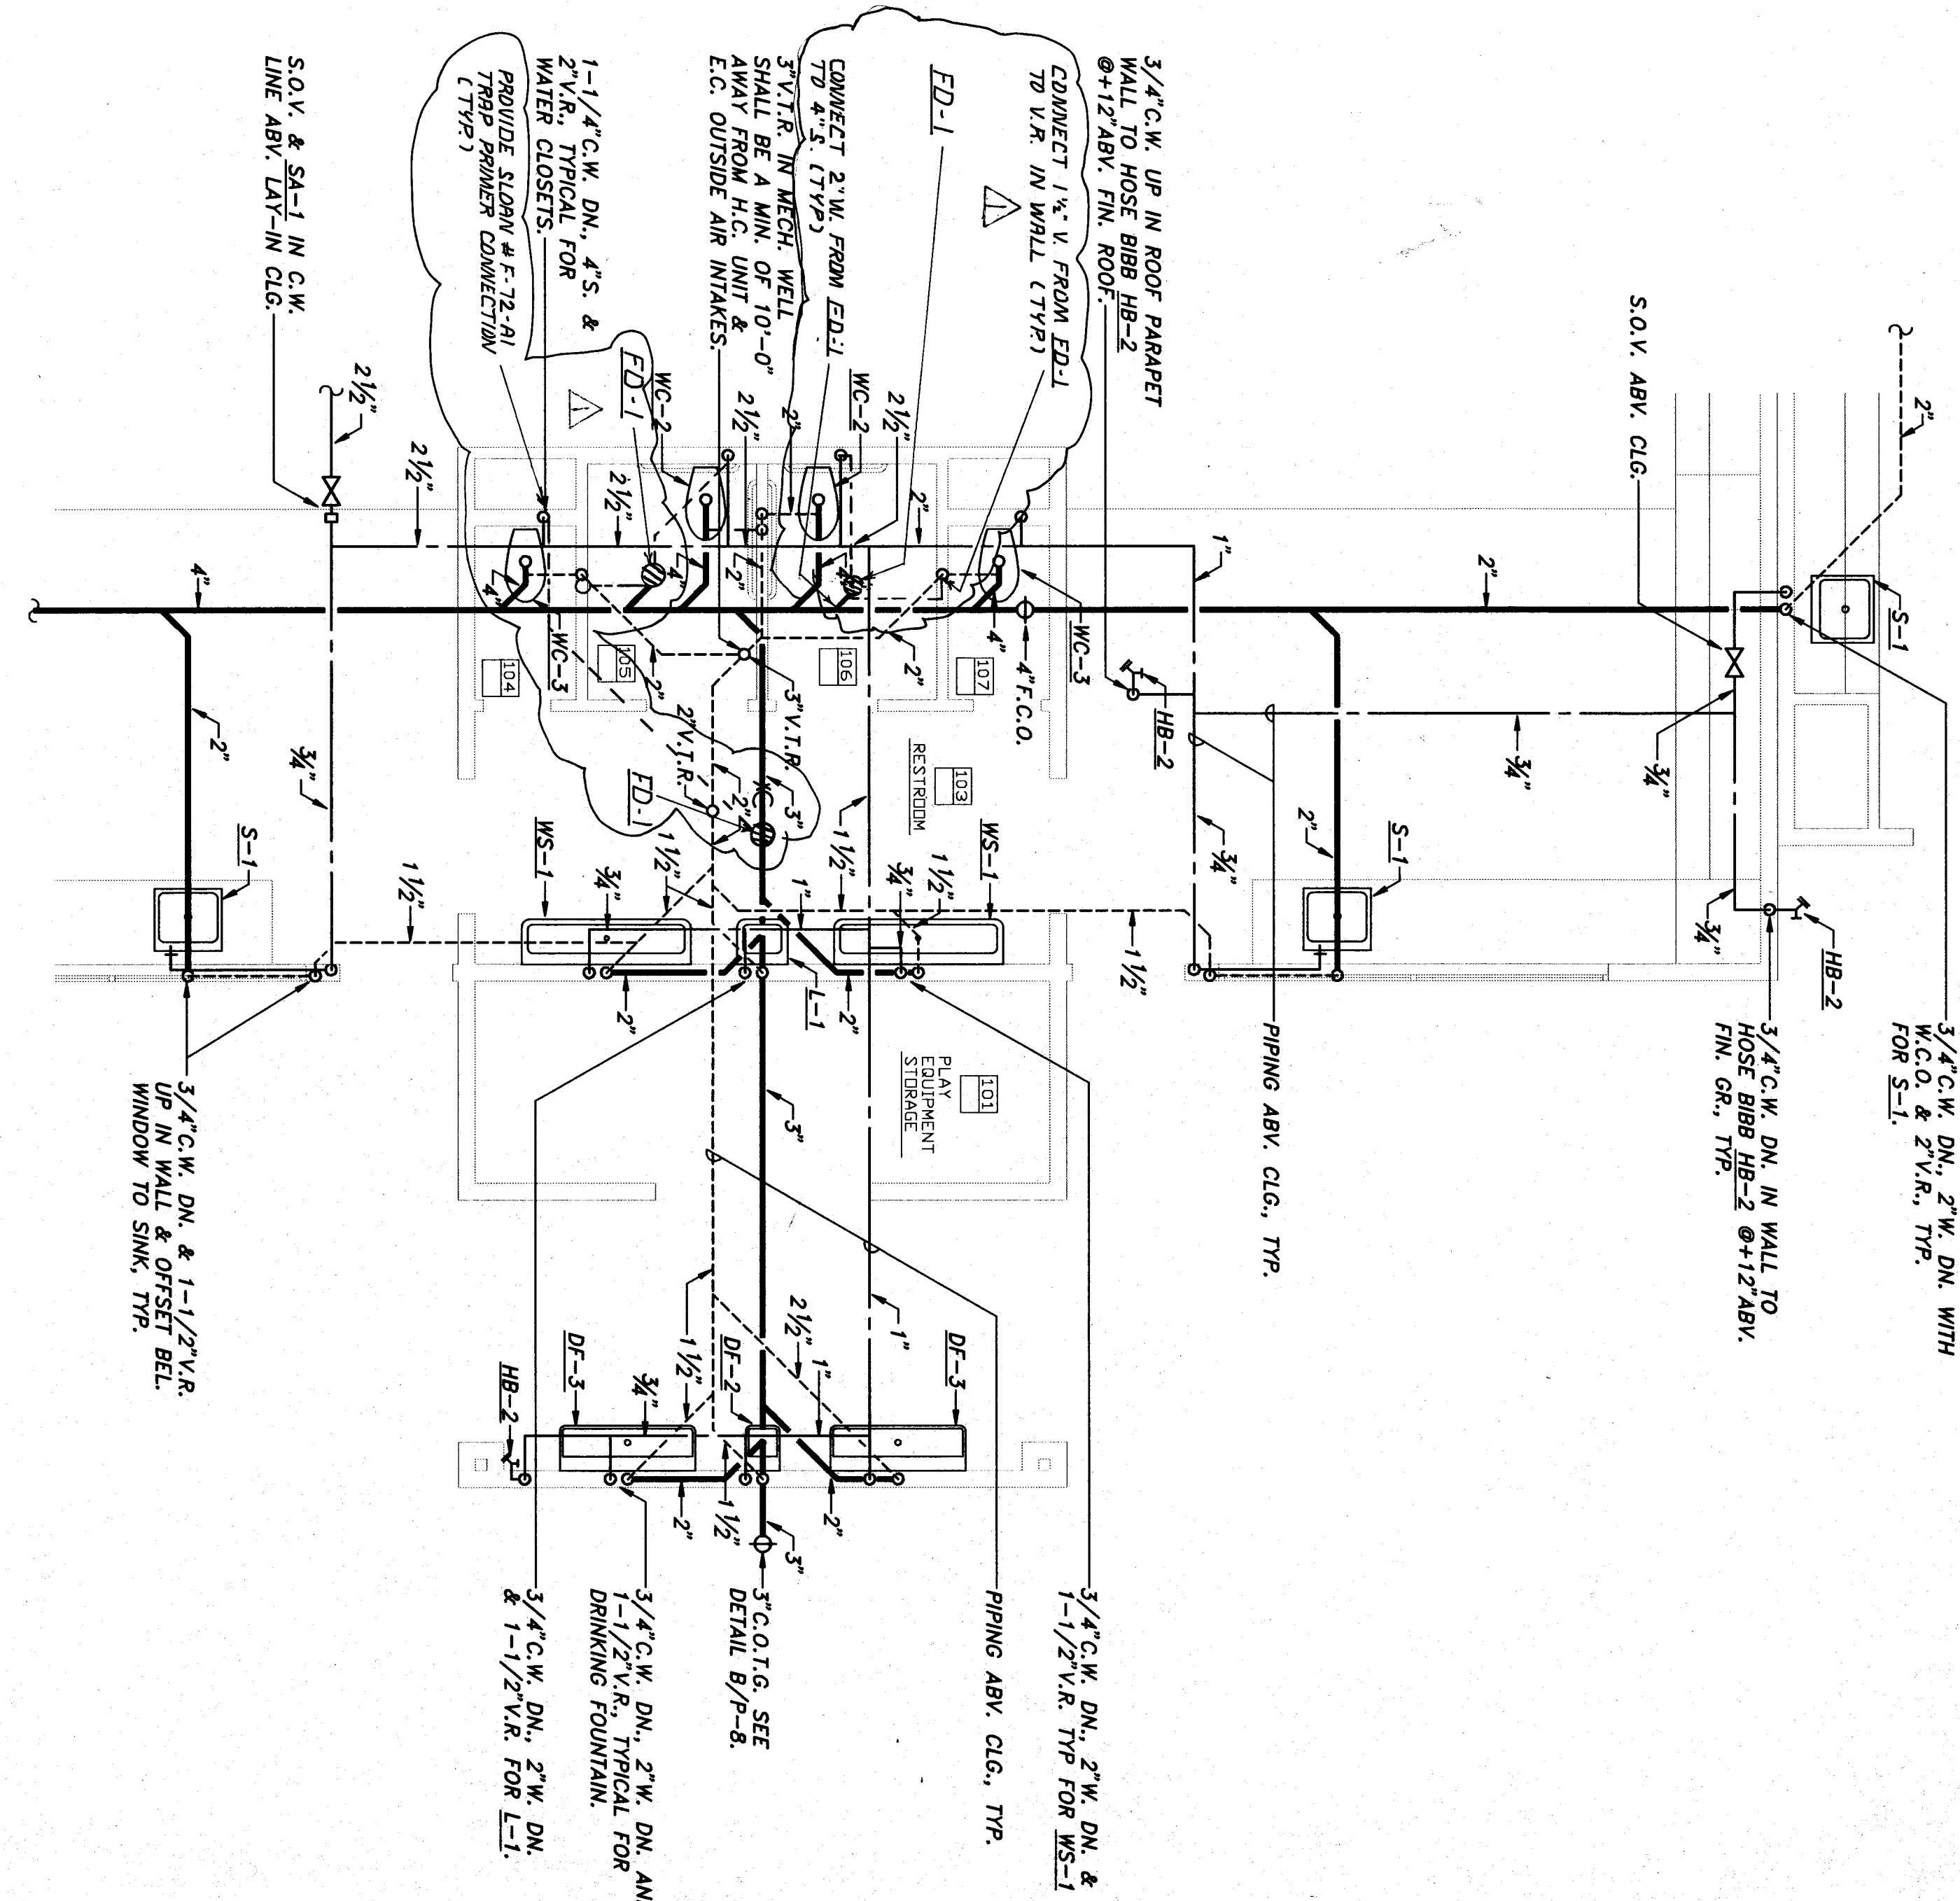

DETAILED PLUMBING PLAN - BLDG. "D"

SCALE 1/4"=1'-0"

P-6

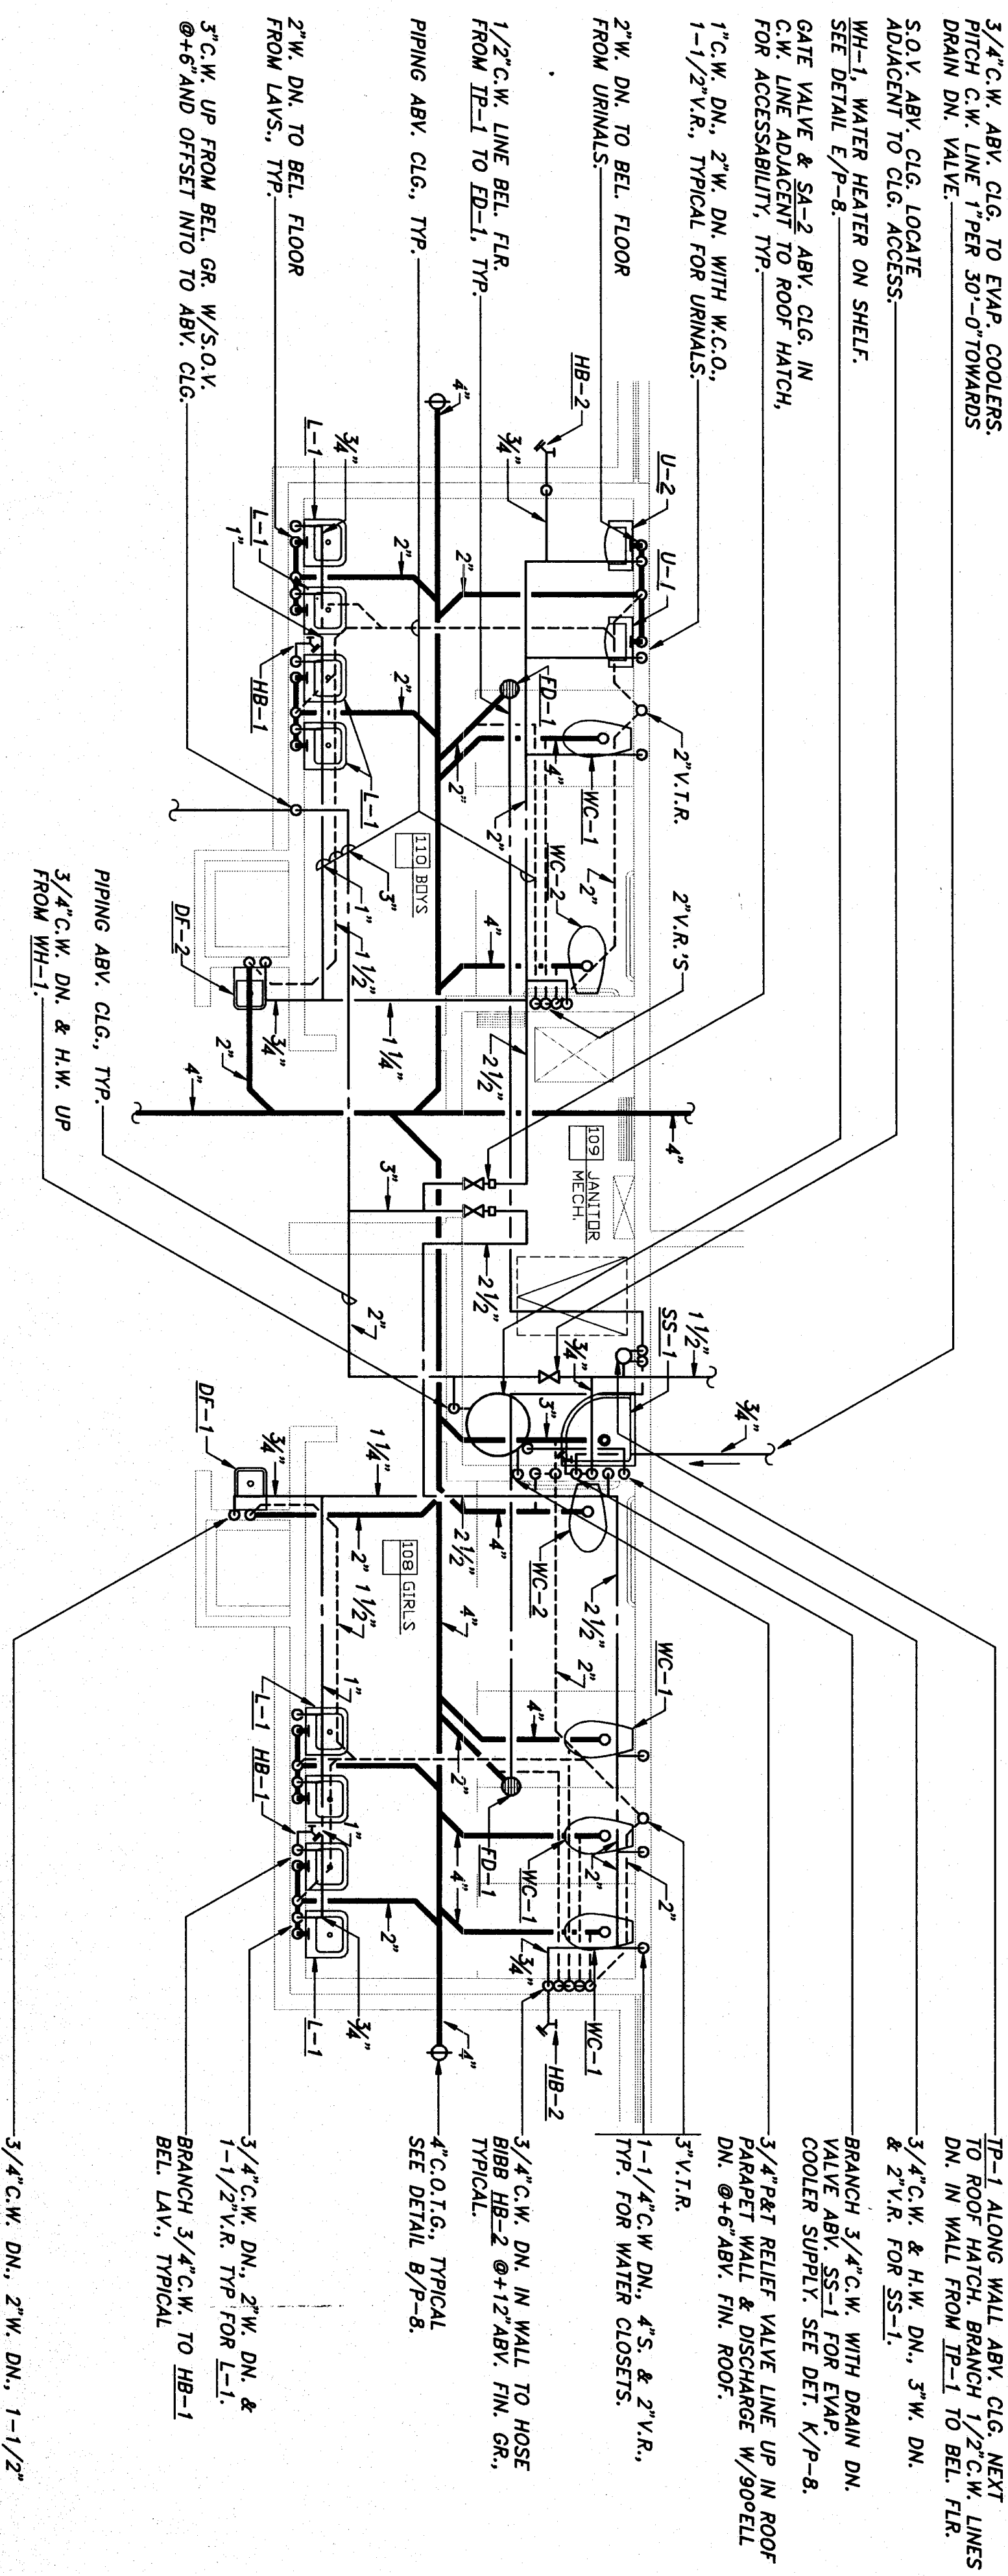

DETAILED PLUMBING PLAN - BLDGS "E" & "F"

SCALE 1/4"=1'-0"

P-6

BAKERSFIELD CITY SCHOOL DISTRICT

MESA MARIN ELEMENTARY SCHOOL

Sheet title: DETAILED PLUMBING PLANS

BAKERSFIELD, CALIFORNIA

KLASSEN CORPORATION

2021 Westwind Drive
Bakersfield, CA 93301
(805) 327-0875

DATE: 02/24/23

BY: [Signature]

CHECKED BY: [Signature]

DATE: 02/24/23

BY: [Signature]

CHECKED BY: [Signature]

DATE: 02/24/23

BY: [Signature]

CHECKED BY: [Signature]

PROJECT: MESA MARIN ELEMENTARY SCHOOL

LOCATION: 2021 Westwind Drive, Bakersfield, CA 93301

DATE: 02/24/23

BY: [Signature]

CHECKED BY: [Signature]

DATE: 02/24/23

BY: [Signature]

CHECKED BY: [Signature]