



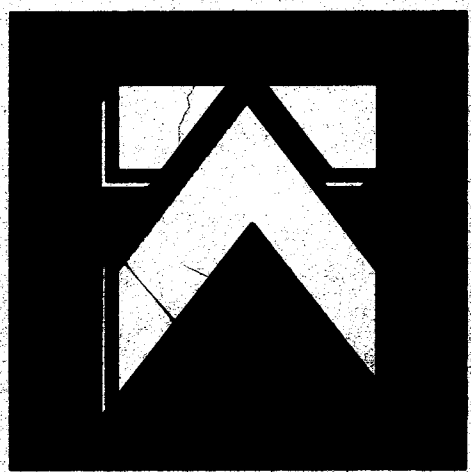

KLASSEN CORPORATION
ARCHITECTURE
CONSTRUCTION
2021 Westwind Drive
Bakersfield, CA 93301
(805) 327-0875

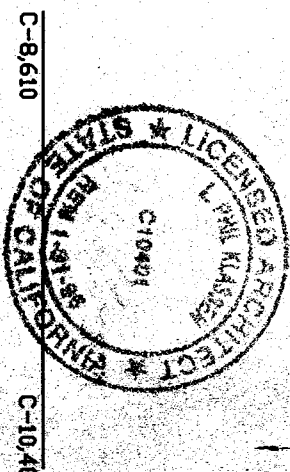

THIS DOCUMENT IS THE PROPERTY OF KLASSEN CORPORATION. IT IS TO BE USED ONLY FOR THE PROJECT AND SITE SPECIFICALLY IDENTIFIED HEREON. IT IS NOT TO BE REPRODUCED, COPIED, OR TRANSMITTED IN ANY FORM OR BY ANY MEANS, ELECTRONIC OR MECHANICAL, INCLUDING PHOTOCOPYING, RECORDING, OR BY ANY INFORMATION STORAGE AND RETRIEVAL SYSTEM, WITHOUT THE WRITTEN PERMISSION OF KLASSEN CORPORATION.


BAKERSFIELD CITY SCHOOL DISTRICT
MESA MARIN ELEMENTARY SCHOOL
BAKERSFIELD, CALIFORNIA

Sheet title:
DETAILED PLUMBING PLAN
KITCHEN AREA BUILDING "C"


DATE: 11/11/2021
REVISIONS:
NO. 1
BY: [Signature]
DATE: 11/11/2021

DATE: 11/11/2021
REVISIONS:
NO. 1
BY: [Signature]
DATE: 11/11/2021

DATE: 11/11/2021
REVISIONS:
NO. 1
BY: [Signature]
DATE: 11/11/2021

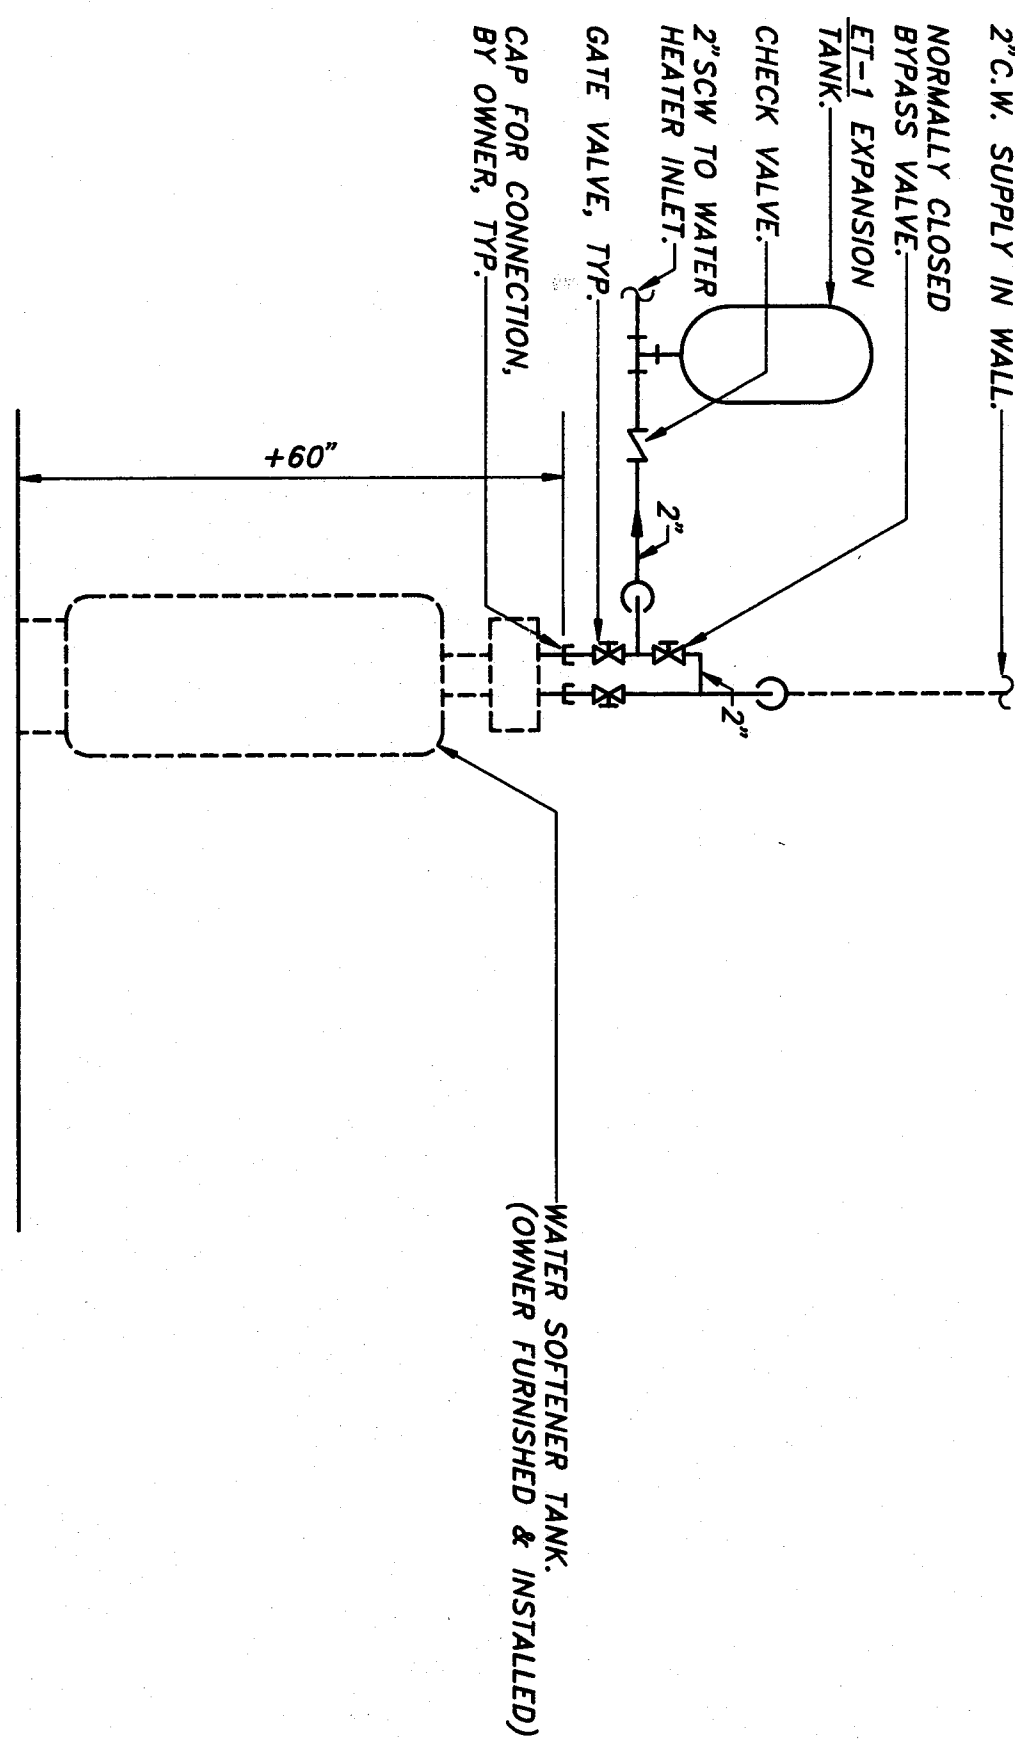

WATER PIPING SCHEMATIC
SCALE: NONE

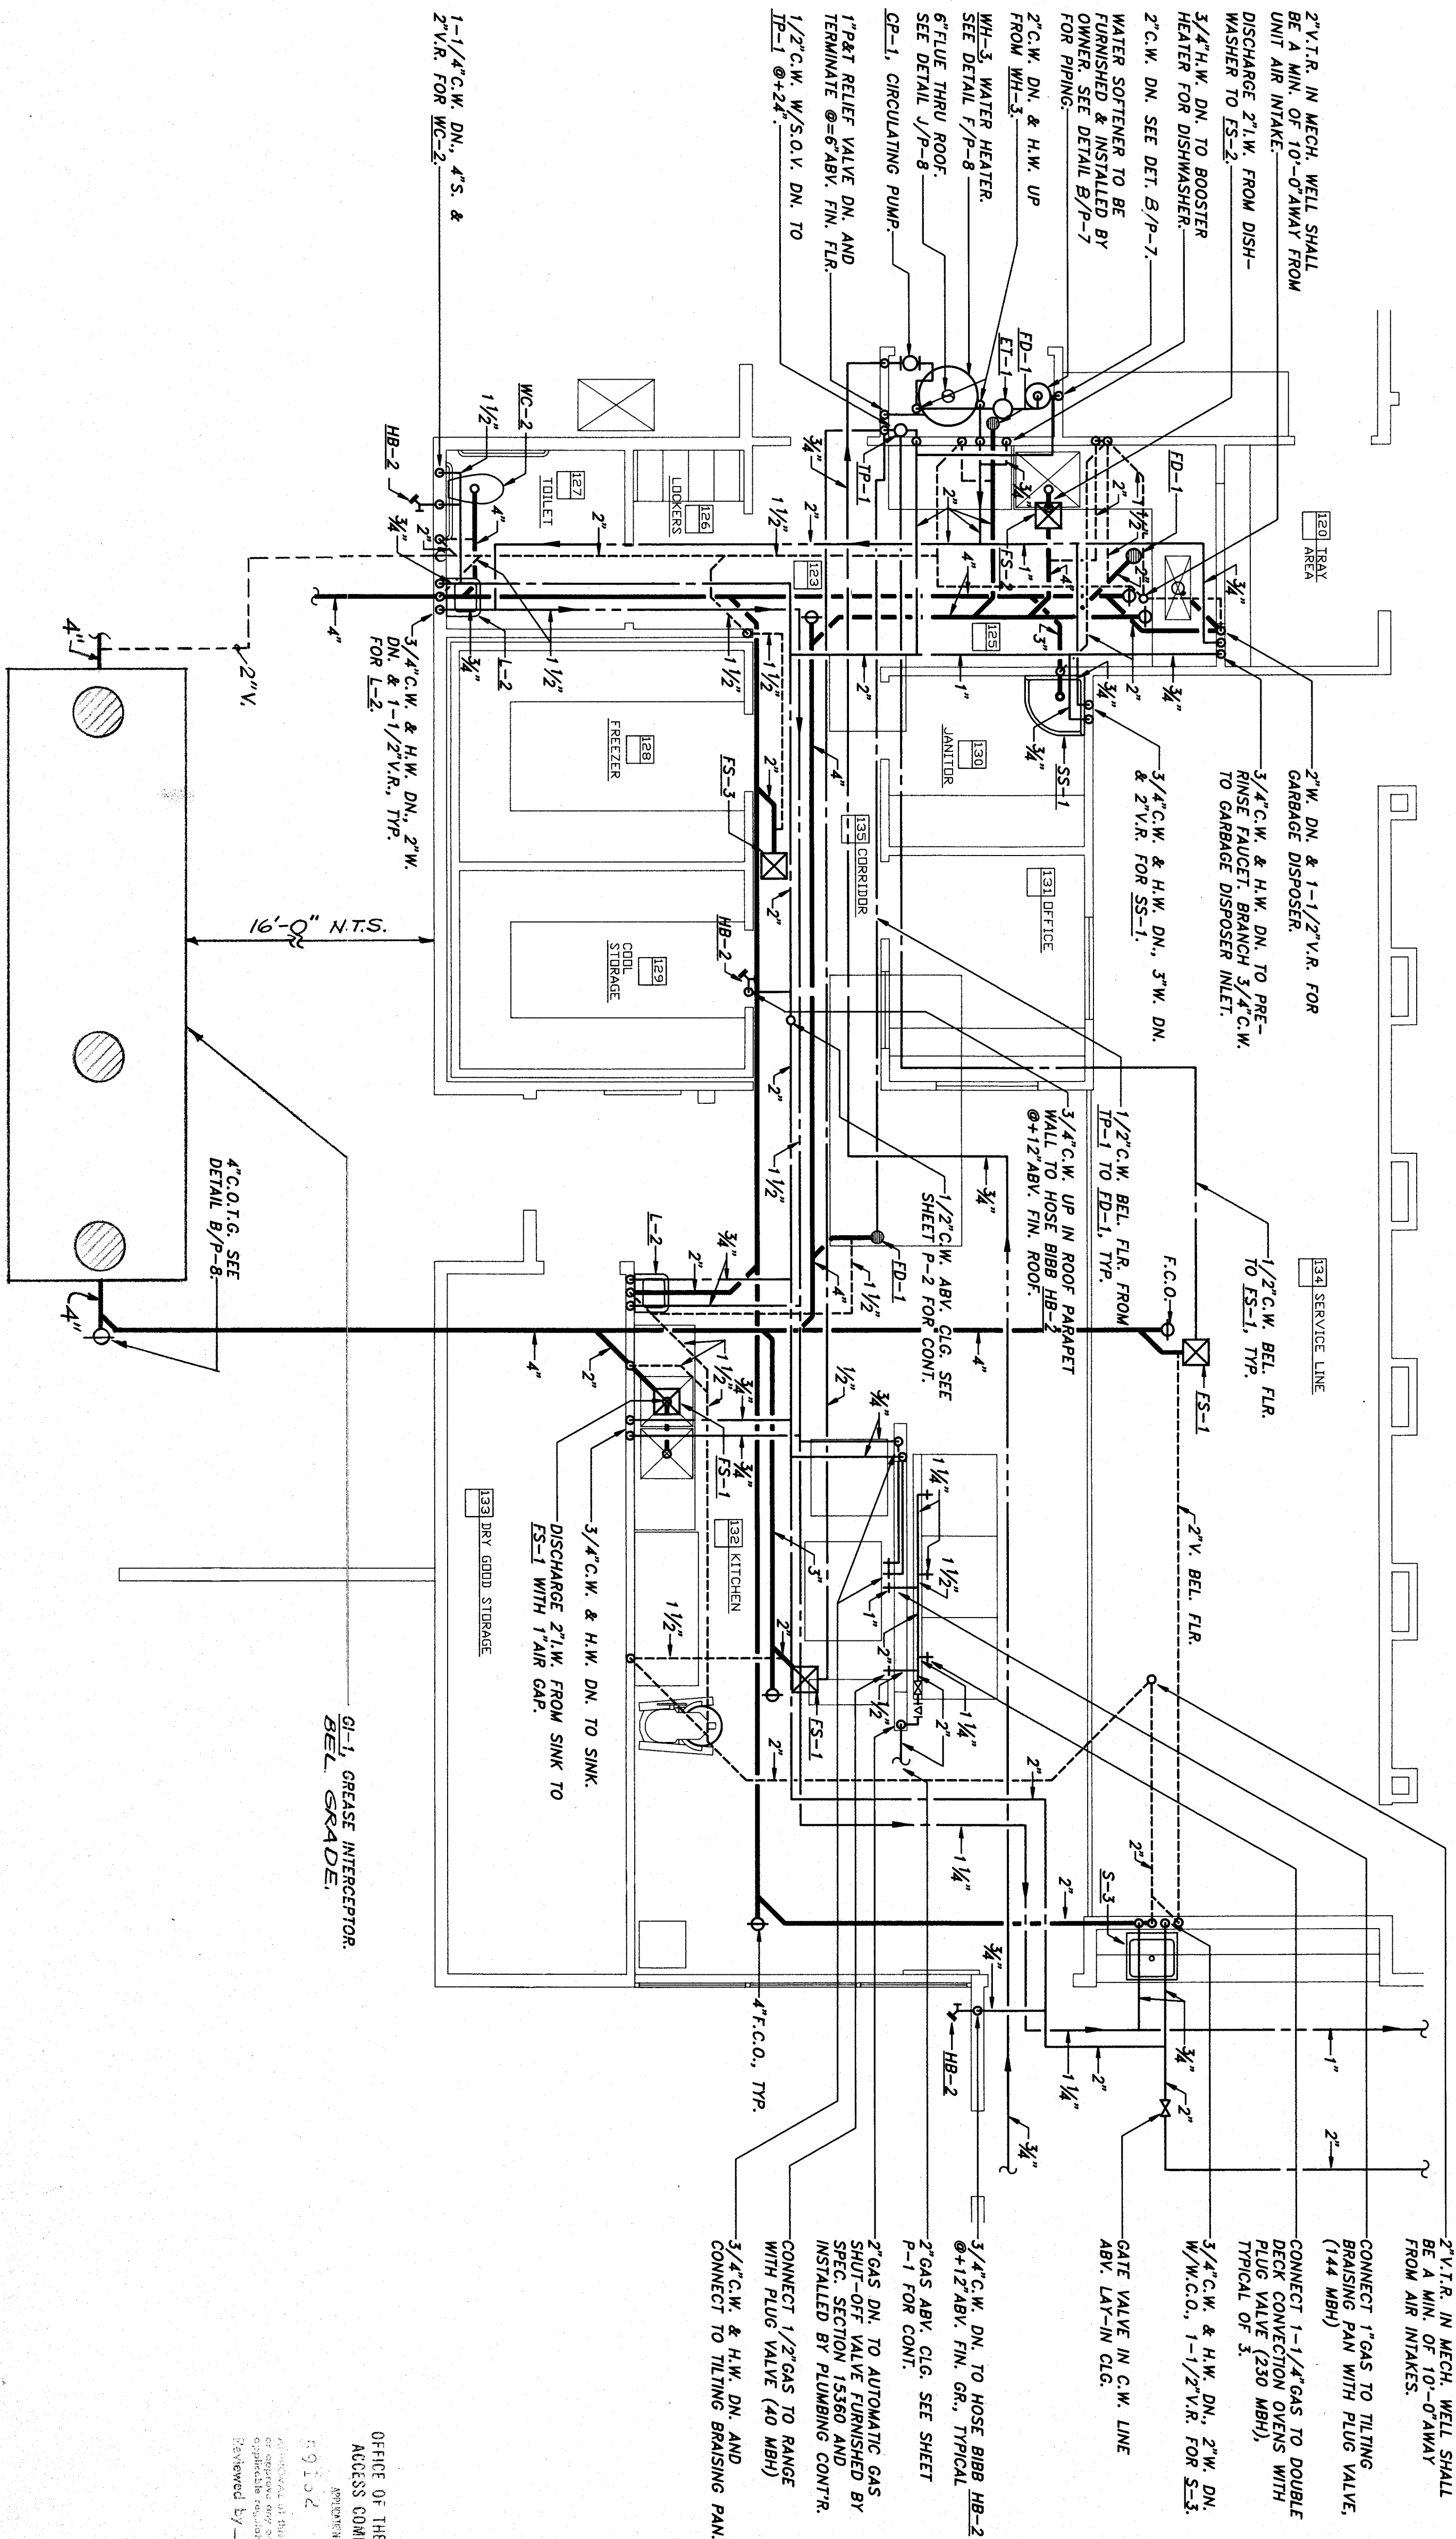

DETAILED PLUMBING PLAN - KITCHEN AREA BLDG. "C"
SCALE: 1/4"=1'-0"

OFFICE OF THE STATE ARCHITECT
ACCESS COMPLIANCE SECTION
11/11/2021
11/11/2021
11/11/2021