


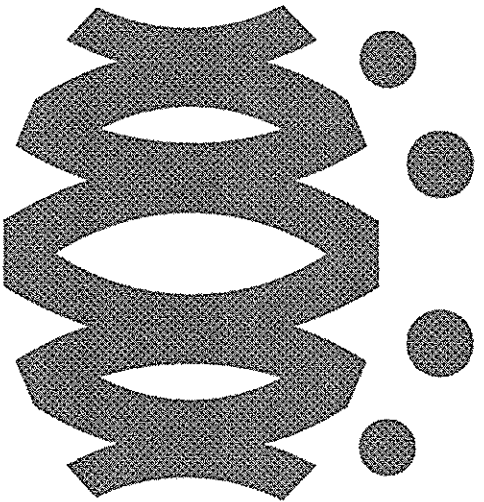


FLEWELLING
&
MOODY
architects for education


HEADQUARTERS OFFICE:
141 South Lake Avenue, 2nd Floor
Pasadena, California 91101
TEL: (626) 799-8800 FAX: (626) 799-8801
E-Mail: projects@flemingmoody.com
www.flemingmoody.com

ANTELOPE VALLEY OFFICE:
15000 Valley Blvd., Suite 200
Livermore, California 94551
TEL: (925) 461-1000 FAX: (925) 461-1001
E-Mail: info@antelopevalleyfmo.com
www.antelopevalleyfmo.com

An Employee Owned Corporation

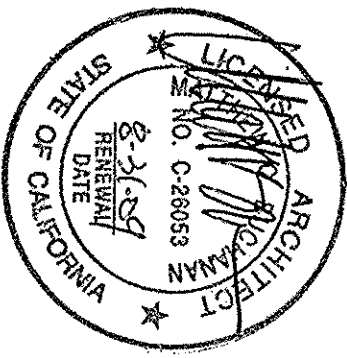

CONSULTANT

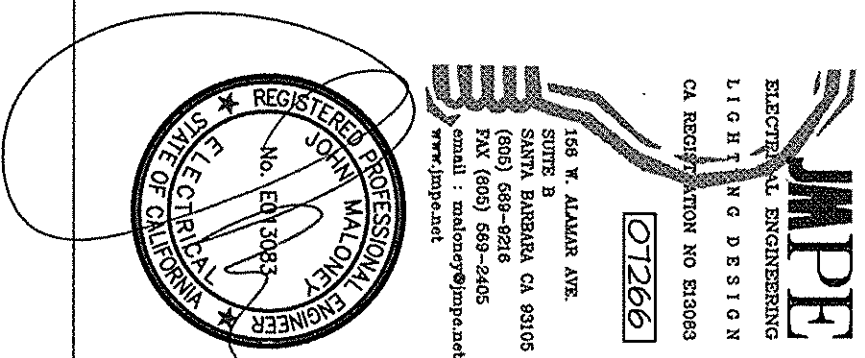

ARCHITECT

IDENTIFICATION STAMP
DIV. OF THE STATE ARCHITECT
APR03 111193
AC/LEWIS & CLARK
BANKS

Drawn by _____		
Checked by _____		
Revisions		
No.	Date	Description

All dimensions shall be to center of line, unless otherwise noted.
These drawings are the property of the architect and shall remain his/her property. No part of these drawings shall be reproduced or transmitted in any form or by any means, electronic, mechanical, photocopying, recording, or by any information storage and retrieval system, without the prior written permission of the architect.

2 24'x40' MODULAR BUILDINGS
AT CESAR E. CHAVEZ ES.
BAKERSFIELD, CA 93305




BAKERSFIELD CITY SCHOOL DISTRICT

PARTIAL SITE
ELECTRICAL PLAN

Job No.	2237
Date	10-1-2007
Sheet	E-2


ELECTRICAL NOTES

- 1-1/4" C. (POWER) SEE SINGLE LINE.
- 1-1/4" C. (FIRE ALARM) (4) #12 THIN CU (ANNUNCIATION) + (4) #14 THIN CU (INITIATION) TO EACH (N) PORTABLE CLASSROOM
- 3/4" C.W (4) #12 THIN CU (ANNUNCIATION) + (4) #14 THIN CU (INITIATION)
- 3/4" C.W (4) #12 THIN CU
- 3/4" C.W (4) #14 THIN CU

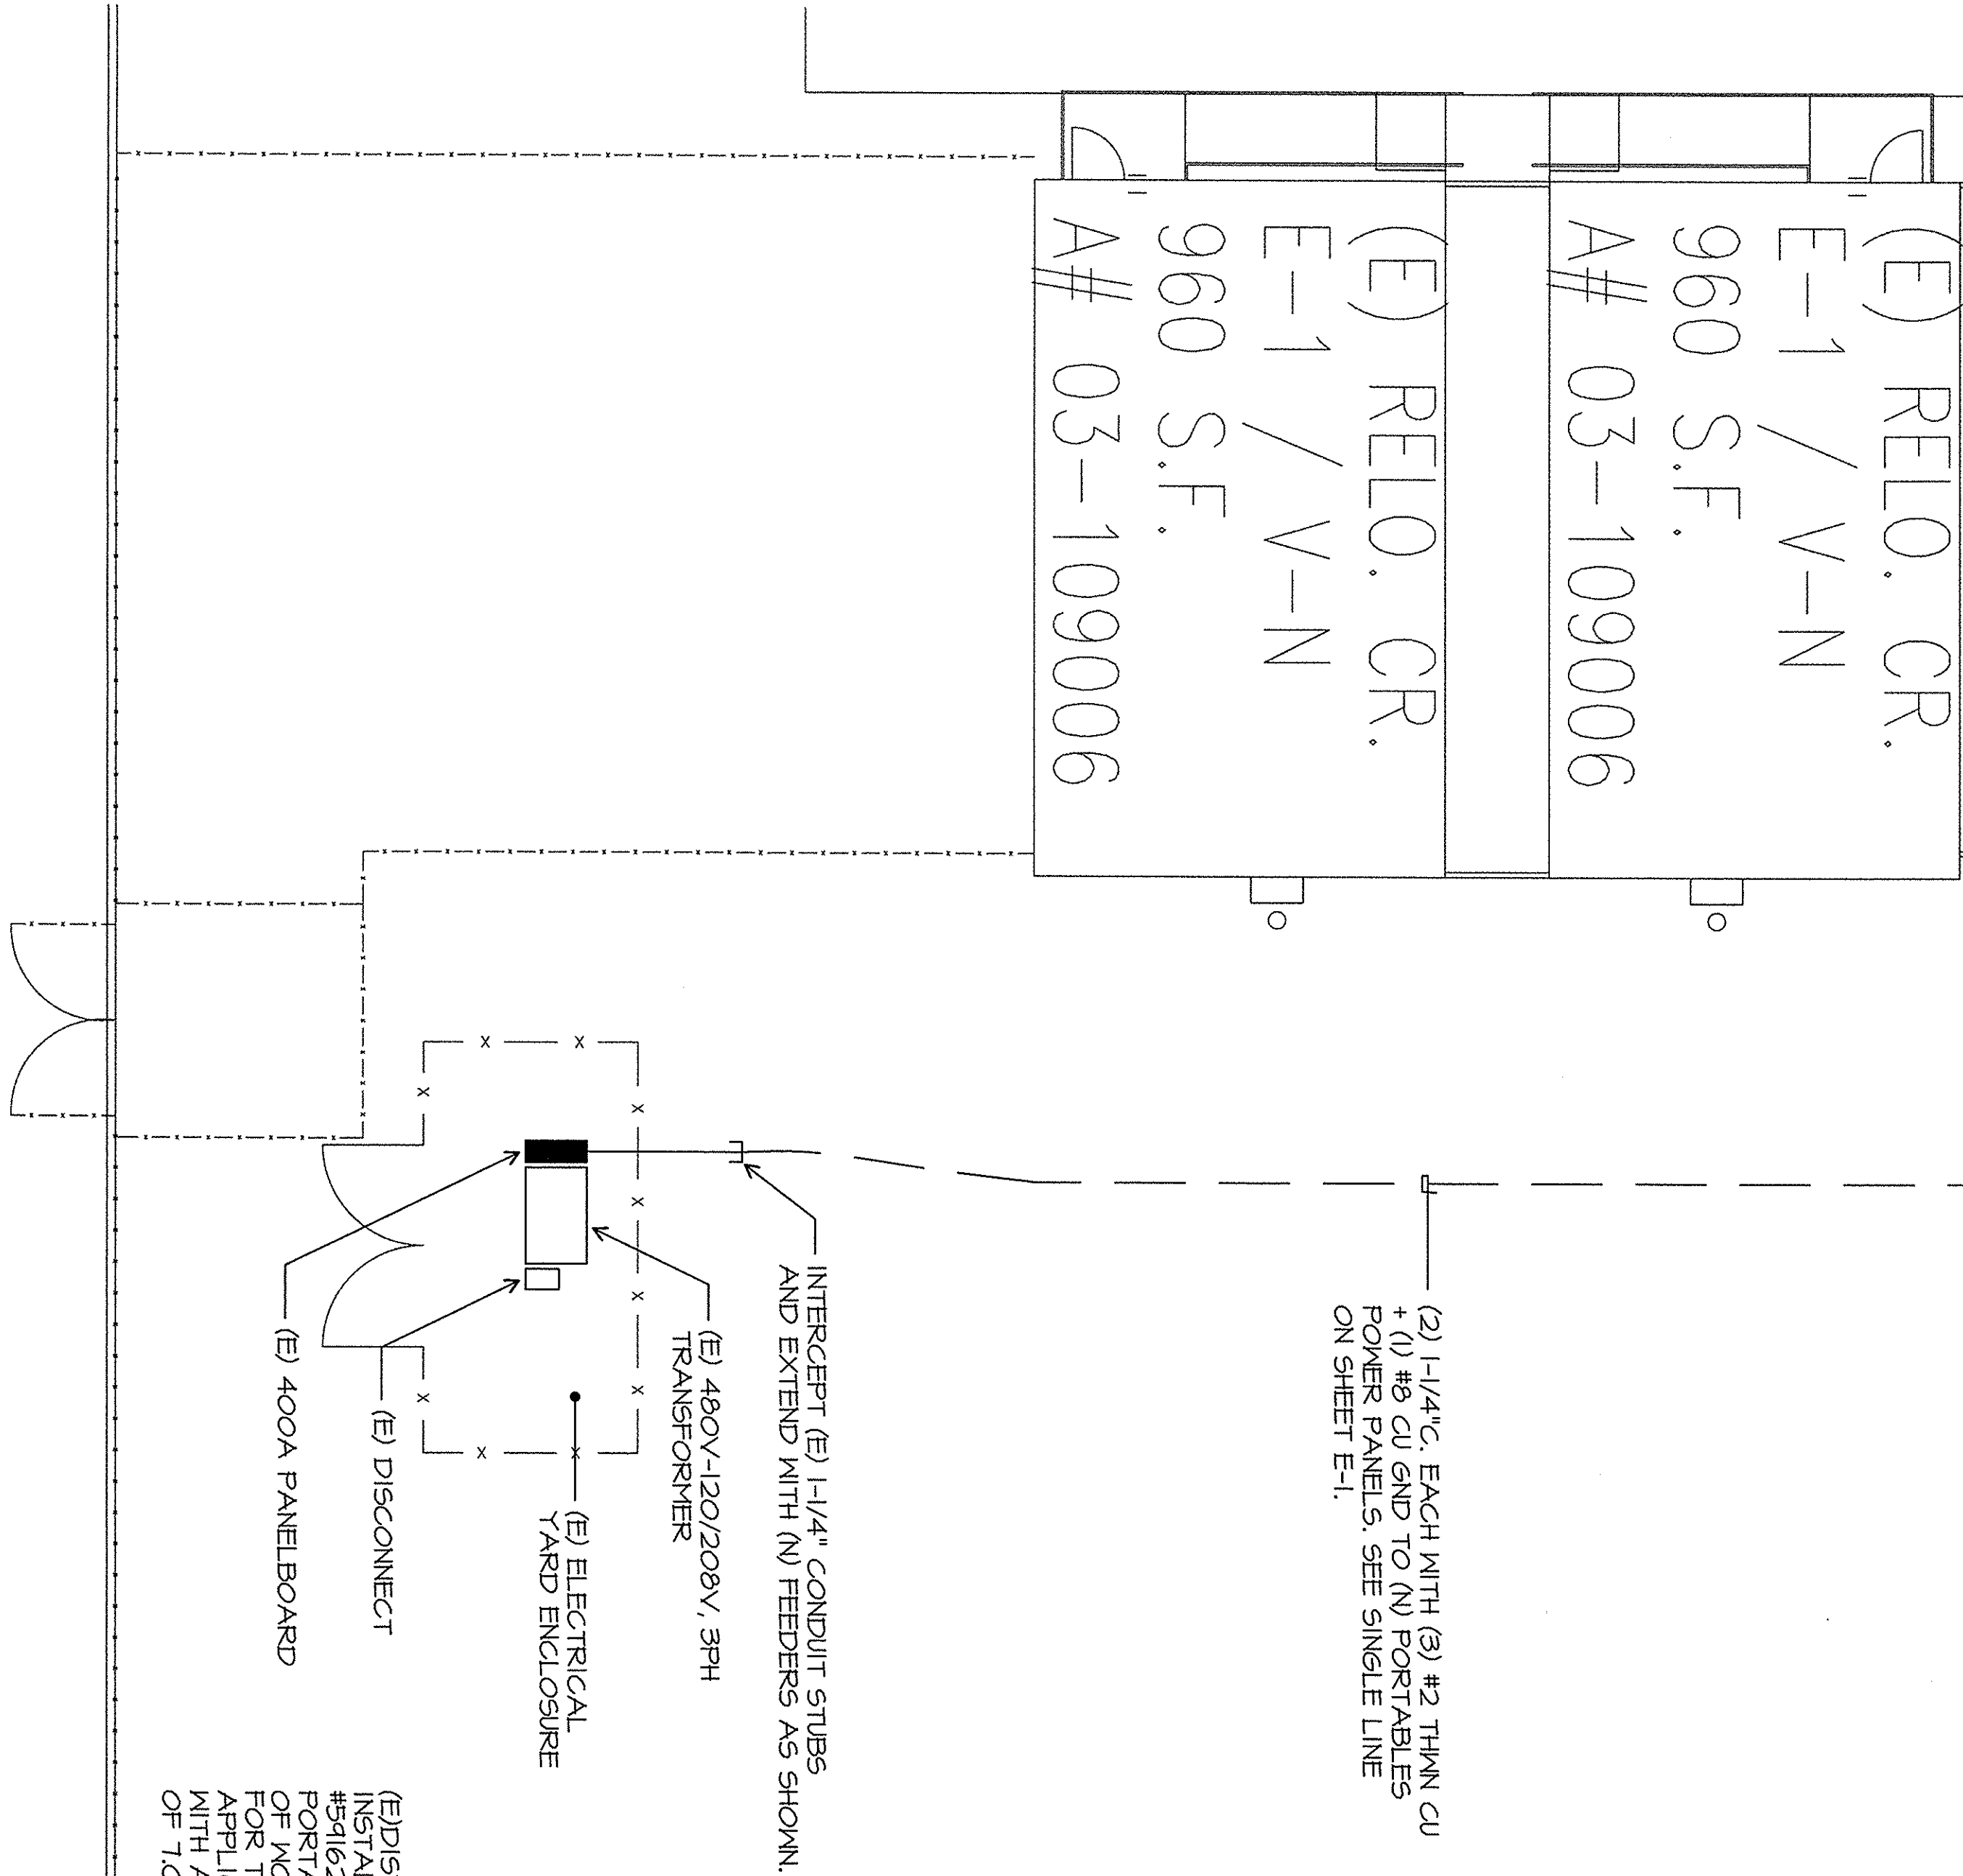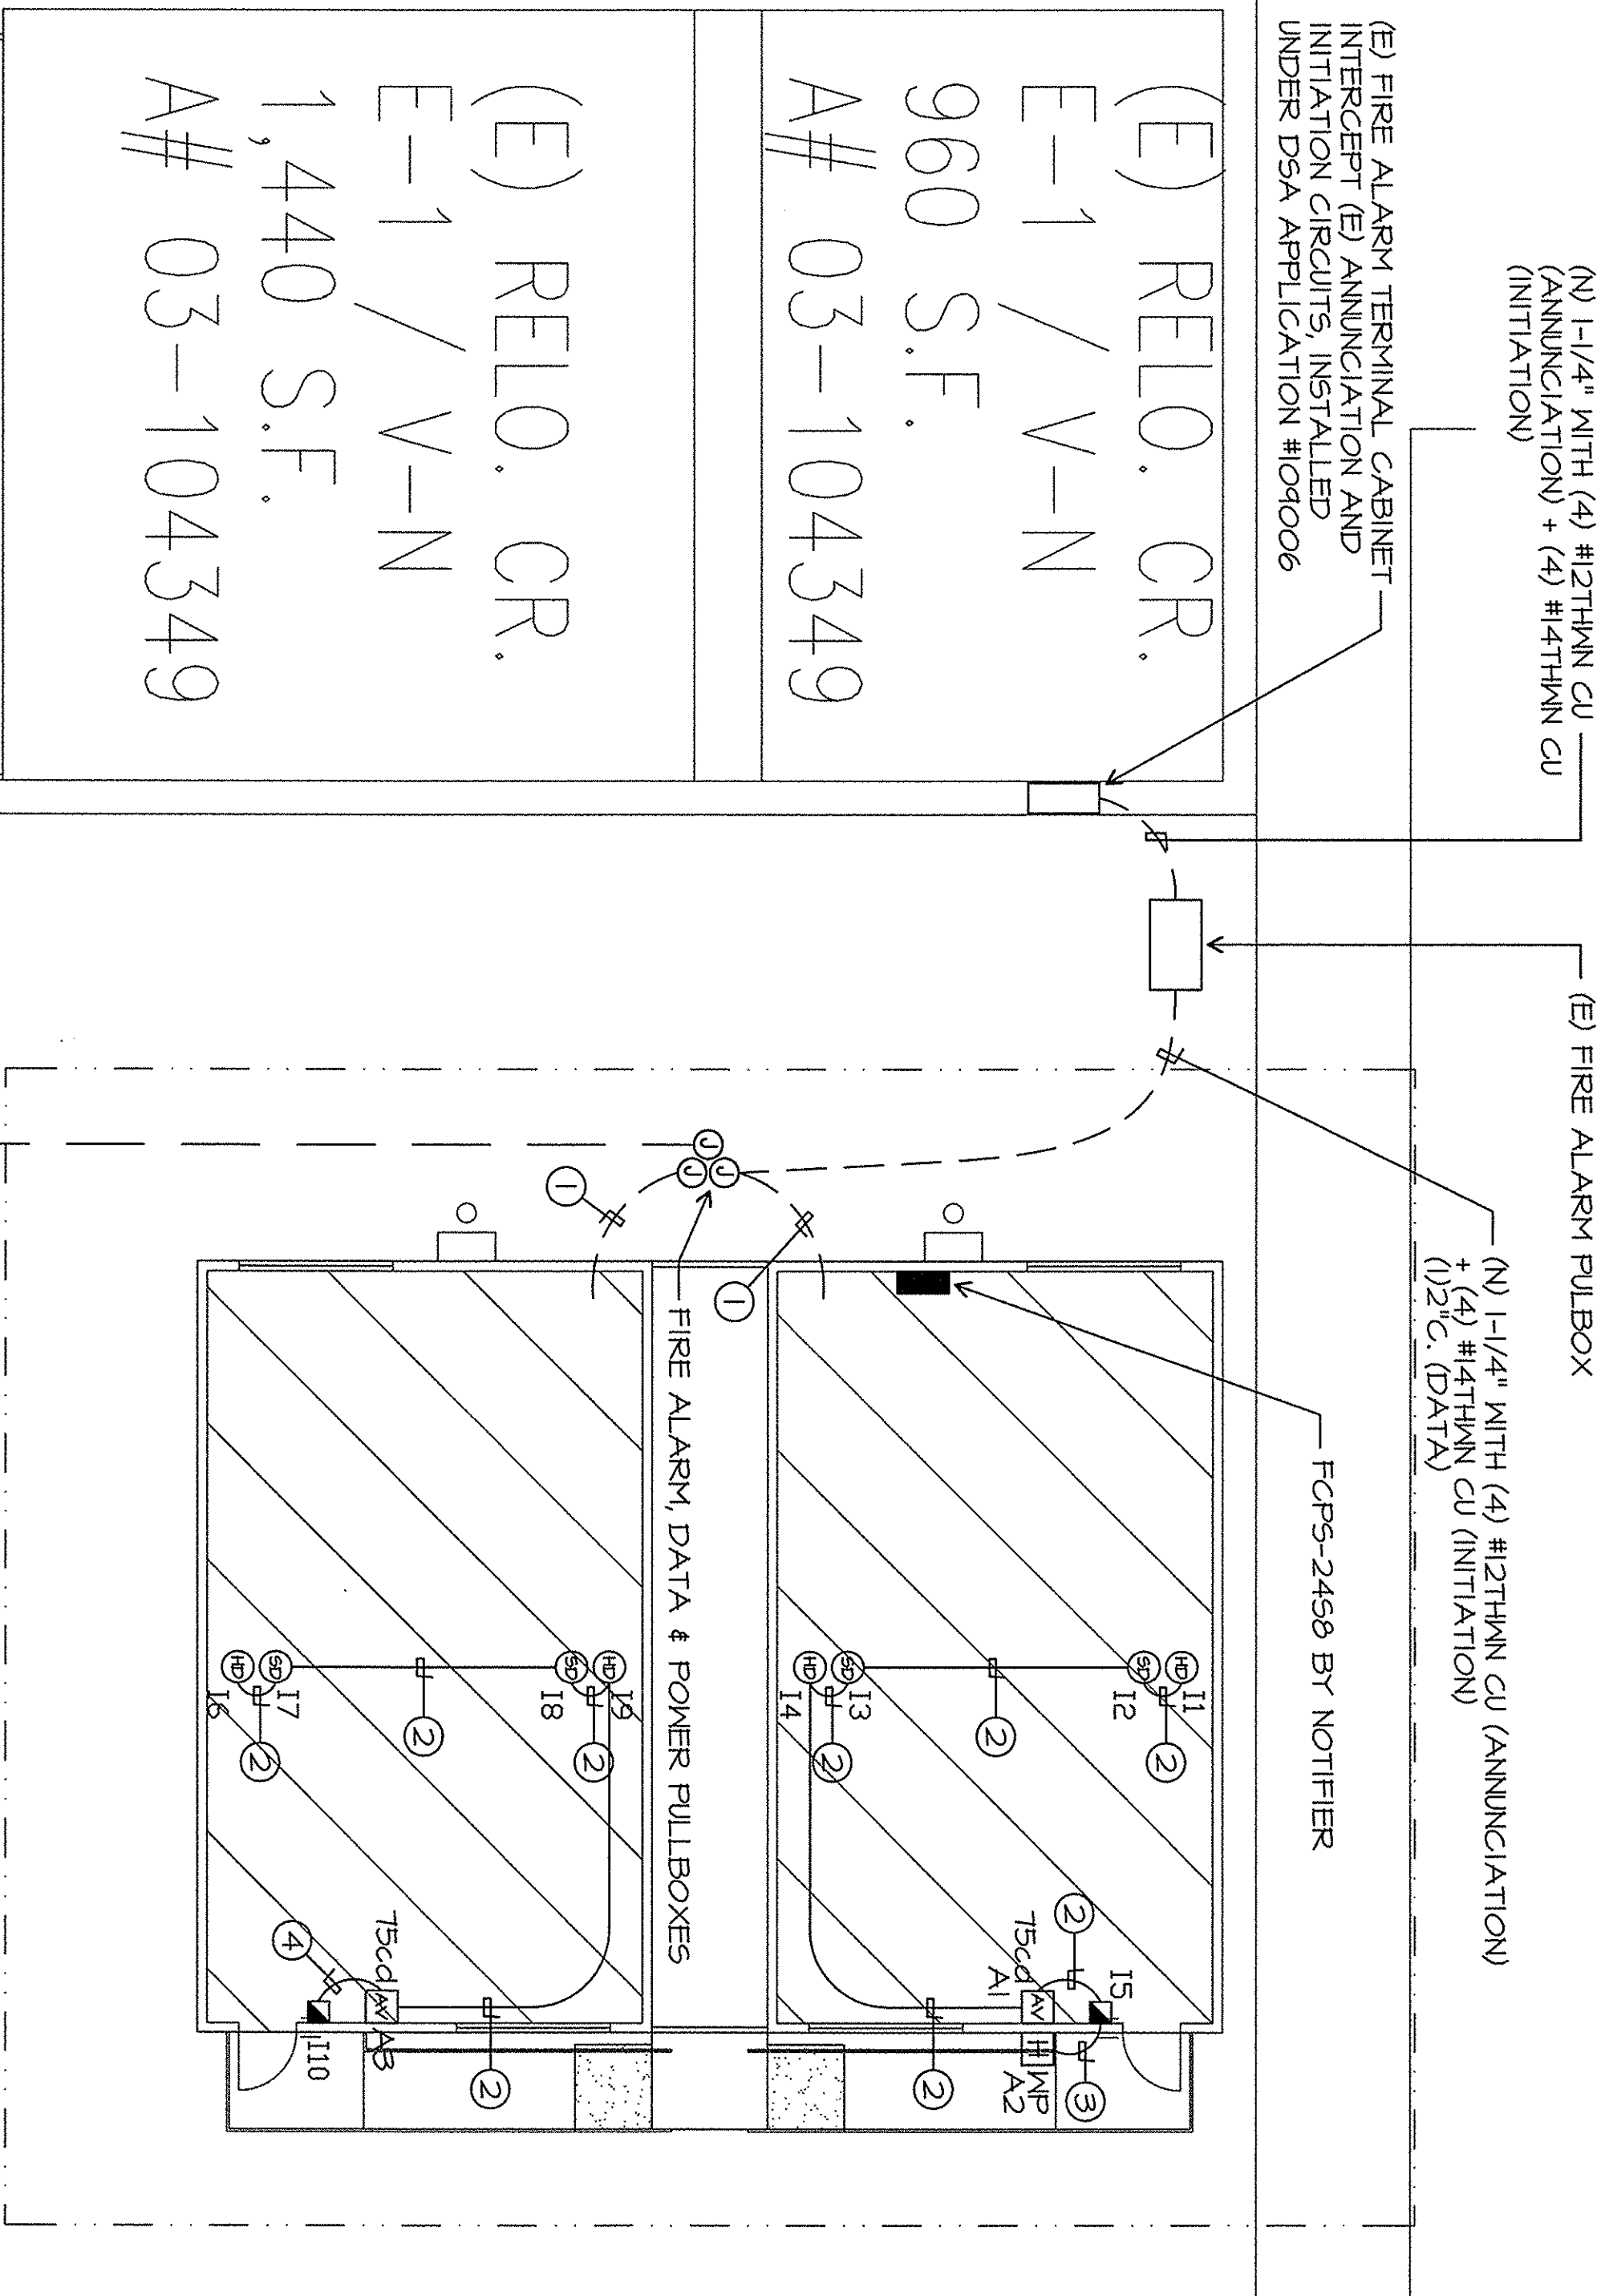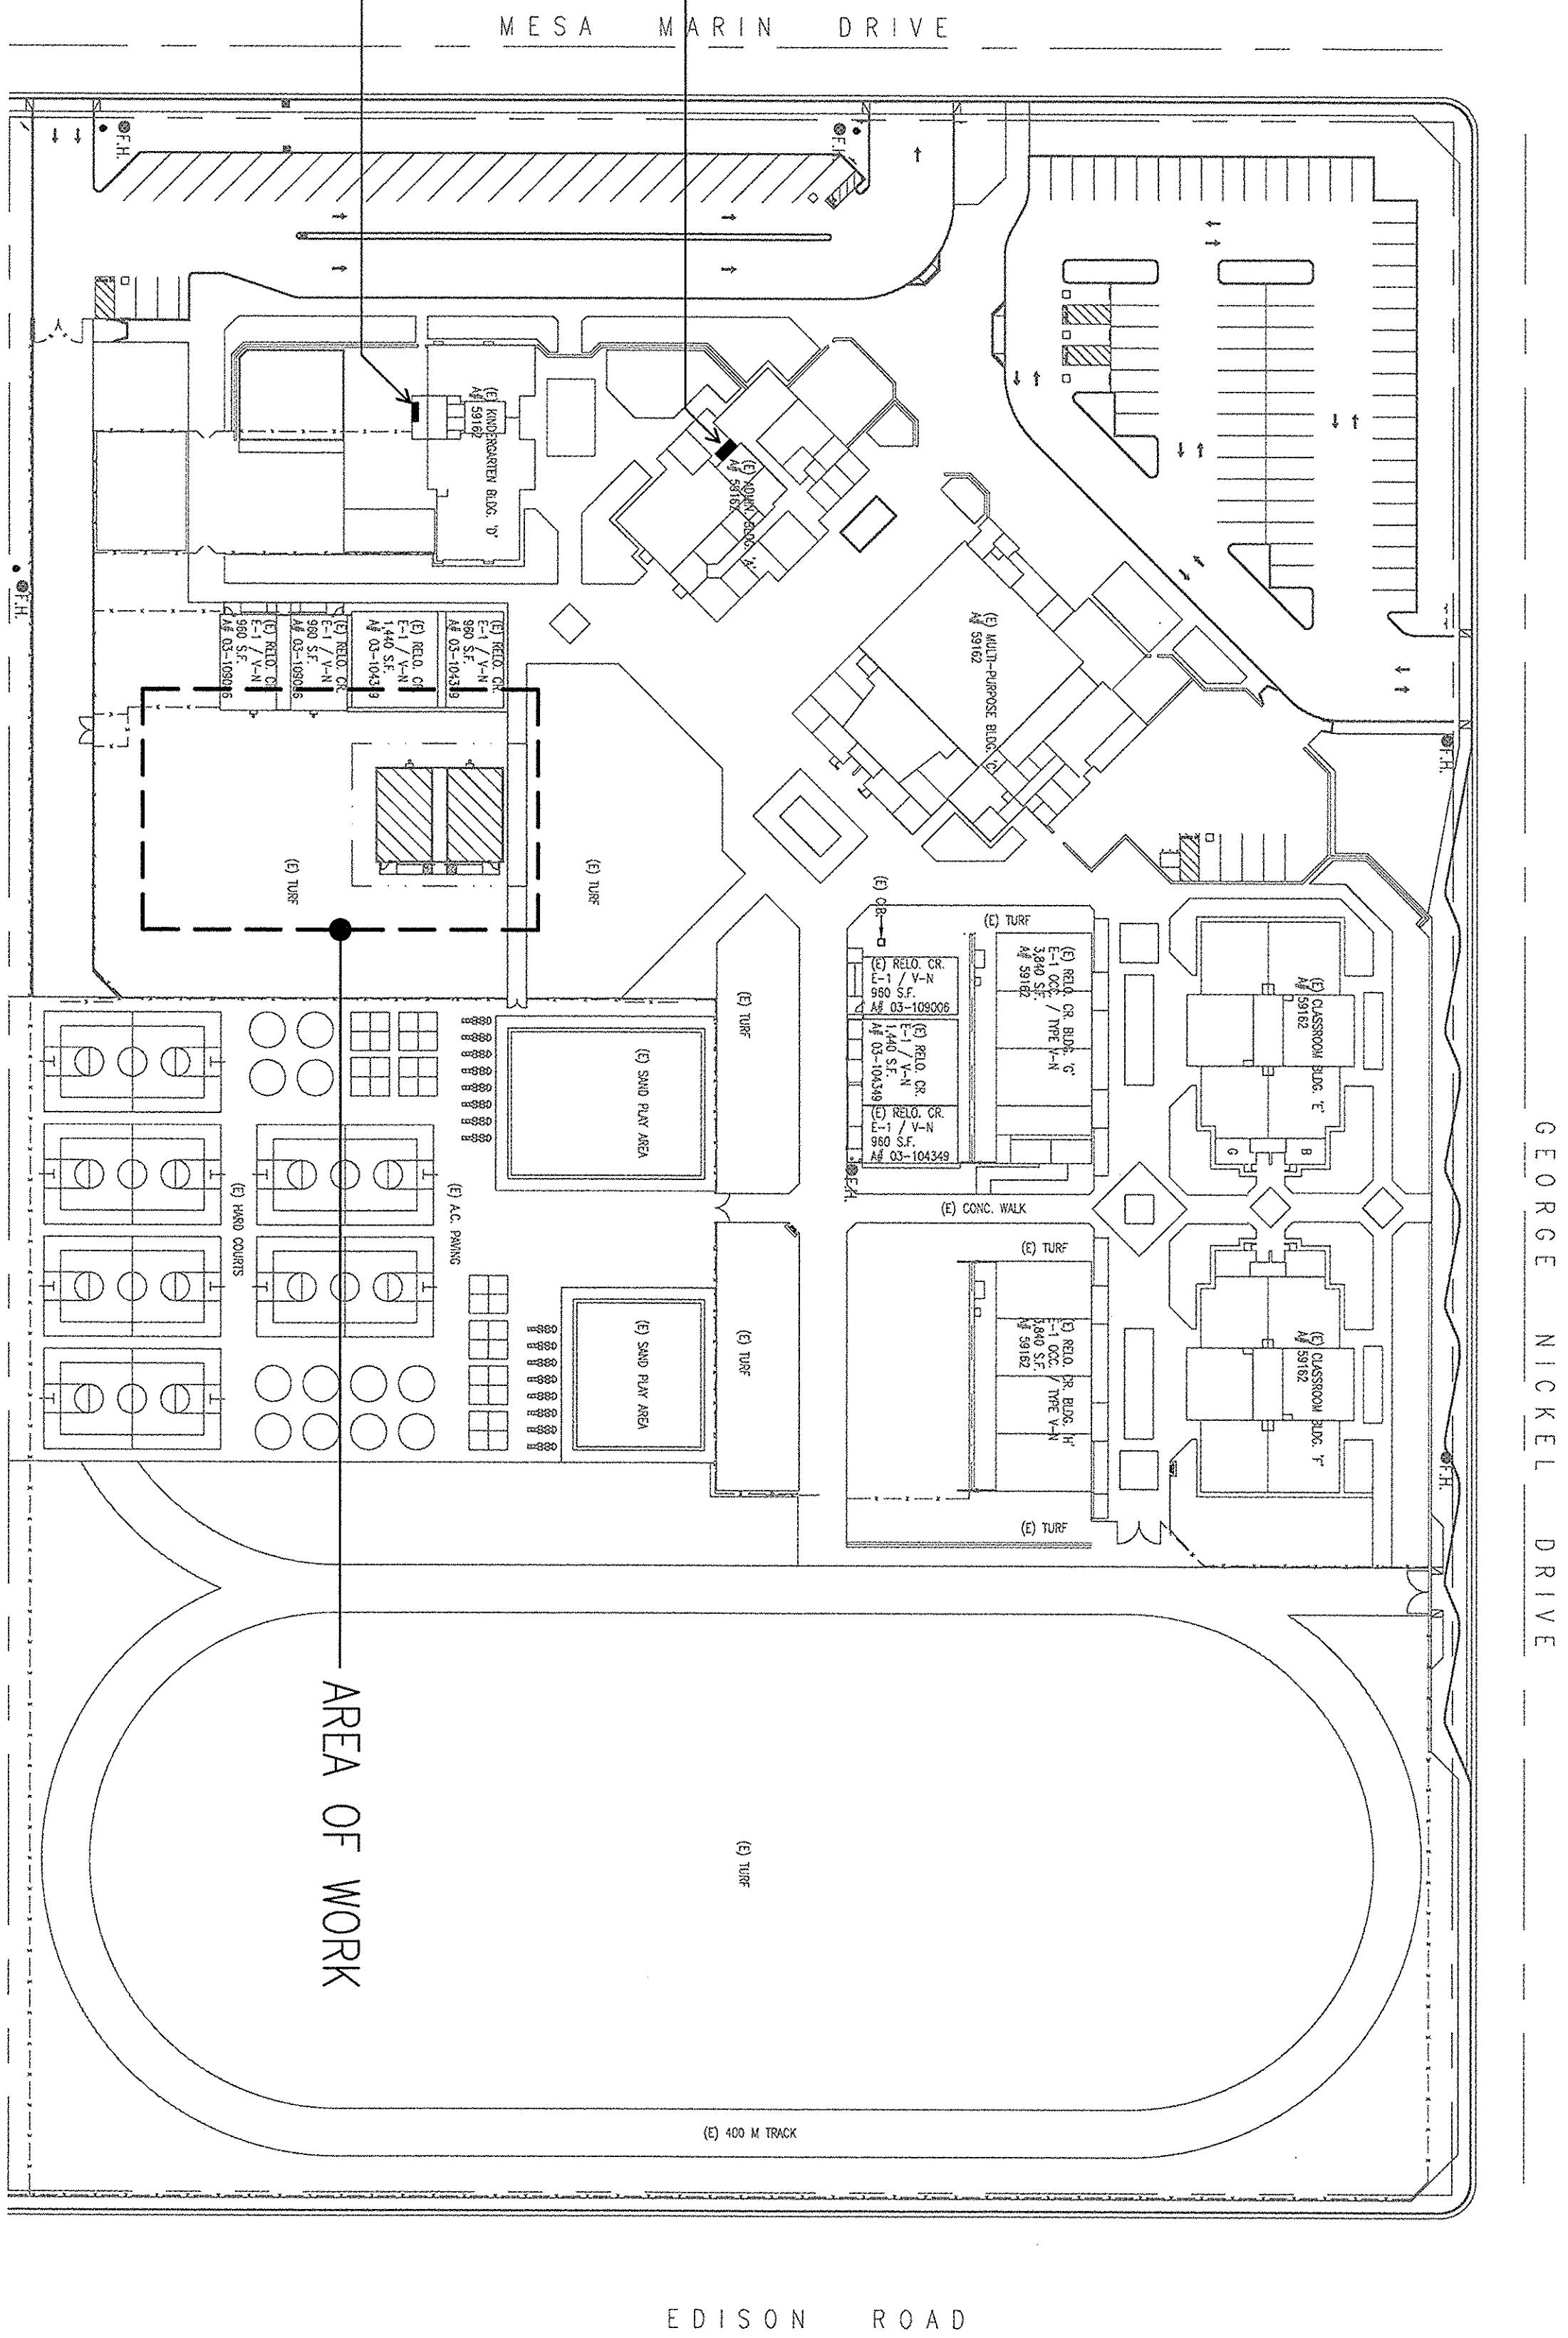

SITE PLAN - CHAVEZ ELEMENTARY SCHOOL

SCALE: 1/8" = 1'-0"

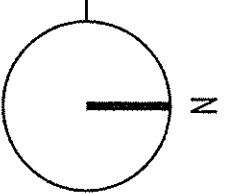

KEYPLAN

SCALE: N.T.S.

