



NUMBERED NOTES


- 1 MAKE POC BELOW GRADE TO (E) CW WITH NEW FITTINGS AND RUN NEW WATER PIPING BELOW GRADE WITH SIZE AS INDICATED. VERIFY LOCATION.
- 2 INSTALL SOV IN YARD BOX AND CONNECT 3/4" CW AND 2" W TO BUILDING UTILITY SUB-OUTS.
- 3 RUN NEW 4" WASTE LINE BELOW GRADE AT 2% SLOPE AND MAKE POC BELOW GRADE TO (E) 4" SEWER LINE WITH NEW WES AND ADAPTORS AS NECESSARY. VERIFY PIPE SIZE, LOCATION AND INVERT ELEVATION.
- 4 WALL MOUNTED HEAT PUMP FINISHED AND INSTALLED WITH RELO. BUILDING (TRP). CONNECT 1" CD WITH TRAP & VENT STUB, AND DROP DOWN TO BELOW GRADE. SEE DETAIL P1.07
- 5 RUN 1" CD BELOW GRADE AT 2% SLOPE AND SPILL INTO DRYWELL. FOR DRYWELL SEE DETAIL P1.07

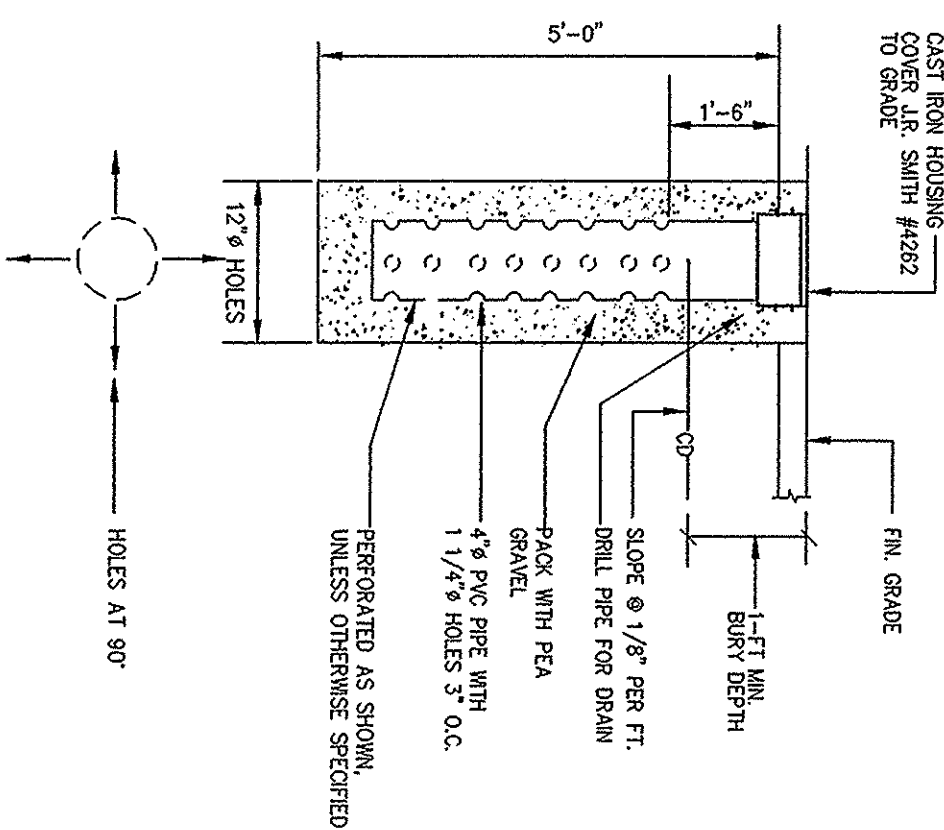

DRYWELL DETAIL
NOT TO SCALE
P1.07

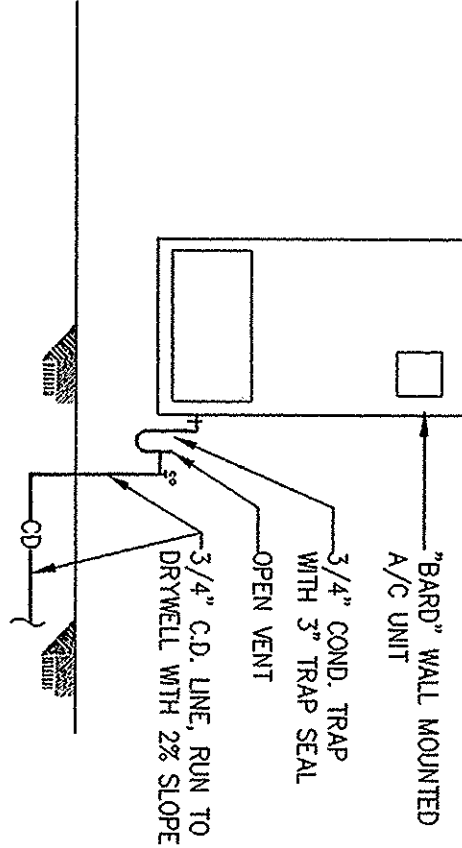

COND. DRAIN CONNECTION DETAIL
NOT TO SCALE
P1.07

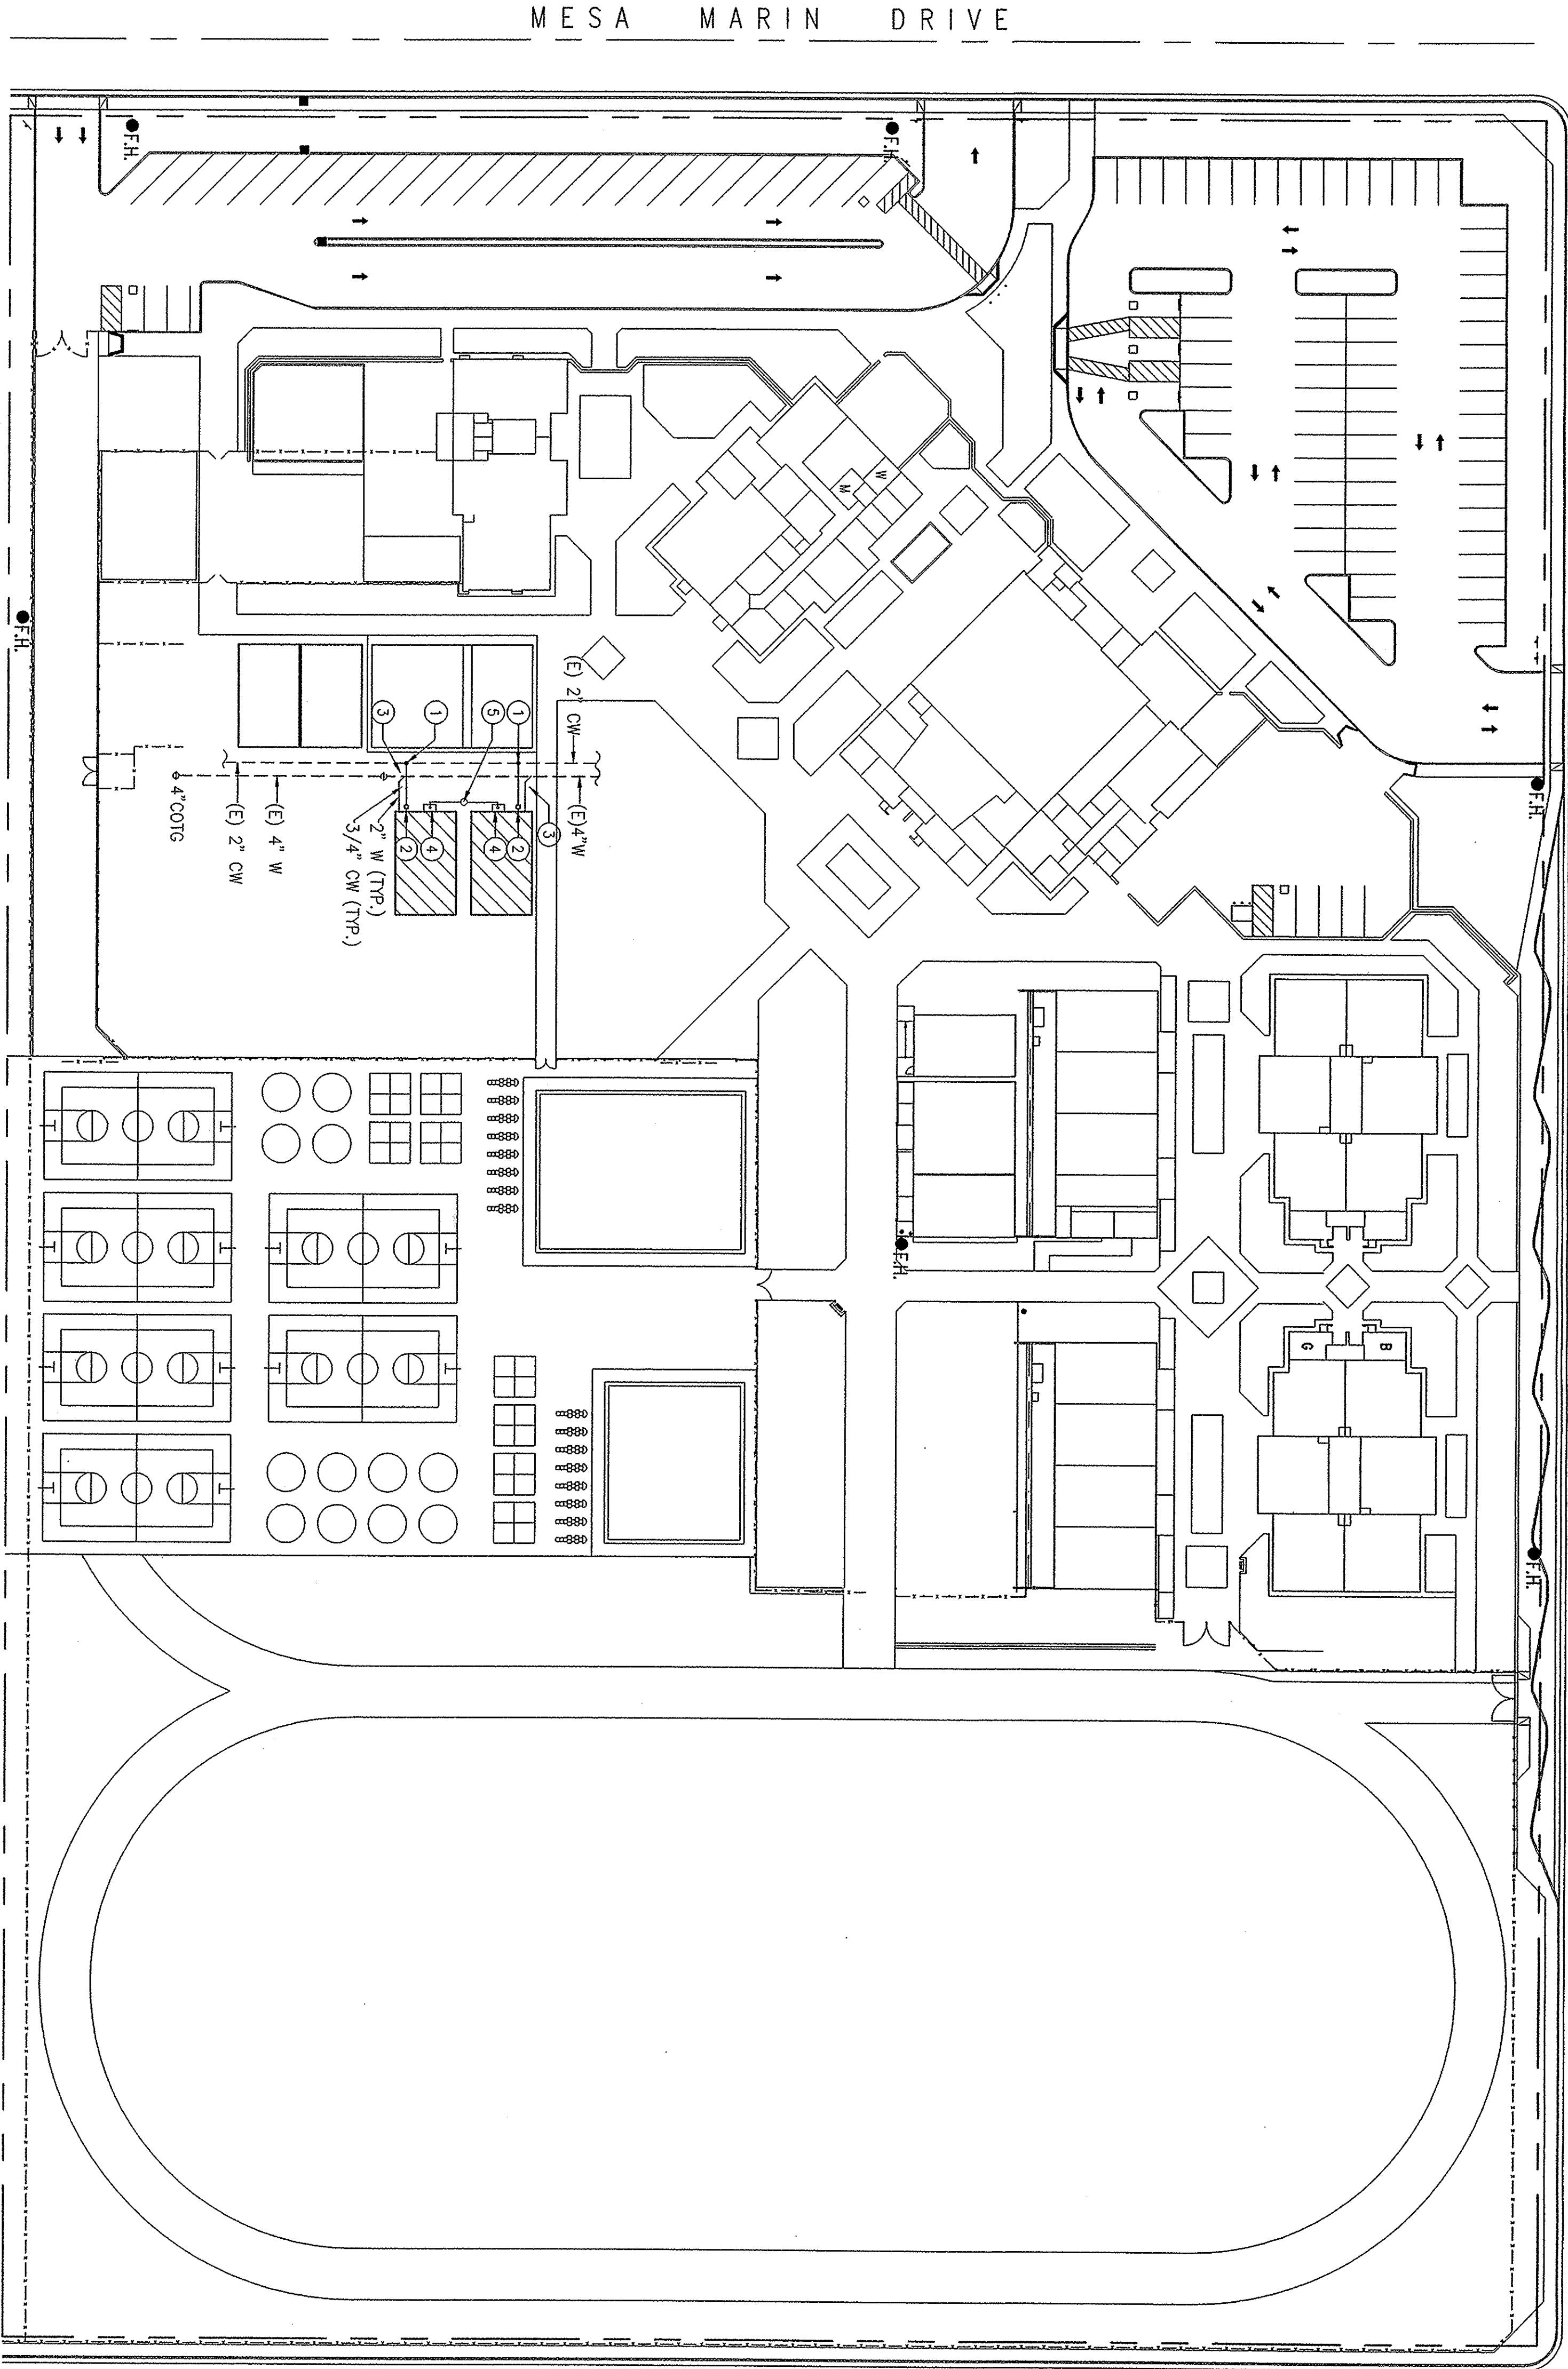


PLUMBING SITE PLAN - CHAVEZ ELEMENTARY SCHOOL
SCALE: 1" = 40'-0"

LEGEND:

- (E)--- EXISTING PIPING
- CW--- COLD WATER
- W--- WASTE, SANITARY SEWER
- POC--- POINT OF CONNECTION
- SOV--- SHUT OFF VALVE
- CDTG--- CLEANOUT TO GRADE

NOTE:

-VERIFY LOCATION OF EXISTING PLUMBING SERVICES BEFORE STARTING ANY TRENCHING AND NEW PLUMBING WORK.
-COORDINATE ALL UNDERGROUND UTILITY LOCATIONS WITH OTHER TRADES TO MINIMIZE POTENTIAL CONFLICT OF SITE DRAINAGE, ELECTRICAL, ETC.
-CUTTING, BORING, SAW CUTTING OR DRILLING THROUGH THE NEW OR EXISTING STRUCTURAL ELEMENTS TO BE DONE ONLY WHEN SO DETAILED IN THE DRAWINGS OR ACCEPTED BY THE ARCHITECT AND STRUCTURAL ENGINEER WITH THE APPROVAL OF DSA REPRESENTATIVE.


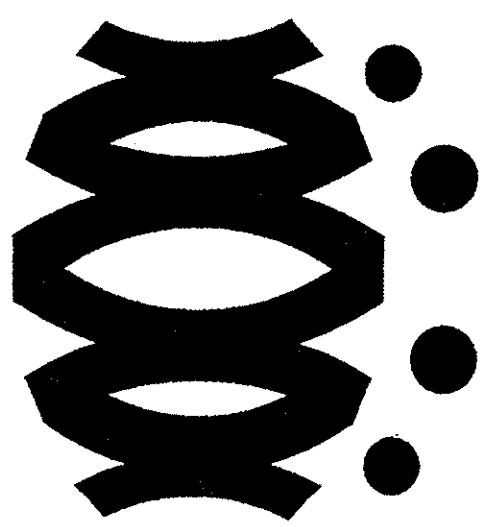


FLEWELLING & MOODY
architects + education

HEADQUARTERS OFFICE:
14100 Wilshire Boulevard
Suite 200
Beverly Hills, CA 90210
Tel: 310.274.8877 FAX: 310.274.8877
Email: info@flewellingmoody.com

ANTIOCH WAREHOUSE OFFICE:
1005 West 10th Street
Antioch, CA 94509
Tel: 925.706.0771 FAX: 925.706.0771
Email: info@flewellingmoody.com

All Projects Owned Corporation

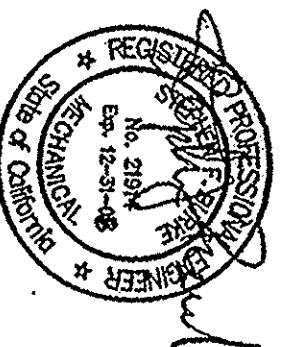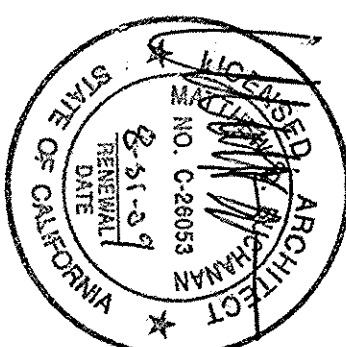

IDENTIFICATION STAMP
DIV. OF THE STATE ARCHITECT
APR 03 11 11 193
ADLTSCHS
DATE 10/1/2007

Drawn by	CE	
Checked by	—	
Revisions		
No.	Date	Description
—	—	—

BAKERSFIELD CITY SCHOOL DISTRICT
2237
10-1-2007
P1.02

PLUMBING
SITE PLAN