
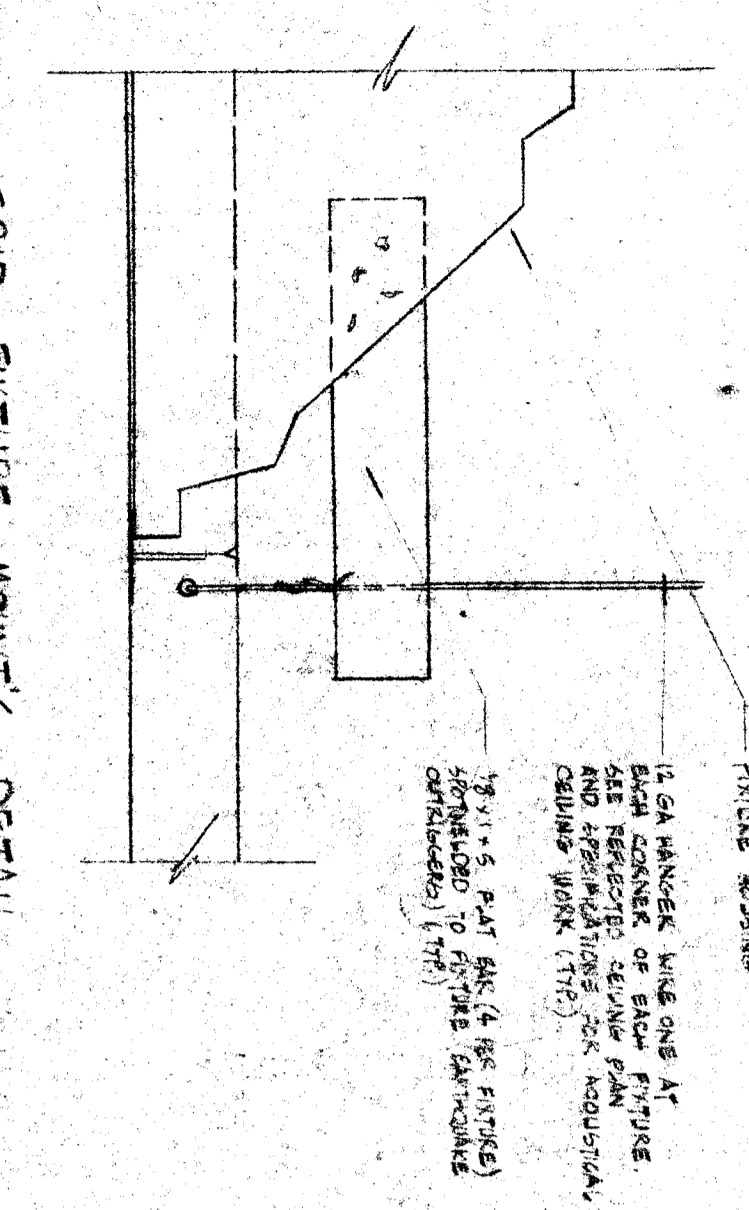


SCHEDULE:

ITEM	QTY	DESCRIPTION	UNIT	FINISH
1	1	TERMINAL CABINET	EA	PAINT TO MATCH
2	1	TERMINAL CABINET	EA	PAINT TO MATCH
3	1	TERMINAL CABINET	EA	PAINT TO MATCH
4	1	TERMINAL CABINET	EA	PAINT TO MATCH
5	1	TERMINAL CABINET	EA	PAINT TO MATCH
6	1	TERMINAL CABINET	EA	PAINT TO MATCH
7	1	TERMINAL CABINET	EA	PAINT TO MATCH
8	1	TERMINAL CABINET	EA	PAINT TO MATCH
9	1	TERMINAL CABINET	EA	PAINT TO MATCH
10	1	TERMINAL CABINET	EA	PAINT TO MATCH
11	1	TERMINAL CABINET	EA	PAINT TO MATCH
12	1	TERMINAL CABINET	EA	PAINT TO MATCH
13	1	TERMINAL CABINET	EA	PAINT TO MATCH
14	1	TERMINAL CABINET	EA	PAINT TO MATCH
15	1	TERMINAL CABINET	EA	PAINT TO MATCH
16	1	TERMINAL CABINET	EA	PAINT TO MATCH
17	1	TERMINAL CABINET	EA	PAINT TO MATCH
18	1	TERMINAL CABINET	EA	PAINT TO MATCH
19	1	TERMINAL CABINET	EA	PAINT TO MATCH
20	1	TERMINAL CABINET	EA	PAINT TO MATCH

- NOTES:
1. REFER TO ALL DIMENSIONS ON DRAWINGS.
 2. ALL DIMENSIONS ARE IN FEET AND INCHES.
 3. ALL MATERIALS ARE TO BE OF THE BEST QUALITY AVAILABLE.
 4. ALL WORK IS TO BE ACCORDANCE WITH THE LATEST EDITIONS OF THE NATIONAL ELECTRICAL CODE, THE NATIONAL FIRE ALARM CODE, AND THE NATIONAL BROADCASTING CODE.
 5. ALL WORK IS TO BE ACCORDANCE WITH THE LATEST EDITIONS OF THE NATIONAL ELECTRICAL CODE, THE NATIONAL FIRE ALARM CODE, AND THE NATIONAL BROADCASTING CODE.

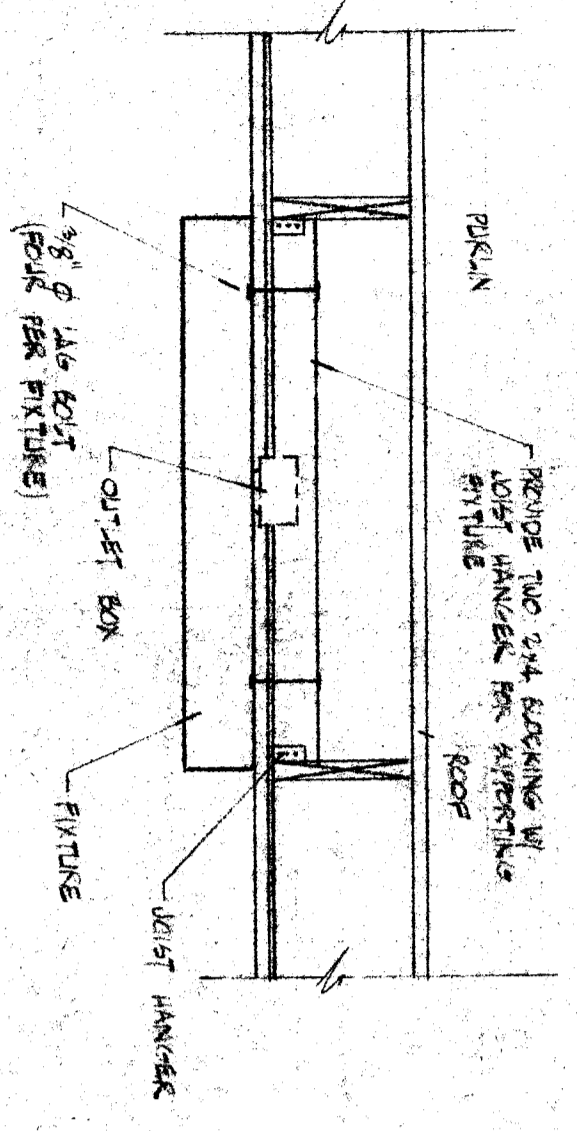


PANEL A SCHEDULE

QTY	UNIT	DESCRIPTION
1	EA	WALL LIGHT
2	EA	WALL LIGHT
3	EA	WALL LIGHT
4	EA	WALL LIGHT
5	EA	WALL LIGHT
6	EA	WALL LIGHT
7	EA	WALL LIGHT
8	EA	WALL LIGHT
9	EA	WALL LIGHT
10	EA	WALL LIGHT
11	EA	WALL LIGHT
12	EA	WALL LIGHT
13	EA	WALL LIGHT
14	EA	WALL LIGHT
15	EA	WALL LIGHT
16	EA	WALL LIGHT
17	EA	WALL LIGHT
18	EA	WALL LIGHT
19	EA	WALL LIGHT
20	EA	WALL LIGHT

PANEL B SCHEDULE

QTY	UNIT	DESCRIPTION
1	EA	WALL LIGHT
2	EA	WALL LIGHT
3	EA	WALL LIGHT
4	EA	WALL LIGHT
5	EA	WALL LIGHT
6	EA	WALL LIGHT
7	EA	WALL LIGHT
8	EA	WALL LIGHT
9	EA	WALL LIGHT
10	EA	WALL LIGHT
11	EA	WALL LIGHT
12	EA	WALL LIGHT
13	EA	WALL LIGHT
14	EA	WALL LIGHT
15	EA	WALL LIGHT
16	EA	WALL LIGHT
17	EA	WALL LIGHT
18	EA	WALL LIGHT
19	EA	WALL LIGHT
20	EA	WALL LIGHT

FLOOR PLAN - LIGHTING LAYOUT
SCALE: 1/8" = 1'-0"

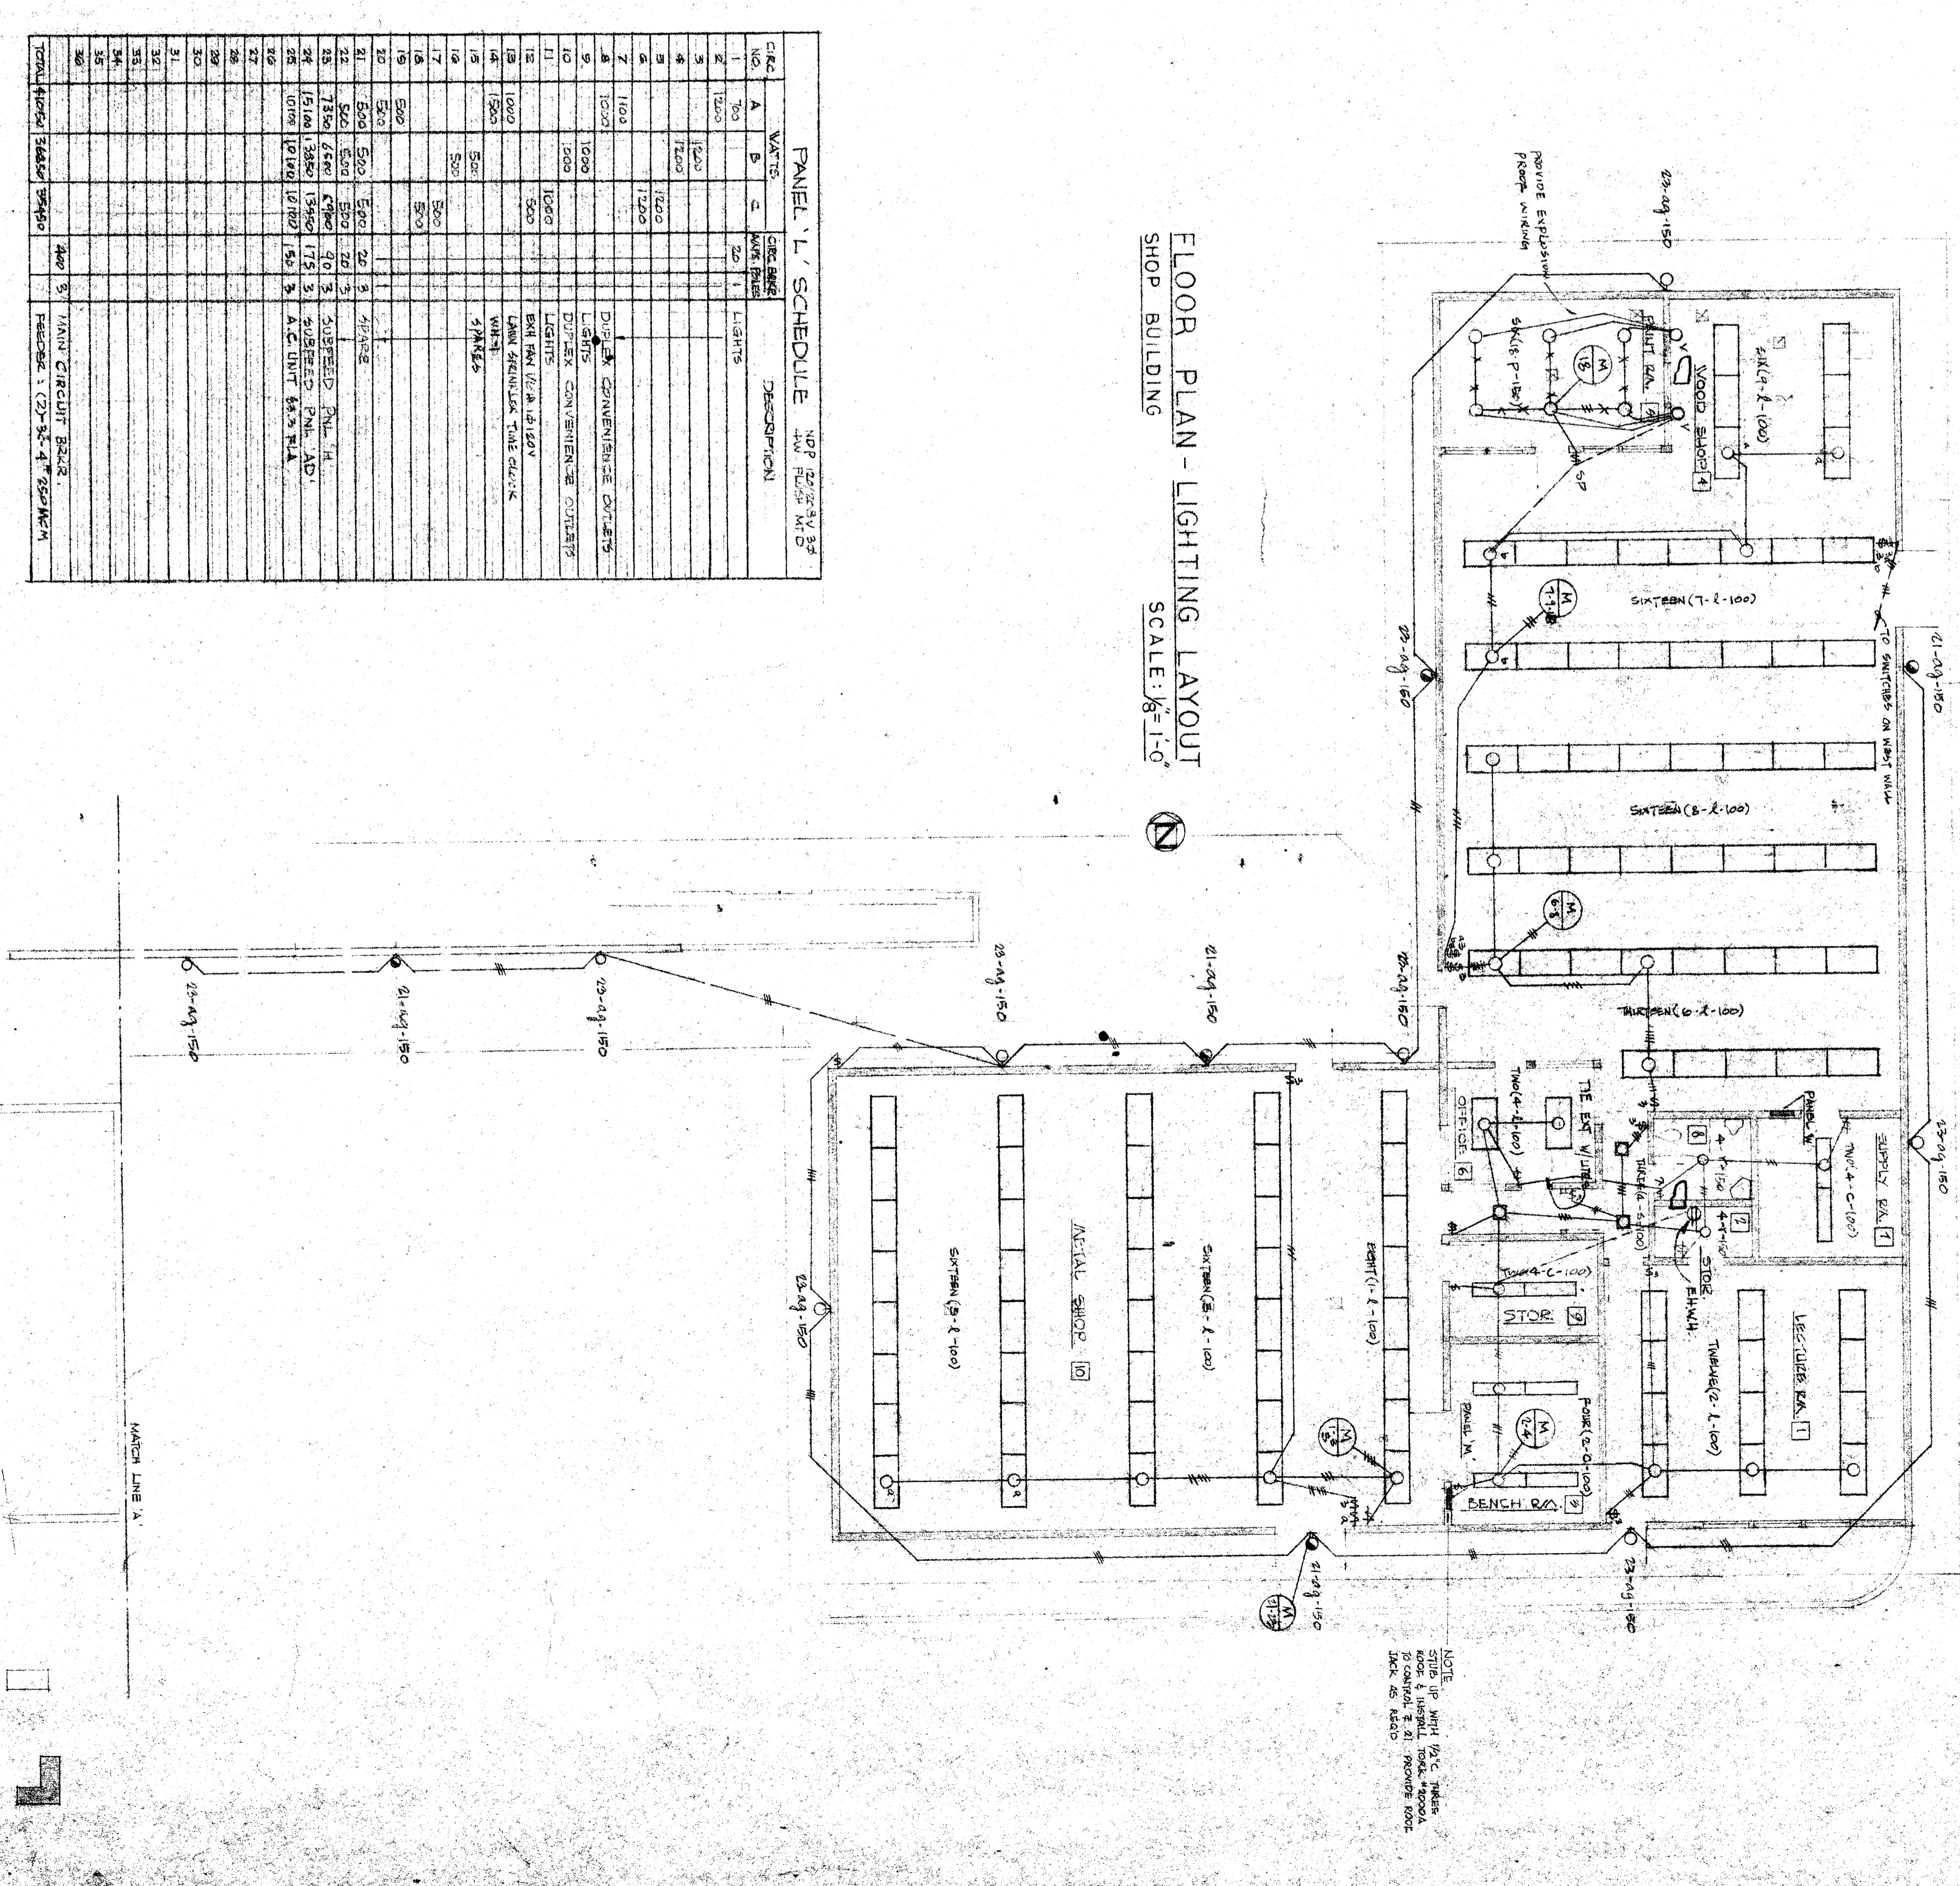

CHECK AND VERIFY ALL DIMENSIONS AND CONDITIONS AT JOB SITE BEFORE PROCEEDING WITH THE WORK. REPORT ANY DISCREPANCIES TO THE ARCHITECT.	DATE: APR 23, 1988
	BY: [Signature]
STATE OF CALIFORNIA STATE FIRE MARSHAL APPROVED UNDER STRUTTS OF CALIFORNIA	DATE: APR 23, 1988
APPROVED - DATE	APPROVED - DATE
EDWARD LOWE ELECTRICAL ENGINEER 502 WEST 1ST STREET SANTA ANA, CALIFORNIA	ERNEST L. MCROY AIA ARCHITECT 2411 H STREET BAKERSFIELD
BERNICE HARELL CHIPMAN JUNIOR HIGH SCHOOL BAKERSFIELD CITY SCHOOL DISTRICT BAKERSFIELD, CALIFORNIA	PROJECT NO. 1000

SHOP LIGHTING PLAN