


CHECK AND VERIFY ALL DIMENSIONS AND CONDITIONS AT JOB SITE BEFORE PROCEEDING WITH THE WORK. REPORT ANY DISCREPANCIES TO THE ARCHITECT. DRAWN: [Signature] DATE: APR 27 1960
 STATE OF CALIFORNIA
 STATE FIRE MARSHAL
 BAKERSFIELD CITY SCHOOL DISTRICT
 BAKERSFIELD, CALIFORNIA
 APPROVED - DATE: [Signature] DATE: [Blank]
 EDWARD LOWE
 ELECTRICAL ENGINEER
 2811 H STREET
 BAKERSFIELD, CALIFORNIA
 ERNEST L. MCCOY AIA ARCHITECT
 2811 H STREET
 BAKERSFIELD, CALIFORNIA
 BERNICE HARELL CHIPMAN
 JUNIOR HIGH SCHOOL
 BAKERSFIELD CITY SCHOOL DISTRICT
 BAKERSFIELD, CALIFORNIA
 SHEET NO. 10 OF 10
 DATE: APR 27 1960

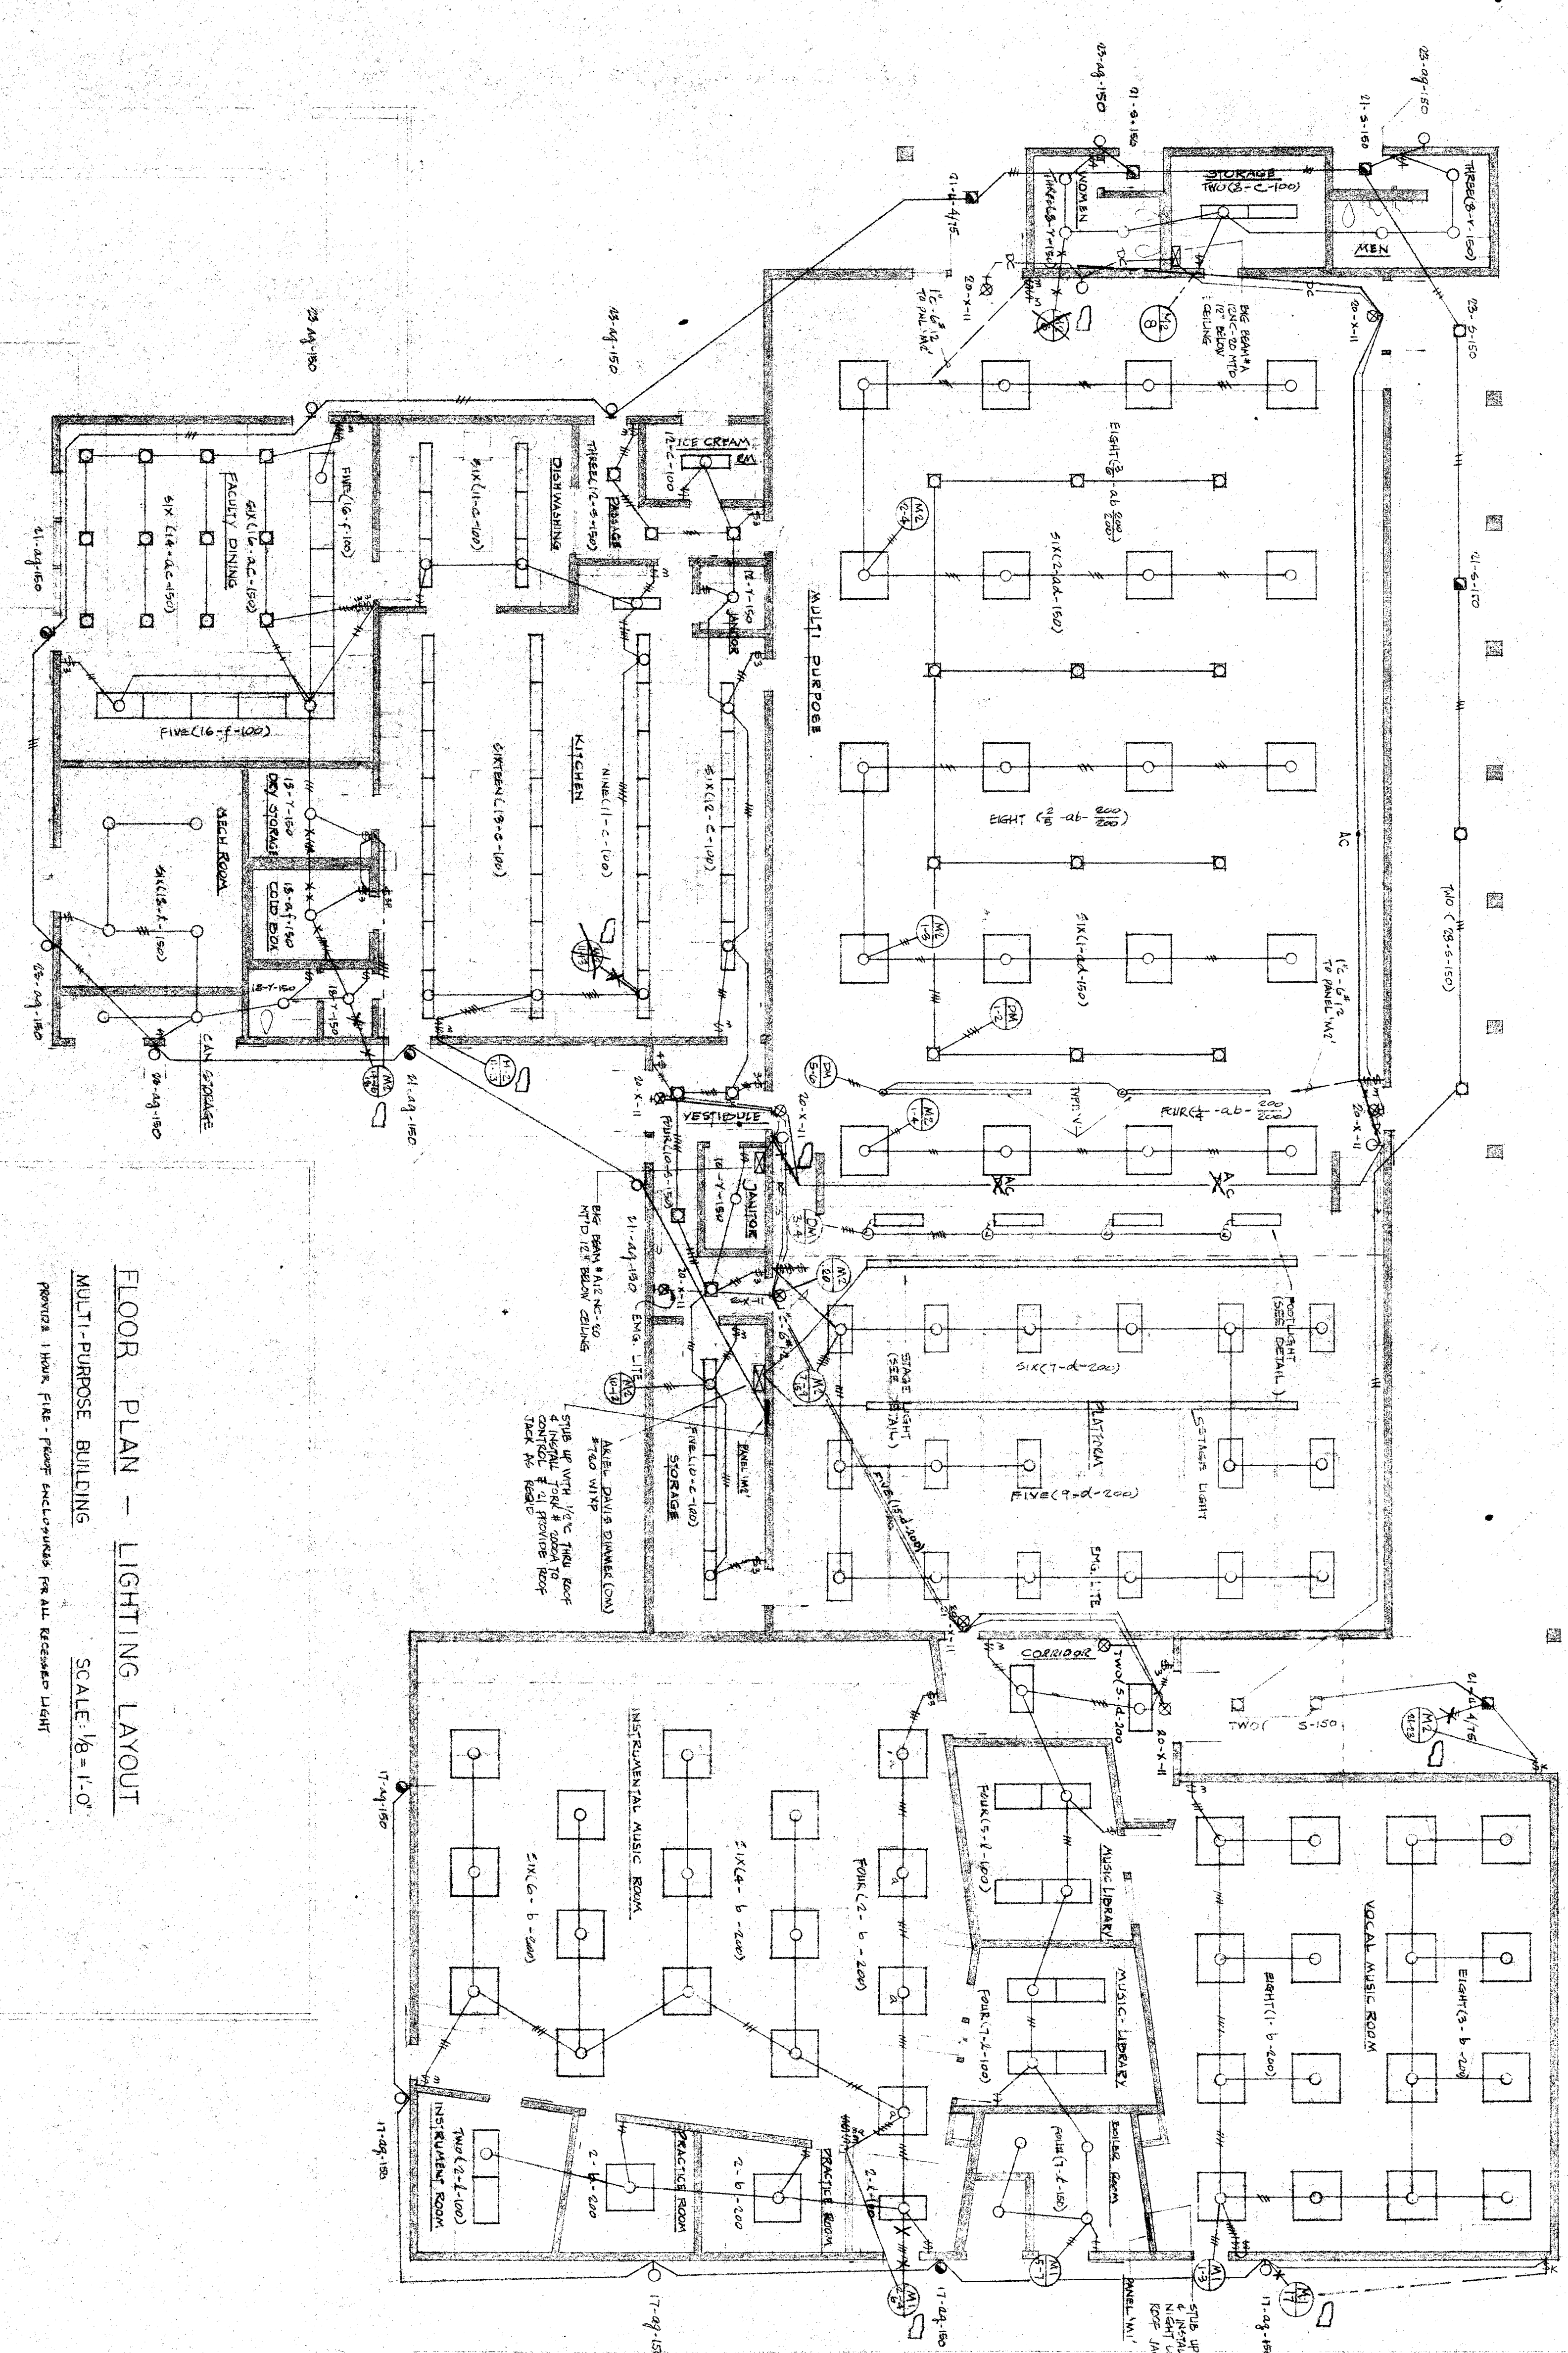

FLOOR PLAN - LIGHTING LAYOUT
 MULTI-PURPOSE BUILDING
 SCALE 1/8" = 1'-0"
 PROVIDE THREE FIVE-FOOT RECESSED PANEL RECESSED LIGHT

PANEL 'A1' SCHEDULE

NO.	WATTAGE	TYPE	DESCRIPTION
1	1000	FLUO	FLUORESCENT LIGHT
2	500	FLUO	FLUORESCENT LIGHT
3	1000	FLUO	FLUORESCENT LIGHT
4	1000	FLUO	FLUORESCENT LIGHT
5	1000	FLUO	FLUORESCENT LIGHT
100	1000	FLUO	FLUORESCENT LIGHT

PANEL 'A2' SCHEDULE

NO.	WATTAGE	TYPE	DESCRIPTION
1	1000	FLUO	FLUORESCENT LIGHT
2	1000	FLUO	FLUORESCENT LIGHT
3	1000	FLUO	FLUORESCENT LIGHT
100	1000	FLUO	FLUORESCENT LIGHT

