



TYPE	PLACEMENT	QUANTITY	WATTAGE
A	222 Pkg. 1 1/2 x 1 1/2	10	15-watt
B	200 Pkg. 1 1/2 x 1 1/2	6	15-watt
C	41-84 1 1/2 x 1 1/2	3	15-watt
D	BIT CHAIN/ PENDANT	4	15-watt
E	300 Pkg. 1 1/2 x 1 1/2	2	15-watt
F	100 Pkg. 1 1/2 x 1 1/2	2	15-watt

- NOTES:
1. REMOVED WALL REMOVED DIM. CHANNEL MOUNT.
  2. DIM. 1 1/2 x 1 1/2 x 1 1/2.
  3. DIM. 1 1/2 x 1 1/2 x 1 1/2.
  4. DIM. 1 1/2 x 1 1/2 x 1 1/2.

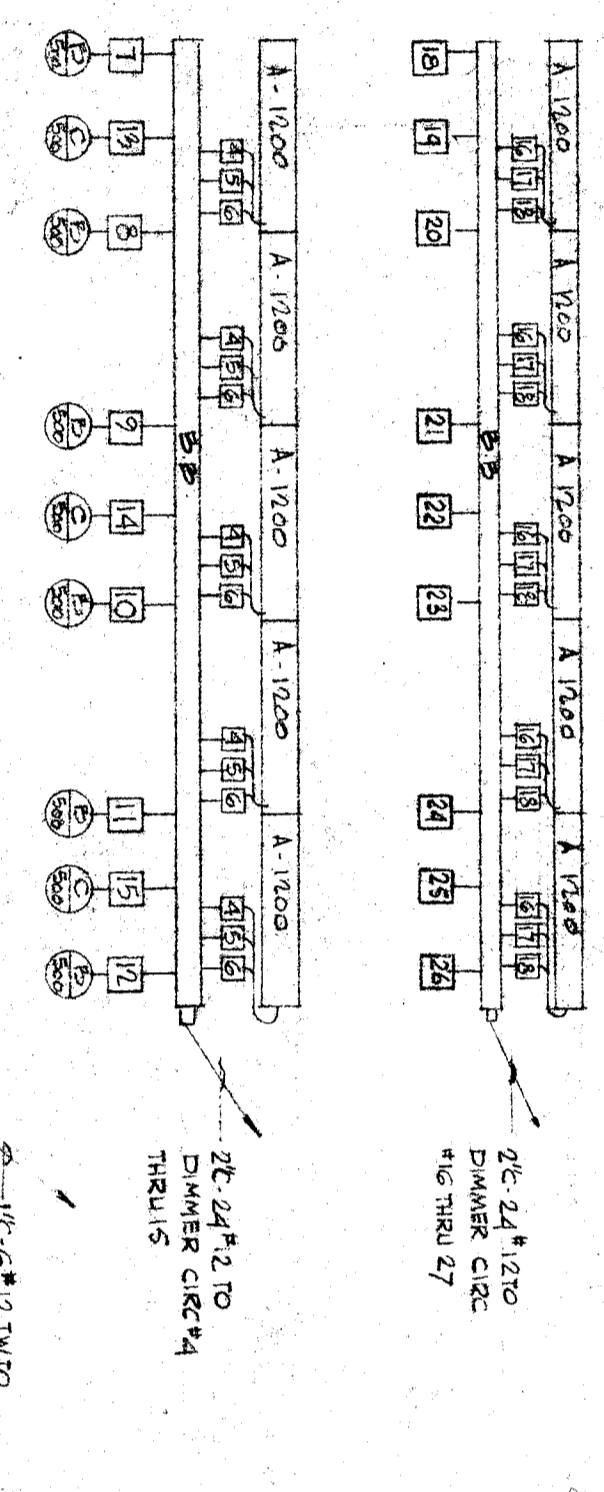

STAIR LIGHTING LINE DIAGRAM

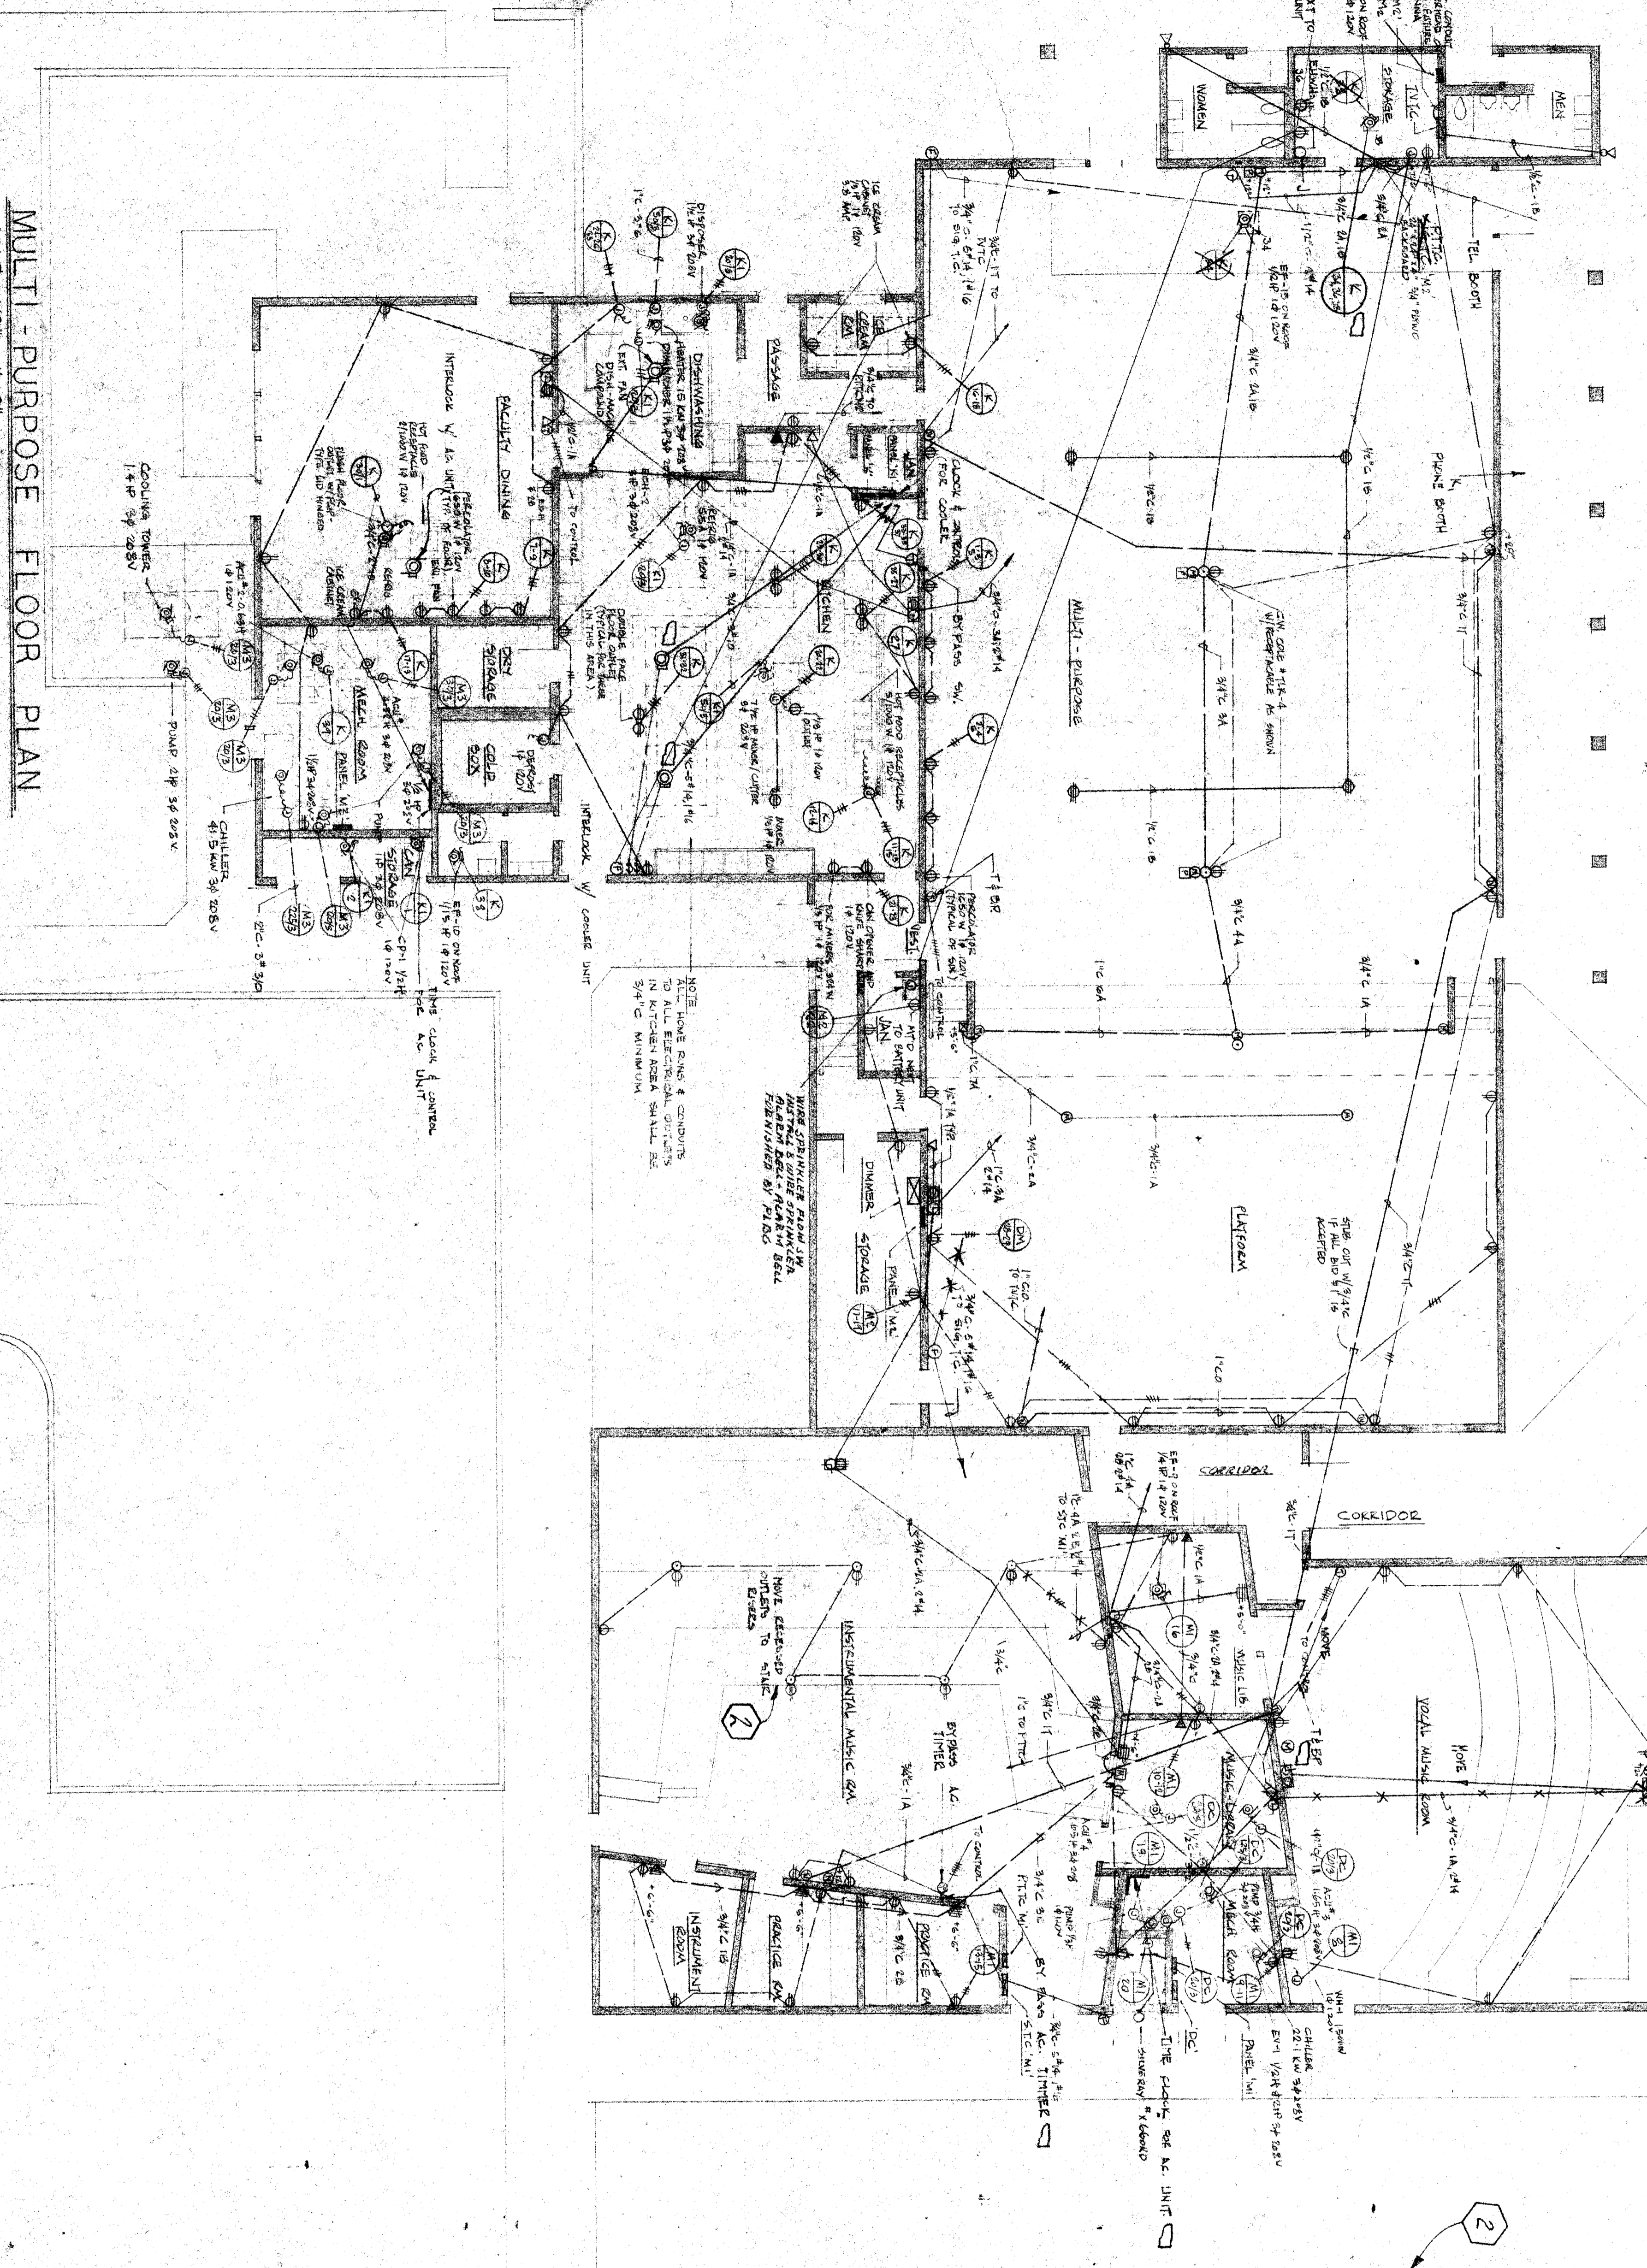

MULTI-PURPOSE FLOOR PLAN  
SCALE: 1/8" = 1'-0"

CIRCUIT	WATTS	DESCRIPTION
1	1000	OFFICE
2	1000	OFFICE
3	1000	OFFICE
100	1000	OFFICE

CIRCUIT	WATTS	DESCRIPTION
1	1000	OFFICE
2	1000	OFFICE
3	1000	OFFICE
100	1000	OFFICE

CHECK AND VERIFY ALL DIMENSIONS AND CONDITIONS AT JOB SITE BEFORE PROCEEDING WITH THE WORK. REPORT ANY DISCREPANCIES TO THE ARCHITECT.

REVISIONS:

NO.	DATE	DESCRIPTION
1	JUL 3 1958	AS BUILT
2	JUL 3 1958	ADDENDUM
3	JUL 3 1958	CHANGE ORDER

STATE OF CALIFORNIA  
STATE FIRE MARSHAL  
APPROVED: [Signature]  
DATE: JUL 3 1958

APPROVED: DATE

EDWARD LOWE  
ELECTRICAL ENGINEER  
2001 TULARE STREET  
FRESNO, CALIFORNIA

ERNEST L. MCCOY, AIA, ARCHITECT  
2811 N. STREET  
BAKERSFIELD

BERNICE HARELL CHIPMAN  
JUNIOR HIGH SCHOOL  
BAKERSFIELD CITY SCHOOL DISTRICT  
BAKERSFIELD, CALIFORNIA

MULTI-PURPOSE POWER PLAN