



FLOOR PLAN — LIGHTING LAYOUT
ADMINISTRATION BUILDING
SCALE: 1/4" = 1'-0"

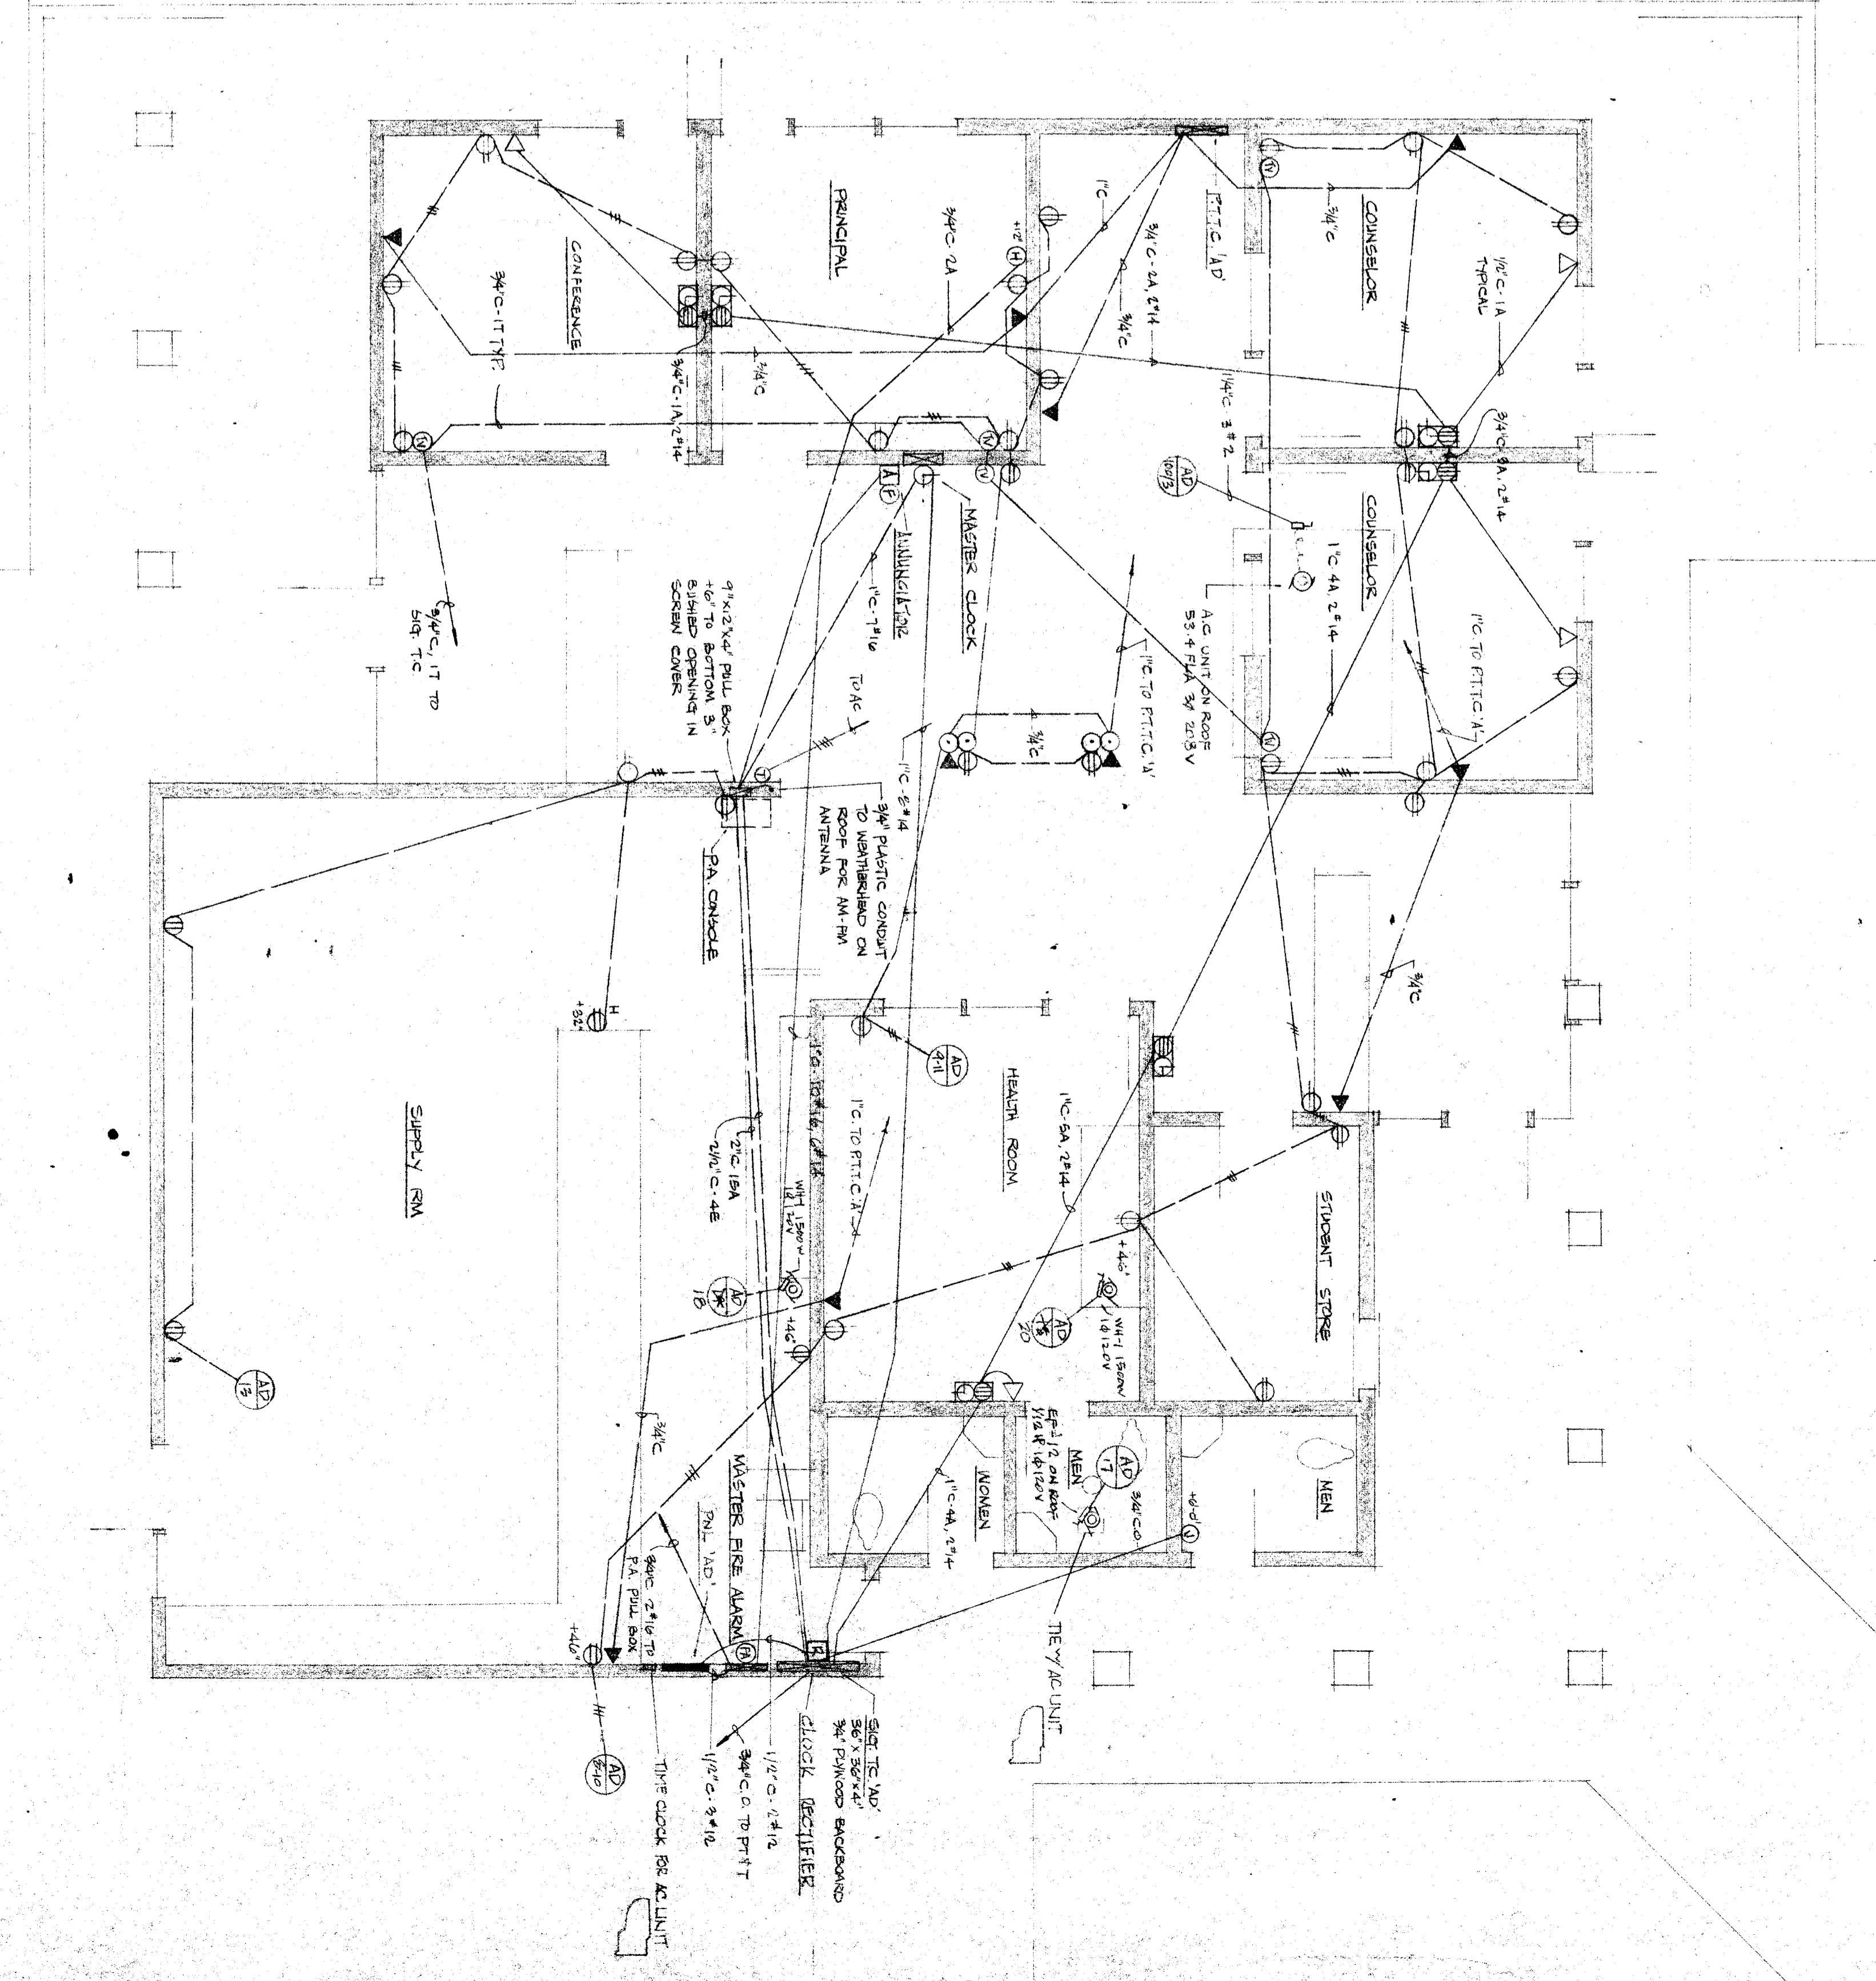

FLOOR PLAN — POWER LAYOUT
ADMINISTRATION BUILDING
SCALE: 1/4" = 1'-0"

CHECK AND VERIFY ALL DIMENSIONS AND CONDITIONS AT JOB SITE BEFORE PROCEEDING WITH THE WORK. REPORT ANY DISCREPANCIES TO THE ARCHITECT.		DRAWN	CHKD	DATE	APPROVED - DATE
R. E. V. I. S. I. O. N. S. BY: [Signature] AS BUILT APPROVED CHANGE ORDER CANCELLED REVISIONS	STATE OF CALIFORNIA STATE FIRE MARSHAL FRESNO COUNTY OFFICE DIVISION OF CALIFORNIA FIRE MARSHAL			APR 11 1958	APPROVED BY: BOARD OF EDUCATION BAKERSFIELD DISTRICT DATE: APR 11 1958 [Signature]
ERNEST L. MCROY AIA ARCHITECT 202 1/2 W. 11TH ST. BAKERSFIELD, CALIFORNIA		EDWARD LOWE ELECTRICAL ENGINEER FRESNO 202 1/2 W. 11TH ST. BAKERSFIELD, CALIFORNIA		ERNICE HARRELL CHIPMAN JUNIOR HIGH SCHOOL BAKERSFIELD CITY SCHOOL DISTRICT BAKERSFIELD, CALIFORNIA	

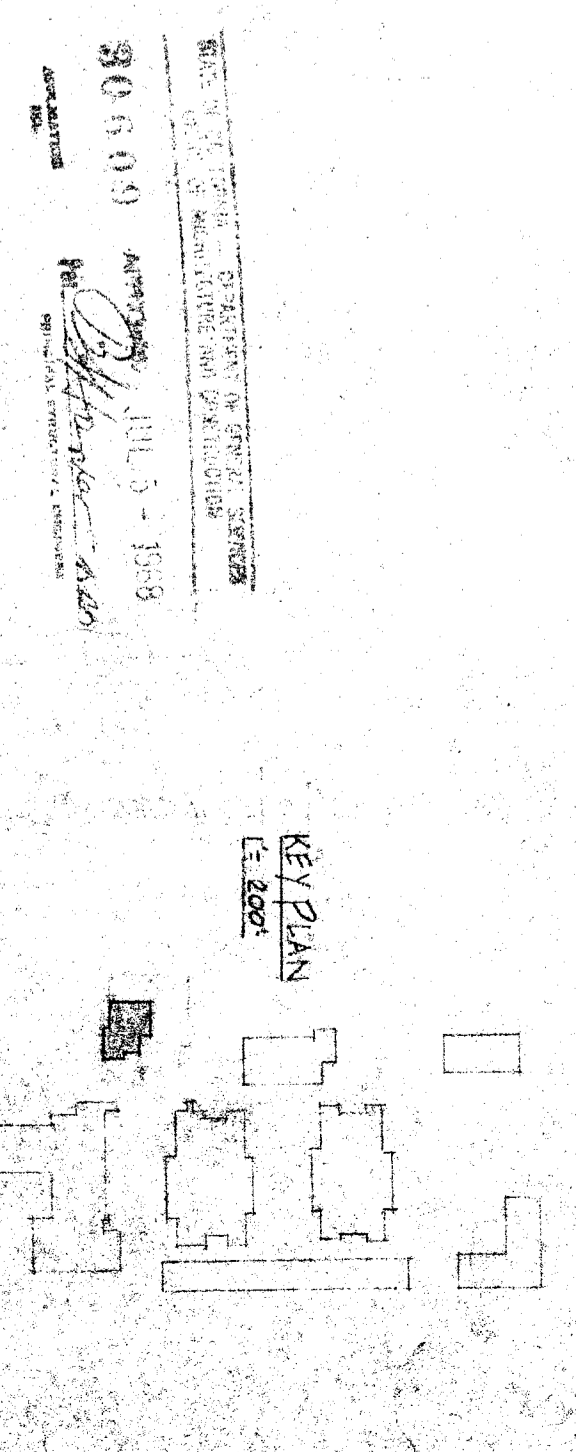

ADMINISTRATION BUILDING POWER & LIGHTING PLAN