

STATE OF CALIFORNIA  
 STATE FIRE MARSHAL  
 JUL 5 1938

REPORT ANY DISCREPANCIES TO THE ARCHITECT, DRAWN  
 DATE APR 21 1938

APPROVED BY  
 BAKERSFIELD CITY SCHOOL DISTRICT  
 DATE JUL 8 1938


APPROVED - DATE

EDWARD LOWE  
 ELECTRICAL ENGINEER  
 BAKERSFIELD CALIFORNIA

ERNEST L. MCGOY AIA ARCHITECT  
 BAKERSFIELD CALIFORNIA

BERNICE HARELL CHIPMAN  
 JUNIOR HIGH SCHOOL  
 BAKERSFIELD CITY SCHOOL DISTRICT  
 BAKERSFIELD CALIFORNIA

FLOOR PLAN - LIGHTING LAYOUT  
 ACADEMIC UNIT B  
 SCALE: 1/8" = 1'-0"

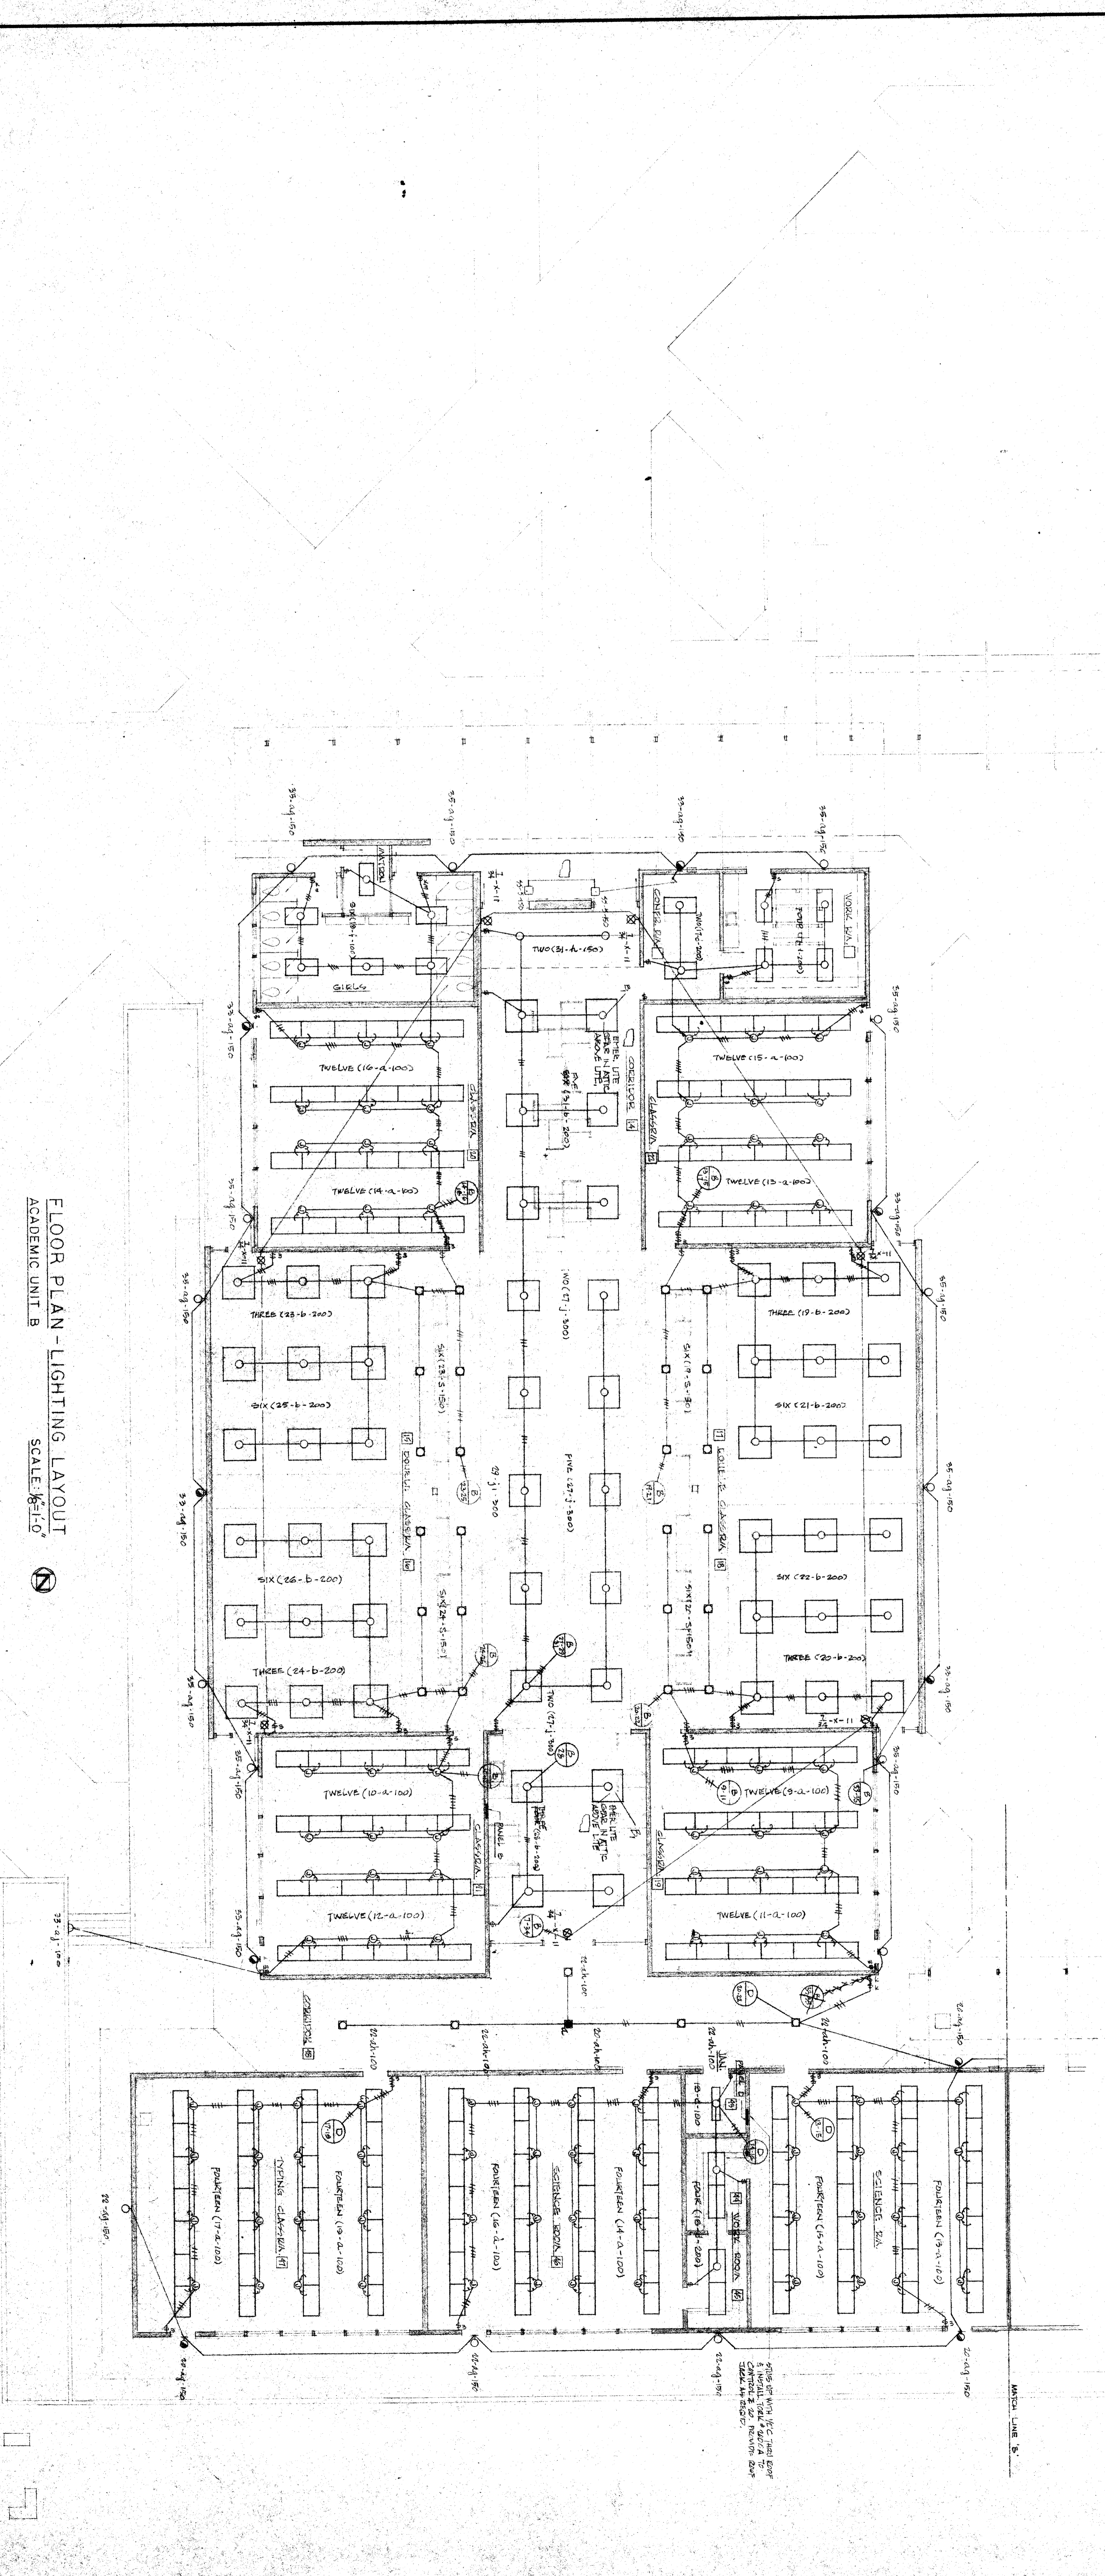

801109  
 JUL 5 1938  
 KEELAN

UNIT B LIGHTING PLAN

SHEET 18 OF 27