



CLASSROOMS & ACADEMIC UNITS A & B

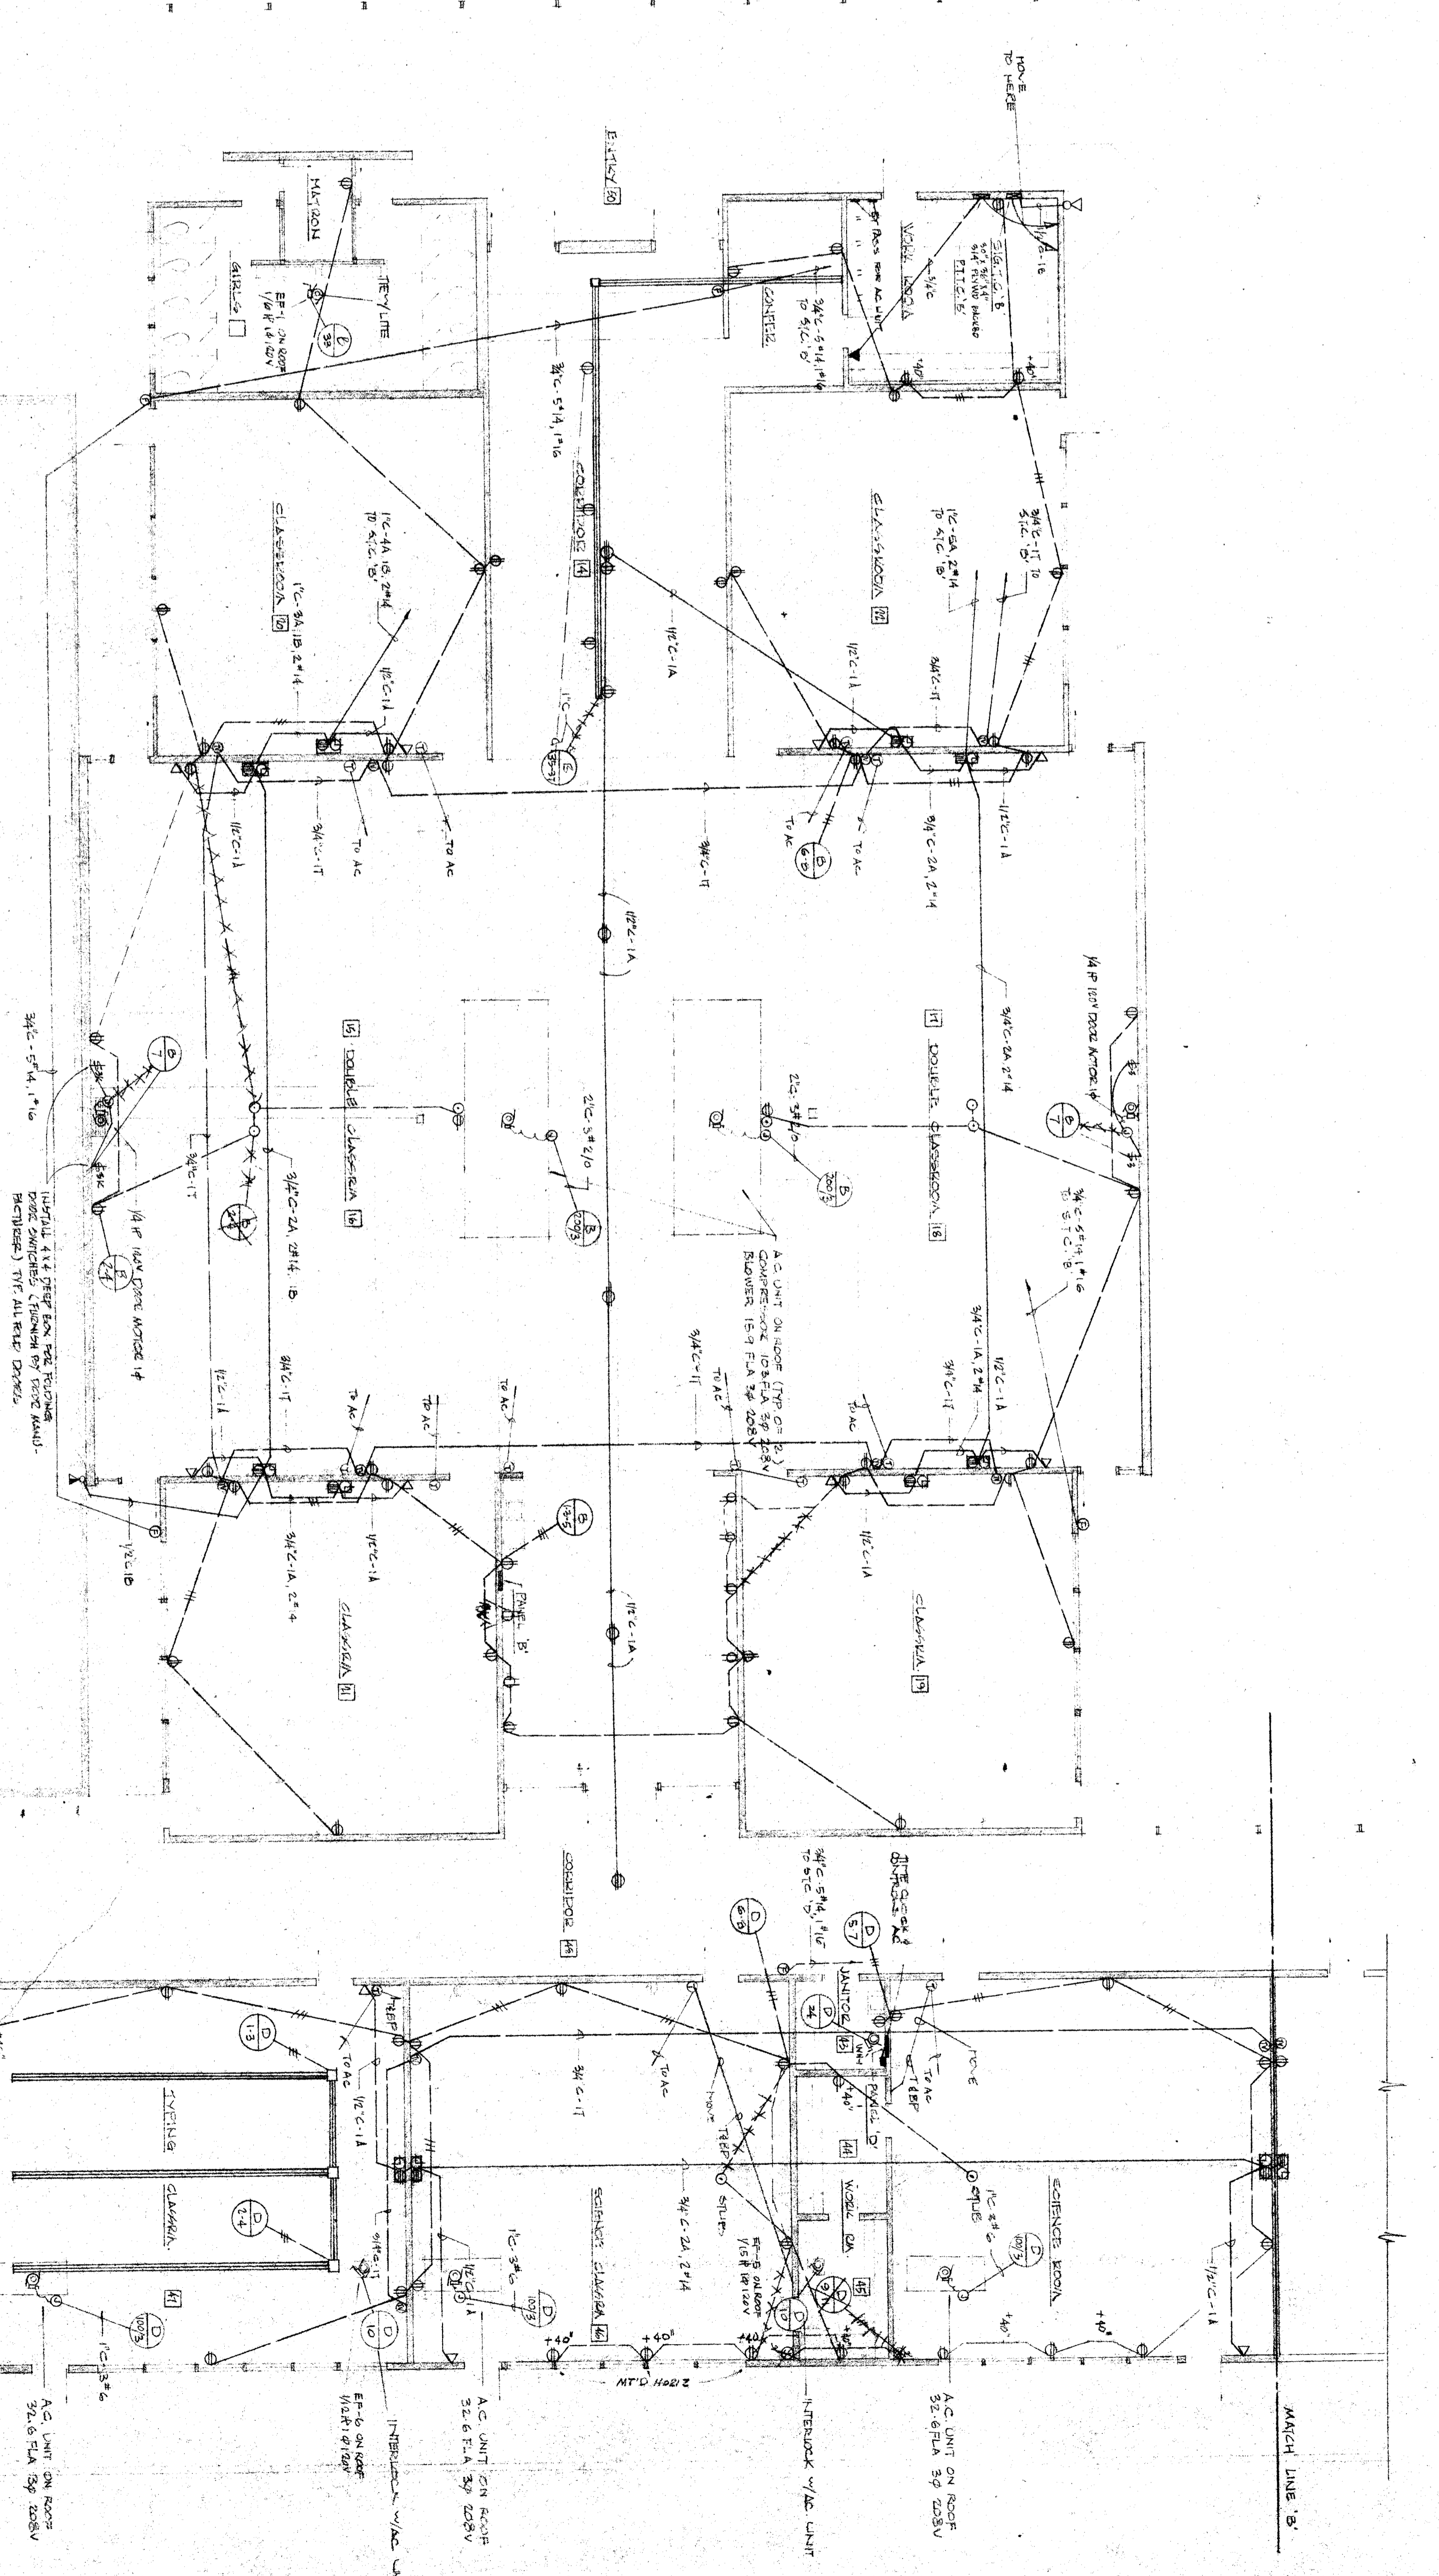

FLOOR PLAN - POWER LAYOUT
ACADEMIC UNIT B
SCALE: 3/8" = 1'-0"

INDICATION OF V. NOTES - SANZ
INDICATION

FIGURE 101 LEAD-OUT
+ TO ST. SANZ JUNK DUMP

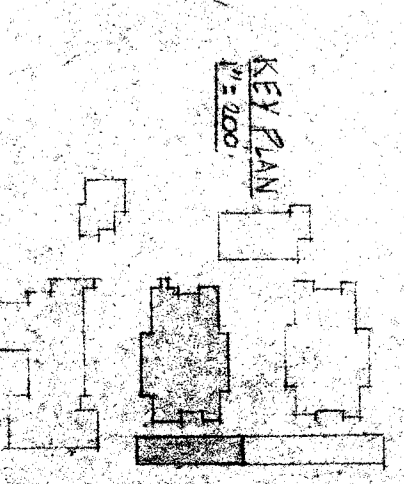

CHECK AND VERIFY ALL DIMENSIONS AND CONDITIONS AT JOB SITE BEFORE PROCEEDING WITH THE WORK. REPORT ANY DISCREPANCIES TO THE ARCHITECT.	DATE	APPROVED - DATE
	NOV 22 1953	
REVISIONS	STATE OF CALIFORNIA STATE FIRE MARSHAL APPROVED UNDER AUTHORITY OF CALIFORNIA FIRE MARSHAL	APPROVED - DATE
BY: AS SHOWN DATE: JUL 5 1953	BOARD OF SCHOOL EXAMINERS DATE: JUL 8 1953 OFFICE OF THE STATE ENGINEER DIVISION OF ELECTRICAL ENGINEERING	
CHANGES ORDER	EDWARD J. LONE ELECTRICAL ENGINEER 205 JEFFERSON AVENUE ALHAMBRA, CALIFORNIA	ENEST L. MCCOY A.I.A. ARCHITECT 301 1/2 STREET BAKERSFIELD, CALIFORNIA 93303
CLASSIFICATION	UNIT B POWER & SIGNAL PLAN	
SHEET NO. 67-B OF 12 SHEETS		