

DATE	APR 27 1959
BY	ERNEST L. MCCOY AIA
FOR	BERNICE HARELL CHIPMAN JUNIOR HIGH SCHOOL
PROJECT	PLUMBING FLOOR PLANS - SHOP & PE. BUILDING
SCALE	1/8" = 1'-0"

DATE	APR 27 1959
BY	ERNEST L. MCCOY AIA
FOR	BERNICE HARELL CHIPMAN JUNIOR HIGH SCHOOL
PROJECT	PLUMBING FLOOR PLANS - SHOP & PE. BUILDING
SCALE	1/8" = 1'-0"


DATE	APR 27 1959
BY	ERNEST L. MCCOY AIA
FOR	BERNICE HARELL CHIPMAN JUNIOR HIGH SCHOOL
PROJECT	PLUMBING FLOOR PLANS - SHOP & PE. BUILDING
SCALE	1/8" = 1'-0"

DATE	APR 27 1959
BY	ERNEST L. MCCOY AIA
FOR	BERNICE HARELL CHIPMAN JUNIOR HIGH SCHOOL
PROJECT	PLUMBING FLOOR PLANS - SHOP & PE. BUILDING
SCALE	1/8" = 1'-0"


DATE	APR 27 1959
BY	ERNEST L. MCCOY AIA
FOR	BERNICE HARELL CHIPMAN JUNIOR HIGH SCHOOL
PROJECT	PLUMBING FLOOR PLANS - SHOP & PE. BUILDING
SCALE	1/8" = 1'-0"

DATE	APR 27 1959
BY	ERNEST L. MCCOY AIA
FOR	BERNICE HARELL CHIPMAN JUNIOR HIGH SCHOOL
PROJECT	PLUMBING FLOOR PLANS - SHOP & PE. BUILDING
SCALE	1/8" = 1'-0"


DATE	APR 27 1959
BY	ERNEST L. MCCOY AIA
FOR	BERNICE HARELL CHIPMAN JUNIOR HIGH SCHOOL
PROJECT	PLUMBING FLOOR PLANS - SHOP & PE. BUILDING
SCALE	1/8" = 1'-0"

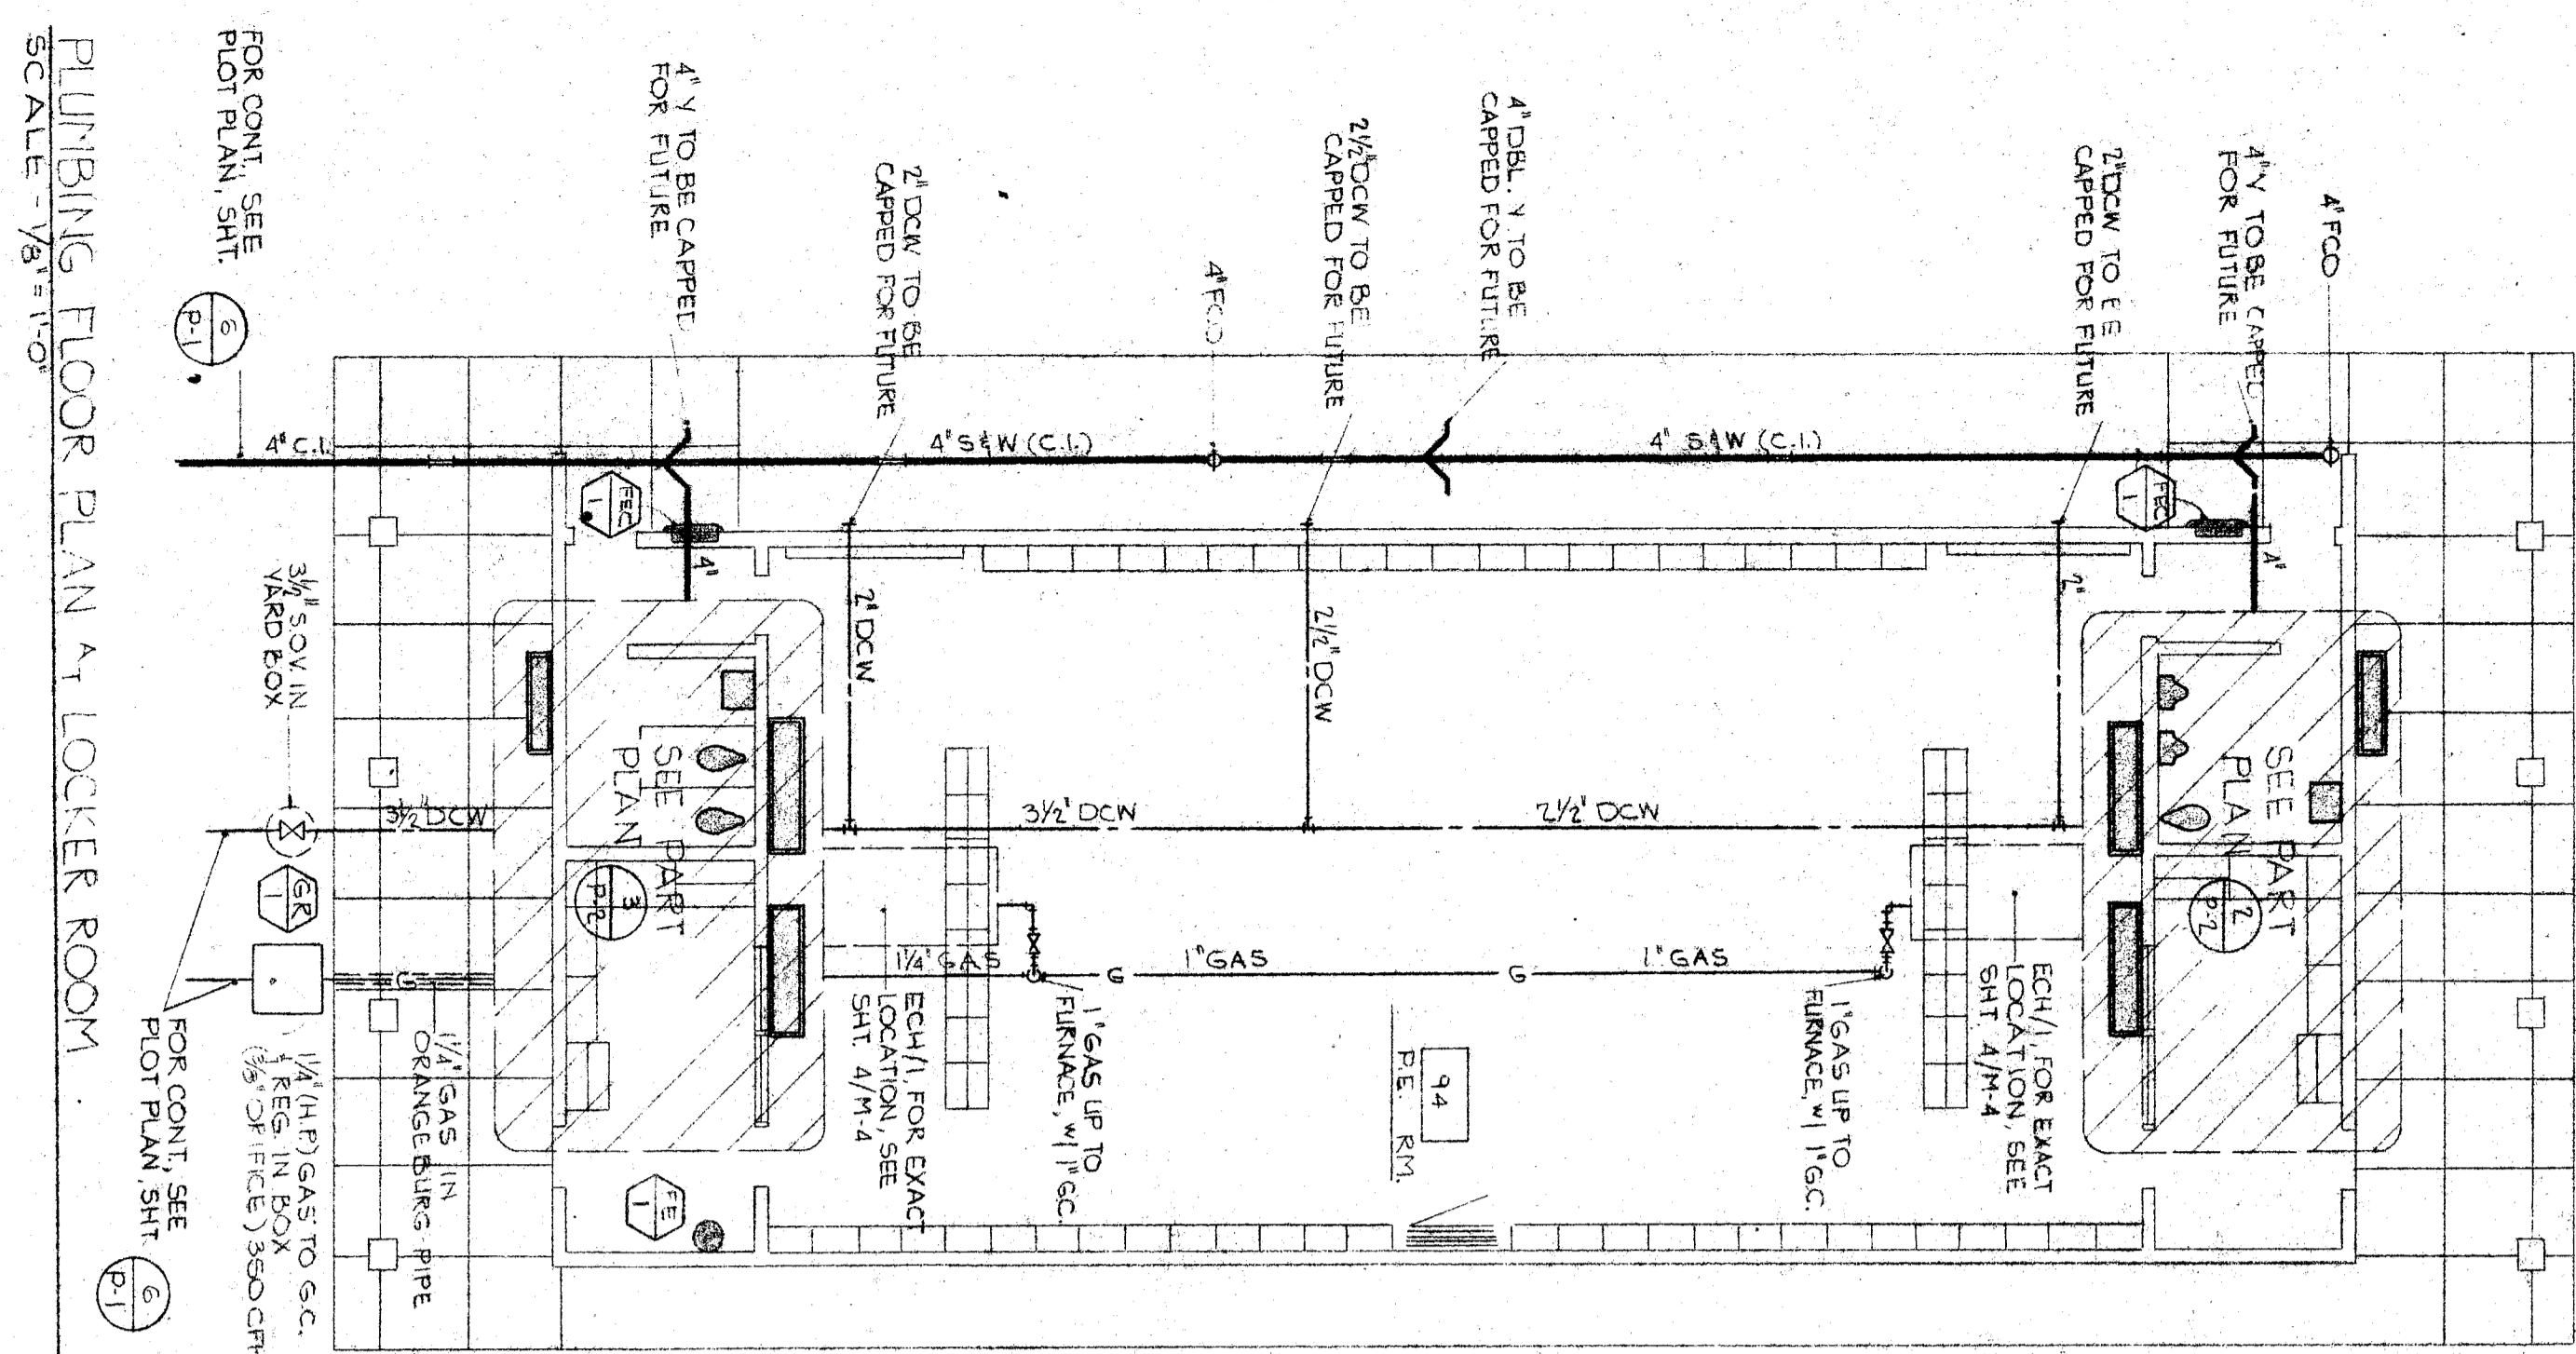


PLUMBING FLOOR PLAN 4 LOCKER ROOM
SCALE 1/8" = 1'-0"

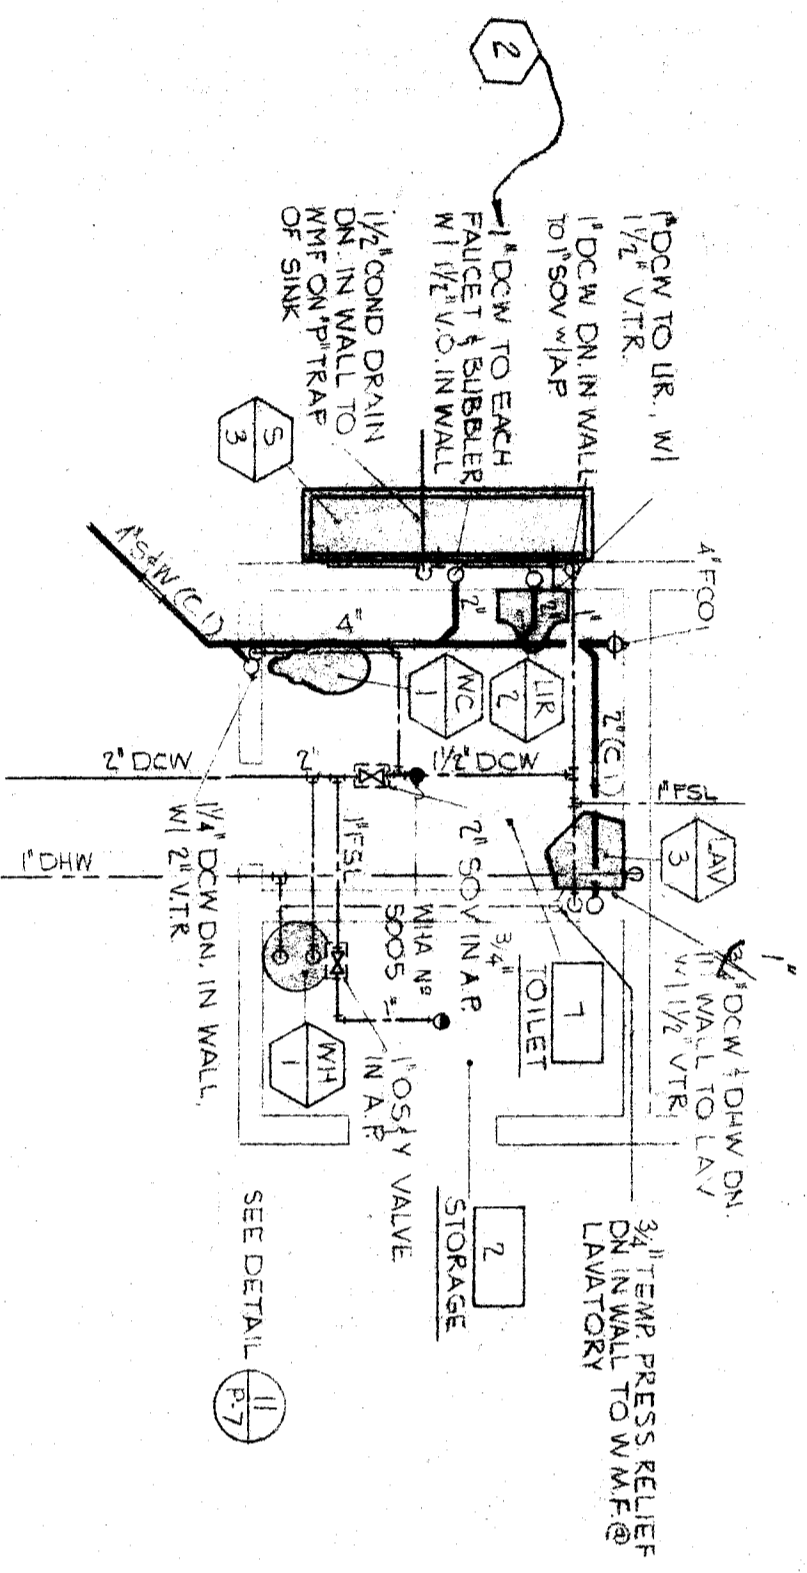


PART FLOOR PLAN
SCALE 1/4" = 1'-0"

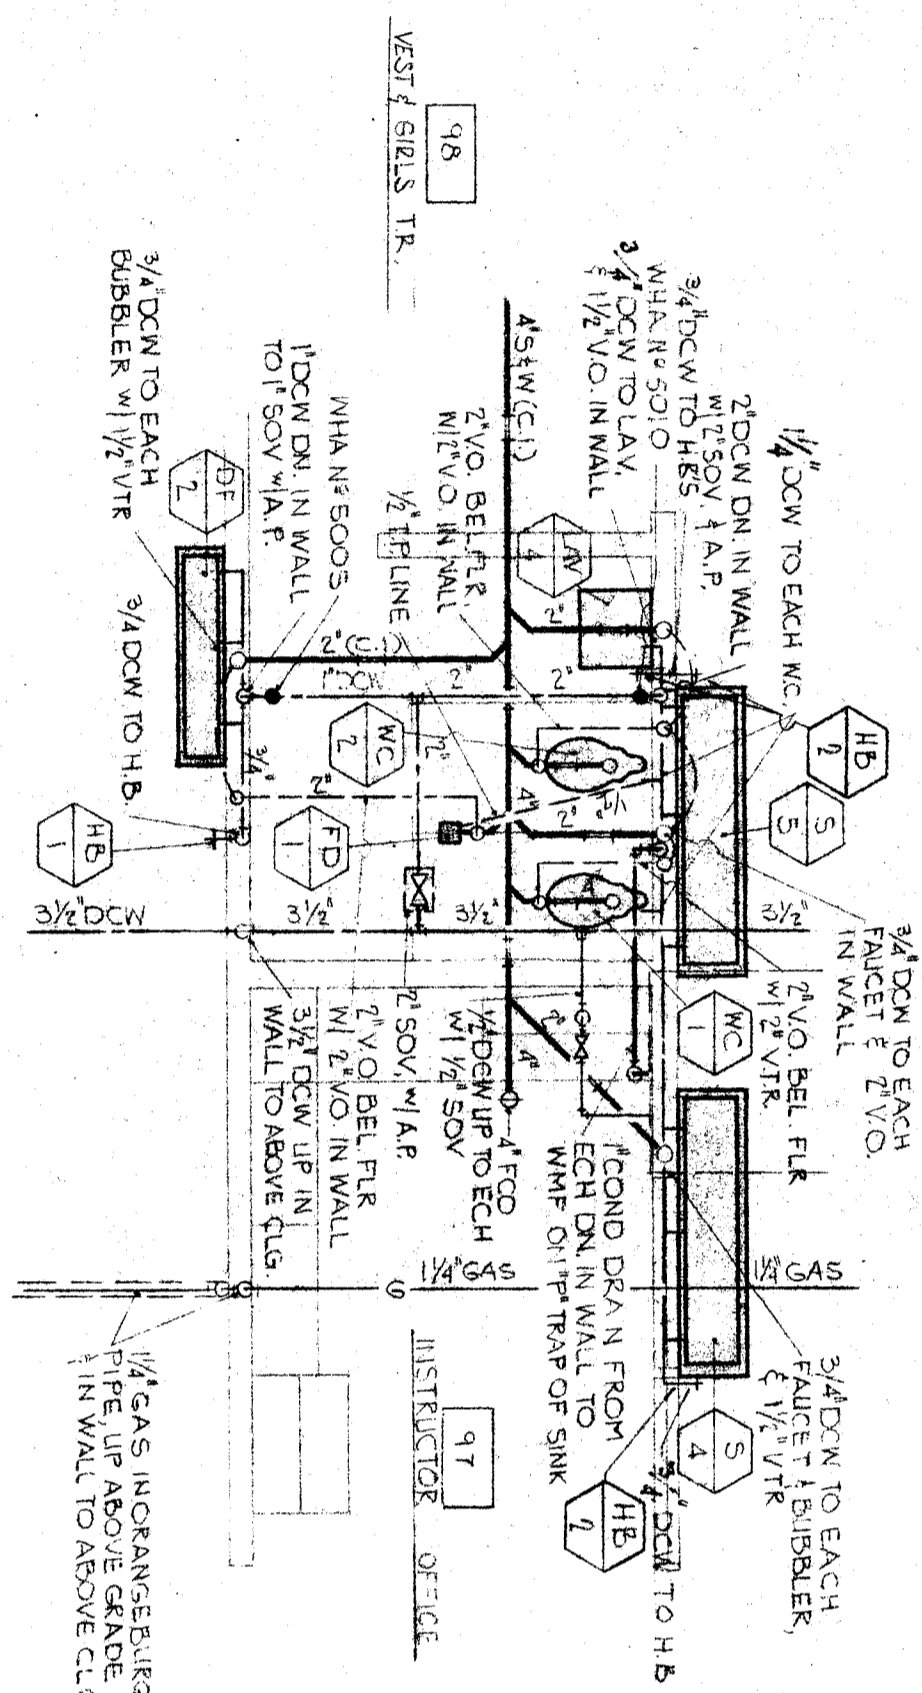


PART FLOOR PLAN
SCALE 1/4" = 1'-0"

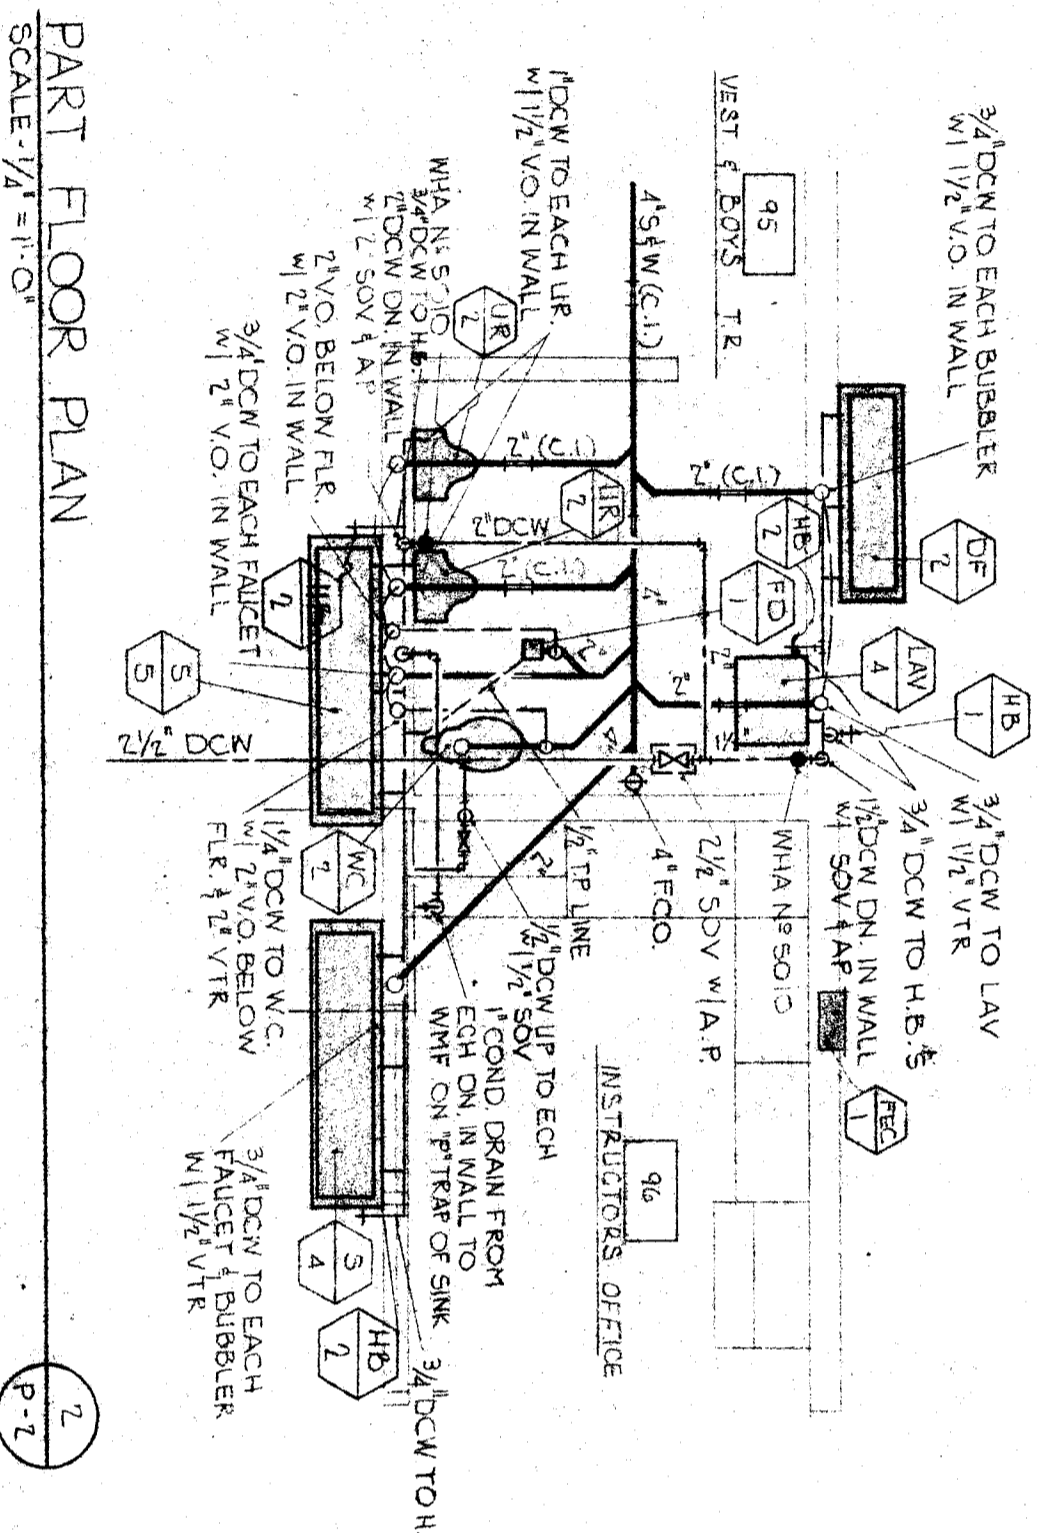


PART FLOOR PLAN
SCALE 1/4" = 1'-0"

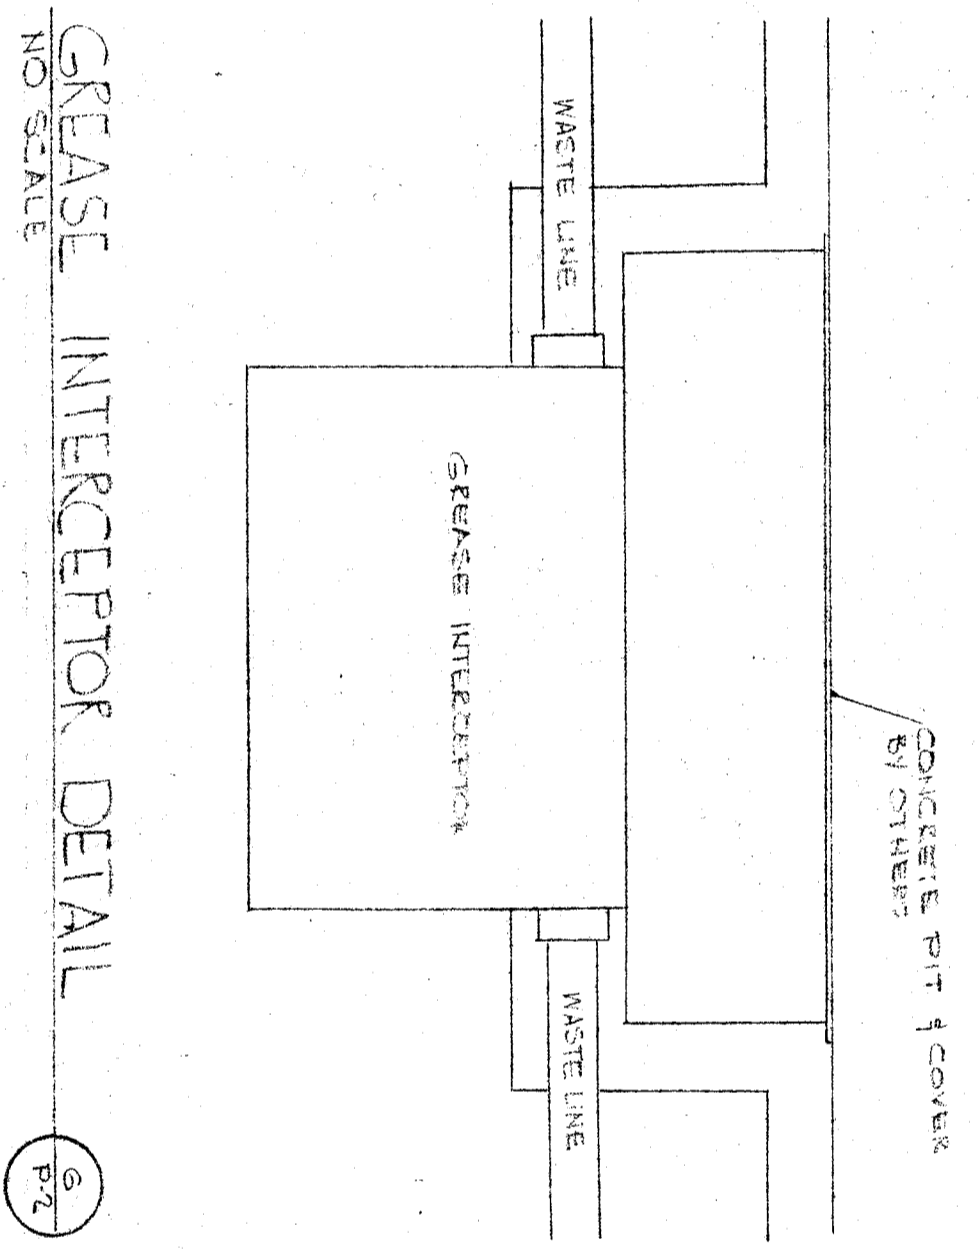

GREASE INTERCEPTOR DETAIL
NO SCALE

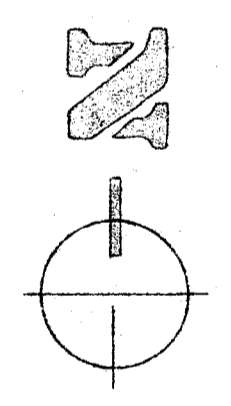

PLUMBING FLOOR PLAN 4 SHOP
SCALE 1/8" = 1'-0"

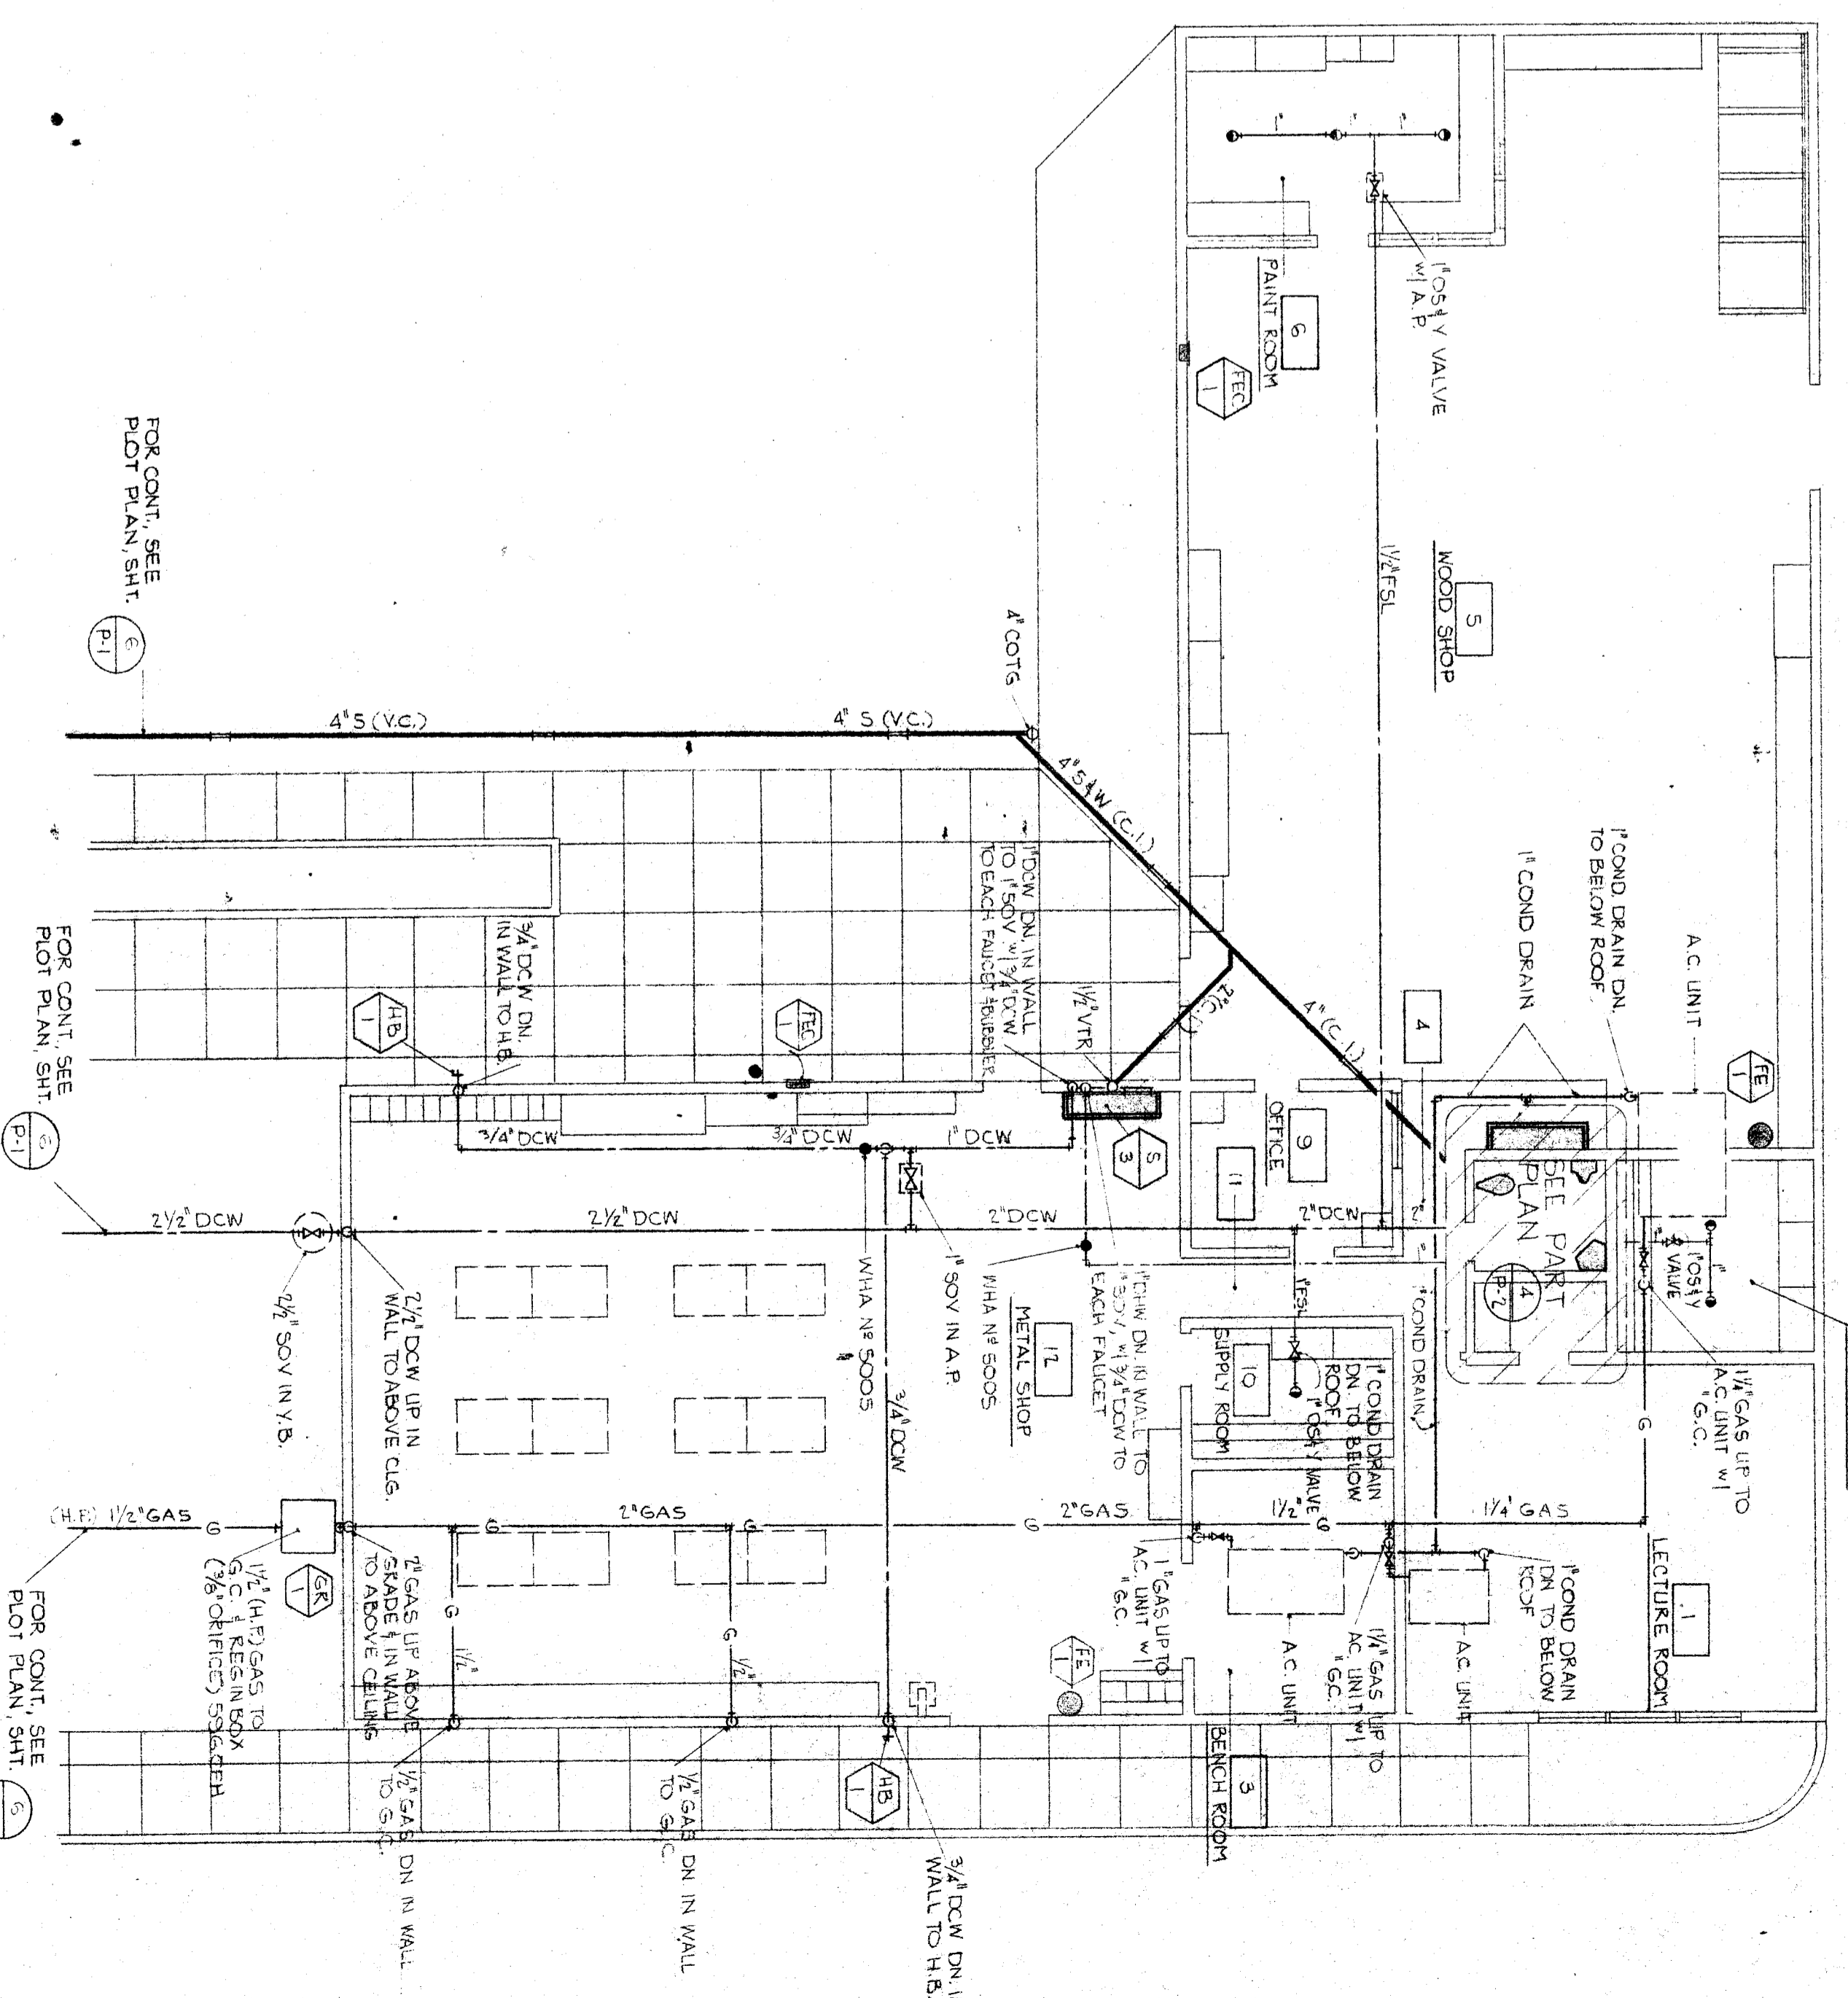

80609
APR 27 1959
ERNEST L. MCCOY AIA
ARCHITECT

BERNICE HARELL CHIPMAN
JUNIOR HIGH SCHOOL
BAKERSFIELD CITY SCHOOL DISTRICT
BAKERSFIELD, CALIFORNIA

PLUMBING FLOOR PLANS - SHOP & PE. BUILDING