



PART FLOOR PLAN (KITCHEN)
SCALE 1/4"

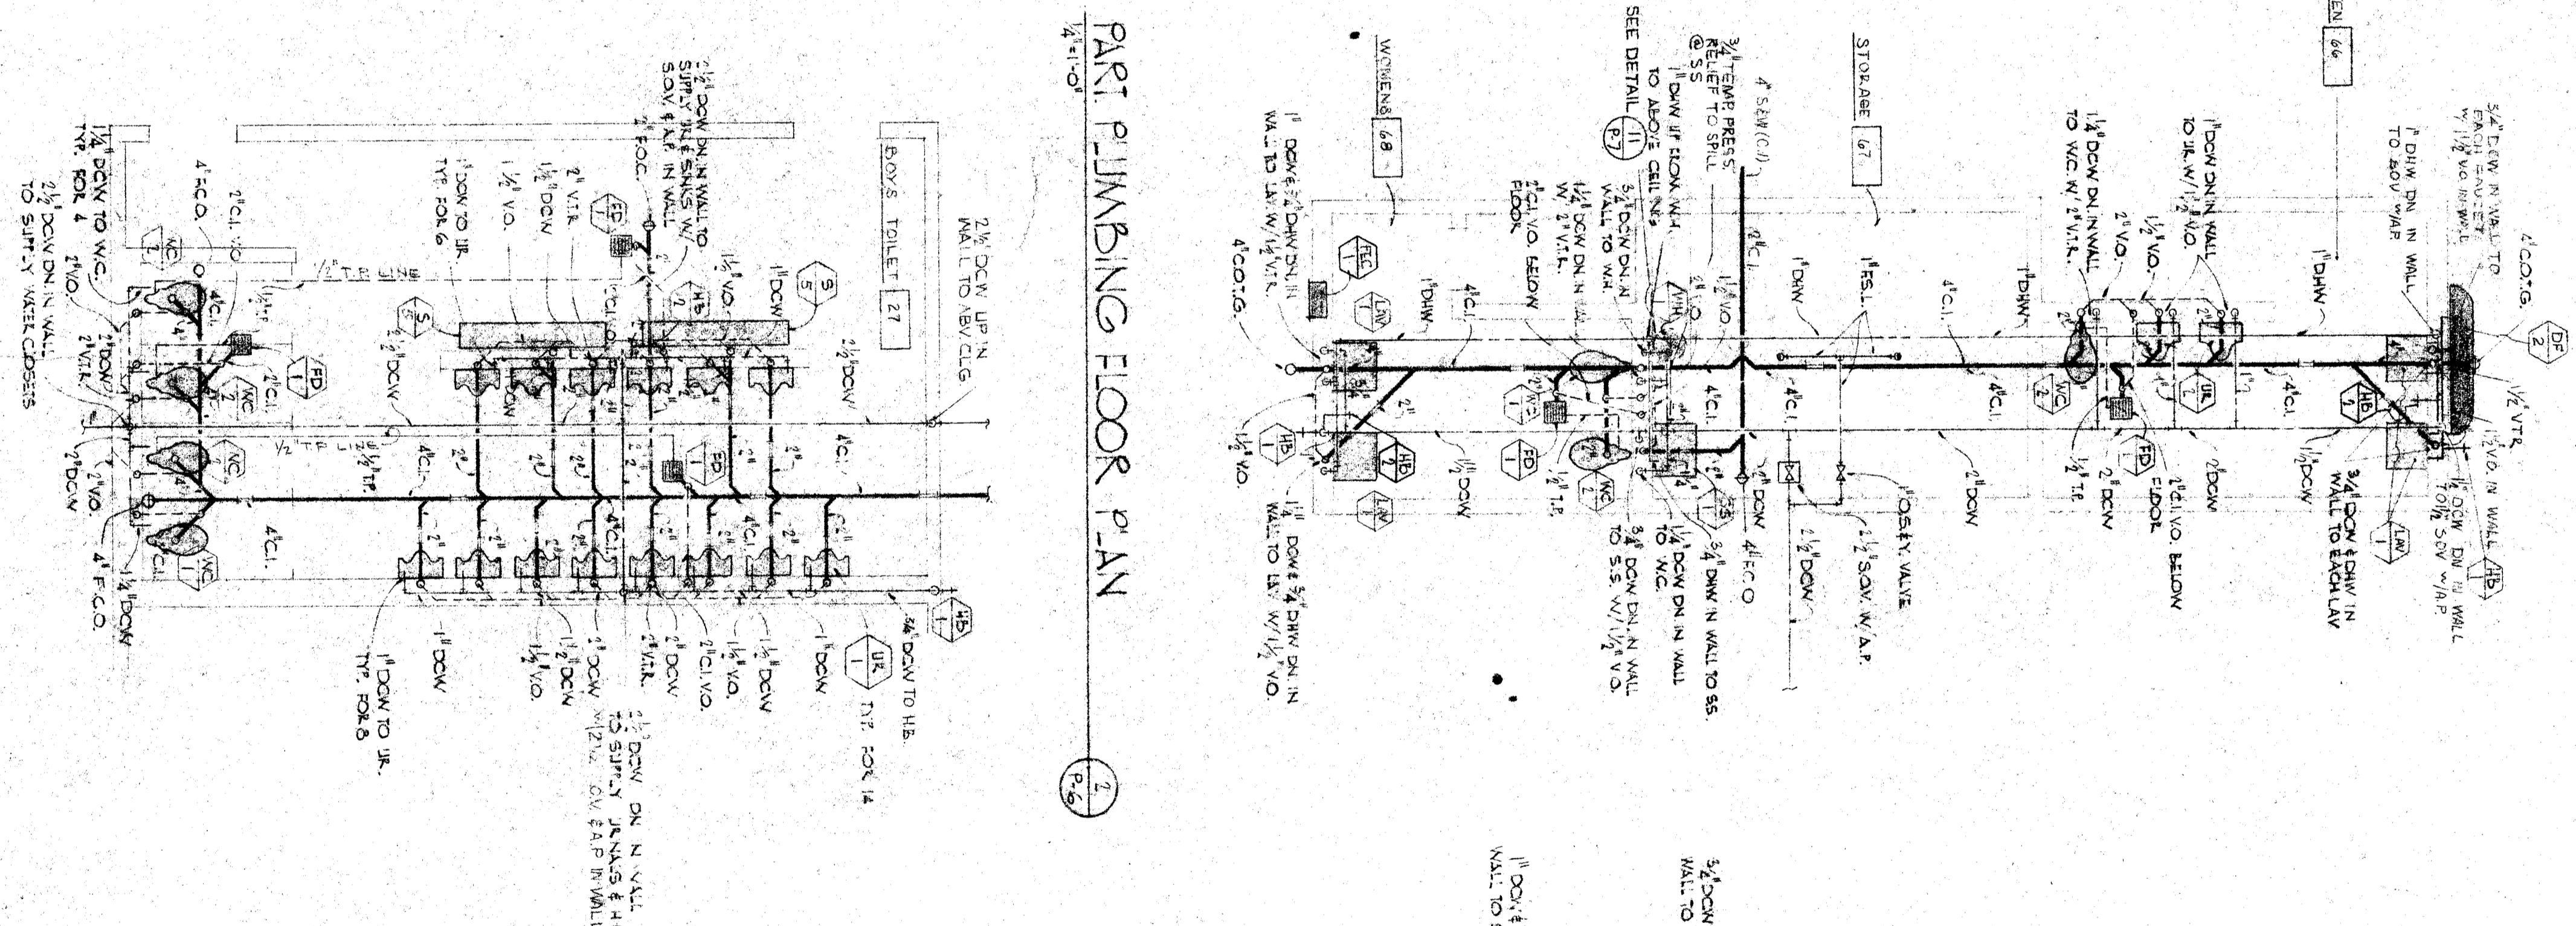

PART PLUMBING FLOOR PLAN

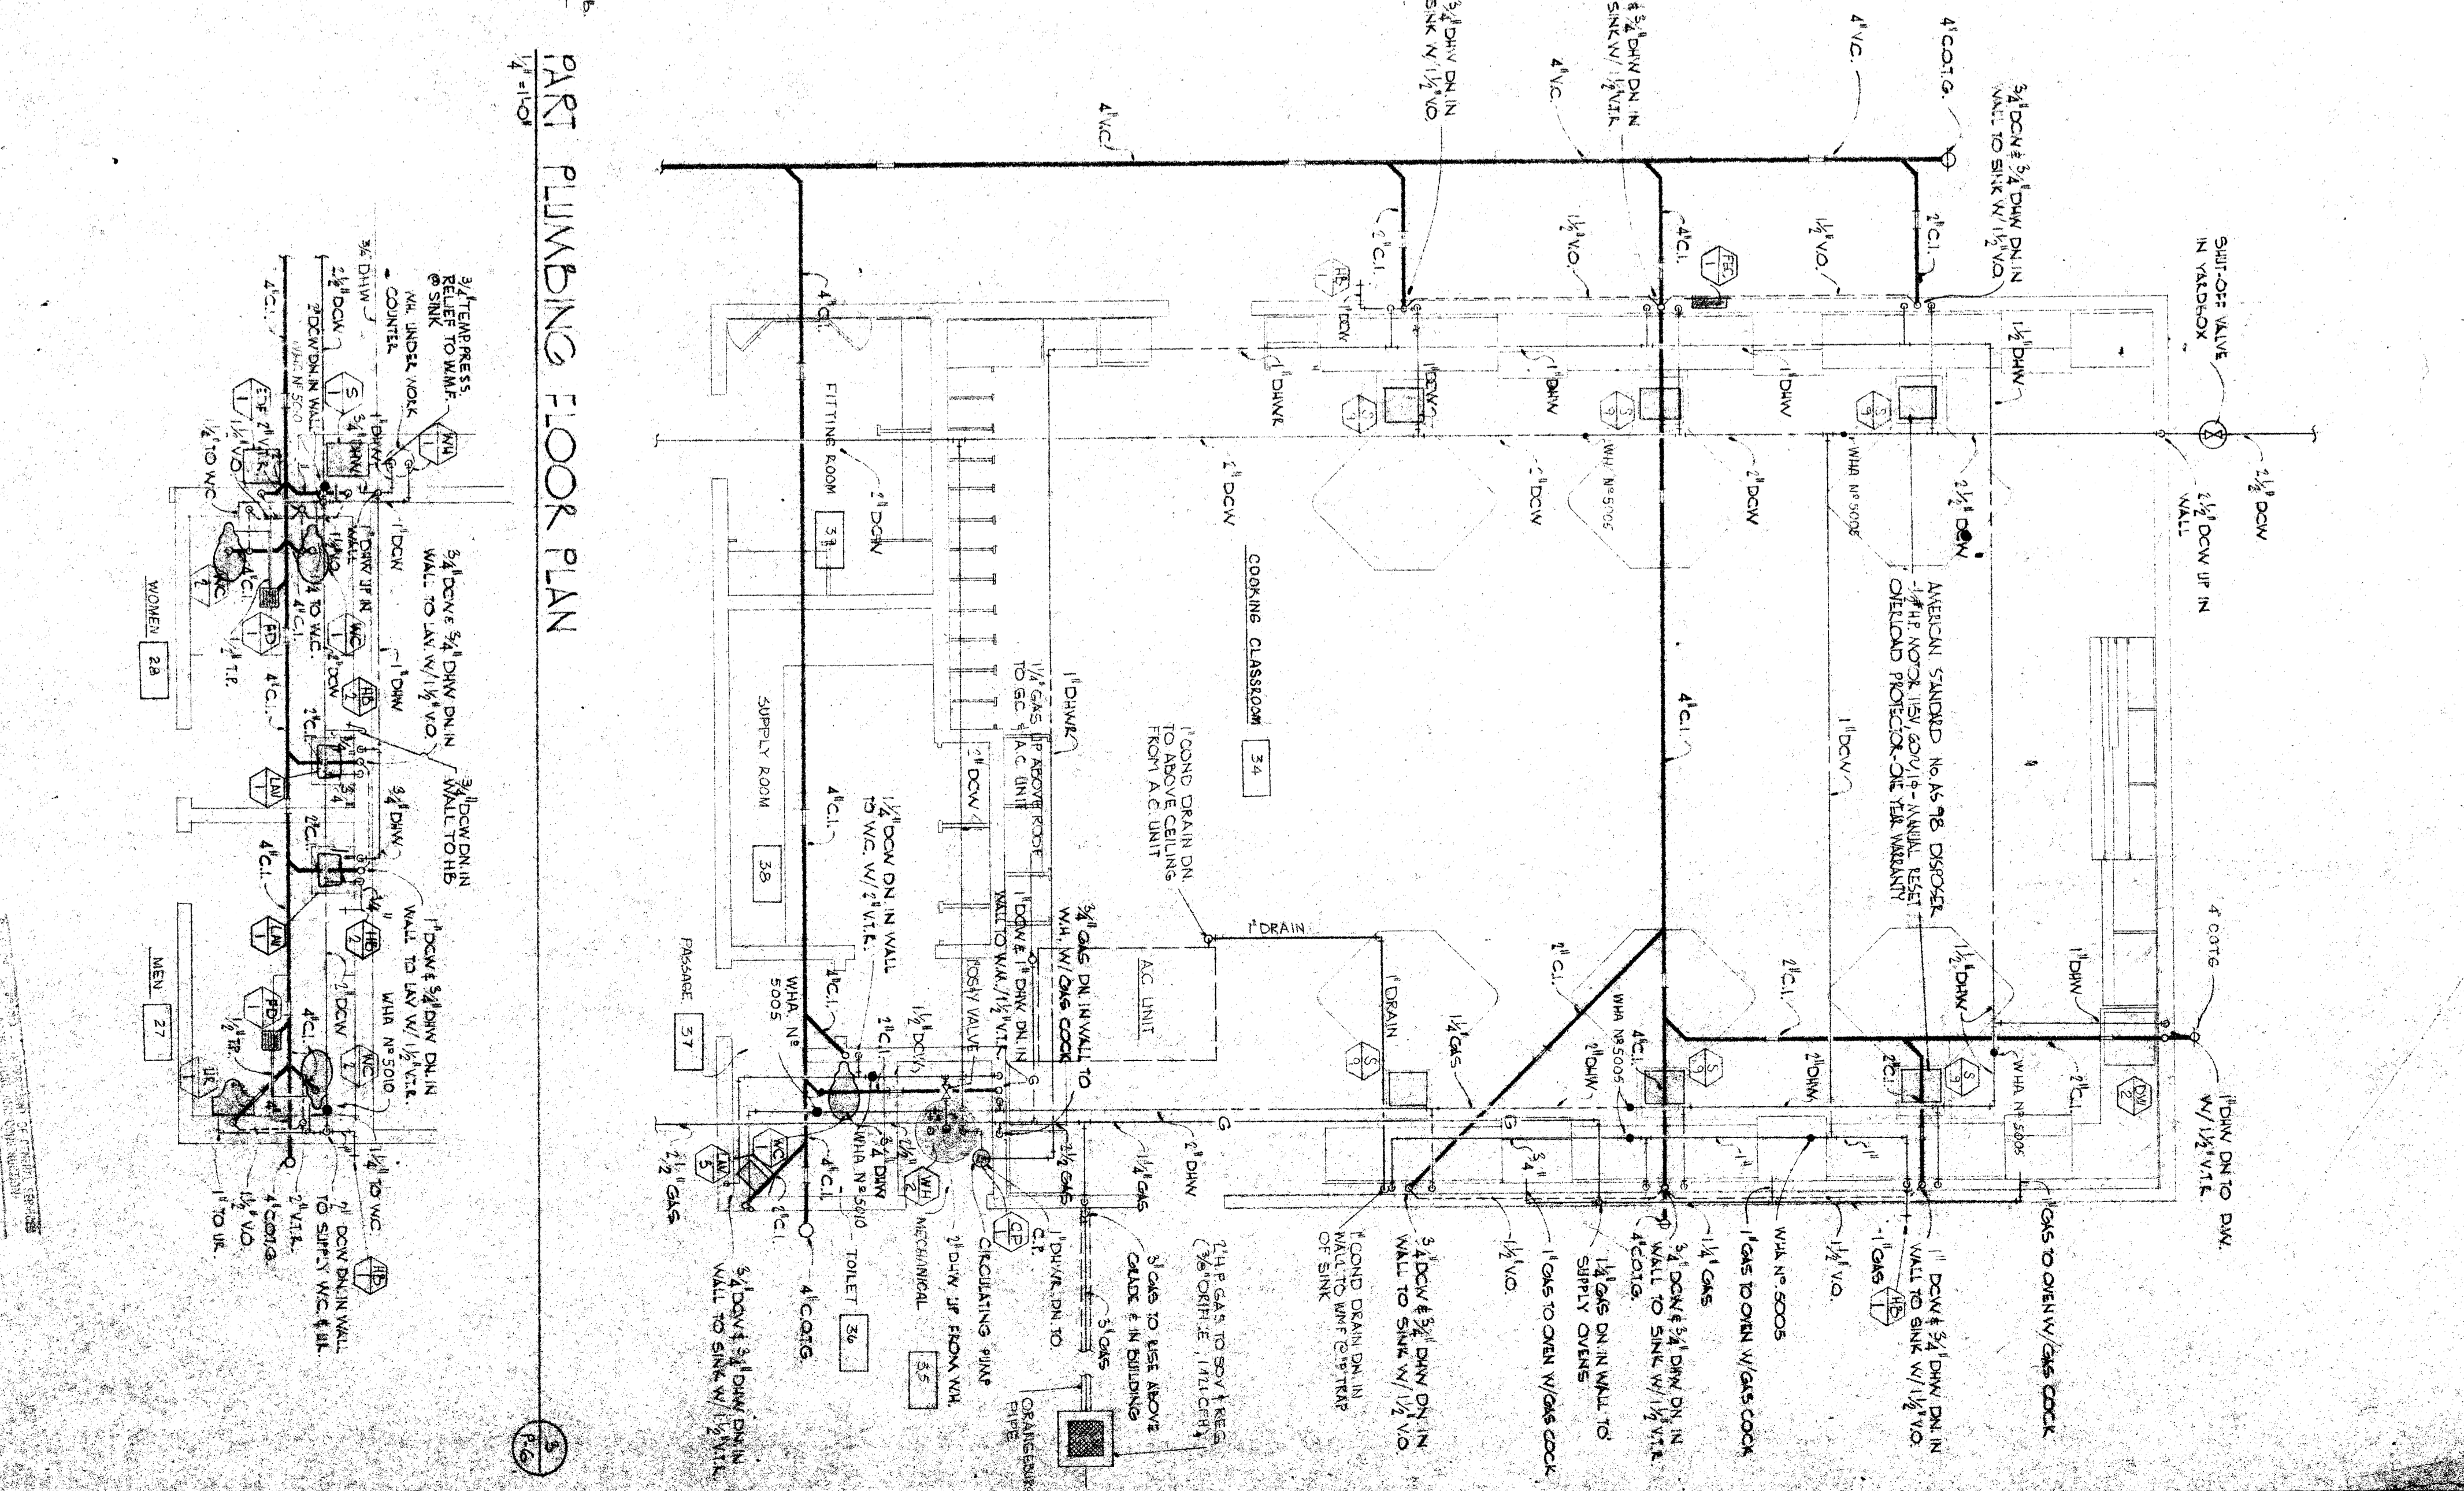

PART PLUMBING FLOOR PLAN

SOCKET PRESS REGULATOR IN Y.B.

PART PLUMBING FLOOR PLAN

PART PLUMBING FLOOR PLAN

PART PLUMBING FLOOR PLAN

CHECK AND VERIFY ALL DIMENSIONS AND CONDITIONS AT JOB SITE BEFORE PROCEEDING WITH THE WORK.		REPORT ANY DISCREPANCIES TO THE ARCHITECT.	
REVISIONS	DATE	BY	REASON
AS BUILT			
APPENDIX			
CHANGE ORDER			
CLASSIFICATION			
STATE OF CALIFORNIA STATE FIRE MARSHAL APPROVED UNDER SIGNATURE OF CALIFORNIA JUL 15 1953			
DRAWN BY DATE APPROVED BY BOARD OF ARCHITECTS BAKERSFIELD CITY SCHOOL DISTRICT DATE APPROVED BY BOARD OF ARCHITECTS BAKERSFIELD CITY SCHOOL DISTRICT		APPROVED - DATE ERNEST L. MCGOY AIA ARCHITECT 2411 H STREET BAKERSFIELD CALIFORNIA 93303	
NO. 578 SHEET OF 7 SHEETS		BERNICE HARKELL CHIPMAN JUNIOR HIGH SCHOOL BAKERSFIELD CITY SCHOOL DISTRICT BAKERSFIELD, CALIFORNIA	

PLUMBING FLOOR PLAN - KITCHEN, DINING, AND TOILETS