
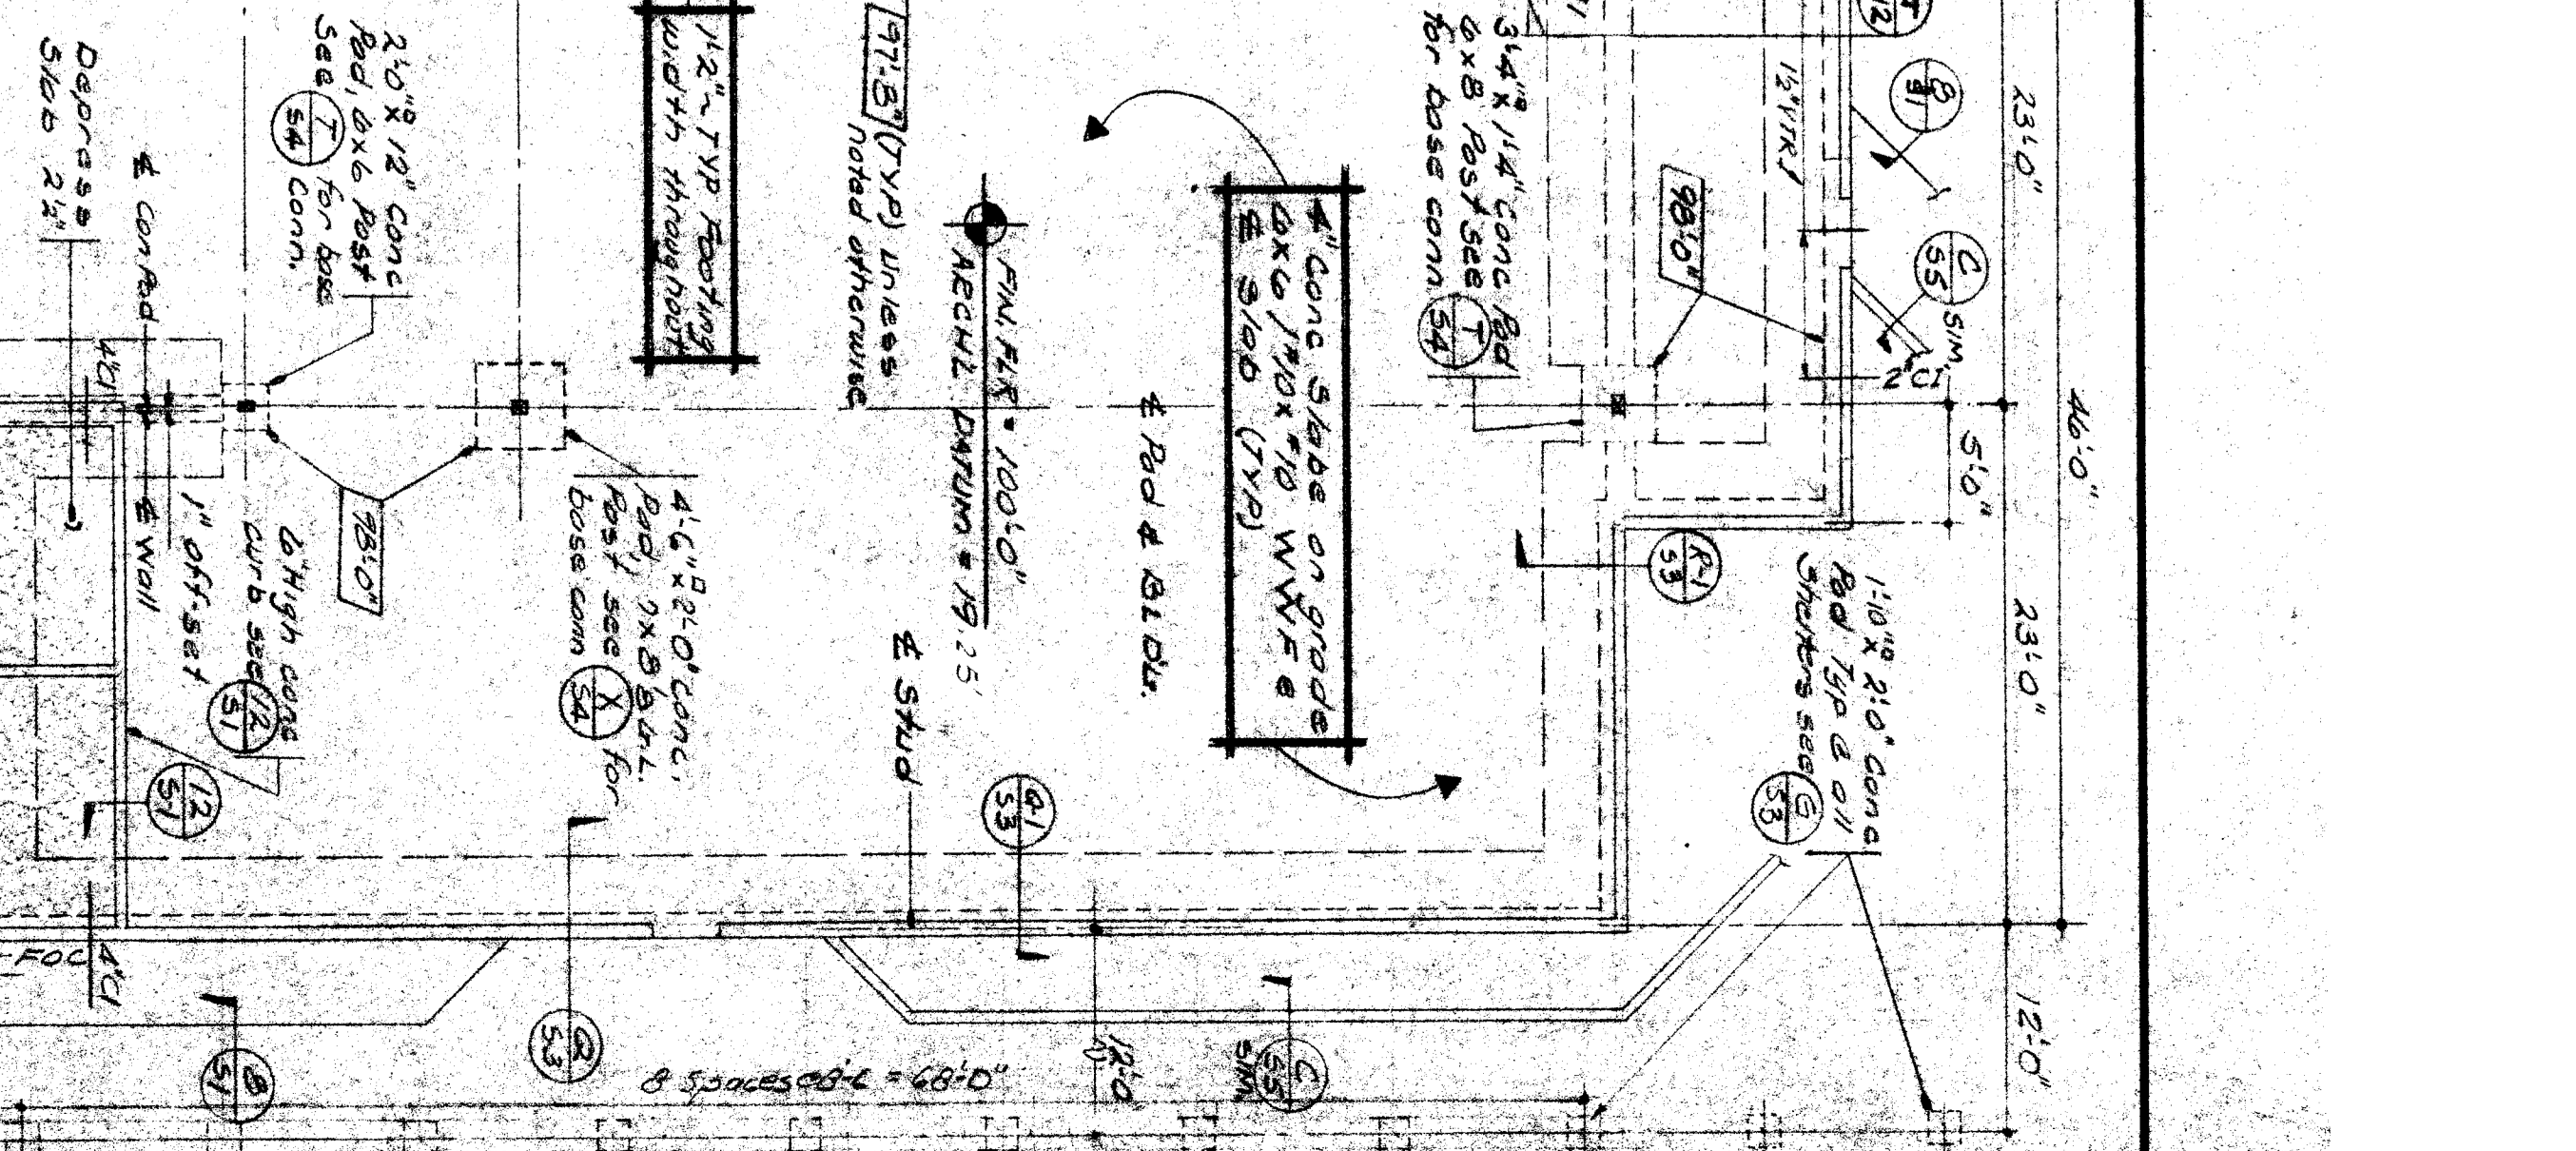
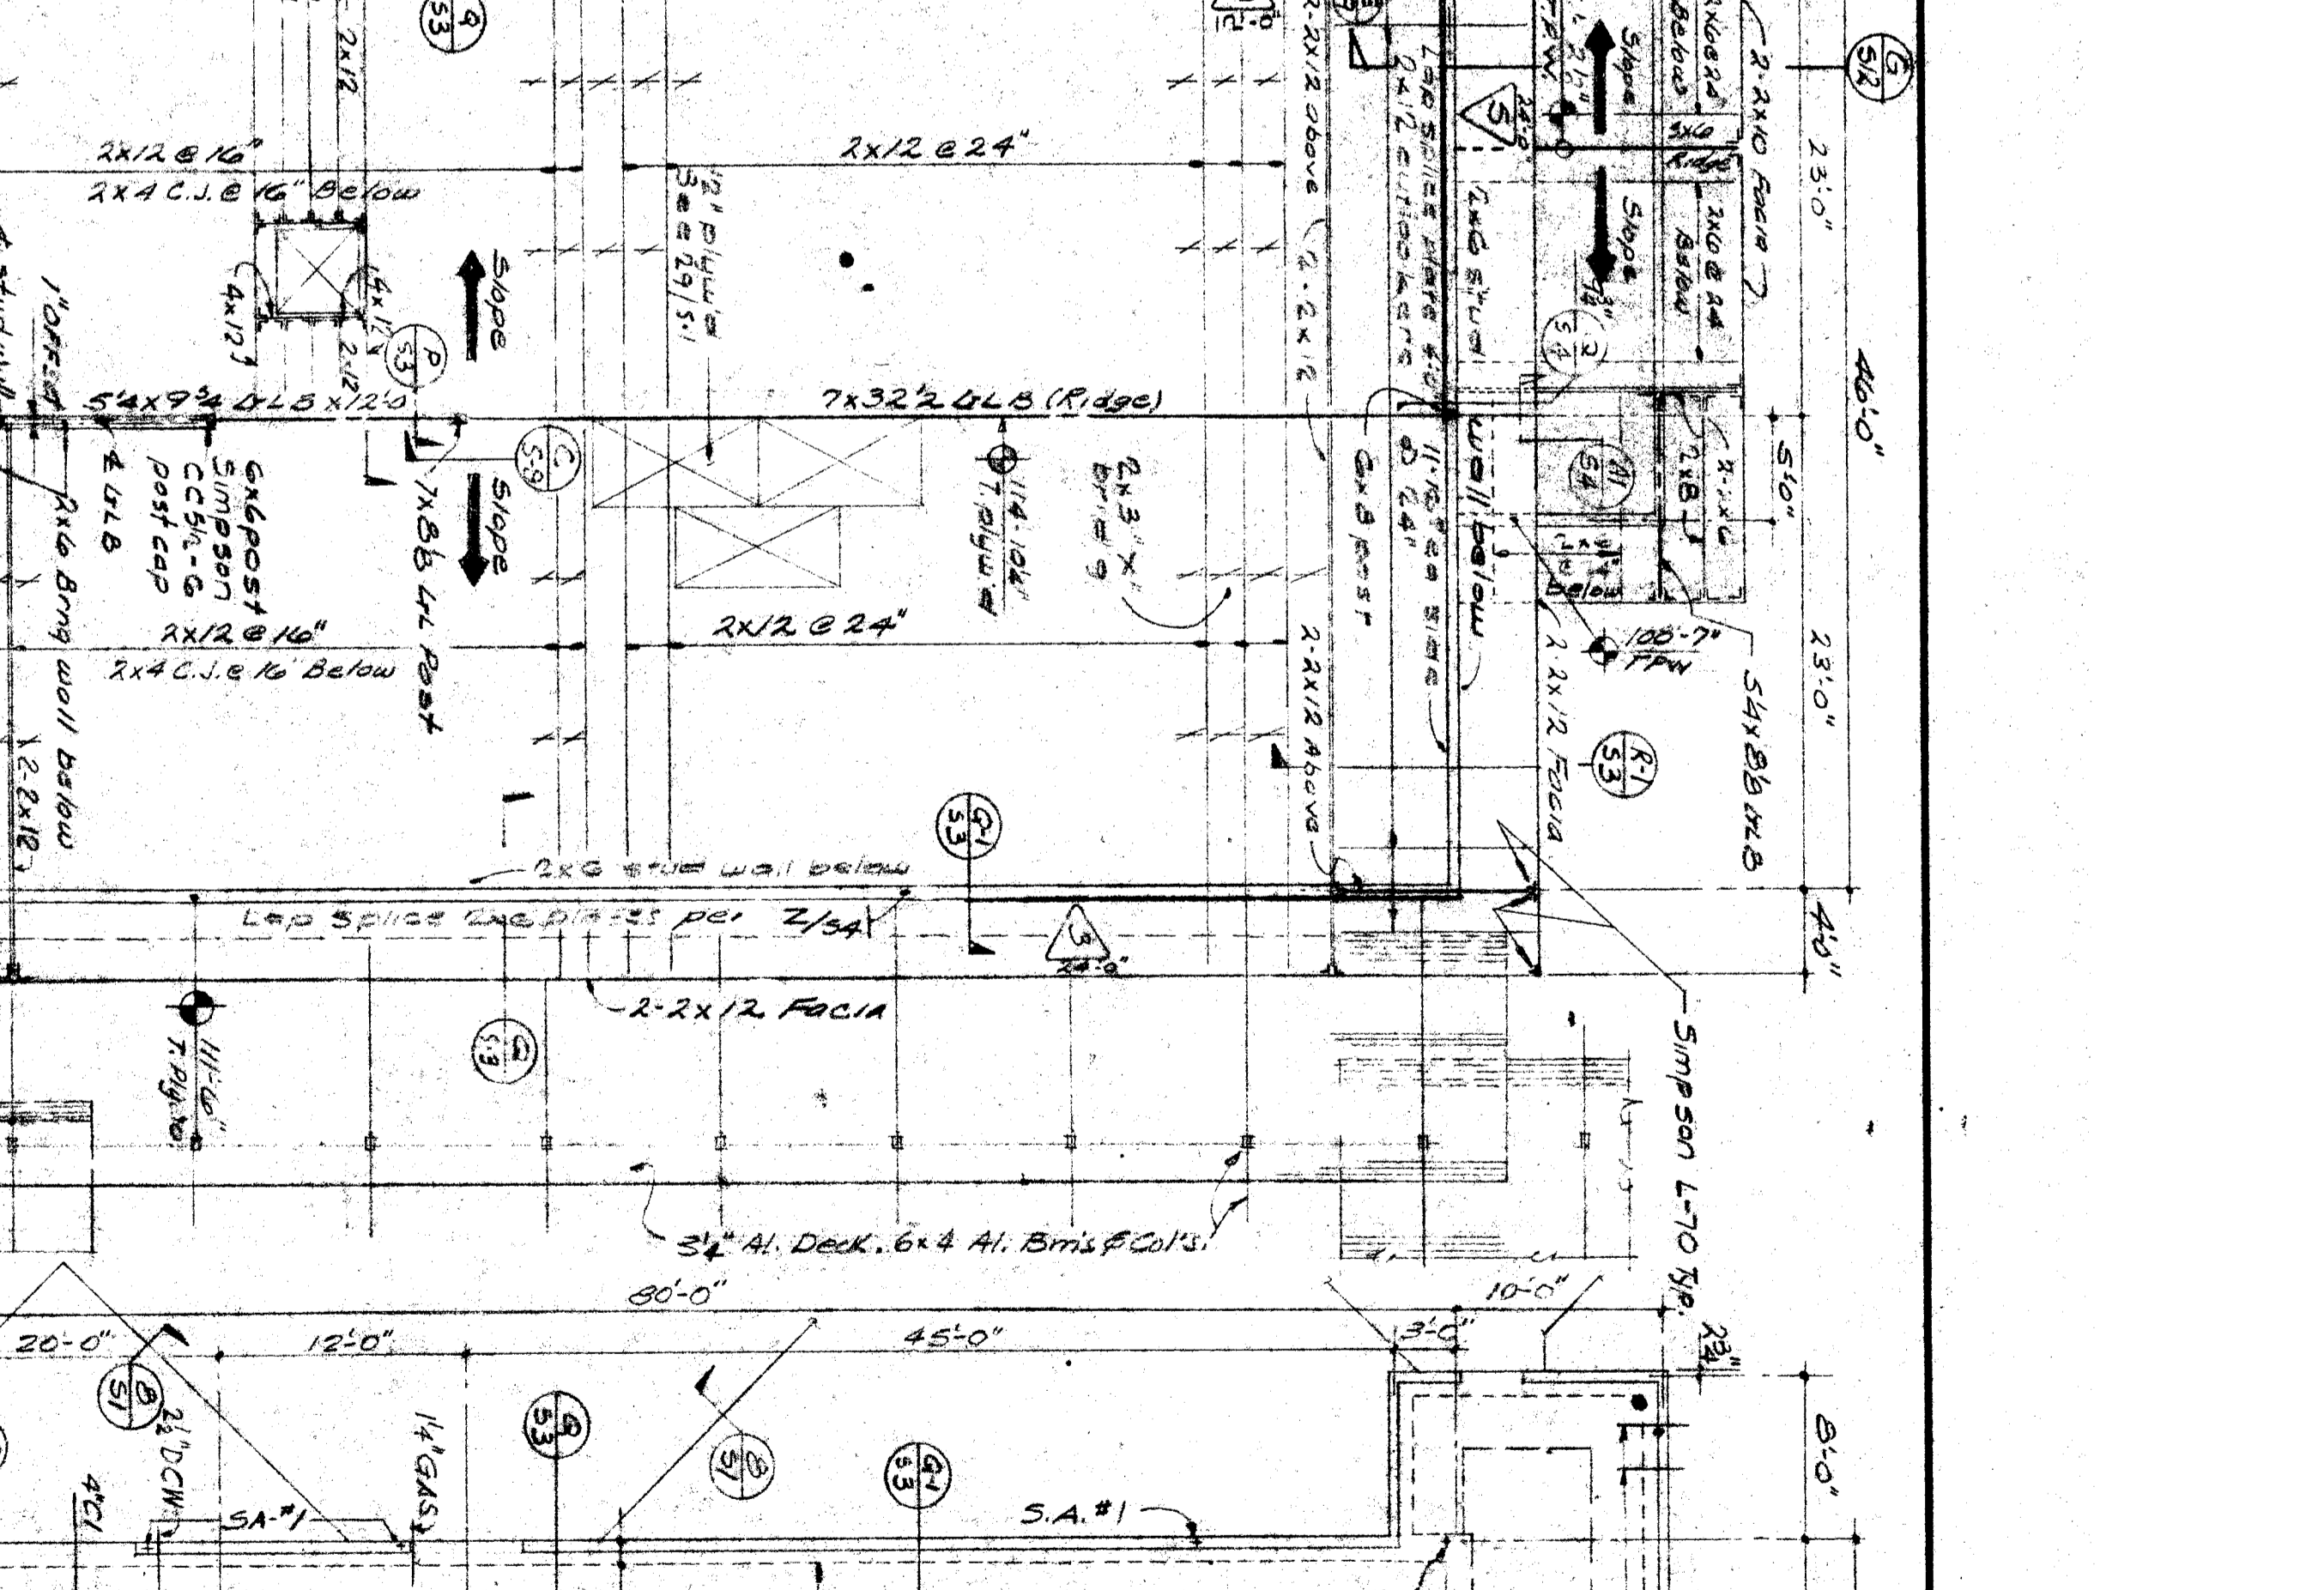
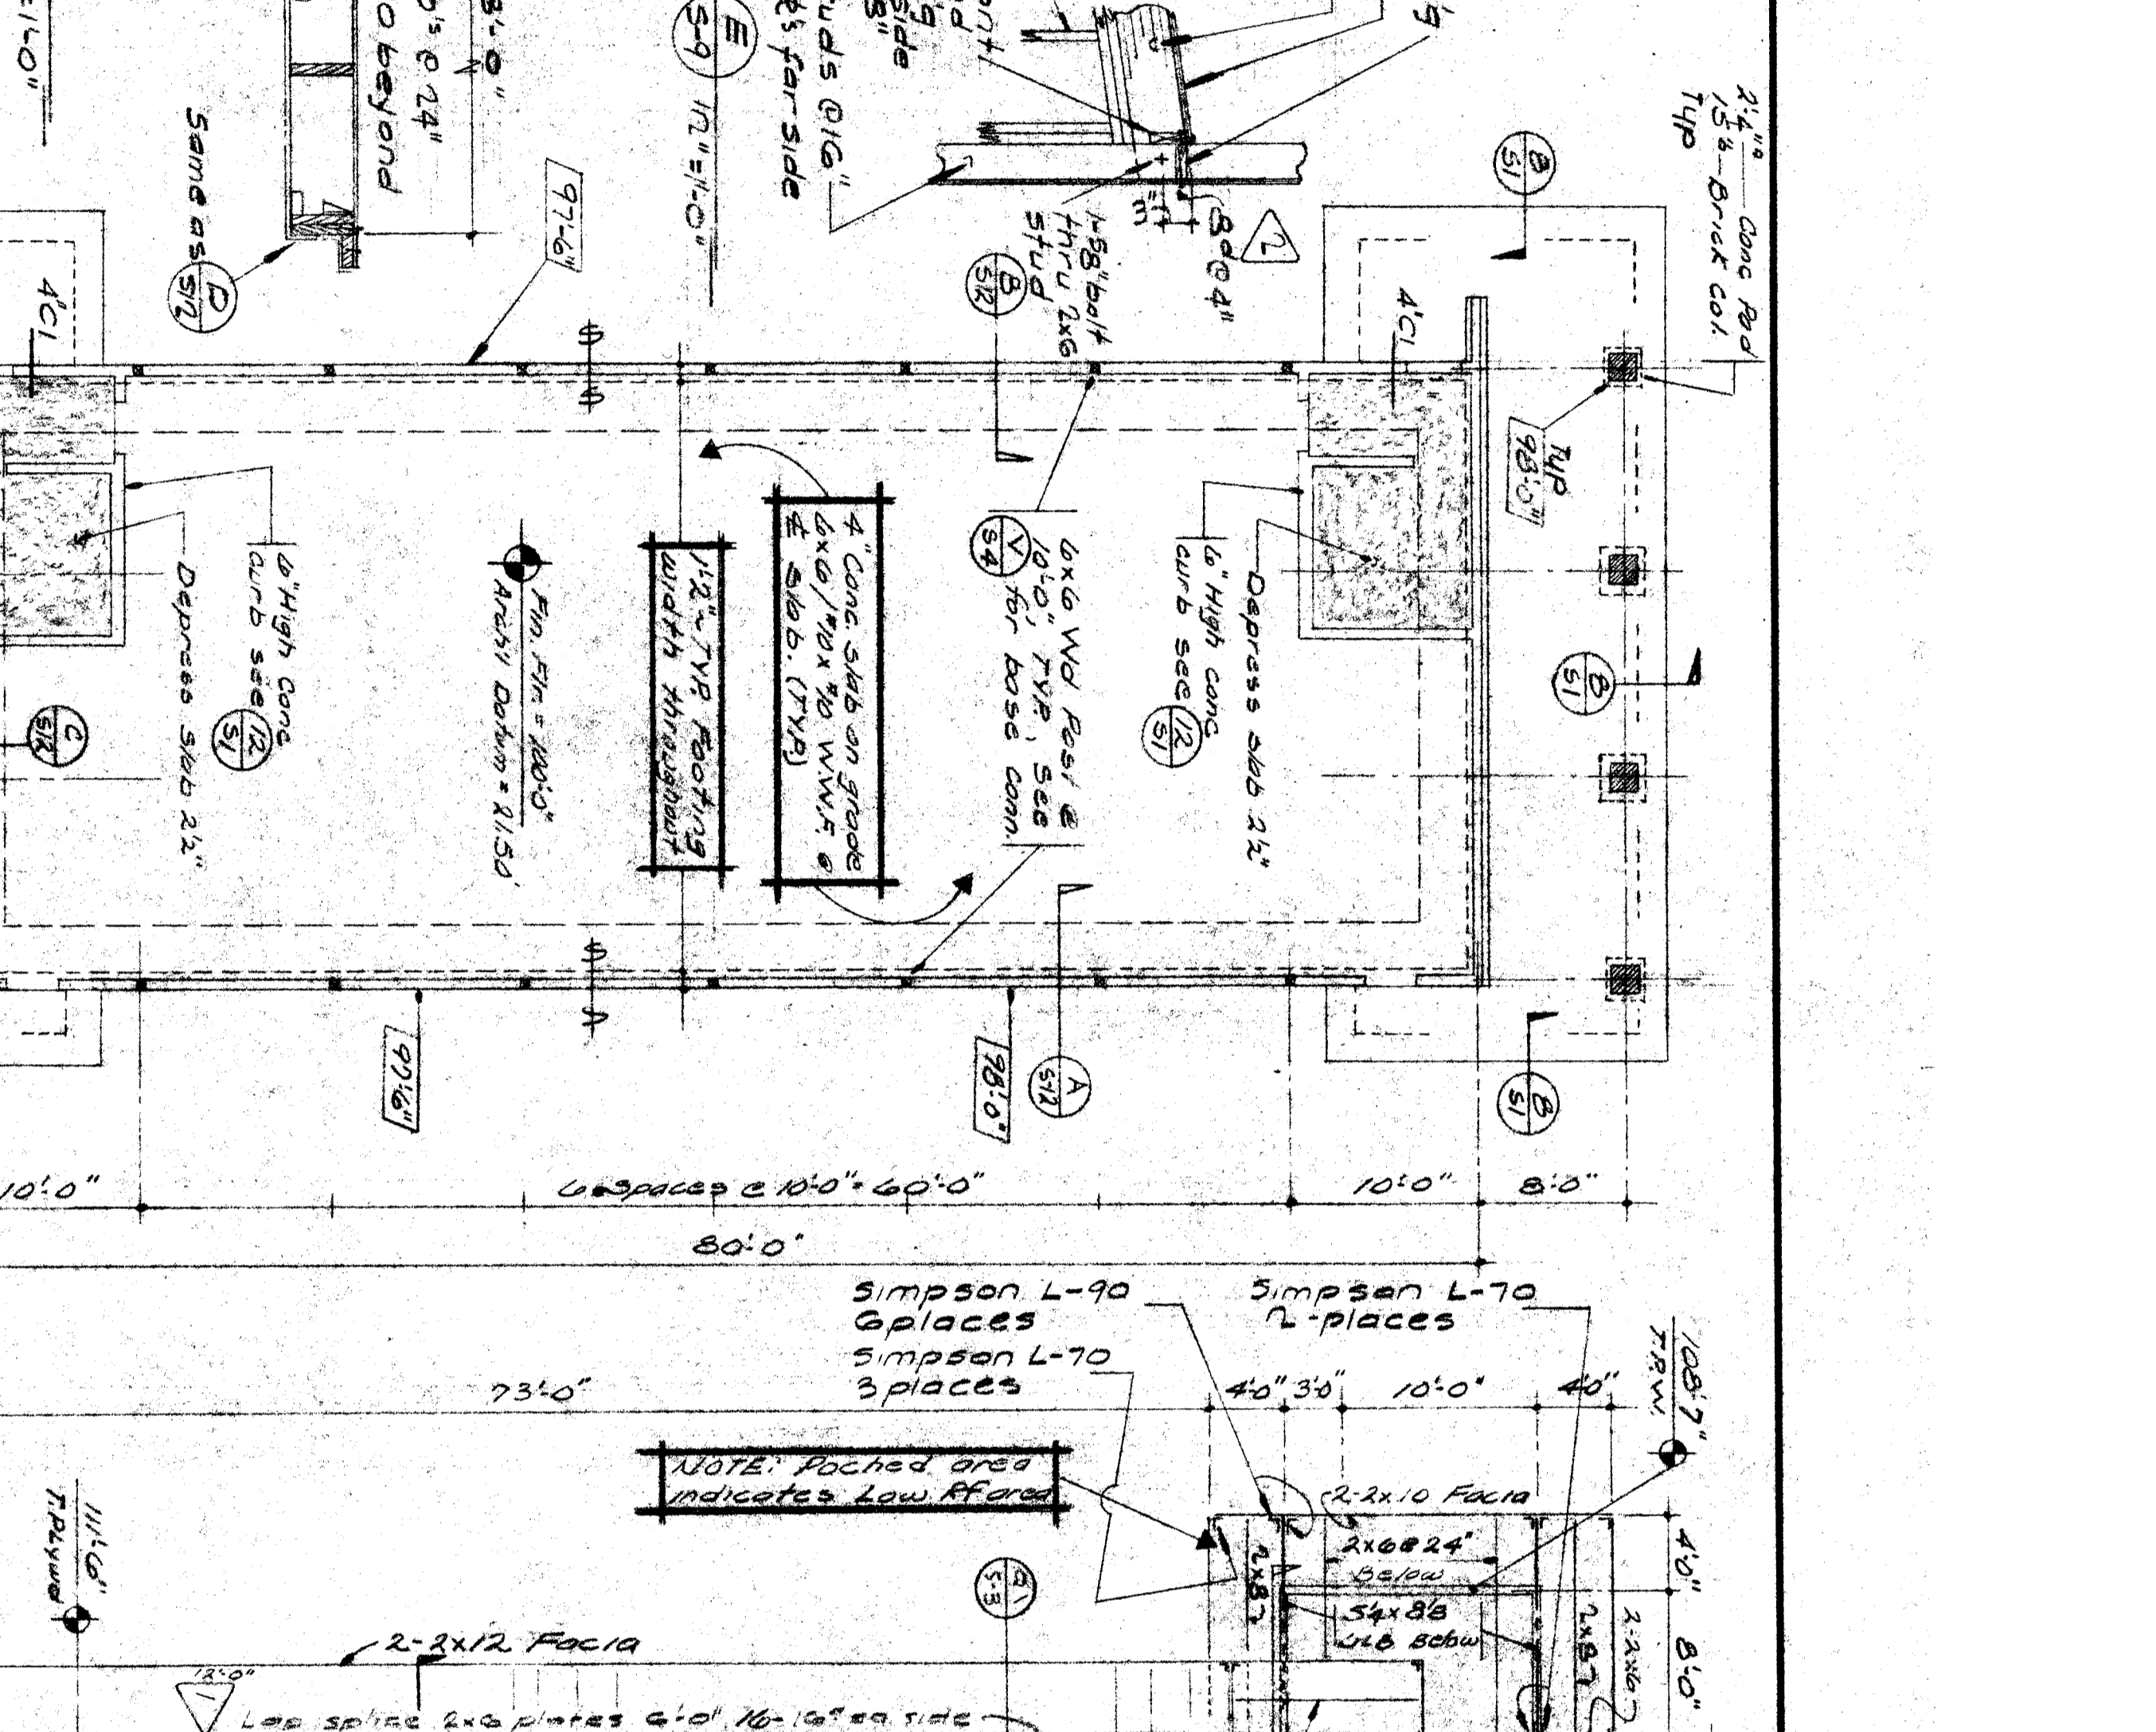


ROOF FRAMING PLAN - SCALE: 5/16" = 1'-0"
 HEALTH FACILITIES BUILDING (Interior Sht. M.2)
 FOR ROOF FRAMING NOTES SEE SHT. S7

FOUNDATION PLAN - SCALE: 5/16" = 1'-0"
 HEALTH FACILITIES BUILDING (Interior Sht. M.2)
 FOR FOUNDATION NOTES SEE SHT. S5

ROOF FRAMING PLAN - SCALE: 5/16" = 1'-0"
 HEALTH FACILITIES BUILDING
 FOR ROOF FRAMING NOTES SEE SHT. S7

FOUNDATION PLAN - SCALE: 5/16" = 1'-0"
 HEALTH FACILITIES BUILDING
 FOR FOUNDATION NOTES SEE SHT. S5

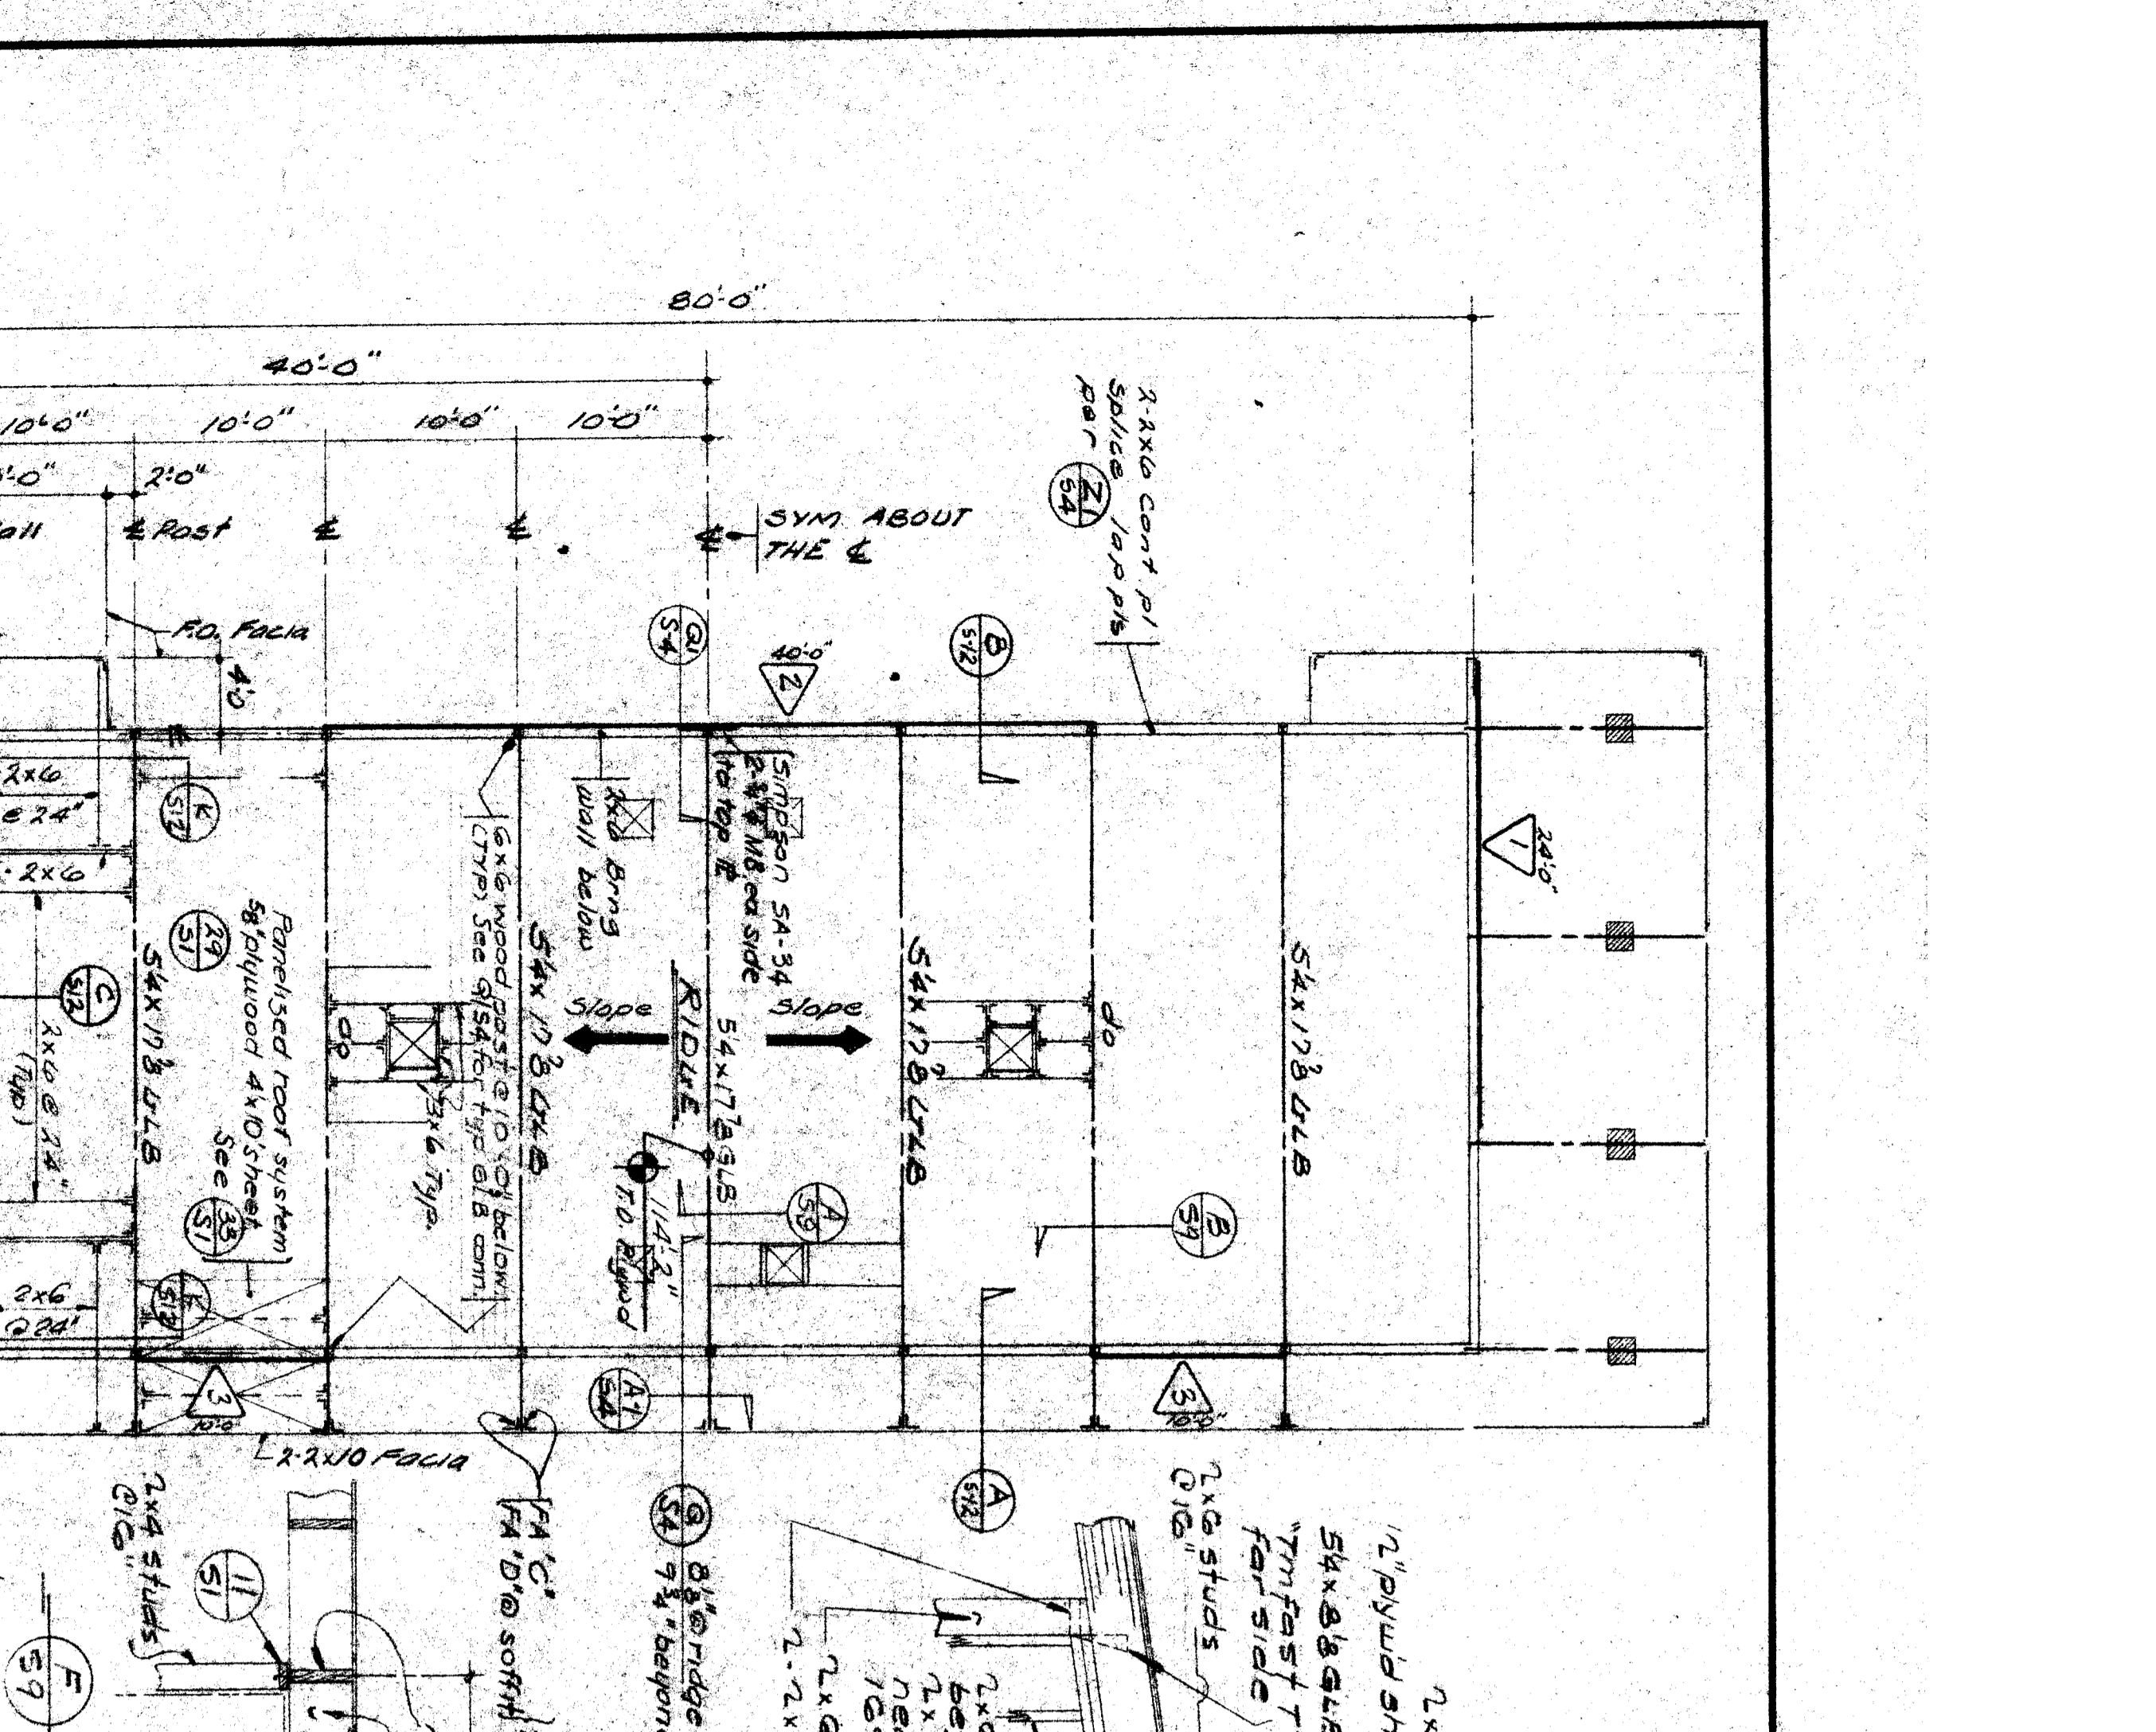

Plywood Shear Panel Schedule	L. B. RAY		S. J. S.		R. J. S.		S. J. S.	
	Max. Span Length	Spanning	Max. Span Length	Spanning	Max. Span Length	Spanning	Max. Span Length	Spanning
1	12'-0"	YES	12'-0"	YES	12'-0"	YES	12'-0"	YES
2	12'-0"	YES	12'-0"	YES	12'-0"	YES	12'-0"	YES
3	12'-0"	YES	12'-0"	YES	12'-0"	YES	12'-0"	YES
4	12'-0"	YES	12'-0"	YES	12'-0"	YES	12'-0"	YES
5	12'-0"	YES	12'-0"	YES	12'-0"	YES	12'-0"	YES
6	12'-0"	YES	12'-0"	YES	12'-0"	YES	12'-0"	YES
7	12'-0"	YES	12'-0"	YES	12'-0"	YES	12'-0"	YES
8	12'-0"	YES	12'-0"	YES	12'-0"	YES	12'-0"	YES
9	12'-0"	YES	12'-0"	YES	12'-0"	YES	12'-0"	YES
10	12'-0"	YES	12'-0"	YES	12'-0"	YES	12'-0"	YES

NOTE: For Typ. Plywood Shear Panel Notes See Sht. S2

PROJECT: HEALTH FACILITIES BUILDING
DATE: JULY 3, 1988
SCALE: 5/16" = 1'-0" (Unless otherwise noted)
DESIGNED BY: ERNEST L. MCGOY AIA ARCHITECT
CHECKED BY: G. J. S.
APPROVED BY: G. J. S.
ENGINEER: ERNEST L. MCGOY AIA ARCHITECT
 2411 N. STREET, BAKERSFIELD, CALIFORNIA 93304
 PHONE (805) 338-1111
 FAX (805) 338-1111
CONTRACT NO.: 88-09
DATE OF CONTRACT: JULY 3, 1988
DATE OF SHEET: JULY 3, 1988
SHEET NO.: 5-9 OF 13 SHEETS