


STATISTICS						
Description	Symbol	Avg	Max	Min	Max/Min	Avg/Min
PARKING LOT	+	0.99 fc	7.74 fc	0.17 fc	45.5:1	5.8:1
Walkway	+	1.44 fc	6.85 fc	0.19 fc	36.1:1	7.6:1

LUMINAIRE SCHEDULE									
Symbol	Label	Qty	Catalog Number	Description	Lamp	File	Lumens	LLF	Watts
□	P2	2	VP-S-30NB-70-4K-T4	SMALL VIPER	C-70-CRI DATA SHOWN IS ABSOLUTE	VP-S-30NB-70-4K-T4.ies	Absolute	0.90	142.7756
□	P3	3	VP-S-24NB-55-3K-T4	SMALL VIPER	C-70-CRI DATA SHOWN IS SCALED FROM 1148116	VP-S-24NB-55-3K-T4.ies	Absolute	0.90	55.8

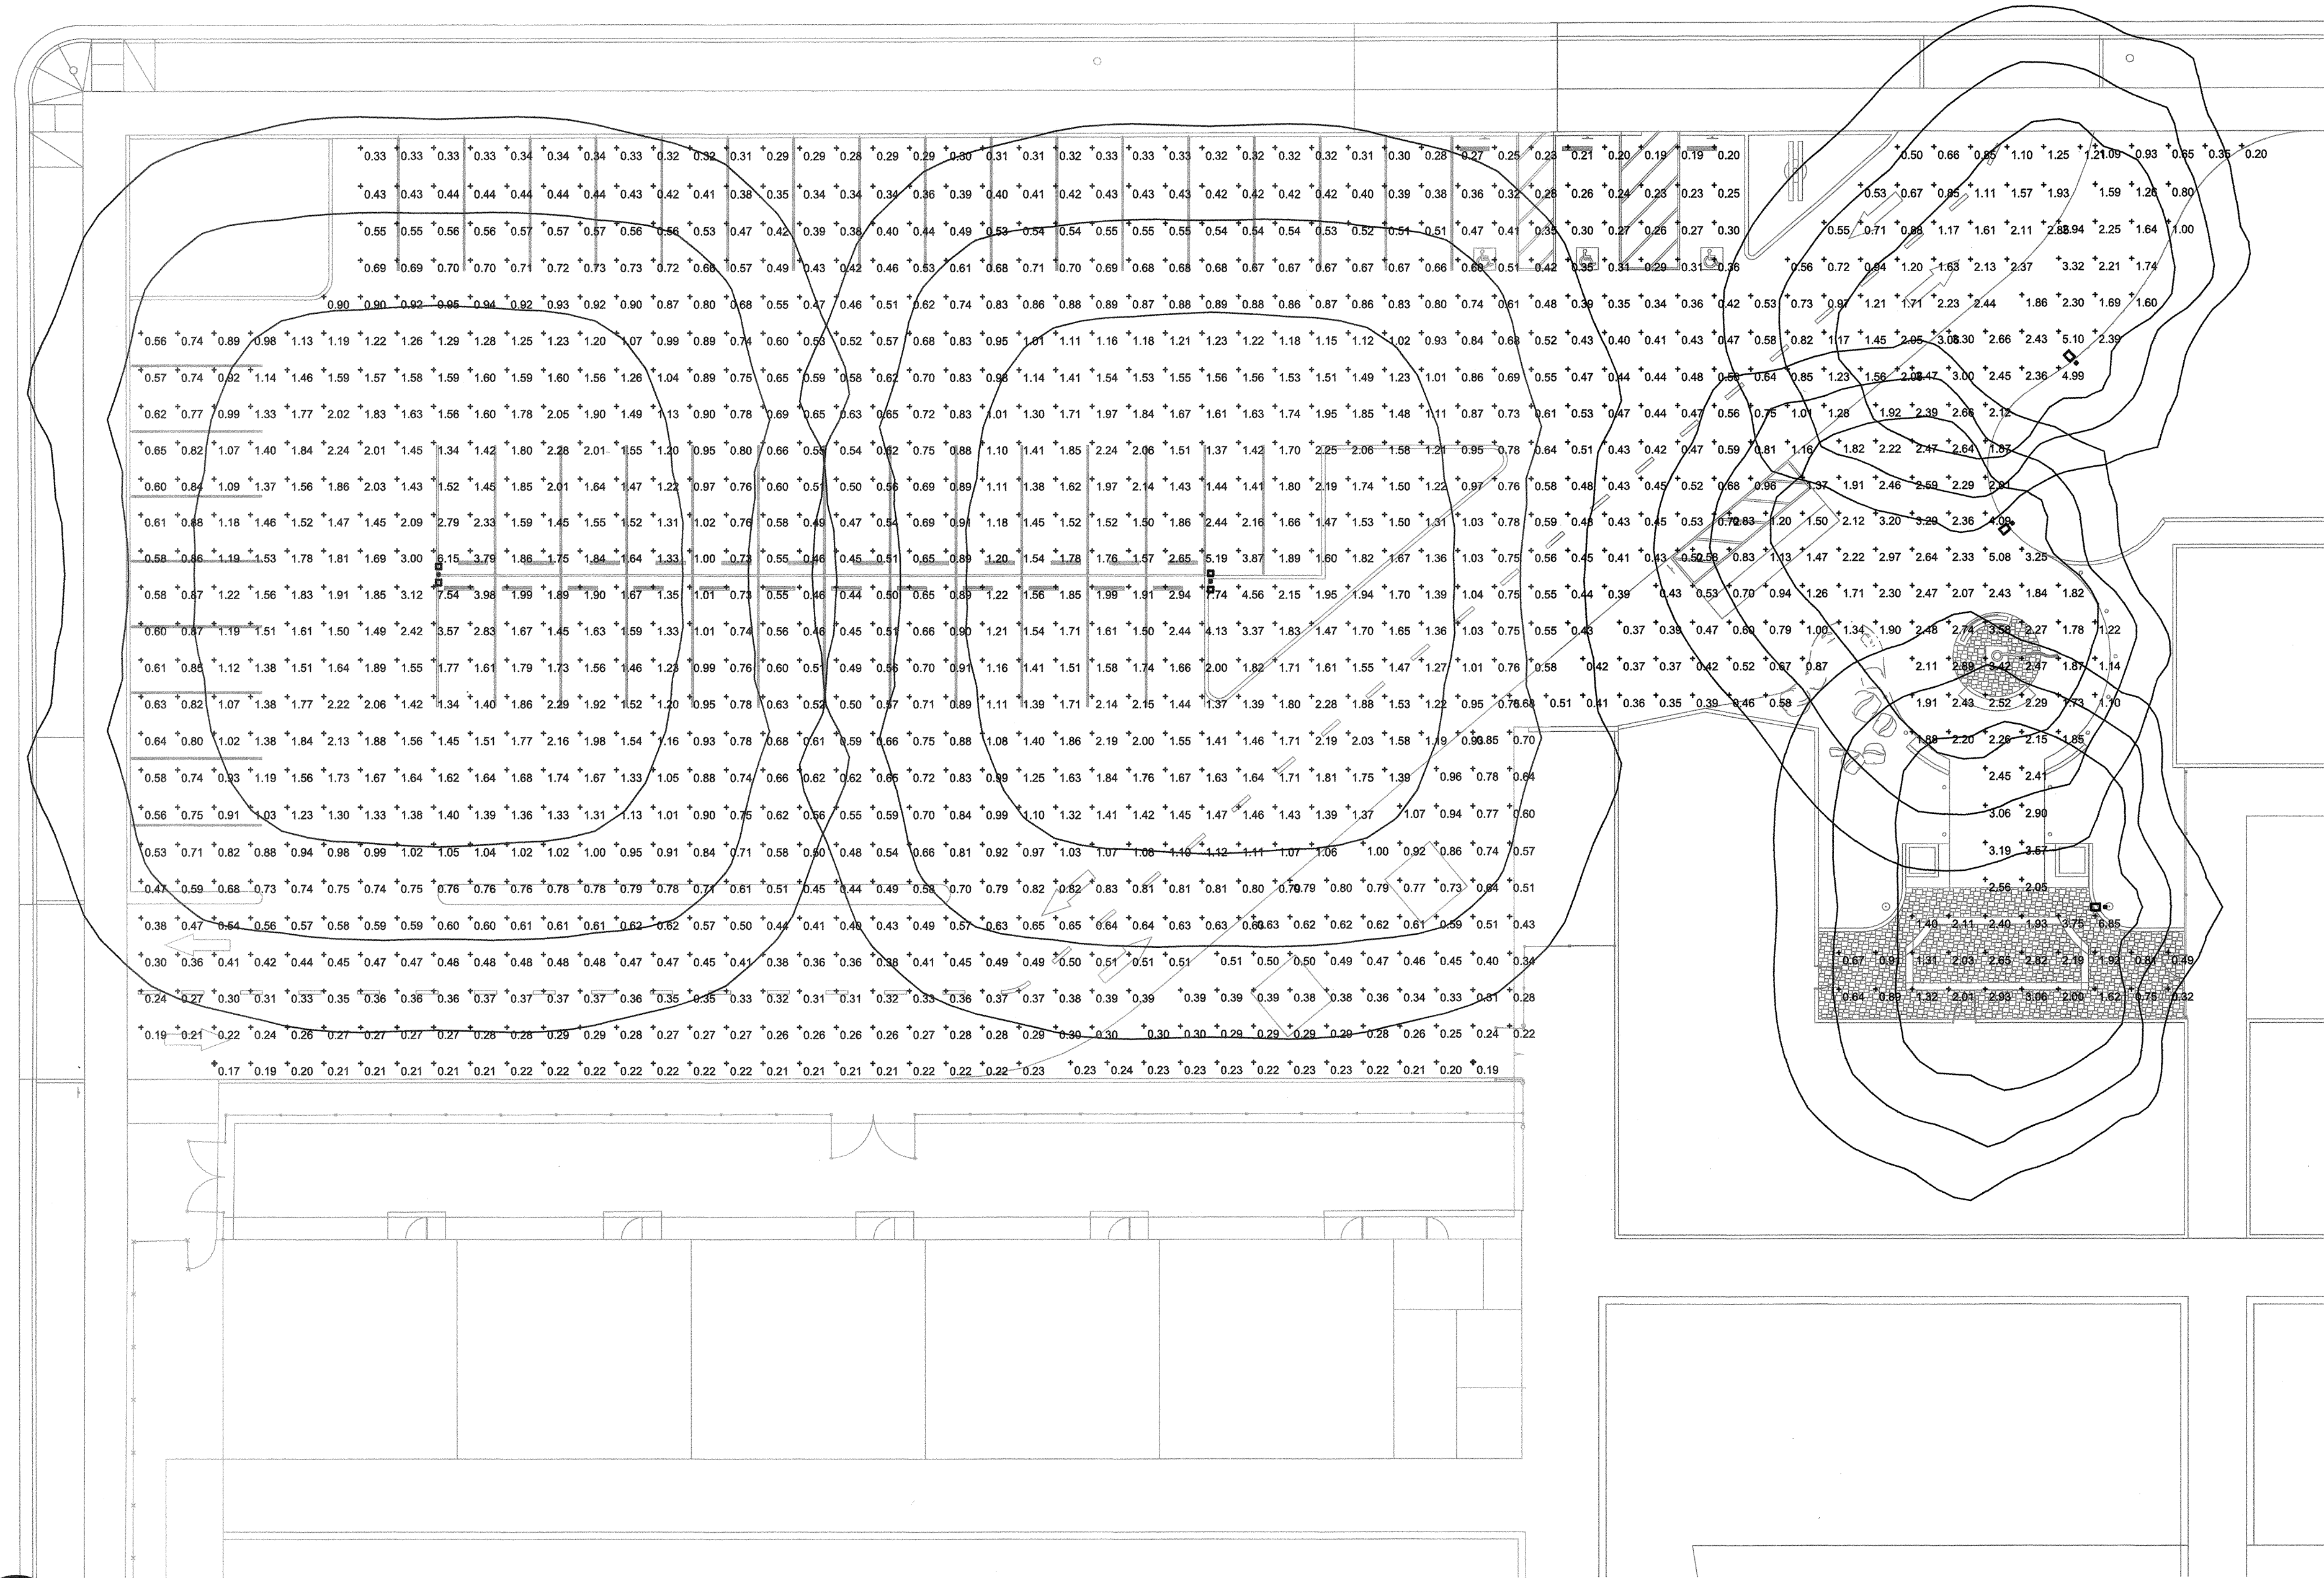

1 SITE PHOTOMETRIC PLAN
SCALE: 1"=16'-0"

PRIME CONSULTANT

IBI ARCHITECTURE PLANNING

San Luis Obispo
4119 Broad Street, Suite 210
San Luis Obispo, CA 93401
805.546.0433 fax: 805.546.0504
ibigroup.com

SEAL

COPYRIGHT:
Any reproduction or distribution for any purpose other than authorized by IBI Group is forbidden.

COPYRIGHT 2017 IBI GROUP

REVISIONS			
NO.	DATE	APPRD.	DESCRIPTION

CONSULTANT

FERRANTI ENGINEERING

C CONSULTING ELECTRICAL ENGINEERS
1211 MARICOPA HWY,
SUITE 250
OJAI, CA 93023
(805) 705-4772
DALEFERRANTI@LIVE.COM

AGENCY INFORMATION:

AGENCY TRACKING NO. 63321-241
FILE NO. 15-6

IDENTIFICATION STAMP
DIV. OF THE STATE ARCHITECT
OFFICE OF REGULATION SERVICES

03-118380
AC: FLS [Signature] SS: DL
DATE: OCT 25 2017

BAKERSFIELD CITY SCHOOL DISTRICT

BESSIE OWENS INTERMEDIATE RELOCATABLES A101 - A106

815 EUREKA ST. BAKERSFIELD CA, 93305

OPSC or OSHPD PROJ. NO.:	
PROJECT NO.:	16241.000
DRAWN BY:	VZ
CHKD BY:	DF
ISSUE DATE:	8/29/2017

SHEET TITLE

SITE PHOTOMETRIC PLAN

SHEET NUMBER

E2.5

CONSTRUCTION DOCUMENTS