




3 TYPICAL RELO CLASSROOM SIGNAL PLAN
NOT TO SCALE

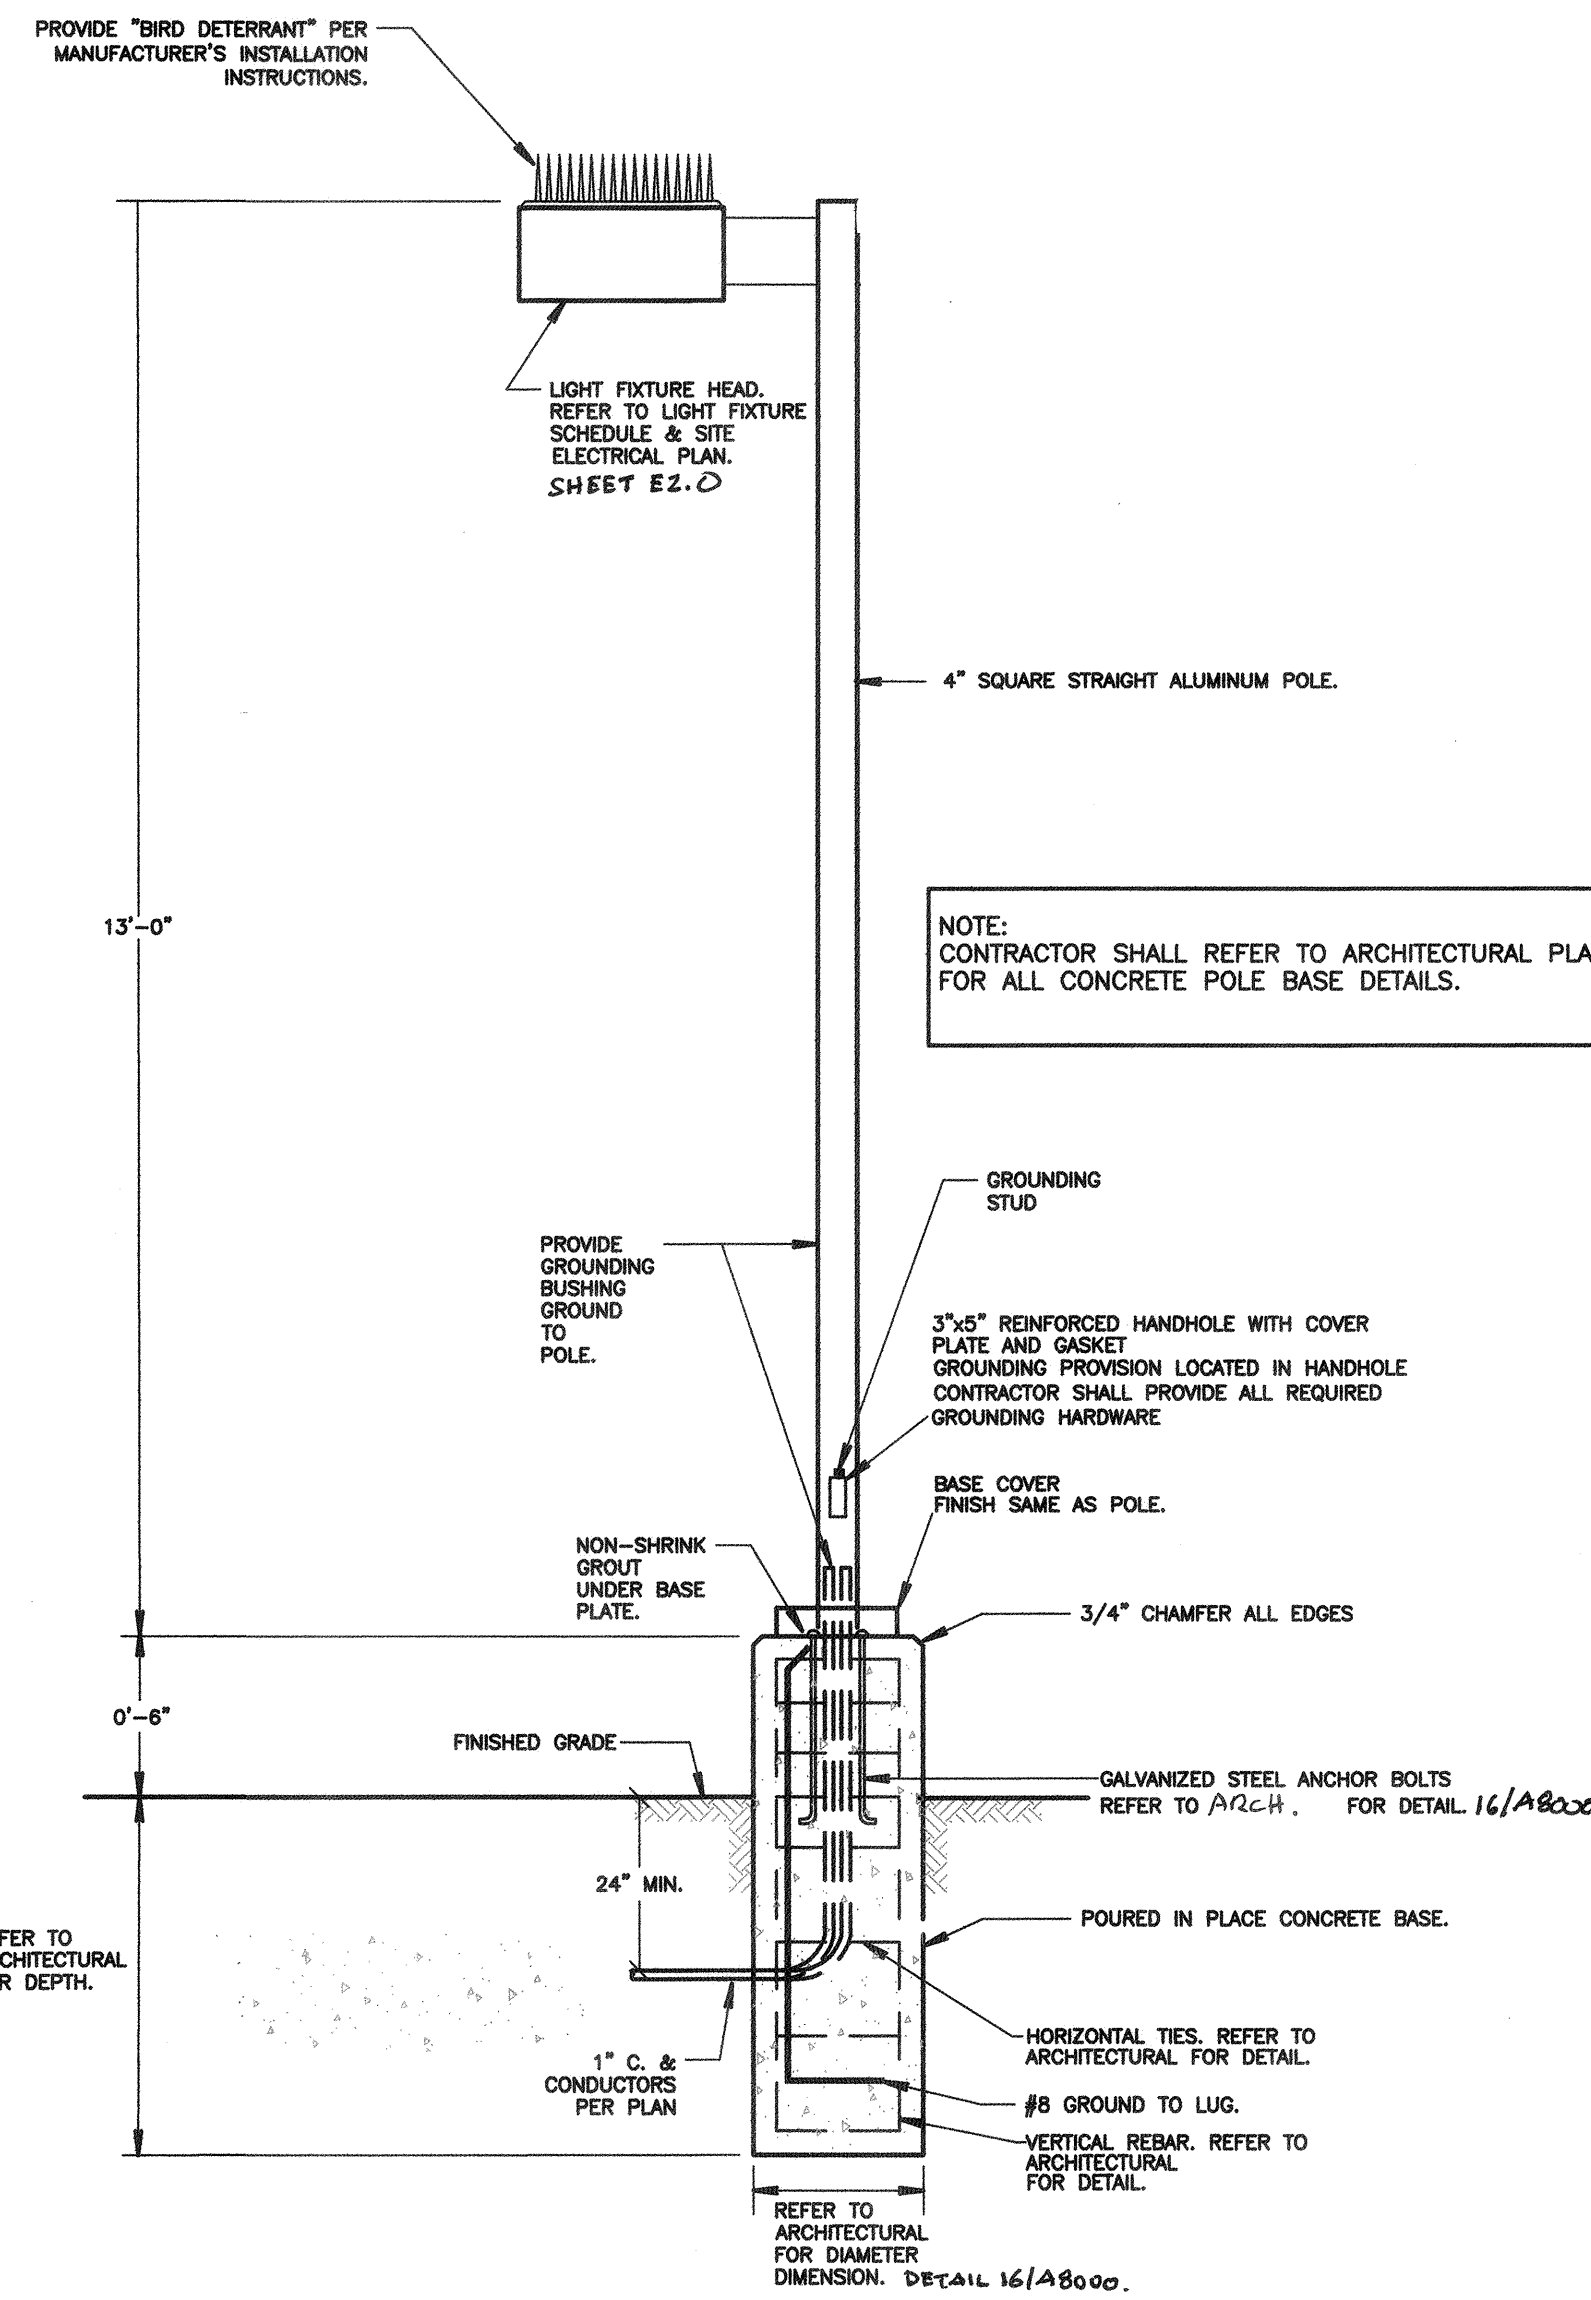

2 TYPICAL POLE LIGHT DETAIL (P3)
NOT TO SCALE
NOTE: NOT PART OF DSA APPROVAL AND REVIEW

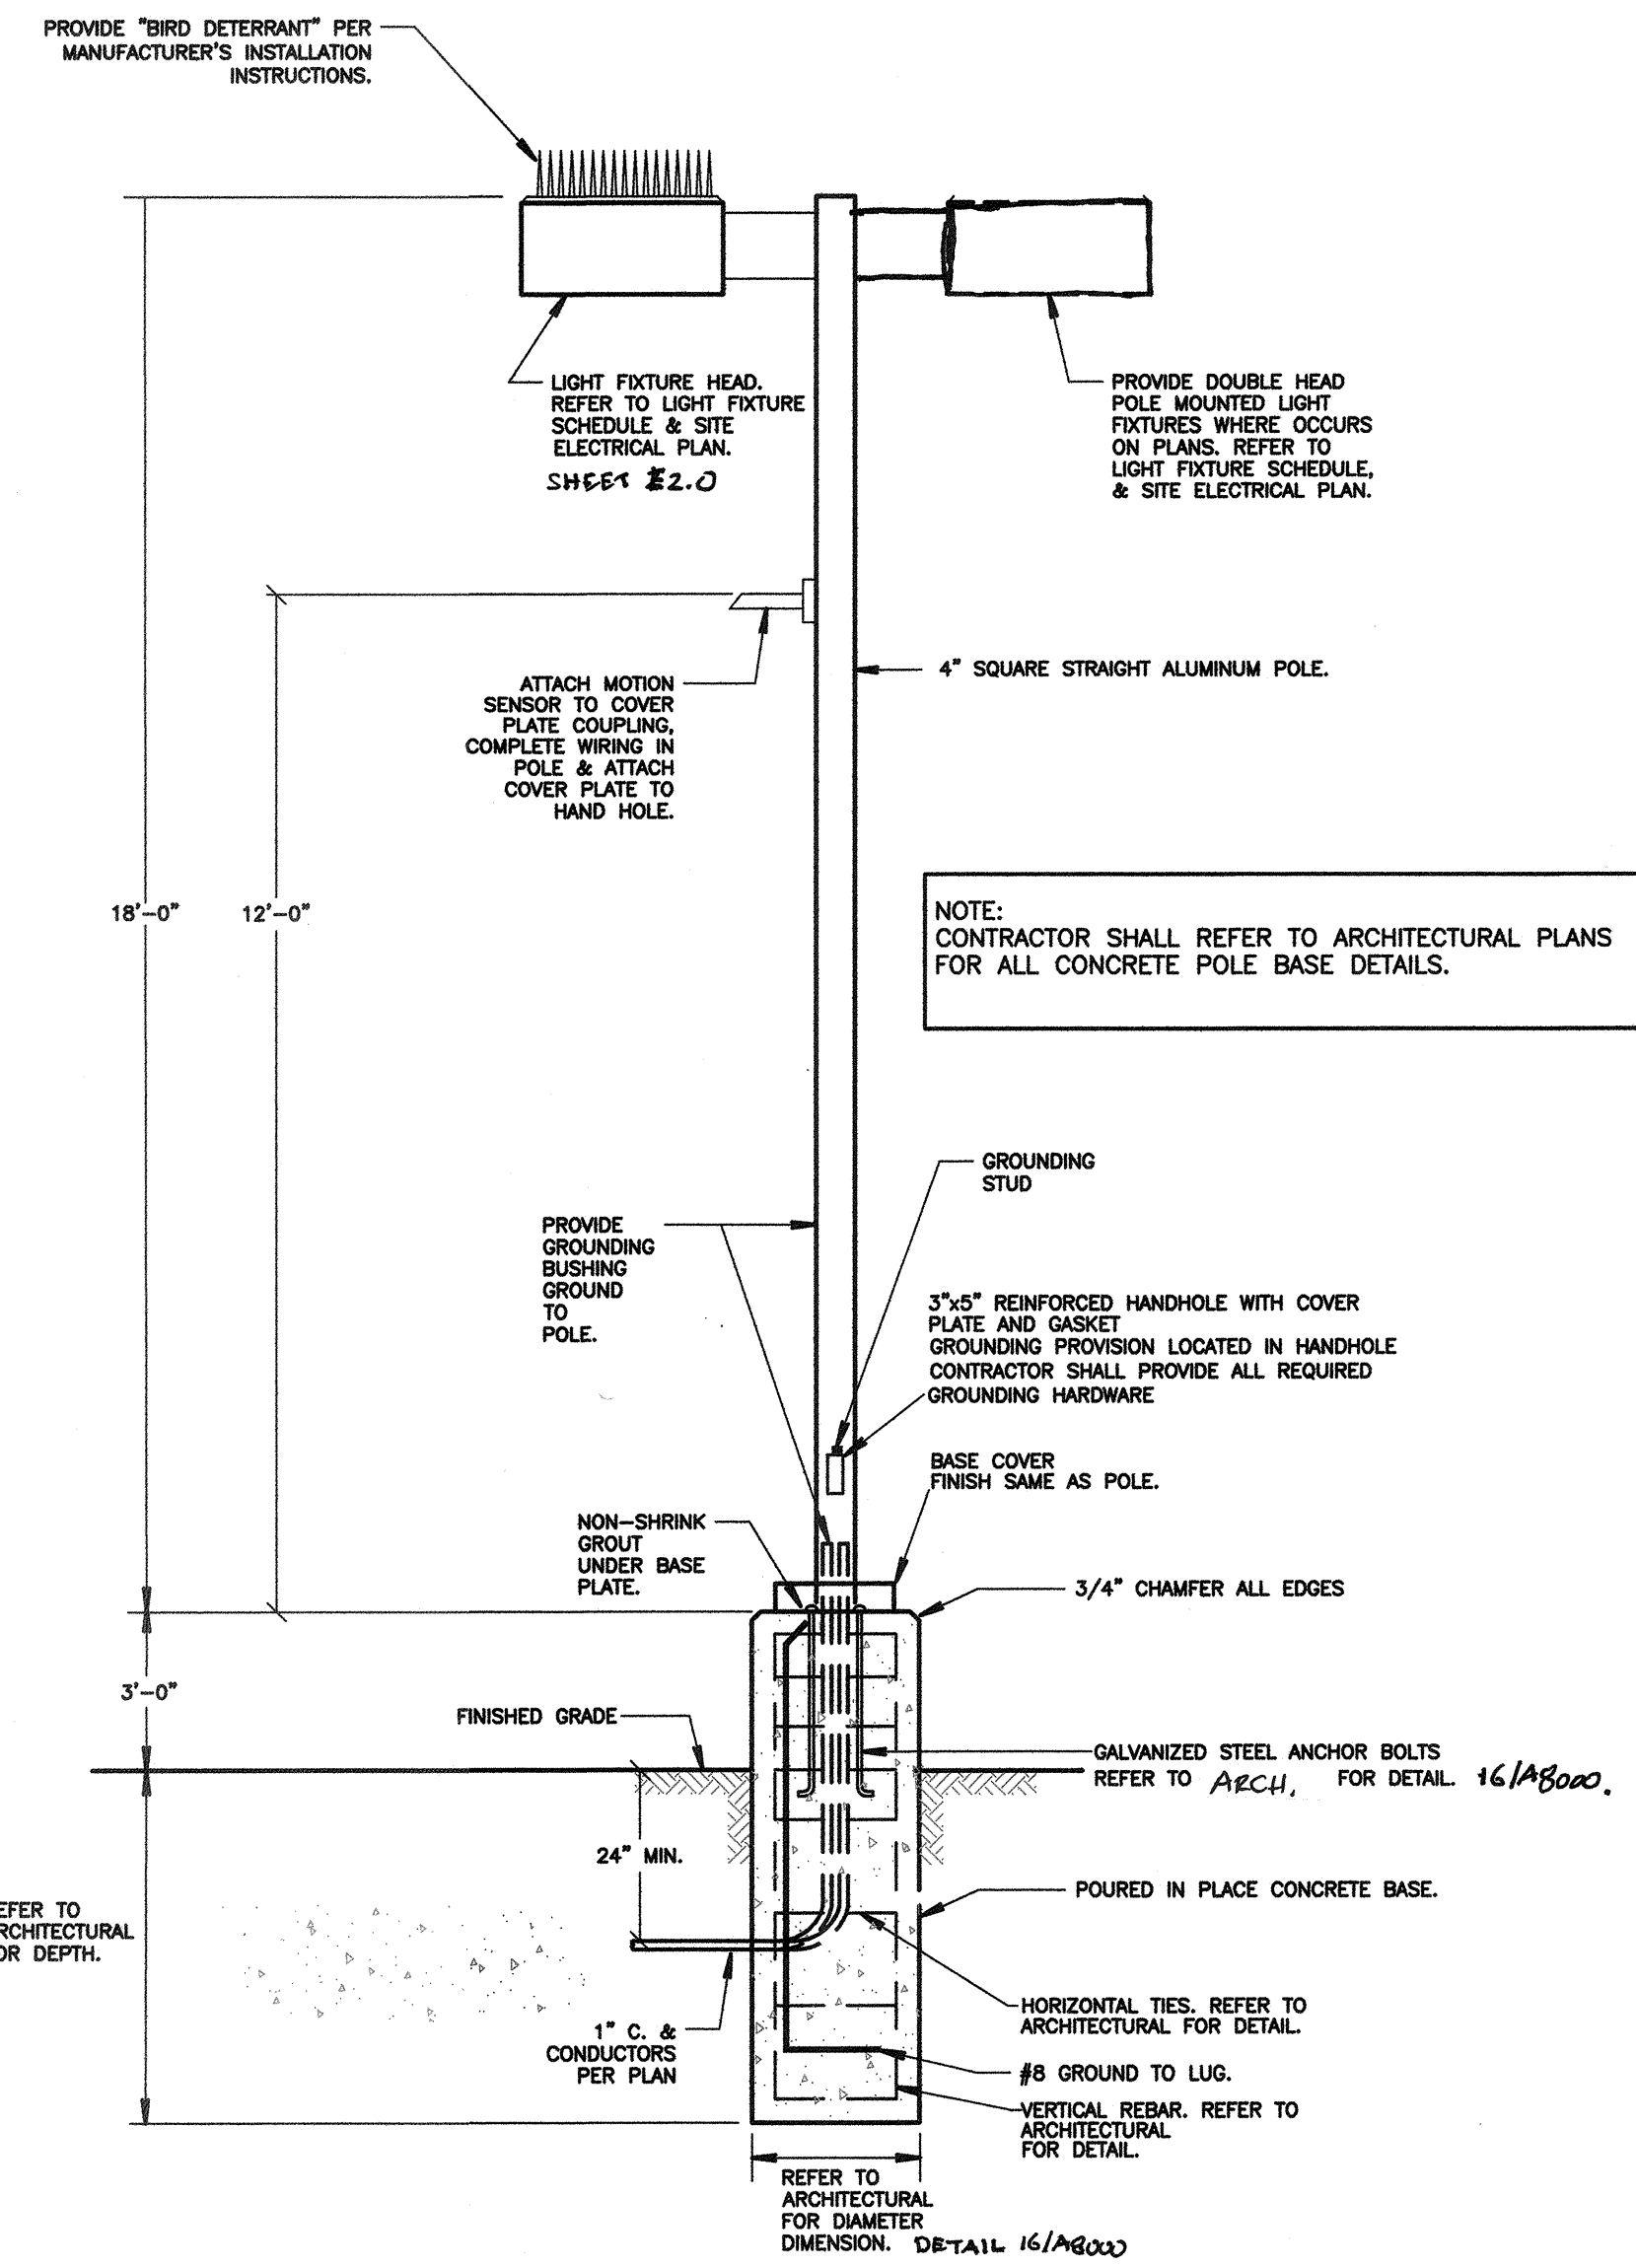

1 TYPICAL POLE LIGHT DETAIL (P2)
NOT TO SCALE
NOTE: NOT PART OF DSA APPROVAL AND REVIEW

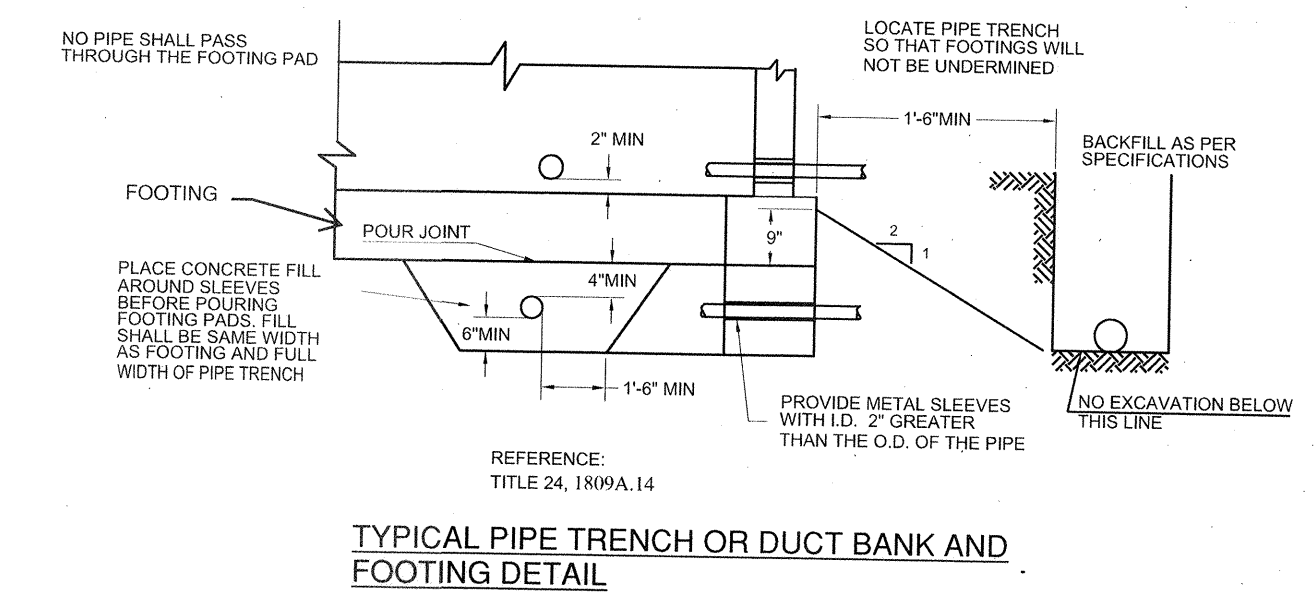

PRIME CONSULTANT
IBI ARCHITECTURE PLANNING
San Luis Obispo
4119 Broad Street, Suite 210
San Luis Obispo, CA 93401
805.546.0433 fax: 805.546.0504
ibigroup.com




COPYRIGHT:
Any reproduction or distribution for any purpose other than authorized by IBI Group is forbidden.
COPYRIGHT 2017 IBI GROUP

REVISIONS

NO.	DATE	APPRD.	DESCRIPTION

CONSULTANT
FERRANTI ENGINEERING
CONSULTING ELECTRICAL ENGINEERS
1211 MARICOPA HWY, SUITE 250
OJAI, CA 93023
(805) 705-4772
DALEFERRANTI@LIVE.COM

AGENCY INFORMATION:
AGENCY TRACKING NO. 63321-241
FILE NO. 15-6
IDENTIFICATION STAMP
DIV. OF THE STATE ARCHITECT
OFFICE OF REGULATION SERVICES
03-118980
AC FLS JES
DATE OCT 25 2017

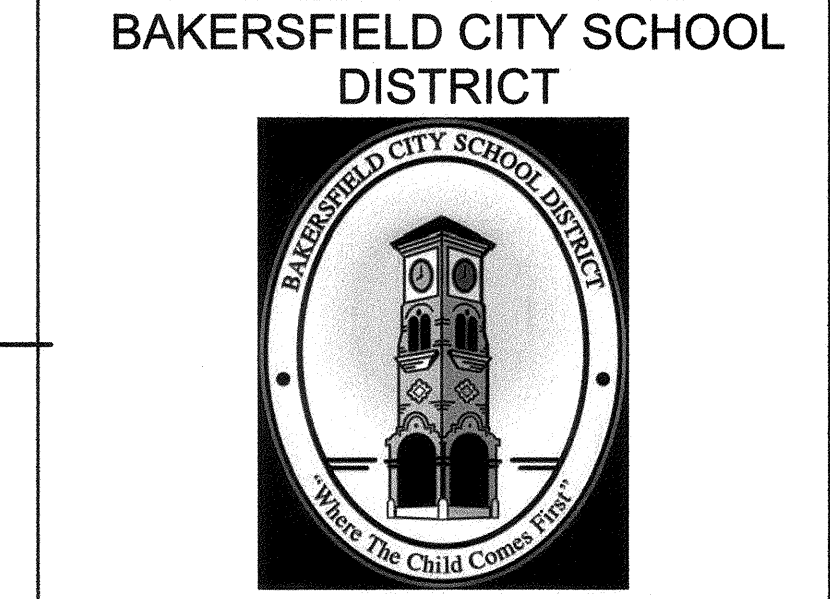

BESSIE OWENS INTERMEDIATE RELOCATABLES A101 - A106
815 EUREKA ST. BAKERSFIELD CA, 93305

OPSC or OSHPD PROJ. NO:
PROJECT NO: 16241.000
DRAWN BY: VZ
CHKD BY: DF
ISSUE DATE: 8/29/2017
SHEET TITLE

ELECTRICAL DETAILS

SHEET NUMBER
E6.0

CONSTRUCTION DOCUMENTS