



American Modular Systems

787 Spreckels Ave. Manteca, CA 95336
Phone (209) 826-1921 - Fax (209) 826-7018
americanmodular.com

MODULAR MANUFACTURER PROPRIETARY STATEMENT

THESE DRAWINGS AND THE MATERIAL CONTAINED THEREIN ARE THE PROPERTY OF AMERICAN MODULAR SYSTEMS, INC. (AMS) AND SHALL NOT BE REPRODUCED, COPIED OR OTHERWISE DISPOSED OF DIRECTLY OR INDIRECTLY AND SHALL NOT BE USED IN WHOLE OR IN PART TO ASSIST IN THE MAKING OF OR FOR THE PURPOSE OF FURNISHING ANY INFORMATION FOR THE MAKING OF DRAWINGS, PRINTS, APPARATUS OR PARTS THEREOF WITHOUT THE FULL KNOWLEDGE AND WRITTEN CONSENT OF AMS. ALL PATENTABLE MATERIAL CONTAINED HEREIN AND ORIGINATING WITH AMS SHALL BE THE SOLE PROPERTY OF AMS.

PRE-CHECKED SET NAME

24' x 40' THRU 120' x 40'
2:12 PITCHED ROOF


SITE SPECIFIC PROJECT NAME

STOCKPILE
(1) 60x40 BUILDING
(1) 72x40 BUILDING


SHEET TITLE

RESTROOM OPTIONS
PLUMBING PLANS
& FIXTURE SCHEDULE


MANUFACTURER PROFESSIONAL OF RECORD, ON PC

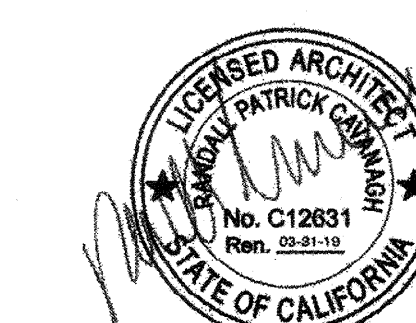

AGENCY TRACKING NO. 63321-241
FILE NO. 15-6

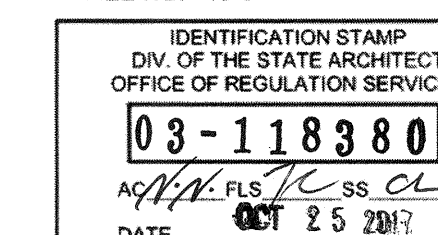

PROJECT SPECIFIC STATE AGENCY APPROVAL

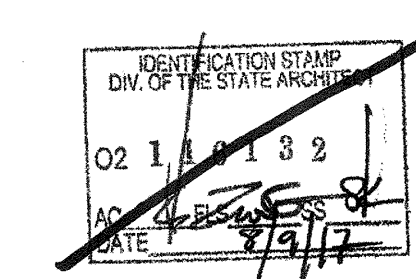

ORIGINAL PC STATE AGENCY APPROVAL

BASED ON PC# 02-113939

PRE-CHECK (PC) DOCUMENT - CODE: 2013 CBC
A SEPARATE PROJECT APPLICATION FOR CONSTRUCTION IS REQUIRED

REVISIONS	


DRAWN BY: BA
SCALE: AS NOTED
DATE: 04/27/17
SHEET NUMBER

P1.0

MARK	FIXTURE*	DESCRIPTION	REMARKS
WC 1		WALL MOUNT FLUSH VALVE TYPE KOHLER "KINGSTON" MODEL K-4330 OR EQUAL W/BEMIS #1955C SEAT	FLUSH VALVE, SLOAN REGAL FLUSHOMETER #111 OR EQUAL. LOCATE AS SPECIFIED ON FLOOR PLANS. MOUNT ACCESSIBLE FIXTURES PER SCHEDULE 7/P2.0.
WC 2		FLOOR MOUNT FLUSH VALVE TYPE KOHLER "HIGHLINE" MODEL K-4405 OR EQUAL W/BEMIS #1955C SEAT	FLUSH VALVE, SLOAN REGAL FLUSHOMETER #111 OR EQUAL. LOCATE AS SPECIFIED ON FLOOR PLANS. MOUNT ACCESSIBLE FIXTURES PER SCHEDULE 7/P2.0.
L 1		"KOHLER" HUDSON #K-2861 WITH CHICAGO 3400-CP FAUCETS	MOUNT AS SPECIFIED IN FLOOR PLANS. MOUNT ACCESSIBLE FIXTURES PER SCHEDULE 7/P2.0
L 2		"KOHLER" HUDSON #K-2861 WITH CHICAGO 3300-CP FAUCETS	MOUNT AS SPECIFIED IN FLOOR PLANS. MOUNT ACCESSIBLE FIXTURES PER SCHEDULE 7/P2.0
M 1		WALL MOUNT TYPE BOBRICK STAINLESS STEEL CHANNEL FRAME MIRROR MODEL B-165 OR EQUAL	MOUNT AS SPECIFIED IN FLOOR PLANS. MOUNT ACCESSIBLE MIRROR PER SCHEDULE 7/P2.0
M 2		WALL MOUNT TYPE BOBRICK FRAMELESS STAINLESS STEEL MIRROR MODEL B-1556 OR EQUAL	MOUNT AS SPECIFIED IN FLOOR PLANS. MOUNT ACCESSIBLE MIRROR PER SCHEDULE 7/P2.0
GB 1		36" GRAB BARS	18 GA. 304 STAINLESS STEEL SATIN FINISH MOUNT AS SPECIFIED IN FLOOR PLANS AND PER SCHEDULE 7/P2.0. (STRUCTURAL STRENGTH OF GRAB BARS 250# MIN.)
GB 2		42" GRAB BARS	
WH 1		WATER HEATER	RHEEMGLAS ENERGY MISER ELECTRIC WATER HEATER RHEEM POINT OF USE MODEL PROE6 1 RH POU OR EQUAL
FV 1		FLUSH VALVE	FLUSH VALVE, SLOAN REGAL FLUSHOMETER #111 OR EQUAL. LOCATE AS SPECIFIED ON FLOOR PLANS. MOUNT ACCESSIBLE FIXTURES PER SCHEDULE 7/P2.0.
FV 2		FLUSH VALVE	ZURN FLUSH VALVE MODEL EXPOSED Z6003AV FOR URINALS OR EQUAL
CS 1		CLASSROOM SINK	"ROC" SINGLE BOWL SINK OR EQUAL W/ZURN AQUA SPEC 871 FAUCET & HALSEY TAYLOR HT 2507 BUBBLER
UR 1		URINAL	KOHLER MODEL "DEXTER" K-5076-ET OR EQUAL
FD 2		FLOOR DRAIN	CONCRETE FLOOR DRAIN ZURN MODEL P415-CC W/STANDARD GRATE ZURN 33160-002 OR EQUAL

*ALL WATER FIXTURES MUST MEET REQUIREMENTS OF CAL-GREEN TITLE 24, PART 11, SECTION 5.303.3 "WATER CONSERVING PLUMBING FIXTURES & SETTINGS".

** INSTALL WATER CLOSET WITH JR. SMITH WALL CARRIER AND WALL CARRIER TO CONCRETE FLOOR WITH (1) 1/2" ANCHOR BOLT AT EACH SIDE WITH 2" MINIMUM EMBEDMENT INTO CONCRETE.

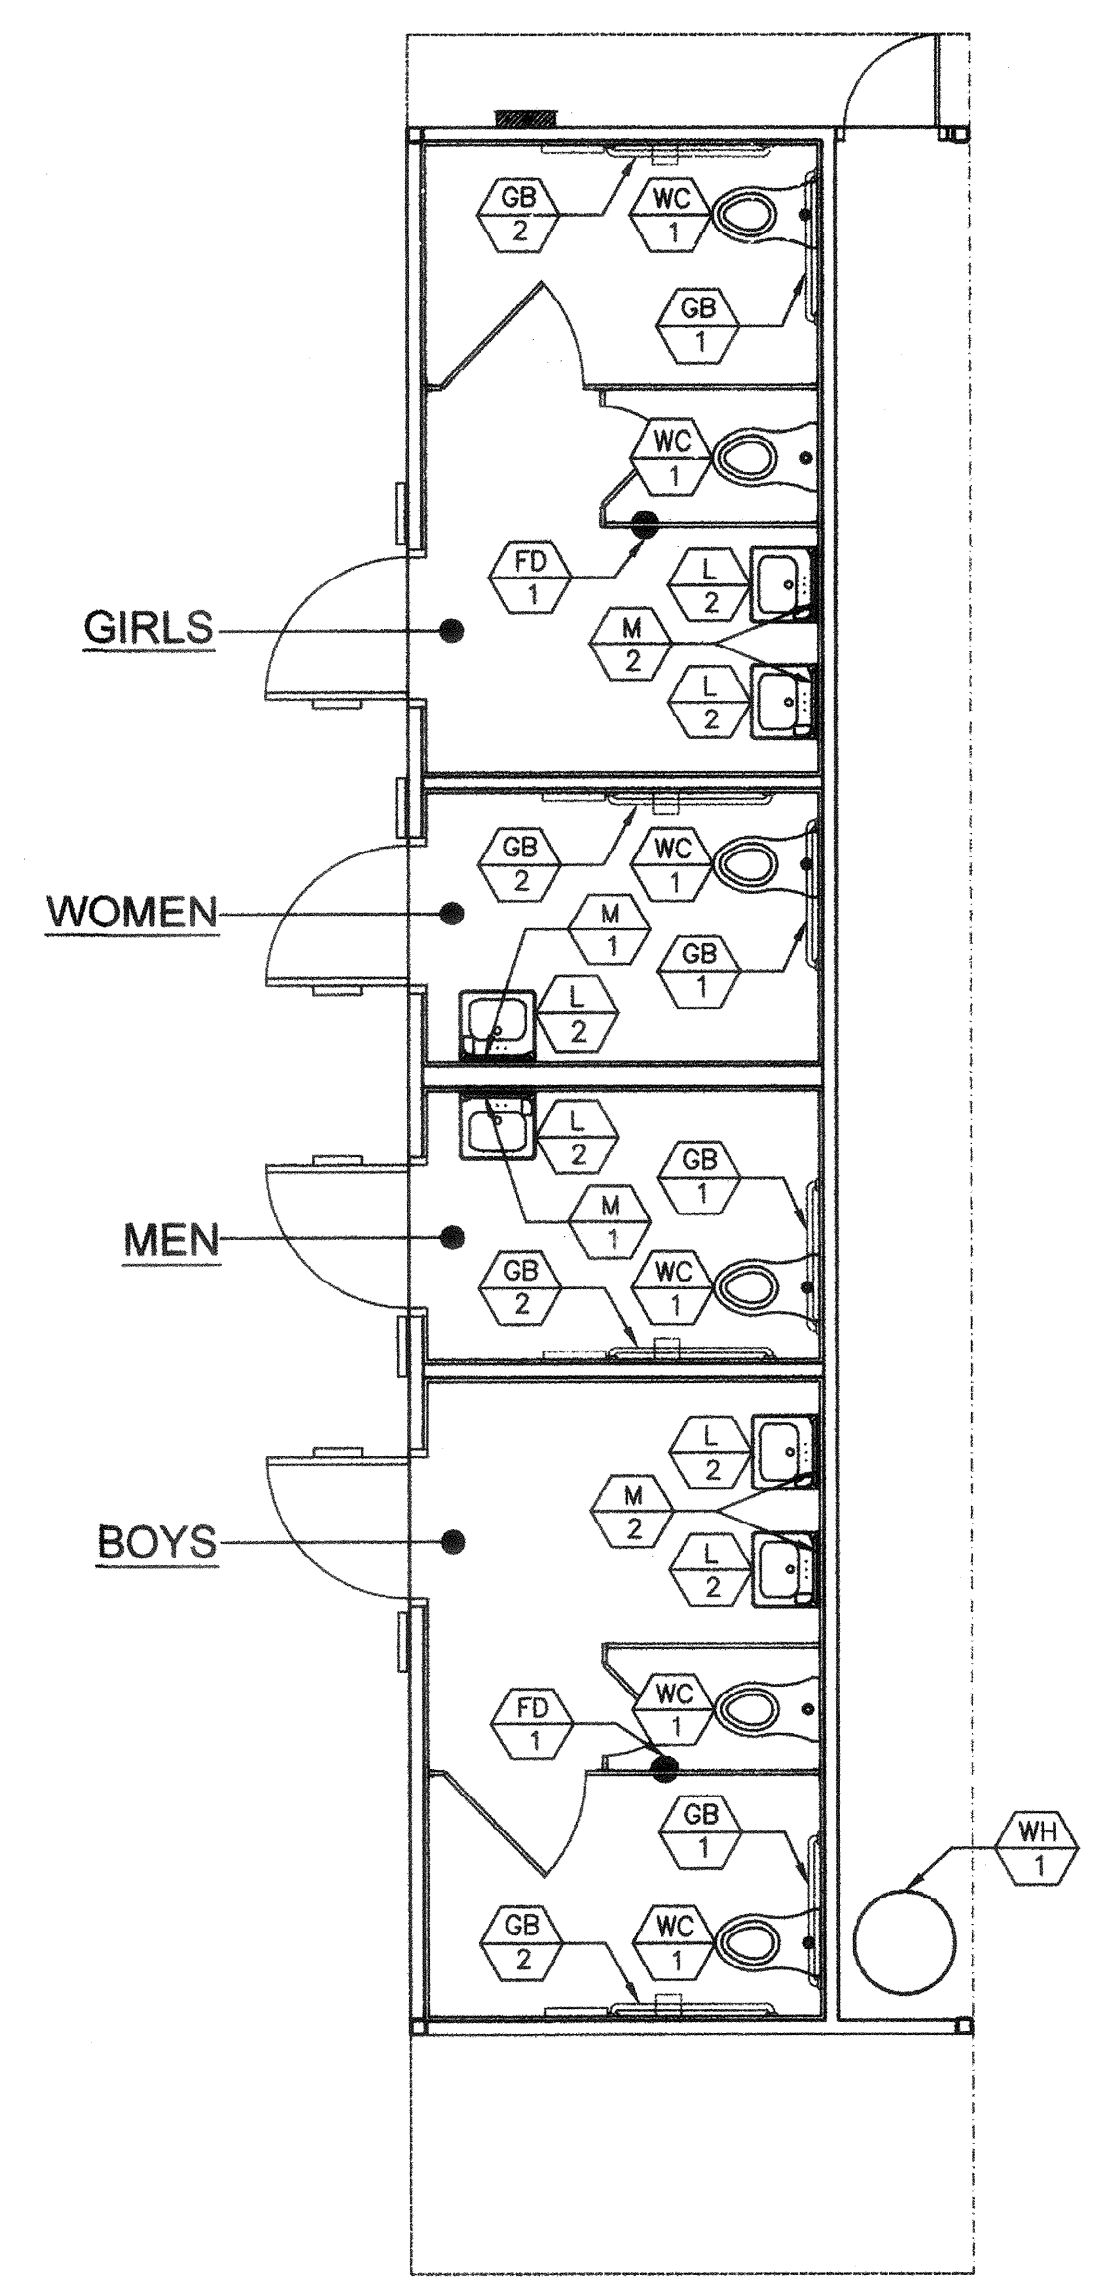

NOT USED 1 GIRLS, WOMEN, MEN & BOYS R.R. PLAN SCALE: 1/4"=1'-0"

2 PLUMBING FIXTURE SCHEDULE

NOT USED 3 TYP. CLASSROOM SINK(S) SCALE: 1/4"=1'-0"

4 NOT USED

5 NOT USED

6 NOT USED

