

UNIT E PLUMBING & MECHANICAL PLAN 1/4"



PLUMBING FIXTURE SCHEDULE

REGISTERS SHALL BE ANONIMOUS SIZE THROW AND C.F.M. AS SHOWN ON DRAWINGS AND AS FOLLOWS

MARK	FIXTURE	S/W	TRAP	V	CM	INH	MANUFACTURER AND CATALOG NUMBER
16	WATER CLOSET	4	2	1	1/4		AM STD 2242-012 "TRITION" SIKAM FLOOR, 012-3 WHITE SEAT
17	LAVATORY	2	1	1/2	1/2	3/4	AM STD 4489-012 "REVALN" 1947 CHROME STAINLESS LEMON HANDLE FAUCET 1/2 LA CP P-TBAP, L.K. STOP
18	LAVATORY	2	1	1/2	1/2	3/4	AM STD 4489-012 "REVALN" 1947 CHROME STAINLESS LEMON HANDLE FAUCET 1/2 LA CP P-TBAP, L.K. STOP
19	LAVATORY	2	1	1/2	1/2	3/4	AM STD 4489-012 "REVALN" 1947 CHROME STAINLESS LEMON HANDLE FAUCET 1/2 LA CP P-TBAP, L.K. STOP
20	RESTROOM SINK	2	1	1/2	1/2	3/4	AM STD 4489-012 "REVALN" 1947 CHROME STAINLESS LEMON HANDLE FAUCET 1/2 LA CP P-TBAP, L.K. STOP
21	RESTROOM SINK	2	1	1/2	1/2	3/4	AM STD 4489-012 "REVALN" 1947 CHROME STAINLESS LEMON HANDLE FAUCET 1/2 LA CP P-TBAP, L.K. STOP
22	SINK	2	1	1/2	1/2	3/4	AM STD 4489-012 "REVALN" 1947 CHROME STAINLESS LEMON HANDLE FAUCET 1/2 LA CP P-TBAP, L.K. STOP

REGISTER SCHEDULE


MARK	CATALOG NUMBER	TYPE	PANEL SIZE	REMARKS
RR-1	SPOLD	T-BAR	24x24	
RR-2	SPOLD	T-BAR	24x24	
RR-3	SPOLD	T-BAR	24x24	
RR-4	SPOLD	T-BAR	48x24	

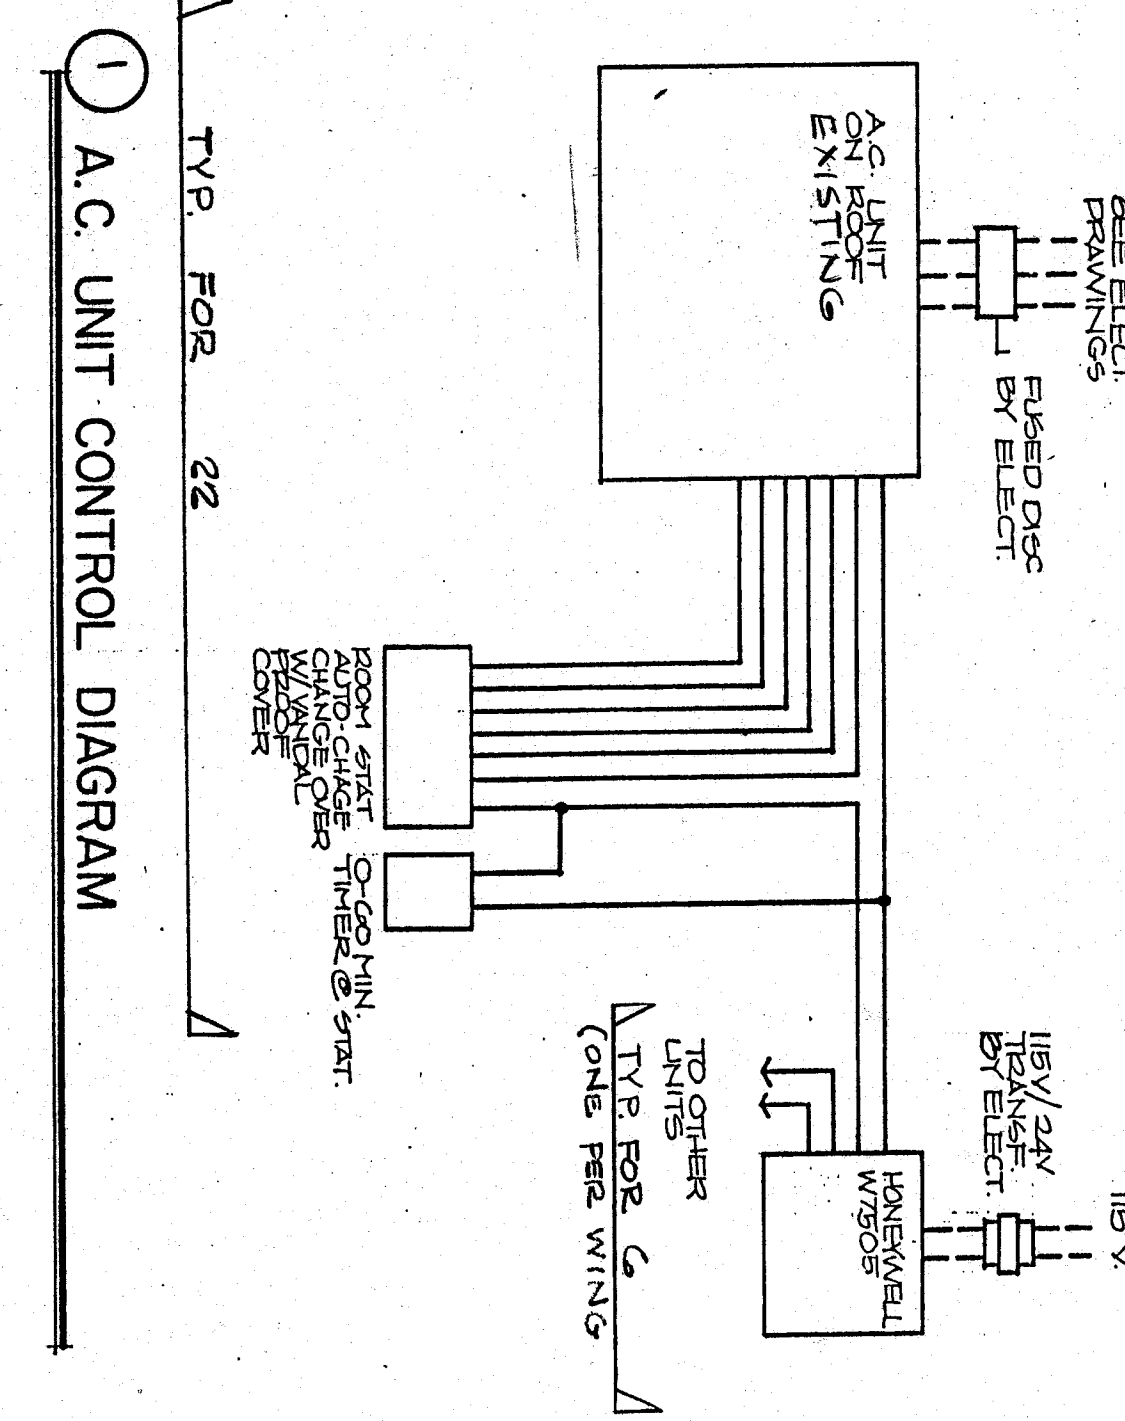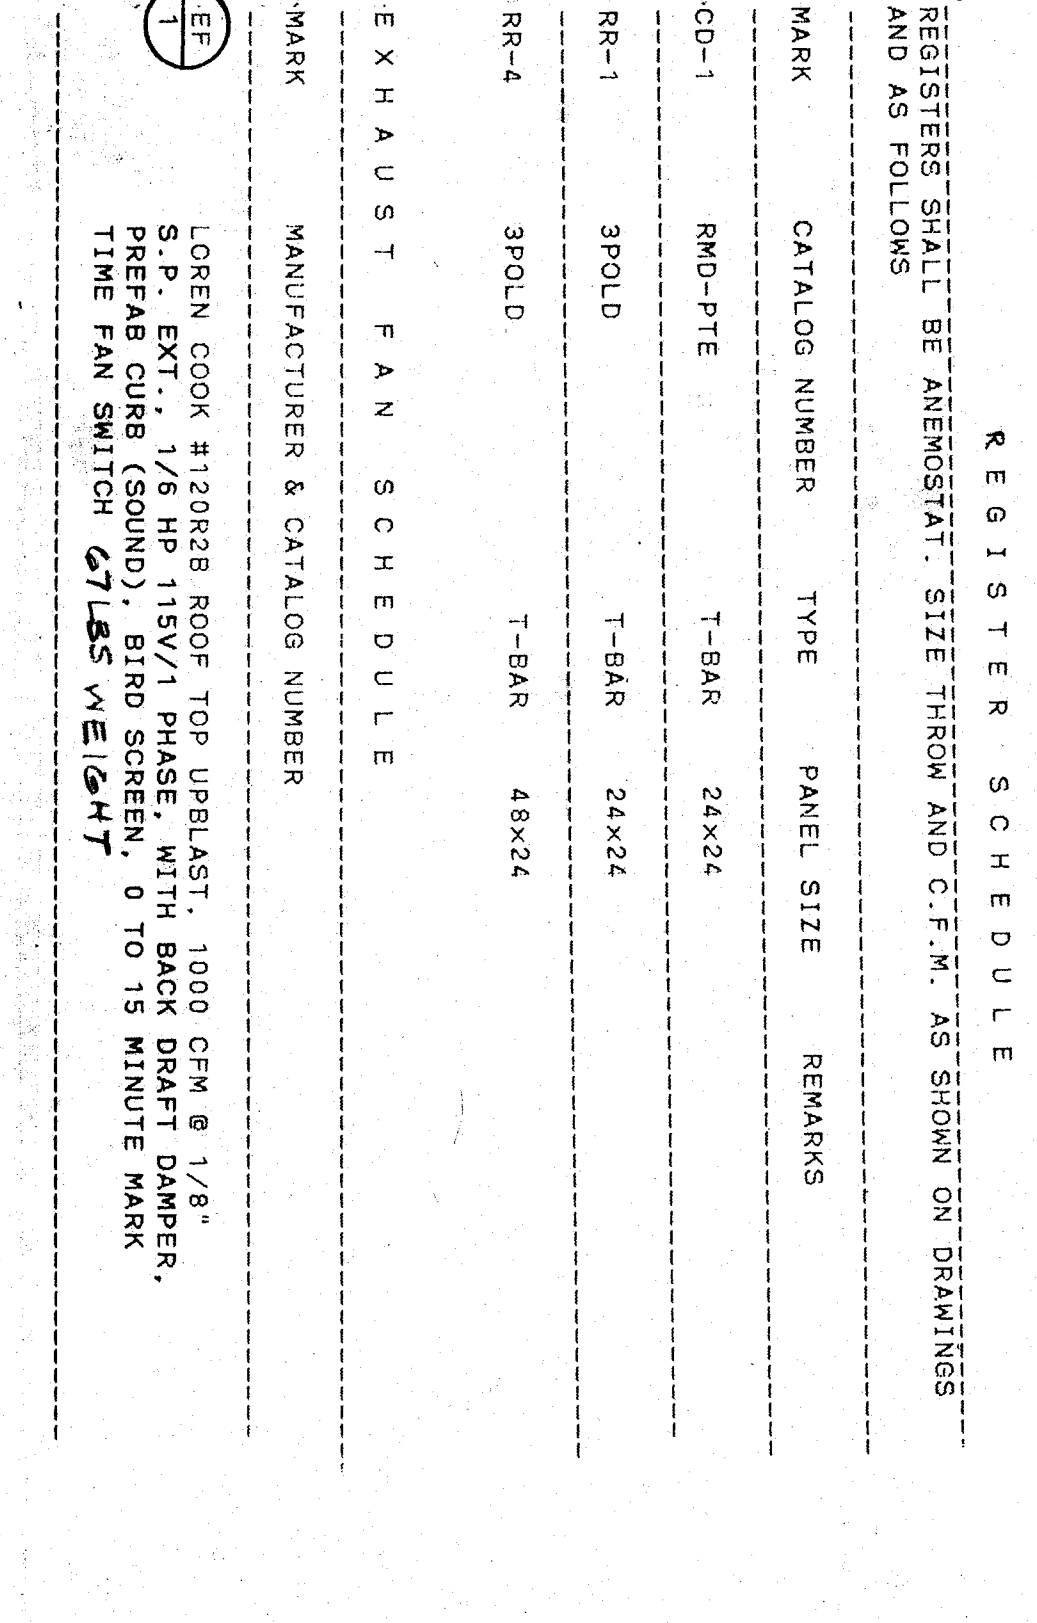

EXHAUST FAN SCHEDULE

MARK MANUFACTURER & CATALOG NUMBER

LOREN COOK #120K28 ROOF TOP UPBLAST 1000 CFM @ 1/8"  
SFP EXTRACTS 1/8 HR 115V/1 PHASE WITH BACK DRAFT DAMPER,  
SERIAL # 376201110 (120K28K210) STAINLESS  
TIME FAN SWITCH 07165 WELCHT

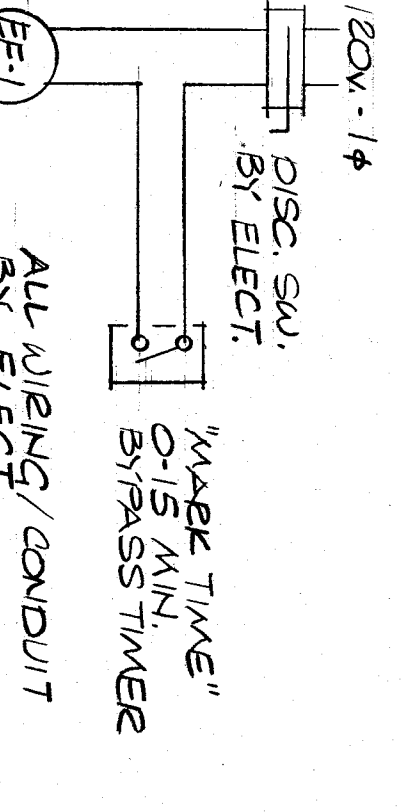

ROBERT F. STUHR ARCHITECT INC.

3121 CALIFORNIA AVE  
BAKERS FIELD, CA 93304  
(805) 327-1632

ROBERT F. STUHR AIA C-1610  
WILLIAM J. MELBY AIA C-18835  
DANN E. ORDIZ AIA C-14728

UNIT E PLUMBING & MECHANICAL PLAN  
PLUMBING FIXTURE & MECH. EQPT. SCHEDULES

VISTA EAST CONTINUATION HIGH SCHOOL 30 YEAR MODERNIZATION

815 EUREKA STREET  
KERN HIGH SCHOOL DISTRICT  
KERN COUNTY, CALIFORNIA

BIRD & MOORE & ASSOCIATE  
CONSULTING MECHANICAL ENGINEER  
SHERWOOD AVE., BOX 233 890  
WHEELER STATION  
CALIFORNIA, NO. M. 9830

CHECK AND VERIFY ALL DIMENSIONS AND WORK WITH THE ARCHITECT. REPORT ALL DISCREPANCIES TO THE ARCHITECT IMMEDIATELY. SHALL BE THE RESPONSIBILITY OF THE ARCHITECT.

MARK	DATE	REVISIONS
▲		
▲		
▲		

JOB NO. 707  
DRAWN: [Signature]  
CHECKED: [Signature]  
DATE: 07-14-90

OF 4 SHEETS