


SEAL

COPYRIGHT:
Any reproduction or distribution for any purpose other than authorized by IBI Group is forbidden.

COPYRIGHT 2019 IBI GROUP

REVISIONS			
NO.	DATE SUBMITTED	DATE APPROVED	DESCRIPTION

CONSULTANT
FERRANTI ENGINEERING
CONSULTING ELECTRICAL ENGINEERS
1211 MARICOPA HWY,
SUITE 250
OJAI, CA 93023
(805) 705-4772
DALE.FERRANTI@LIVE.COM

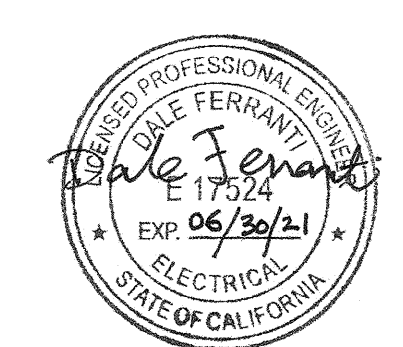

PRIME CONSULTANT
IBI ARCHITECTURE PLANNING
San Luis Obispo
4119 Broad Street, Suite 210
San Luis Obispo, CA 93401
805.546.0433
Fax: 805.546.0504
ibigroup.com

BAKERSFIELD CITY SCHOOL DISTRICT



BESSIE OWENS E.S. KINDERGARTEN MODULAR BUILDINGS
815 POTOMAC AVE, BAKERSFIELD, CA 93307


OPSC or OSHPD PROJ. NO. N/A
PROJECT NO: 118932
DRAWN BY: V.Z.
CHKD BY: D.F.
ISSUE DATE: 10/29/2019
SHEET TITLE

FIRE ALARM RISER DIAGRAM

SHEET NUMBER

E302

CONSTRUCTION DOCUMENTS

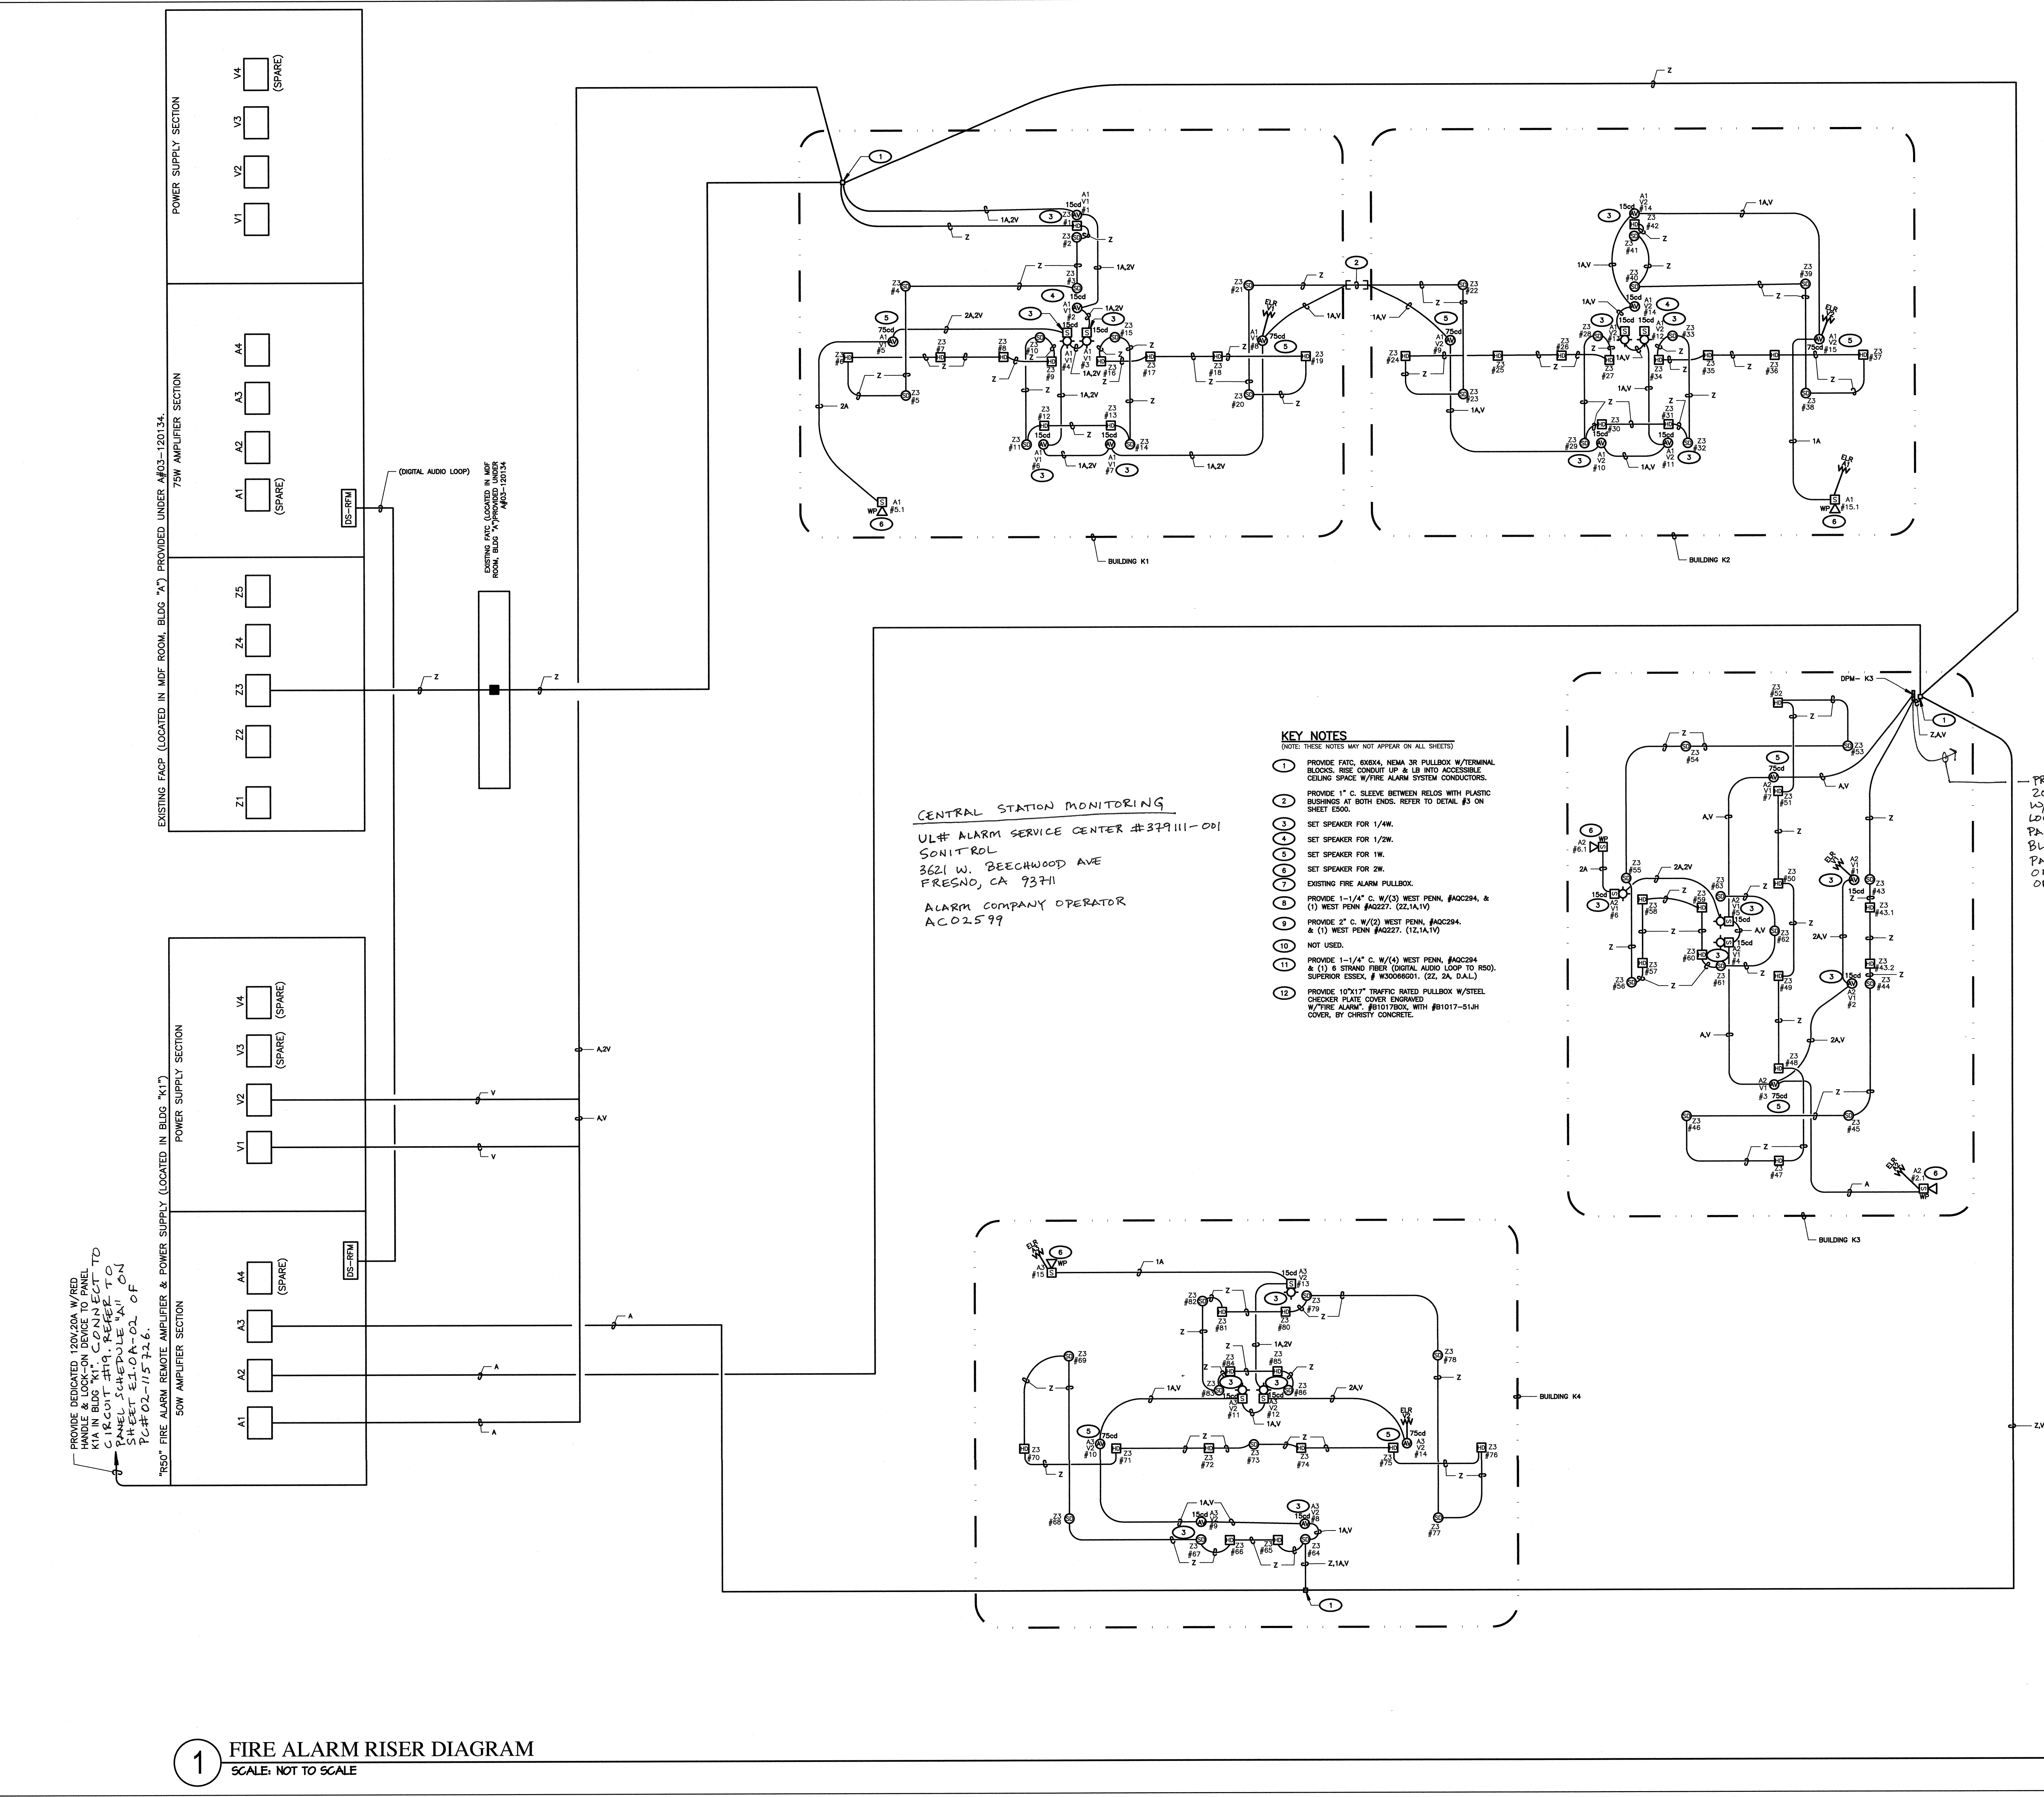

1 FIRE ALARM RISER DIAGRAM
SCALE: NOT TO SCALE