

INTELLECTUAL PROPERTY & PROPRIETARY RIGHTS STATEMENT  
COPYRIGHT TO AMERICAN MODULAR SYSTEMS (AMS)  
AMS OWNS ALL COPYRIGHT AND OTHER INTELLECTUAL-PROPERTY AND PROPRIETARY RIGHTS IN THESE DRAWINGS, SPECIFICATIONS, AND THE MATERIAL CONTAINED HEREIN. THESE DRAWINGS, SPECIFICATIONS, AND THE MATERIAL CONTAINED HEREIN MAY NOT BE REPRODUCED, COPIED, DISTRIBUTED, MODIFIED, OR OTHERWISE DISPOSED OF (DIRECTLY OR INDIRECTLY) AND MAY NOT BE USED (IN WHOLE OR IN PART) TO ASSIST IN THE MAKING OF, OR FOR THE PURPOSE OF FURNISHING ANY INFORMATION FOR THE MAKING OF, ANY BUILDINGS MODULAR OR OTHERWISE), DRAWINGS, SPECIFICATIONS, PRINTS, APPARATUS, OR PARTS THEREOF, EXCEPT AS EXPRESSLY PERMITTED BY WRITTEN CONSENT OF, OR IN A WRITTEN AGREEMENT WITH, AMS.


PRE-CHECKED SET NAME  
24'x40' THRU 120'x40'  
HIGH PITCH MODULAR  
BUILDINGS

SITE SPECIFIC PROJECT NAME

SHEET TITLE


ENERGY CALCULATIONS

MANUFACTURER PROFESSIONAL OF RECORD ON PC

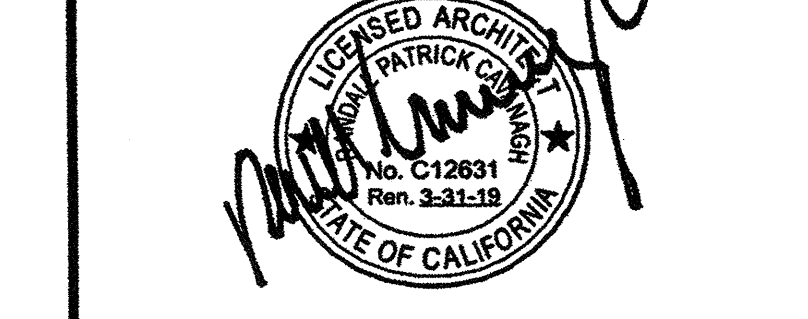


THESE DRAWINGS ARE PRELIMINARY AND NOT FOR CONSTRUCTION UNLESS STAMPED & SIGNED BY THE ENGINEER OF RECORD.

PROJECT SPECIFIC STATE AGENCY APPROVAL

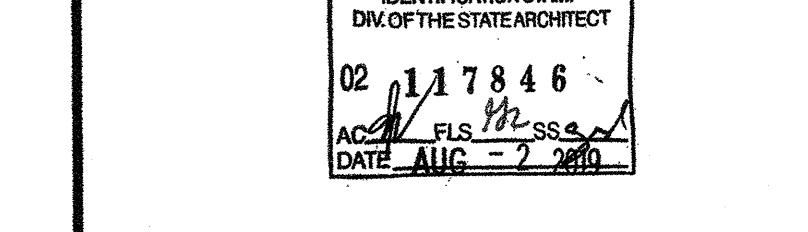

ORIGINAL PC STATE AGENCY APPROVAL

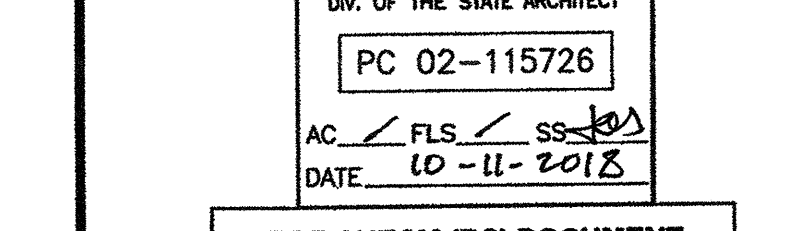

PRE-CHECK (PC) DOCUMENT  
CODE: 2018 PCB  
A SEPARATE PROJECT APPLICATION FOR CONSTRUCTION IS REQUIRED.

REVISIONS

DRAWN BY: SCALE: AS NOTED DATE:

SHEET NUMBER

EN.8-02

STATE OF CALIFORNIA OUTDOOR LIGHTING REGULATIONS CERTIFICATE OF COMPLIANCE  
Project Name: AMS 24-120x40 Ext LTO  
Project Address: 777 S. Highway 101, Suite 203, Manteca, CA 95336  
Phase of Construction: New Construction  
Schedule of Luminaires: 100  
Total Estimated Outdoor Lighting Power: 105

STATE OF CALIFORNIA OUTDOOR LIGHTING REGULATIONS CERTIFICATE OF COMPLIANCE  
Project Name: AMS 24-120x40 Ext LTO  
Schedule of Luminaires: 100  
Total Estimated Outdoor Lighting Power: 105

Table with columns: Location, Luminaire Schedule, Luminaire Type, Luminaire Quantity, Luminaire Power, Total Power. Includes a summary row for 'NEEDED WATTAGE TOTAL' of 105.

STATE OF CALIFORNIA OUTDOOR LIGHTING REGULATIONS CERTIFICATE OF COMPLIANCE  
Project Name: AMS 24-120x40 Ext LTO  
Project Address: 777 S. Highway 101, Suite 203, Manteca, CA 95336  
Phase of Construction: New Construction  
Schedule of Luminaires: 100  
Total Estimated Outdoor Lighting Power: 105

STATE OF CALIFORNIA OUTDOOR LIGHTING CONTROLS REGULATIONS CERTIFICATE OF COMPLIANCE  
Project Name: AMS 24-120x40 Ext LTO  
Schedule of Luminaires: 100  
Total Estimated Outdoor Lighting Power: 105

Table with columns: Location, Luminaire Schedule, Luminaire Type, Luminaire Quantity, Luminaire Power, Total Power. Includes a summary row for 'NEEDED WATTAGE TOTAL' of 105.

STATE OF CALIFORNIA OUTDOOR LIGHTING CONTROLS REGULATIONS CERTIFICATE OF COMPLIANCE  
Project Name: AMS 24-120x40 Ext LTO  
Schedule of Luminaires: 100  
Total Estimated Outdoor Lighting Power: 105

Table with columns: Location, Luminaire Schedule, Luminaire Type, Luminaire Quantity, Luminaire Power, Total Power. Includes a summary row for 'NEEDED WATTAGE TOTAL' of 105.

STATE OF CALIFORNIA OUTDOOR LIGHTING POWER ALLOWANCES REGULATIONS CERTIFICATE OF COMPLIANCE  
Project Name: AMS 24-120x40 Ext LTO  
Schedule of Luminaires: 100  
Total Estimated Outdoor Lighting Power: 105

Table with columns: Location, Luminaire Schedule, Luminaire Type, Luminaire Quantity, Luminaire Power, Total Power. Includes a summary row for 'NEEDED WATTAGE TOTAL' of 105.

STATE OF CALIFORNIA OUTDOOR LIGHTING POWER ALLOWANCES REGULATIONS CERTIFICATE OF COMPLIANCE  
Project Name: AMS 24-120x40 Ext LTO  
Schedule of Luminaires: 100  
Total Estimated Outdoor Lighting Power: 105

STATE OF CALIFORNIA OUTDOOR LIGHTING POWER ALLOWANCES REGULATIONS CERTIFICATE OF COMPLIANCE  
Project Name: AMS 24-120x40 Ext LTO  
Schedule of Luminaires: 100  
Total Estimated Outdoor Lighting Power: 105