

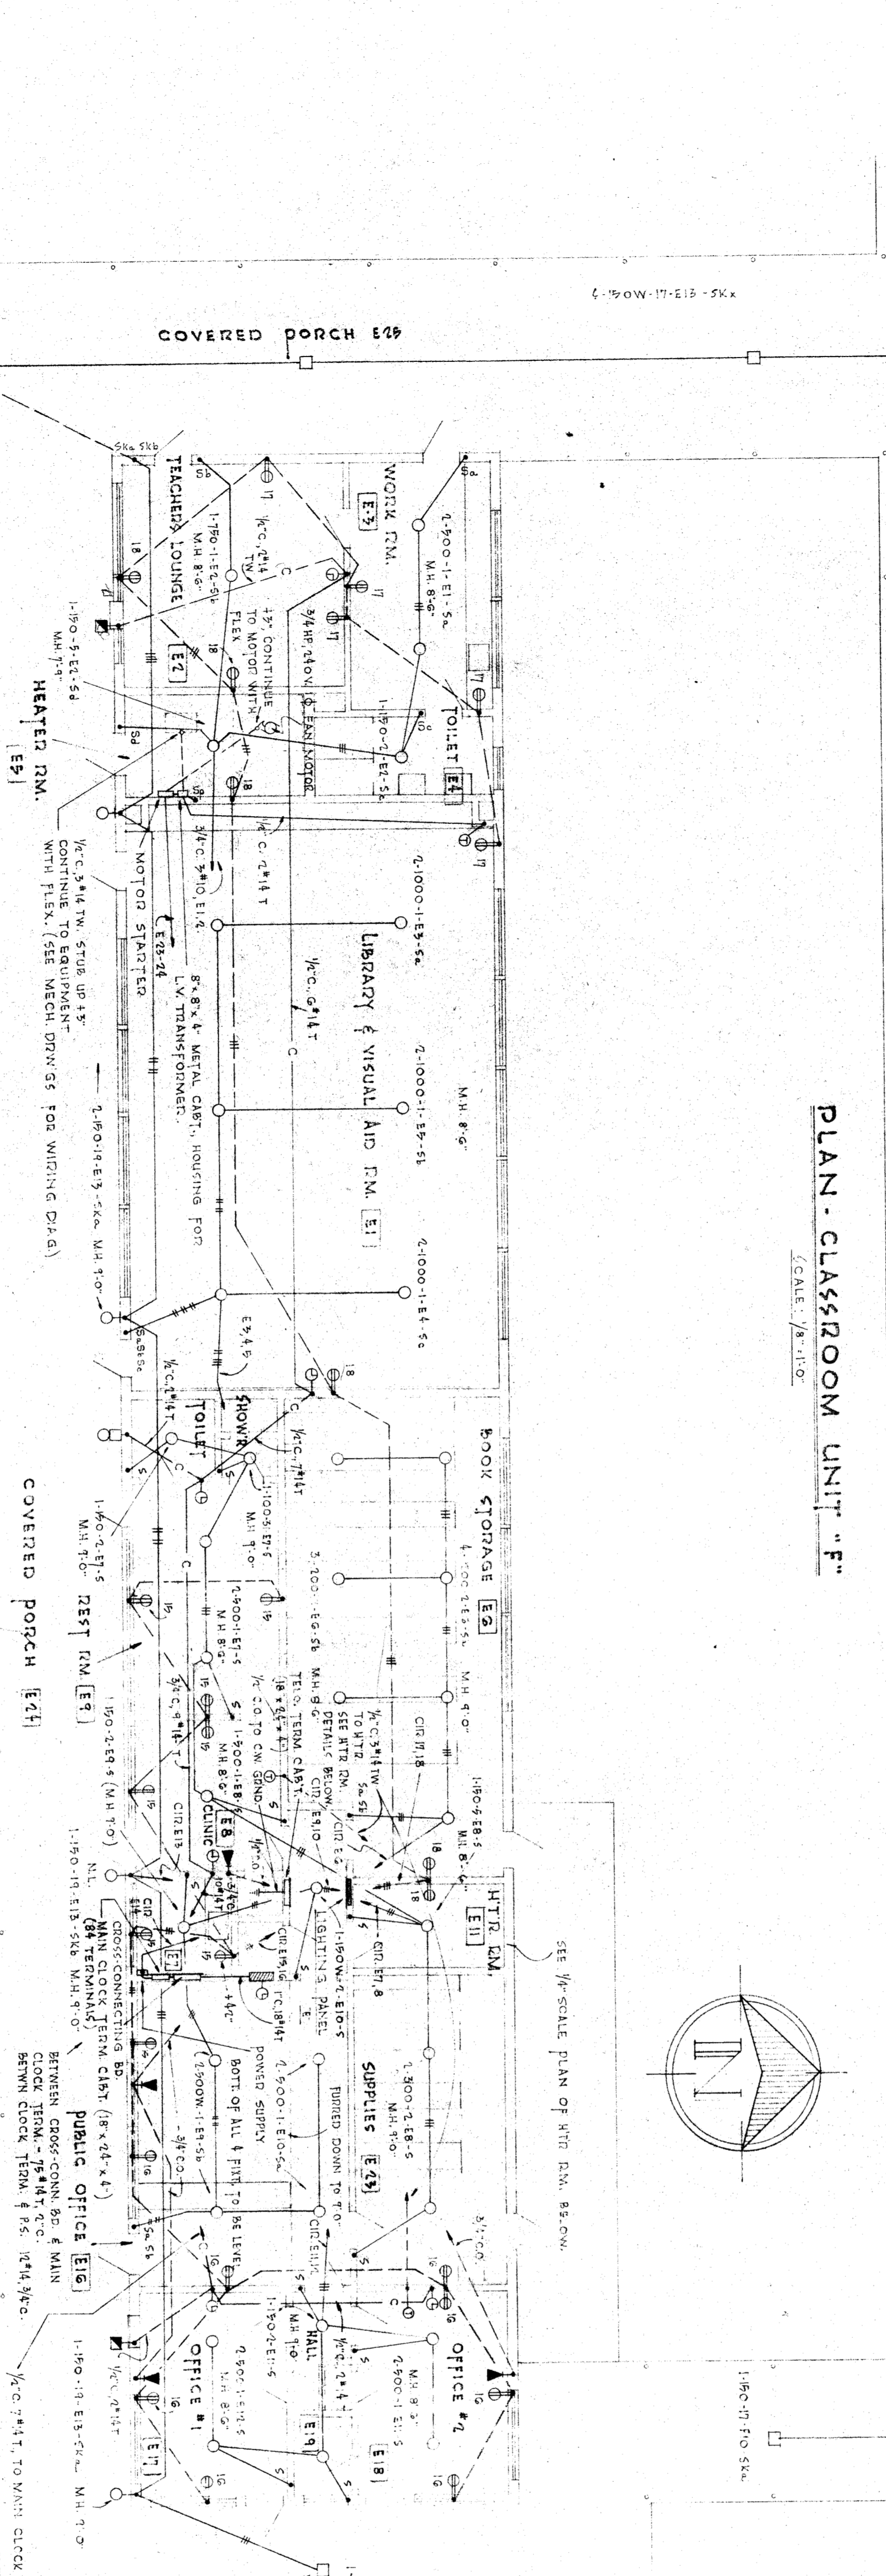


CIR. N°	N° OUTLETS	TOTAL WATTS	CIR. BREAKER
F-1	2	2000	20A 1P
2	2	2000	20A 1P
3	2	2000	20A 1P
4	2	2000	20A 1P
5	2	2000	20A 1P
6	2	2000	20A 1P
7	2	2000	20A 1P
8	2	2000	20A 1P
9	2	2000	20A 1P
10	2	2000	20A 1P
11	2	2000	20A 1P
12	2	2000	20A 1P
13	2	2000	20A 1P
14	2	2000	20A 1P
15	2	2000	20A 1P
16	2	2000	20A 1P
17	2	2000	20A 1P
18	2	2000	20A 1P
19	2	2000	20A 1P
20	2	2000	20A 1P
21	2	2000	20A 1P
22	2	2000	20A 1P
23	2	2000	20A 1P
24	2	2000	20A 1P
TOTAL	48	48000	48A 1P

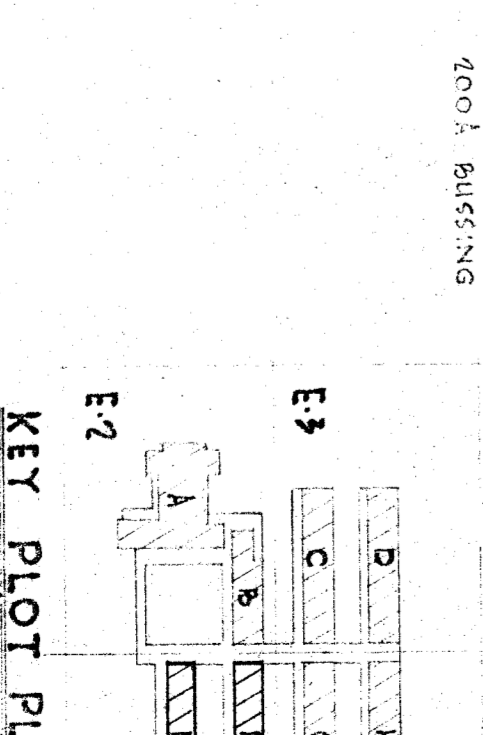

CIR. N°	N° OUTLETS	TOTAL WATTS	CIR. BREAKER
E-1	2	1000	20A 1P
2	2	1000	20A 1P
3	2	1000	20A 1P
4	2	1000	20A 1P
5	2	1000	20A 1P
6	2	1000	20A 1P
7	2	1000	20A 1P
8	2	1000	20A 1P
9	2	1000	20A 1P
10	2	1000	20A 1P
11	2	1000	20A 1P
12	2	1000	20A 1P
13	2	1000	20A 1P
14	2	1000	20A 1P
15	2	1000	20A 1P
16	2	1000	20A 1P
17	2	1000	20A 1P
18	2	1000	20A 1P
19	2	1000	20A 1P
20	2	1000	20A 1P
21	2	1000	20A 1P
22	2	1000	20A 1P
23	2	1000	20A 1P
24	2	1000	20A 1P
TOTAL	48	48000	48A 1P

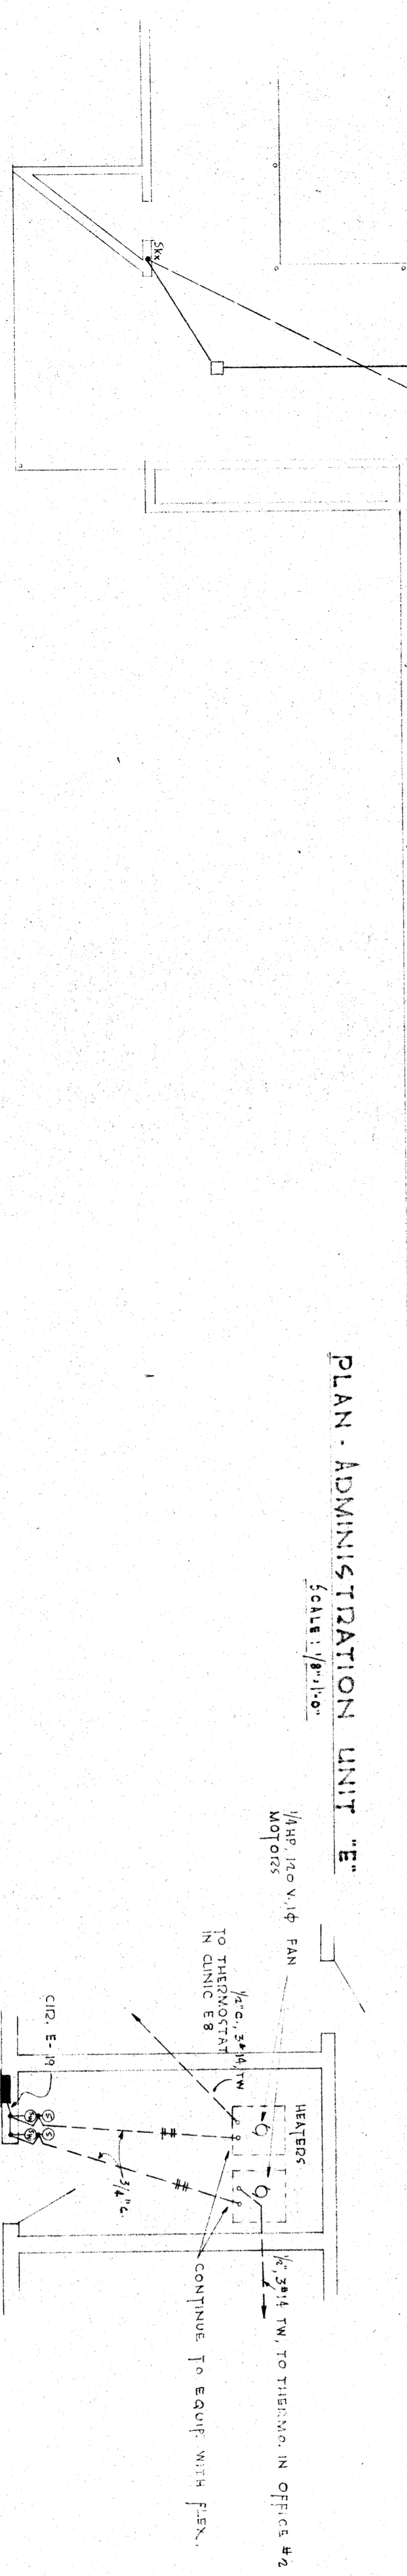

FOSTER K. SAMPSON
 REGISTERED ELECTRICAL ENGINEER
 PROFESSIONAL NUMBER 314
 LOS ANGELES, CALIFORNIA

STATE OF CALIFORNIA
 DEPARTMENT OF PUBLIC WORKS
 DIVISION OF ARCHITECTURE

BAKERFIELD CITY SCHOOL DISTRICT
 BOARD OF EDUCATION
 APPROVED: _____
 SECRETARY: _____
 DATE: 7-7-49

DATE: 7-7-49
 DRAWN: W. C. H. I. T. S.
 CHECKED: A. L. A.
 PROJECT: BAKERFIELD CITY SCHOOL DISTRICT
 311 KIRKMAN BUILDING
 BAKERSFIELD, CALIFORNIA

JOB: 193
 SHEET: E-4

ELECTRICAL FLOOR PLAN - UNITS 'E' & 'F'
POTOMAC & SOUTH KING ST. SCHOOL
 FOR THE
BAKERFIELD CITY SCHOOL DISTRICT
 KERN COUNTY
 CALIFORNIA