



PLAN CLASSROOM UNIT "H"  
SCALE: 1/8" = 1'-0"

PANEL NO.	NO. OUTLETS	TOTAL WATTS	CIR. BREAKER
H-1	2	1000	15A 1-P
2	2	1000	15A 1-P
3	2	1000	15A 1-P
4	2	1000	15A 1-P
5	2	1000	15A 1-P
6	2	1000	15A 1-P
7	2	1000	15A 1-P
8	2	1000	15A 1-P
9	2	1000	15A 1-P
10	2	1000	15A 1-P
11	2	1000	15A 1-P
12	2	1000	15A 1-P
13	2	1000	15A 1-P
14	2	1000	15A 1-P
15	2	1000	15A 1-P
16	2	1000	15A 1-P
TOTAL WATTS		16000	15A 1-P

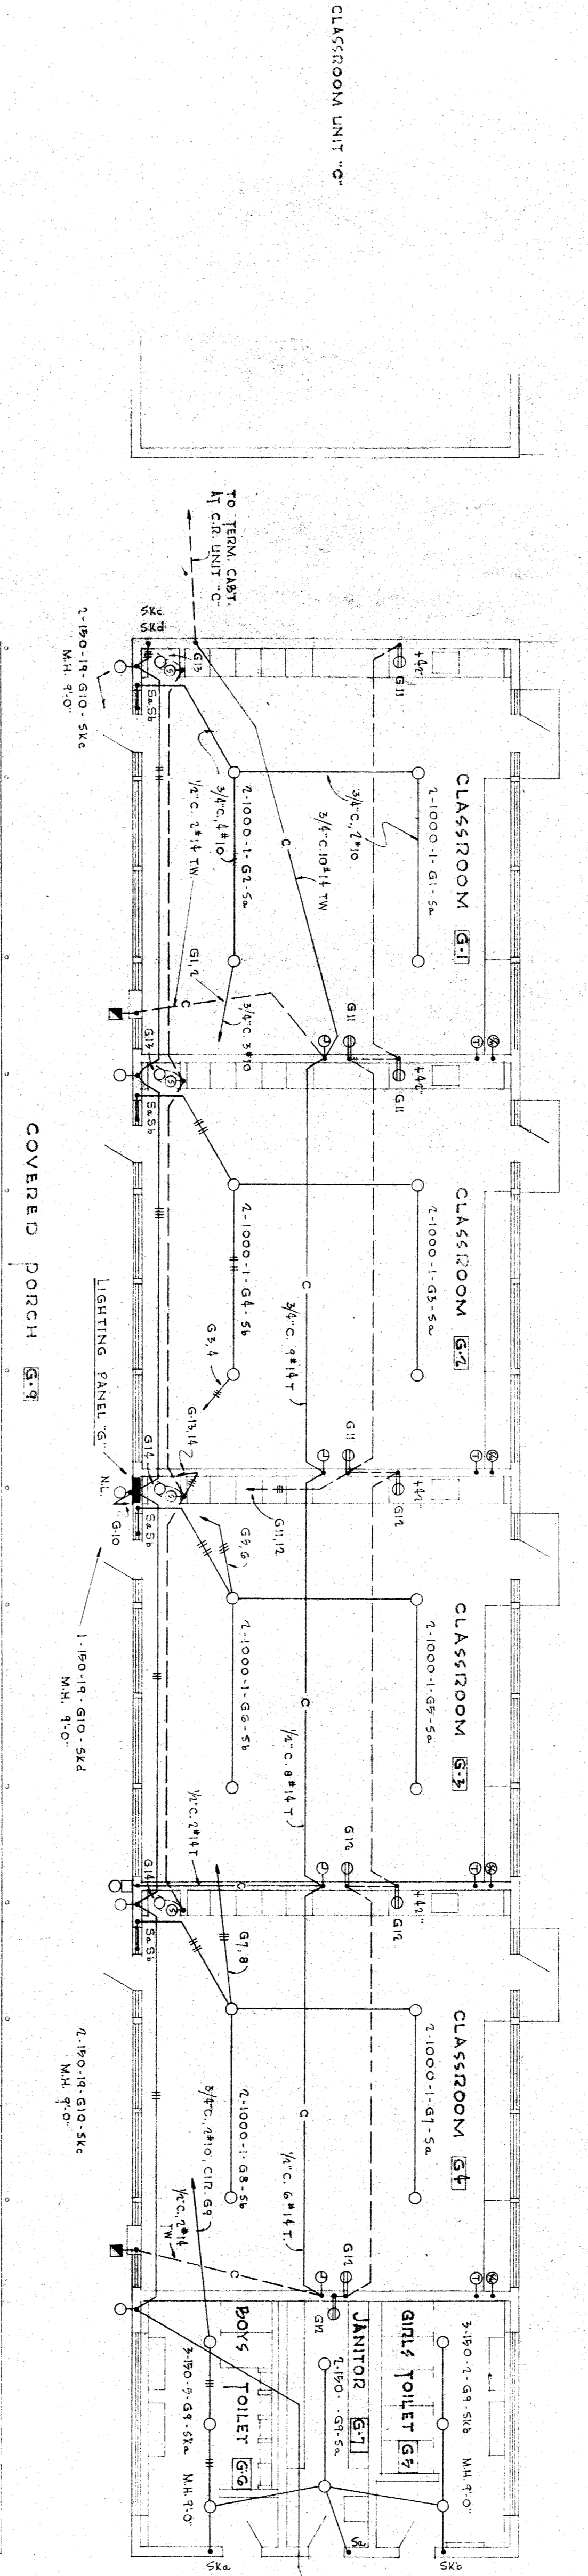

PLAN CLASSROOM UNIT "G"  
SCALE: 1/8" = 1'-0"

PANEL NO.	NO. OUTLETS	TOTAL WATTS	CIR. BREAKER
G-1	2	1000	15A 1-P
2	2	1000	15A 1-P
3	2	1000	15A 1-P
4	2	1000	15A 1-P
5	2	1000	15A 1-P
6	2	1000	15A 1-P
7	2	1000	15A 1-P
8	2	1000	15A 1-P
9	2	1000	15A 1-P
10	2	1000	15A 1-P
11	2	1000	15A 1-P
12	2	1000	15A 1-P
13	2	1000	15A 1-P
14	2	1000	15A 1-P
15	2	1000	15A 1-P
16	2	1000	15A 1-P
TOTAL WATTS		16000	15A 1-P

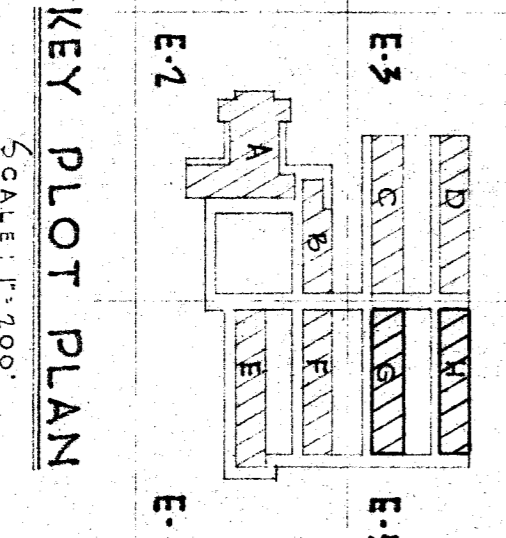

KEY PLOT PLAN  
SCALE: 1/8" = 1'-0"

FOSTER K. SAMPSON  
REGISTERED ELECTRICAL ENGINEER  
CERTIFICATE NUMBER 944  
LOS ANGELES CALIFORNIA

STATE OF CALIFORNIA  
DEPARTMENT OF PUBLIC WORKS  
DIVISION OF ARCHITECTURE

BAKERFIELD CITY SCHOOL DISTRICT  
BOARD OF EDUCATION  
APPROVED: \_\_\_\_\_  
DATE: 7-7-49

ELECTRICAL FLOOR PLAN UNITS "G" & "H"  
POTOMAC & SOUTH KING ST. SCHOOL  
FOR THE BAKERFIELD CITY SCHOOL DISTRICT  
BAKERFIELD KERN COUNTY CALIFORNIA  
DRAWN BY: \_\_\_\_\_  
DATE: 7-7-49  
CHECKED BY: \_\_\_\_\_  
DATE: \_\_\_\_\_  
JOB NO. 153  
SHEET 4 OF 4  
PARSONS  
A. L. A.  
ENGINEERS ARCHITECTS