
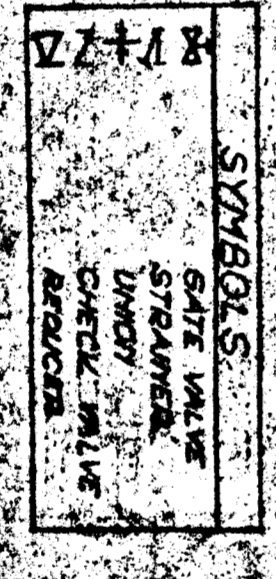
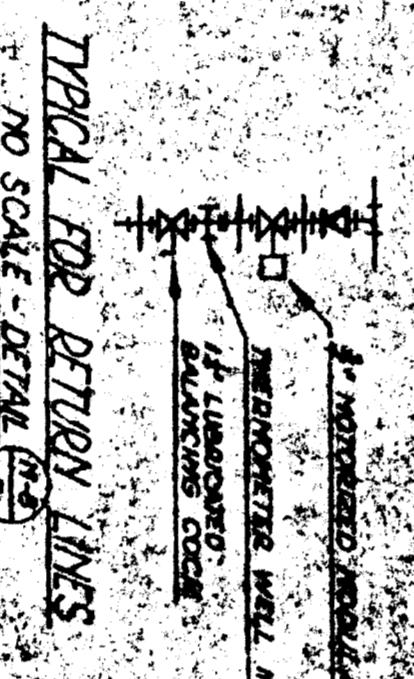


NOTE: ALL PIPING ABOVE THE FLOOR SHALL HAVE SCREWED JOINTS. ALL PIPING BELOW THE FLOOR SHALL BE WELDED.

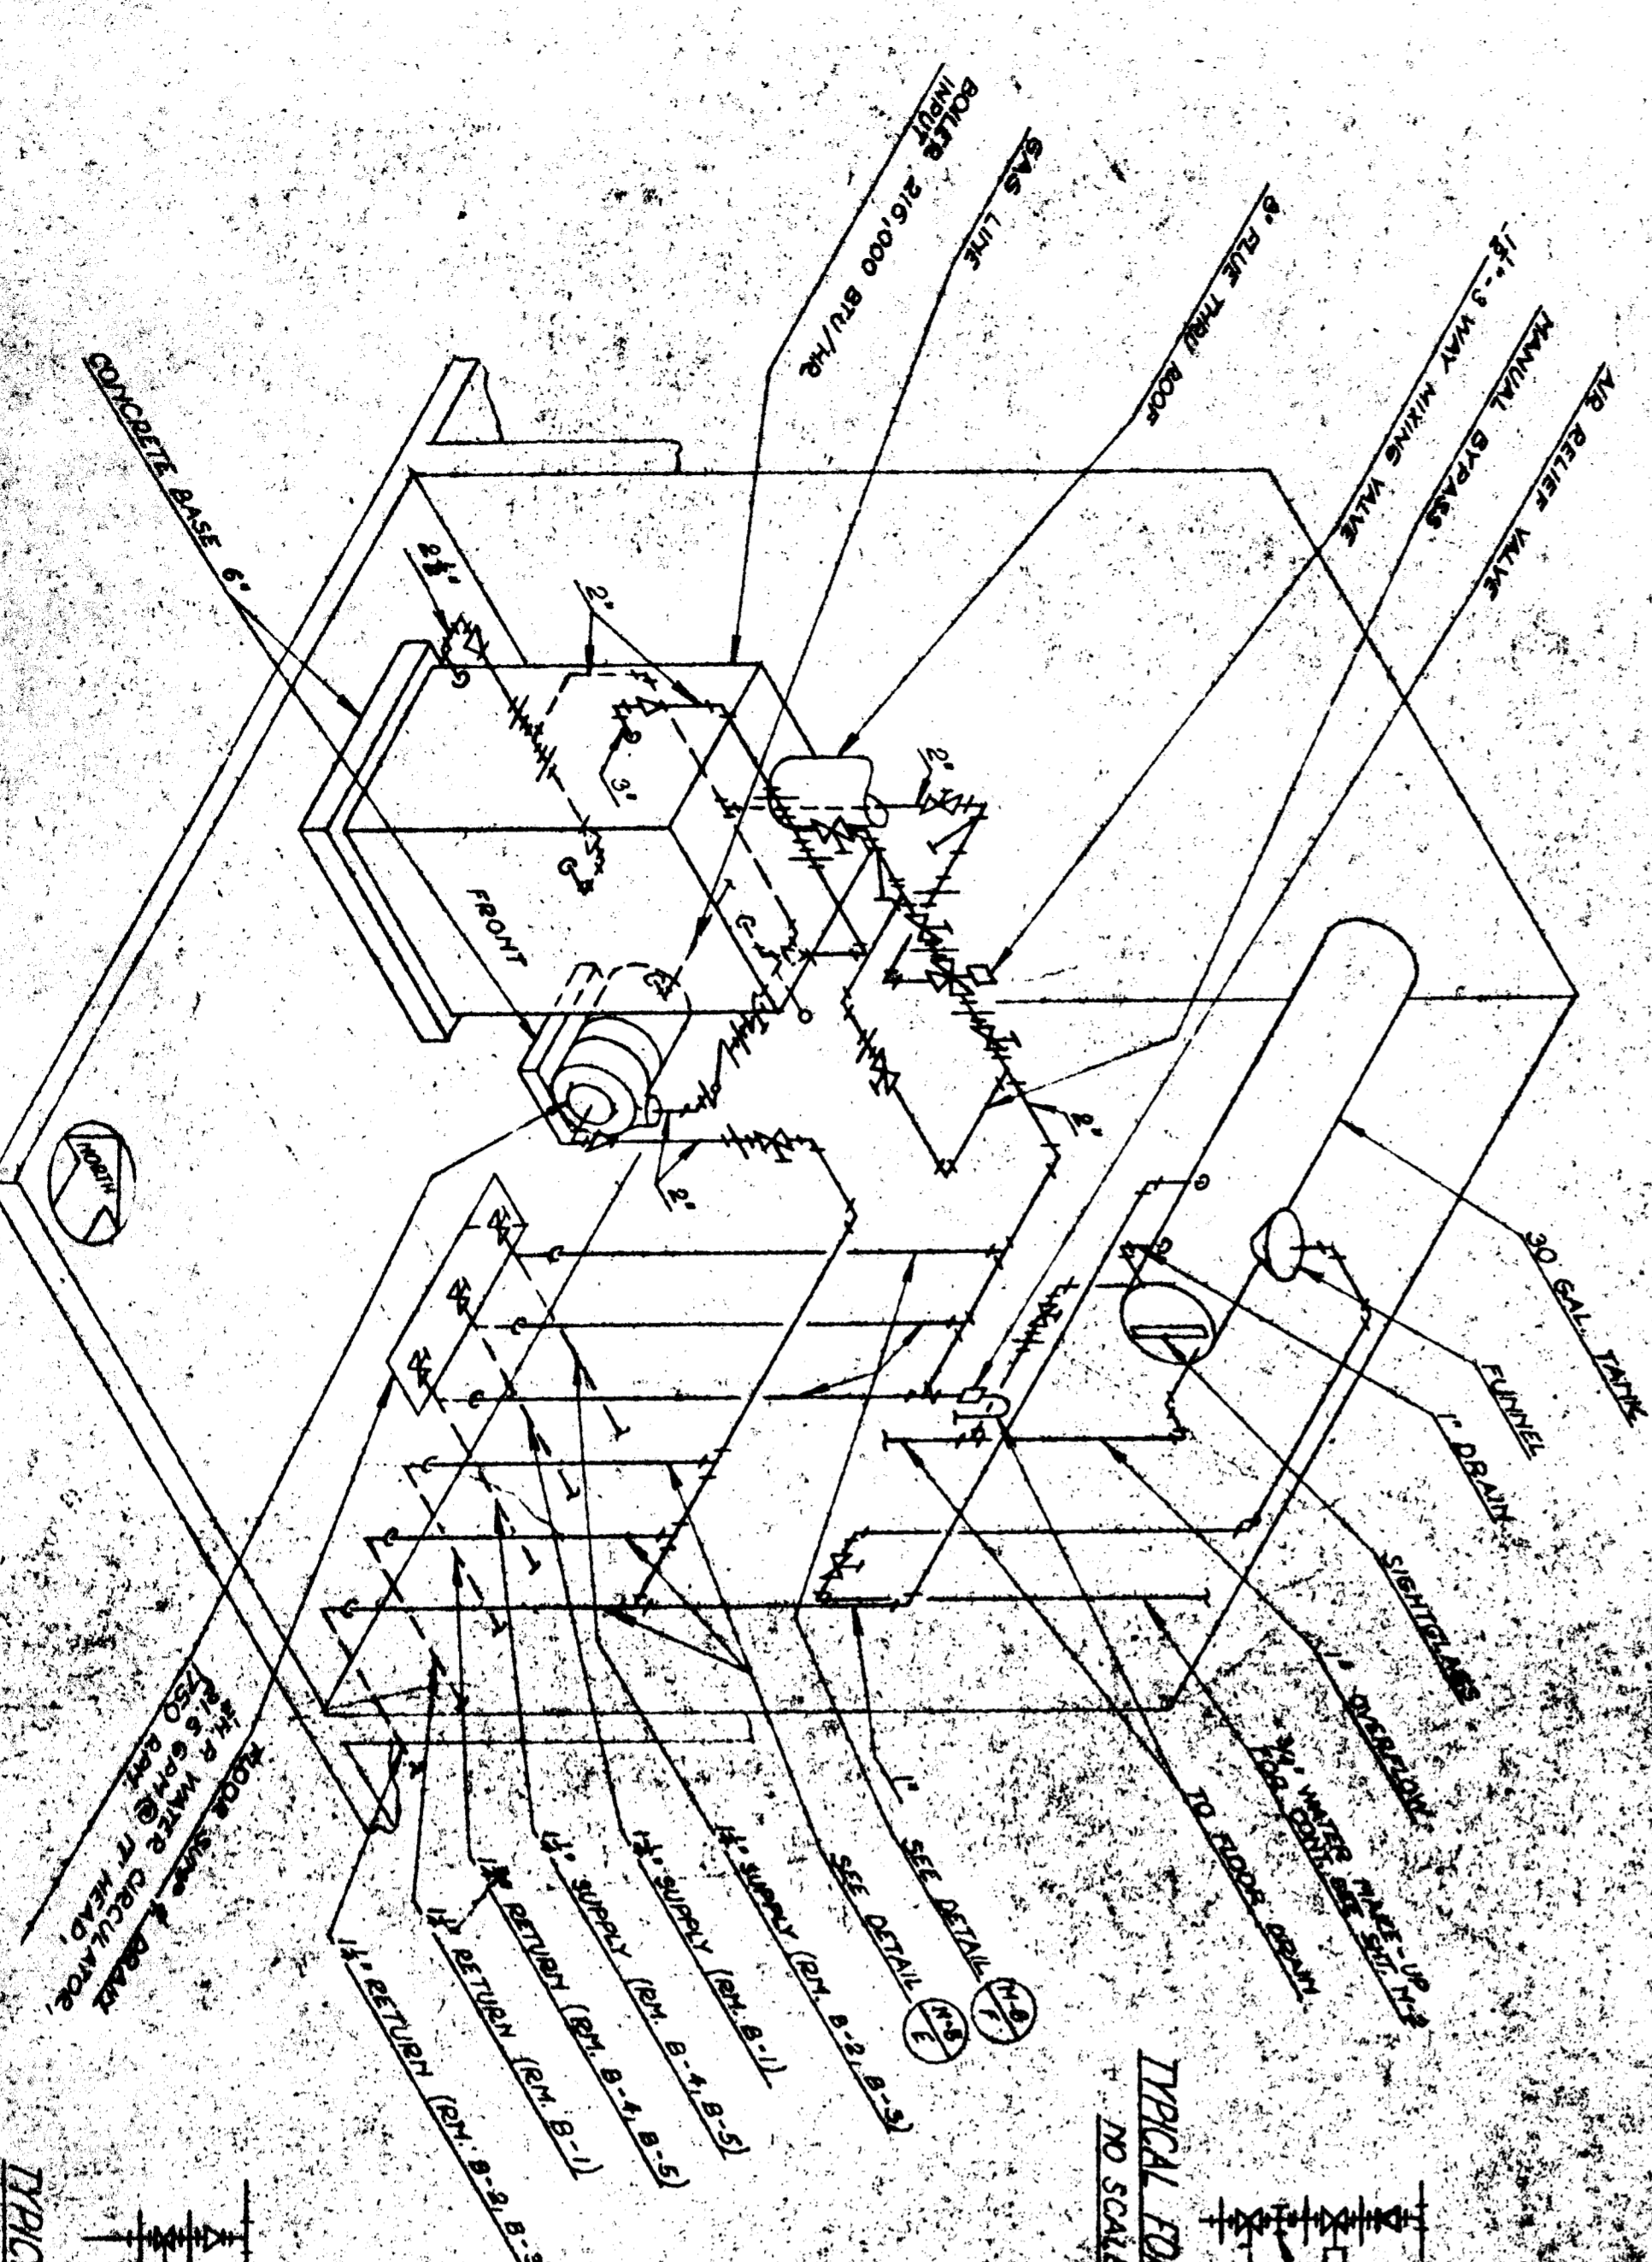

HEATER ROOM B-12 - ISOMETRIC
SCALE 1/4" = 1'-0" - DETAIL (1/4)

STATE OF CALIFORNIA
DEPARTMENT OF EDUCATION
BARKERSFIELD CITY SCHOOL DISTRICT
BARKERSFIELD CITY SCHOOL
HEATING LAYOUT-KINDERGARTEN UNIT B
FOTONAC AND SOUTH KING ST. SCHOOL
BARKERSFIELD, CALIFORNIA COUNTY
111 HORTON BUILDING
BARKERSFIELD, CALIFORNIA

DATE: 1-2-49
DESIGNED BY: WRIGHT METCALF & PARSONS
CHECKED BY: A. R. C. H. I. T. E. C.
DRAWN BY: B. H. H.

PROJECT NO. 133
SHEET 1 / 5