

Donald W. Reno, AIA
Mark E. Russell, AIA
C-5283
C-13726
4810 Shiloh Street, Suite 204, Bakersfield, California 93309 (805) 327-7075

CONSULTANTS

FRANK MITCHELL ARCHITECTS EST. 1973
JOHN FRANK MITCHELL, INC.
CONSULTING MECHANICAL ENGINEERS
PHONE: 833-1399
444 WEST 28TH STREET 1ST FLOOR, CAUCONIA 91378
SUN 833-1172


PROJECT

**BAKERSFIELD
CITY
SCHOOL
DISTRICT**

**FRANKLIN
ELEMENTARY
SCHOOL
MODERNIZATION**

THE ABOVE DRAWINGS AND SPECIFICATIONS AND DATA, RESPONSES AND NOTES HERETO, TOGETHER WITH ANY AND ALL SUPPLEMENTAL NOTES AND SPECIFICATIONS AND SCHEDULES AND CHANGES TO THE SAME, SHALL BE USED BY THE CONTRACTOR AND SUBCONTRACTOR TO FULFILL THE OBLIGATION OF THE CONTRACT. THE CONTRACTOR SHALL BE RESPONSIBLE FOR OBTAINING ALL NECESSARY PERMITS AND APPROVALS FROM THE LOCAL AUTHORITIES. THE CONTRACTOR SHALL BE RESPONSIBLE FOR OBTAINING ALL NECESSARY PERMITS AND APPROVALS FROM THE LOCAL AUTHORITIES. THE CONTRACTOR SHALL BE RESPONSIBLE FOR OBTAINING ALL NECESSARY PERMITS AND APPROVALS FROM THE LOCAL AUTHORITIES.

KEY PLAN

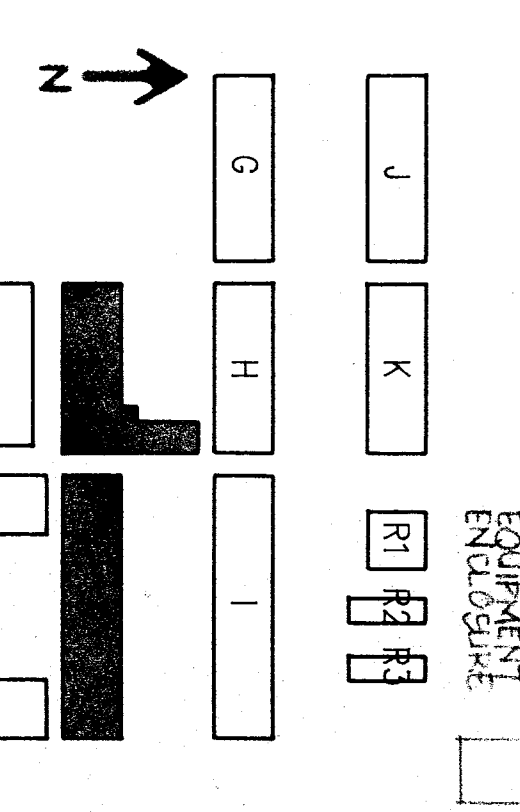


**BAKERSFIELD CITY SCHOOL DISTRICT
BOARD OF EDUCATION**

DATE	APPROVED


**SHEET TITLE
AIR CONDITIONING PLAN
BUILDING D, E, F**

APPROVED ARCHITECT: *John Mitchell*
CHECKED JFM
DRAWN BY MJB
PROJECT NO. 86-216-P1
SHEET NUMBER
M - 6
8619/MIC/08
OF 7 SHEETS

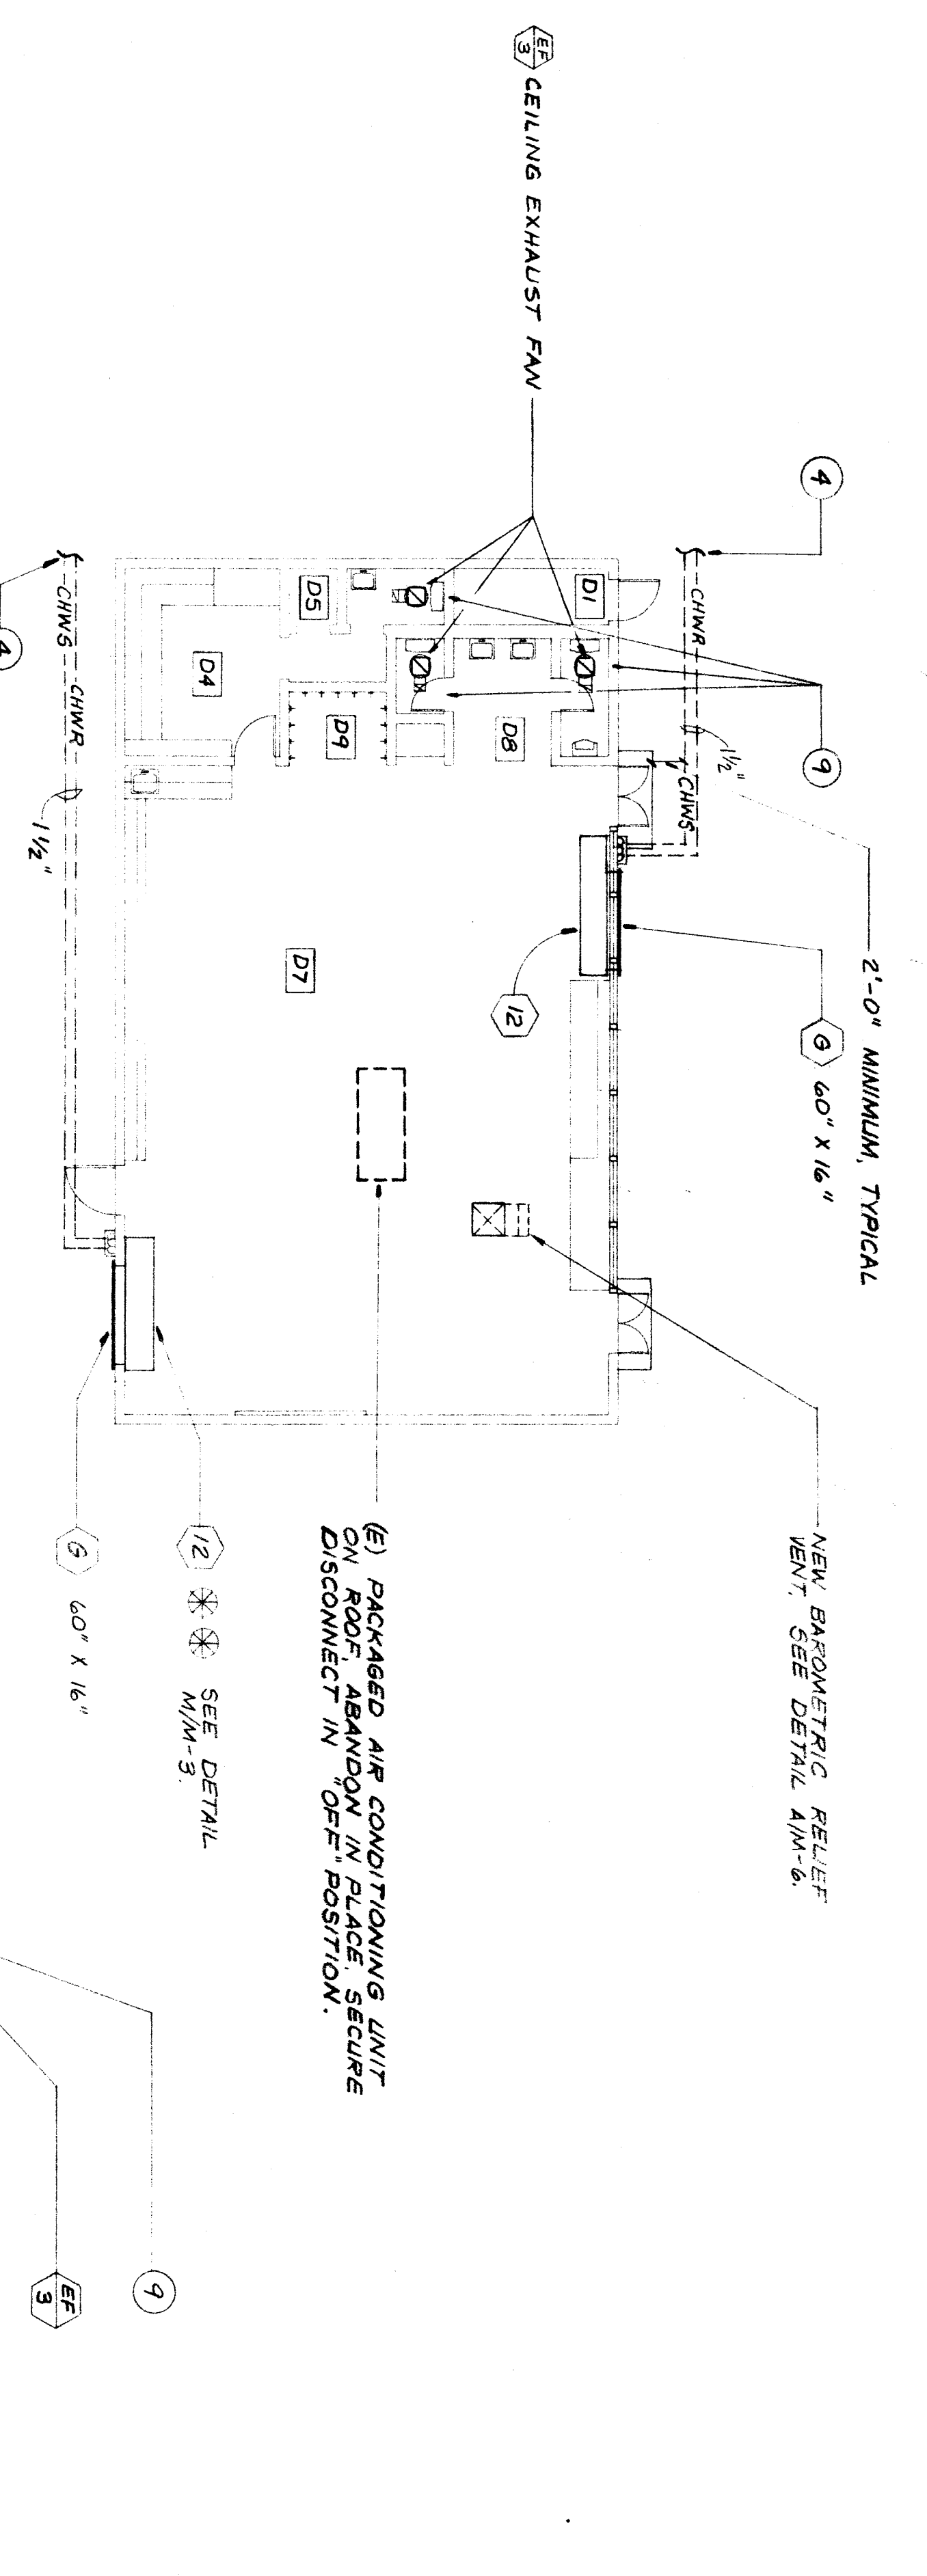


BUILDING D

DETAIL

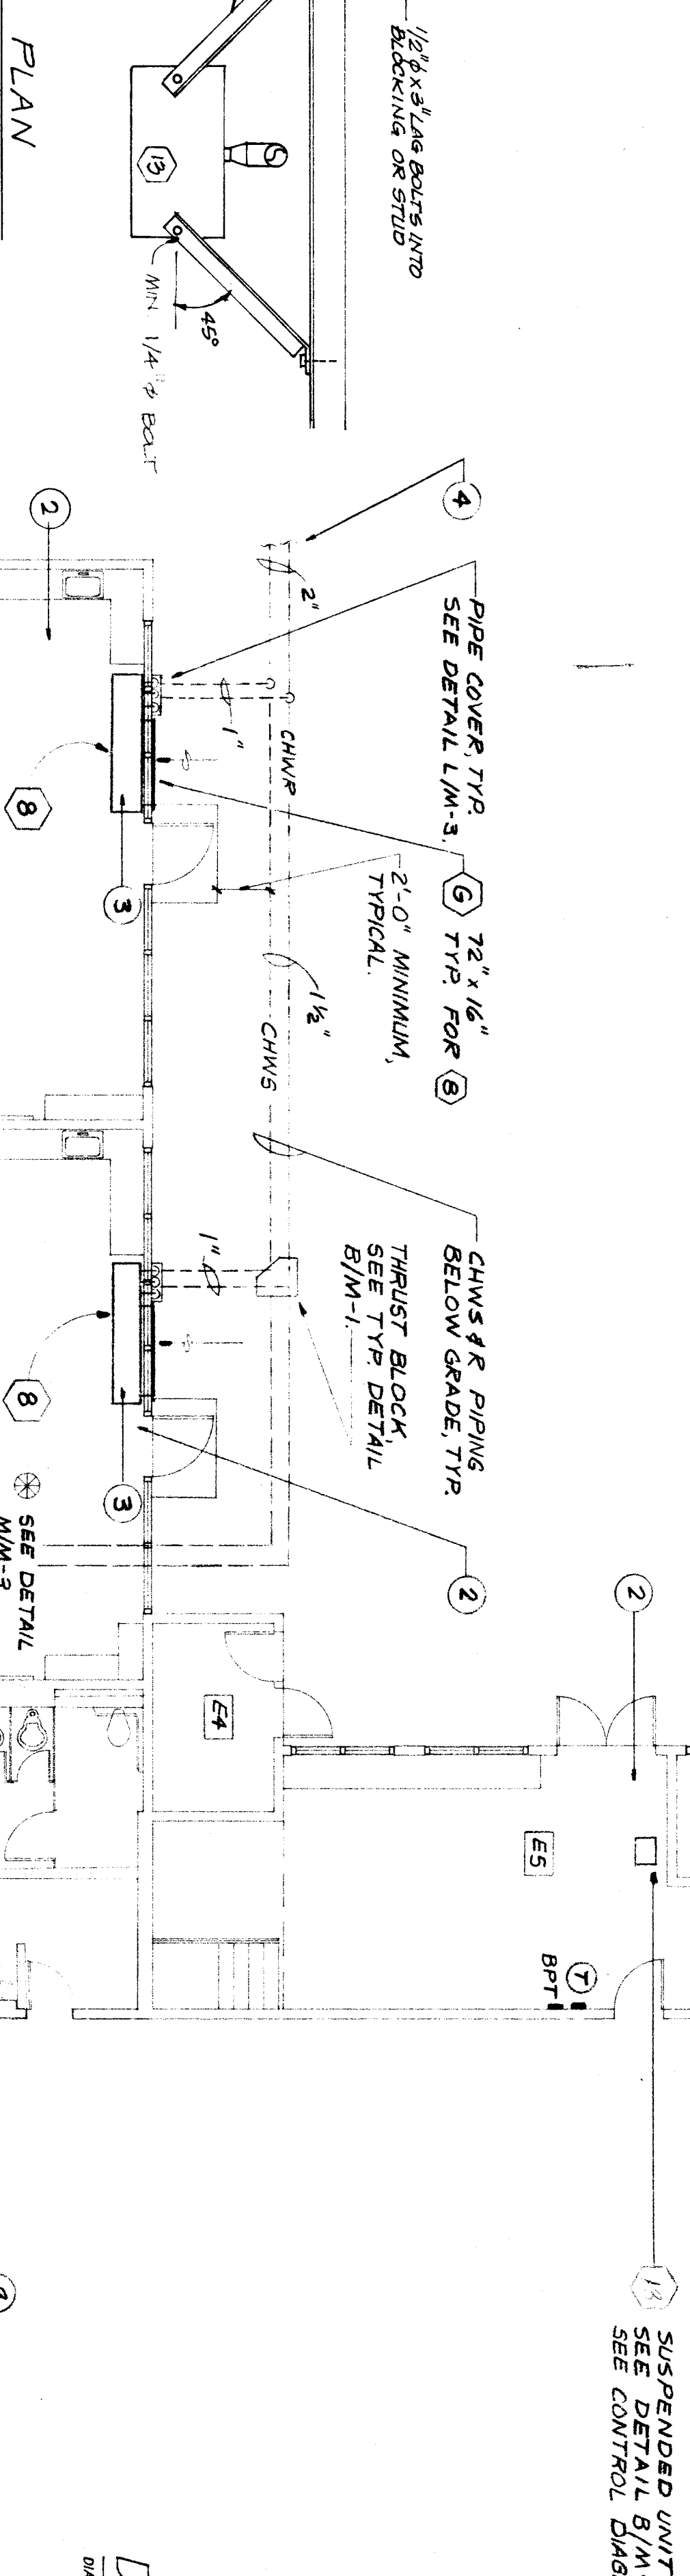


BUILDING E

DETAIL

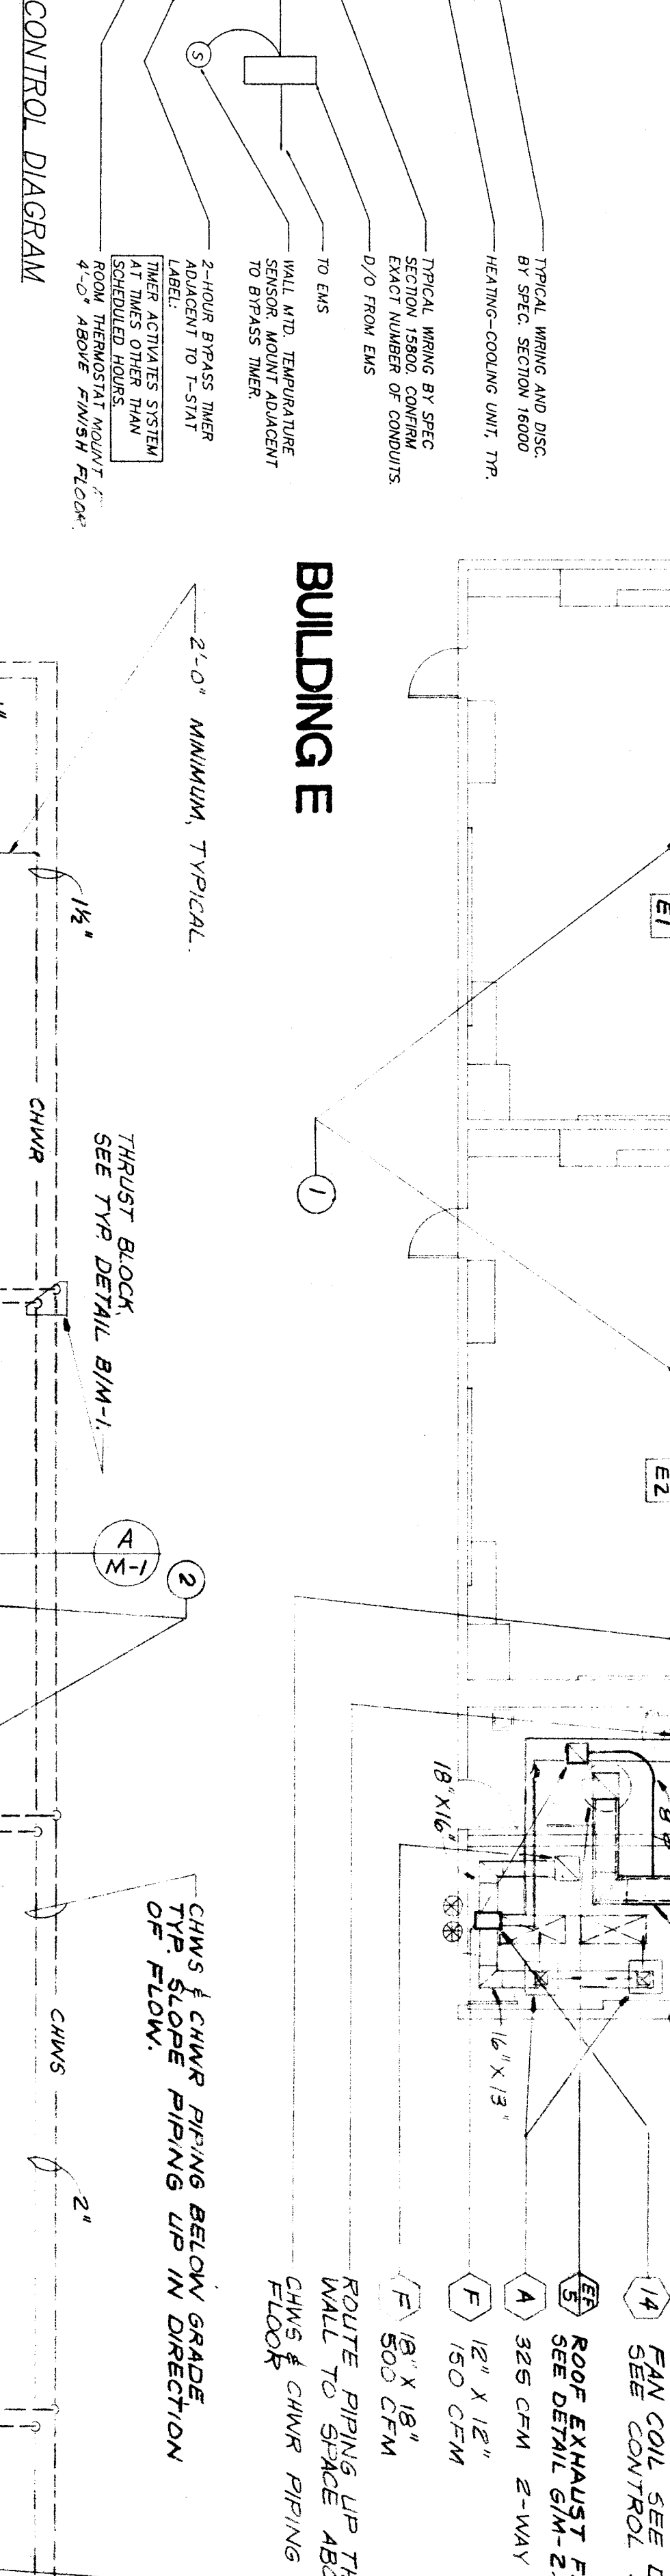


BUILDING F

DETAIL

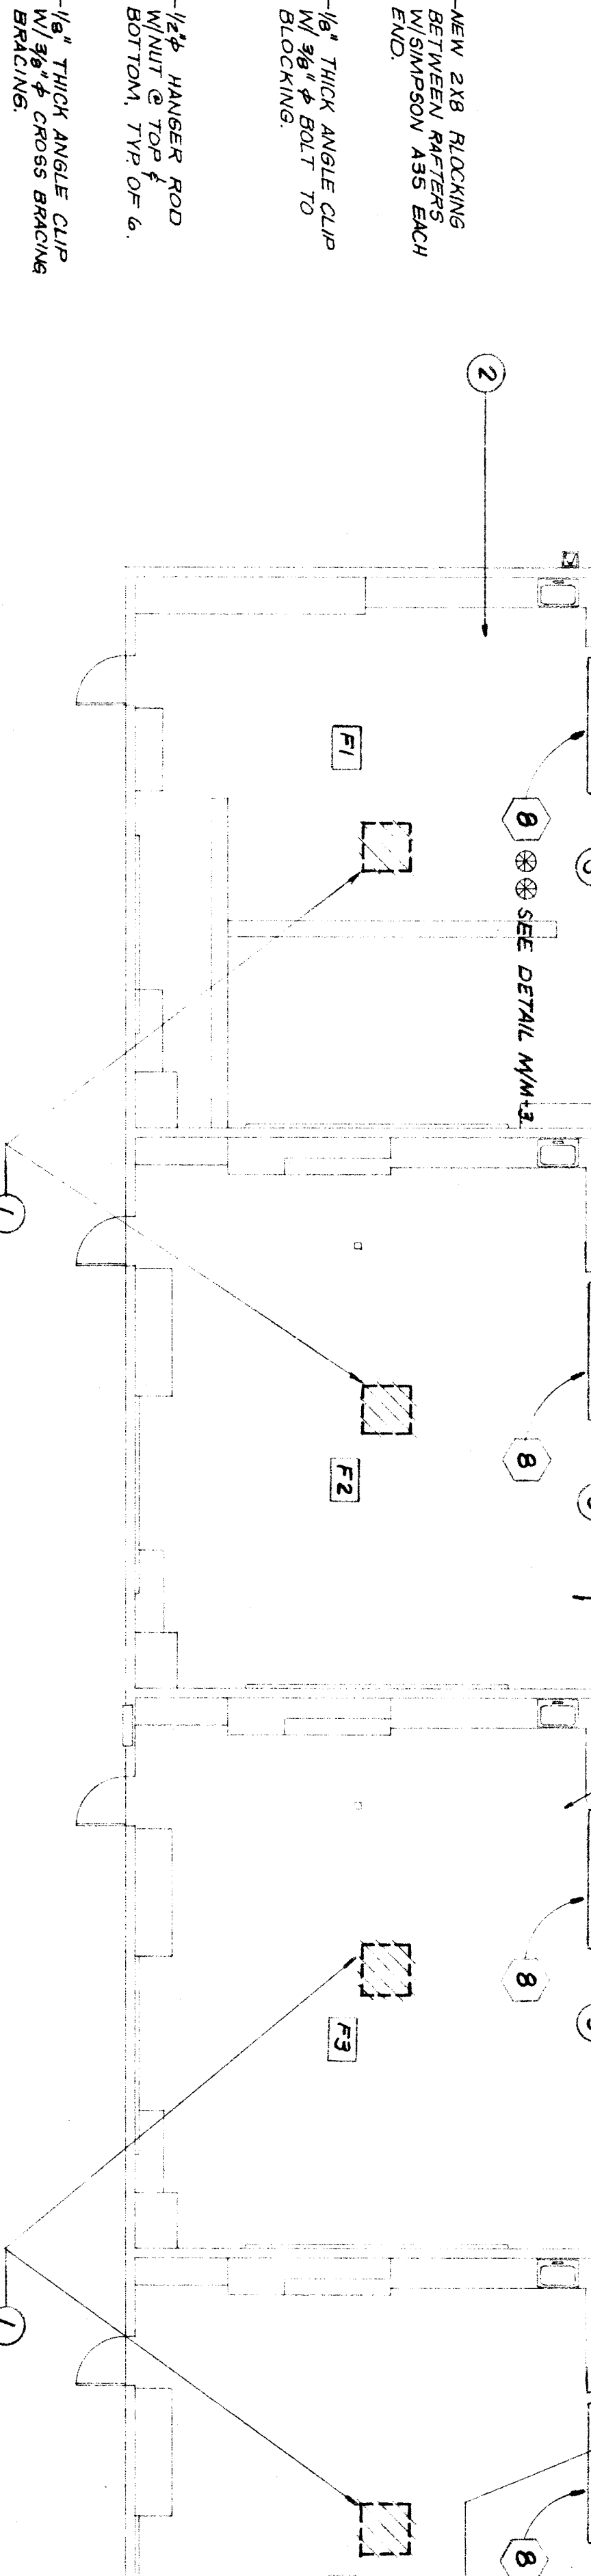


BUILDING G

DETAIL

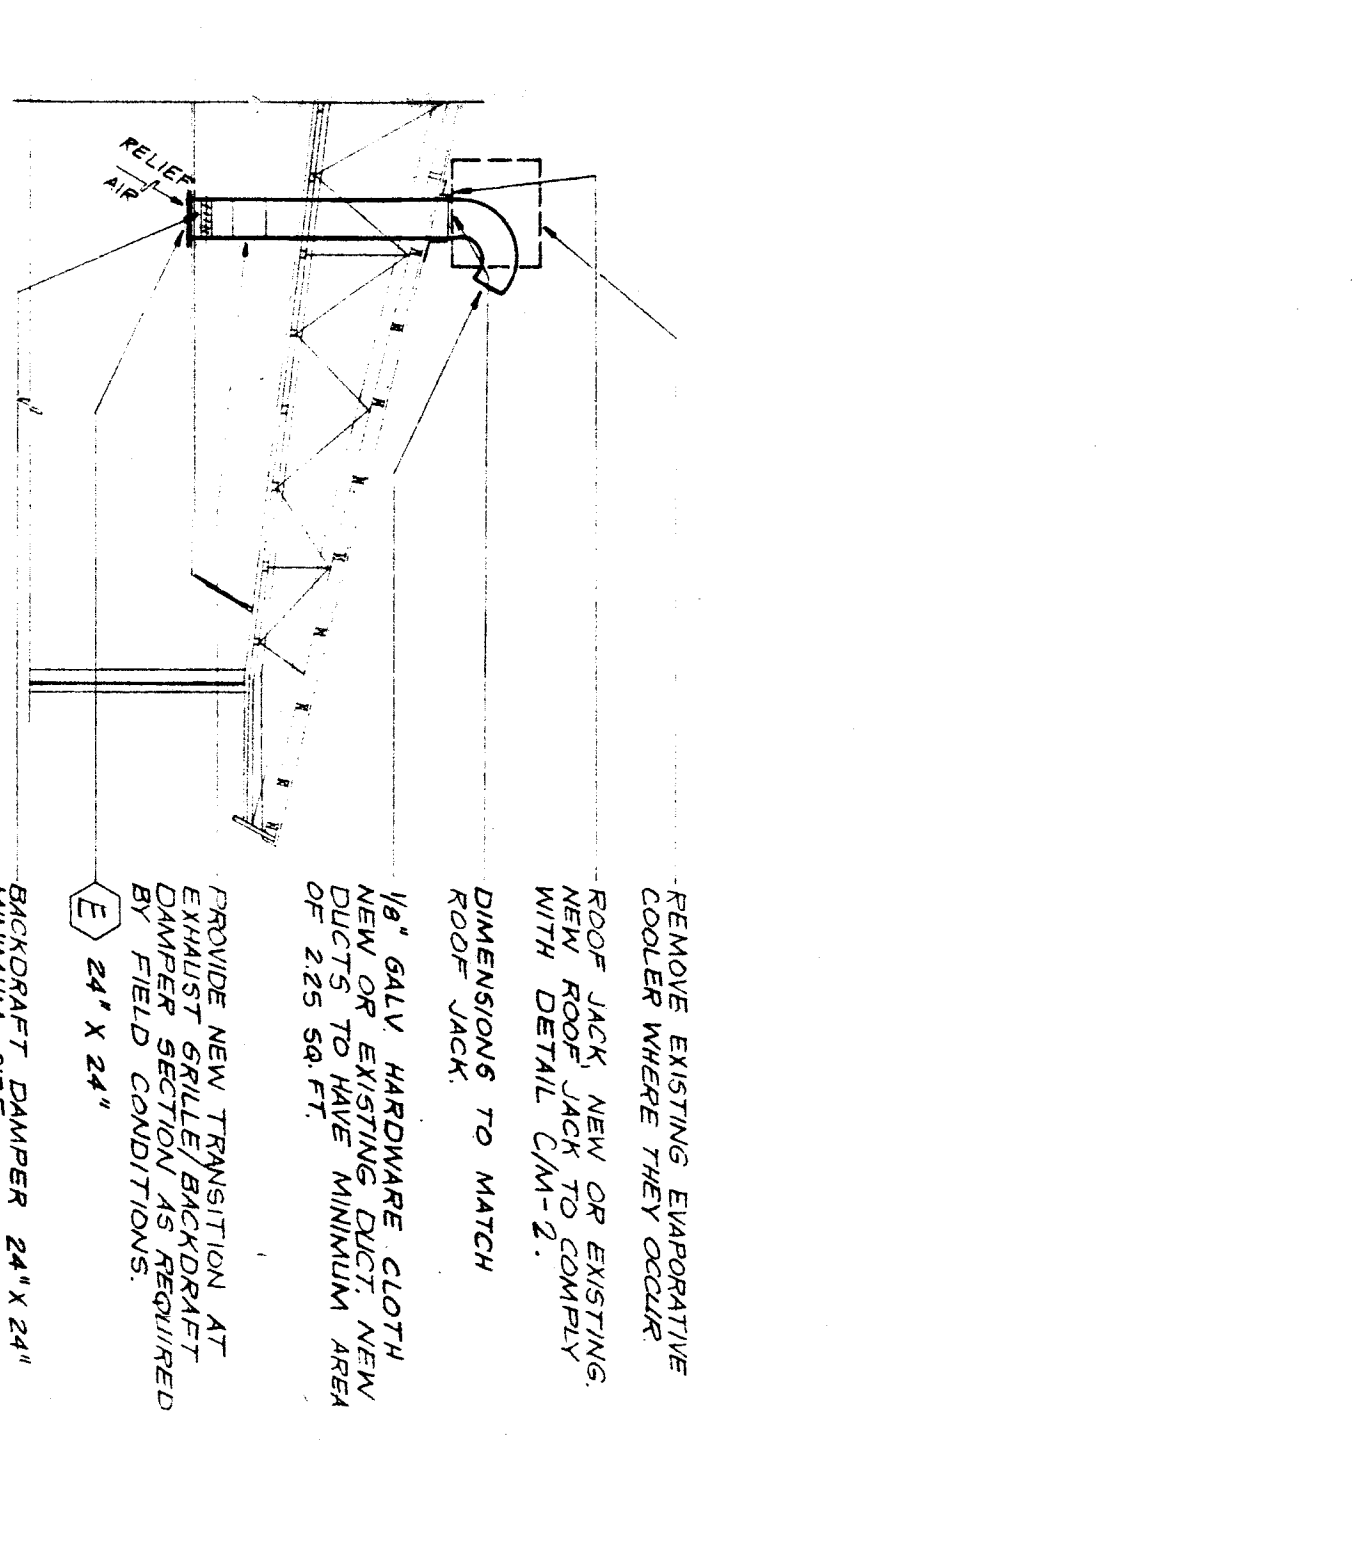


**BAROMETRIC RELIEF VENT
DETAIL**


NO SCALE
NOTE: THIS DETAIL APPLICABLE TO ALL CLASSROOMS.

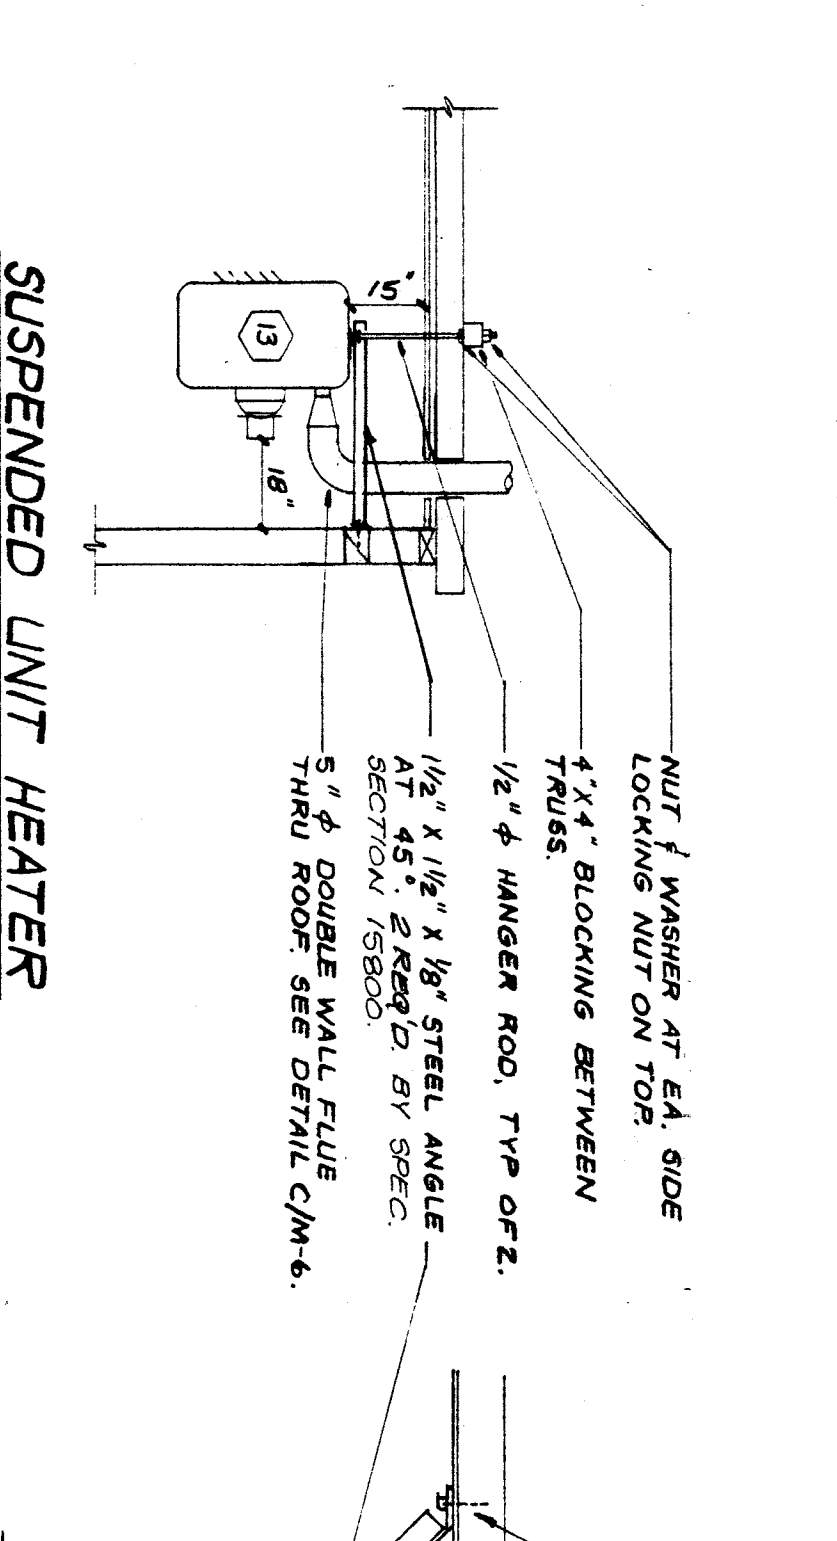

**SUSPENDED UNIT HEATER
DETAIL**

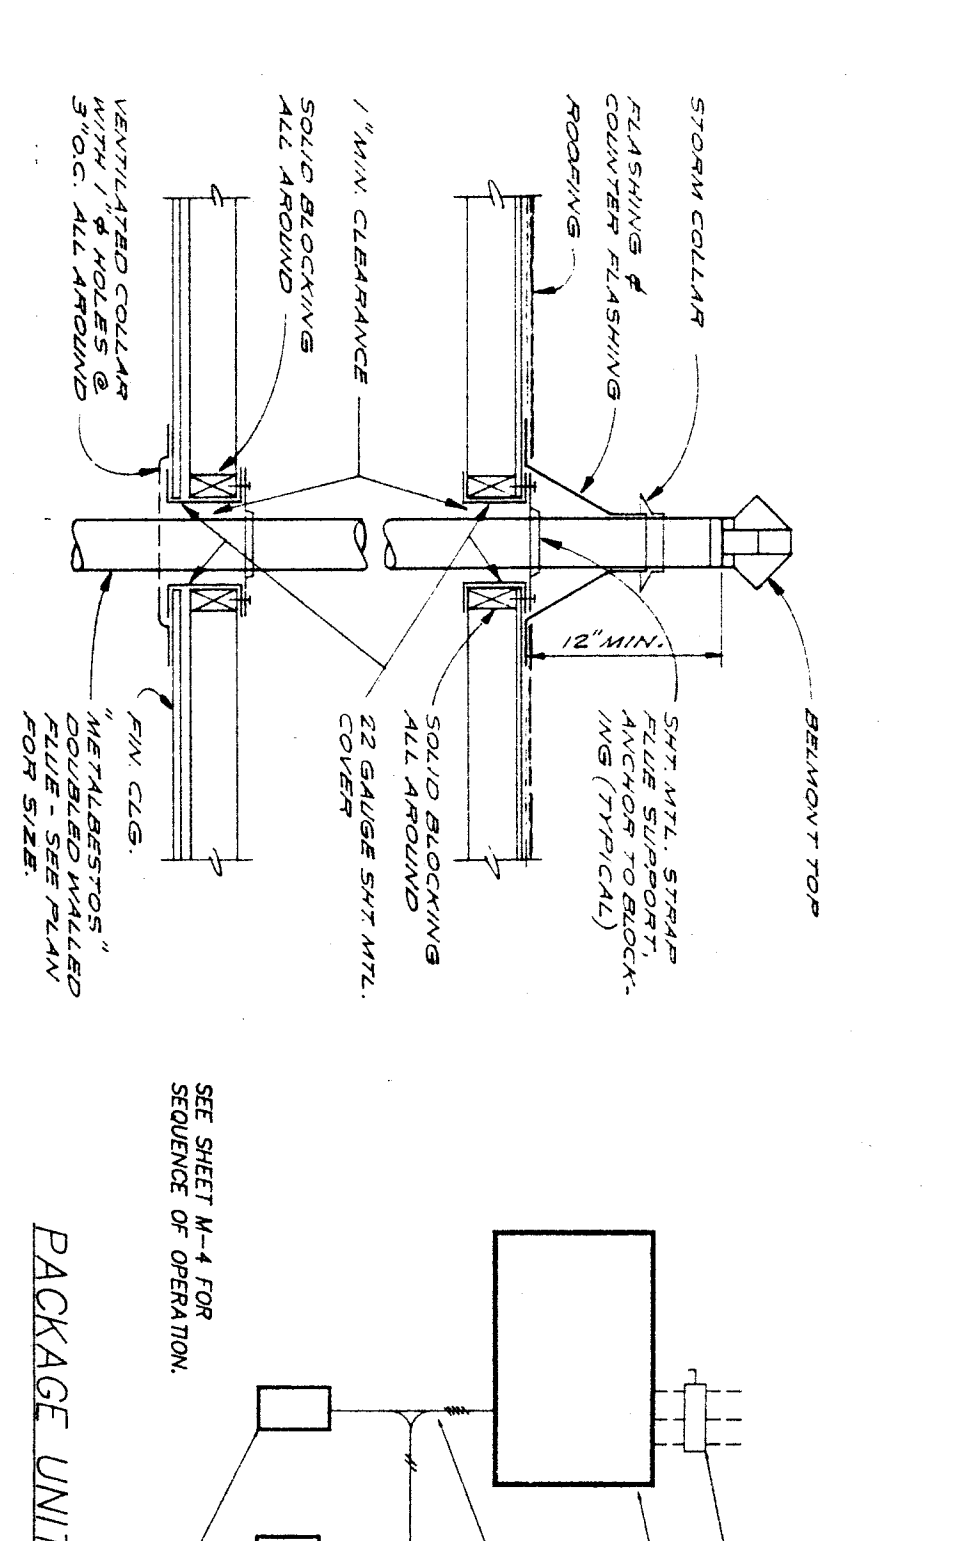


**PACKAGE UNIT CONTROL DIAGRAM
DETAIL**

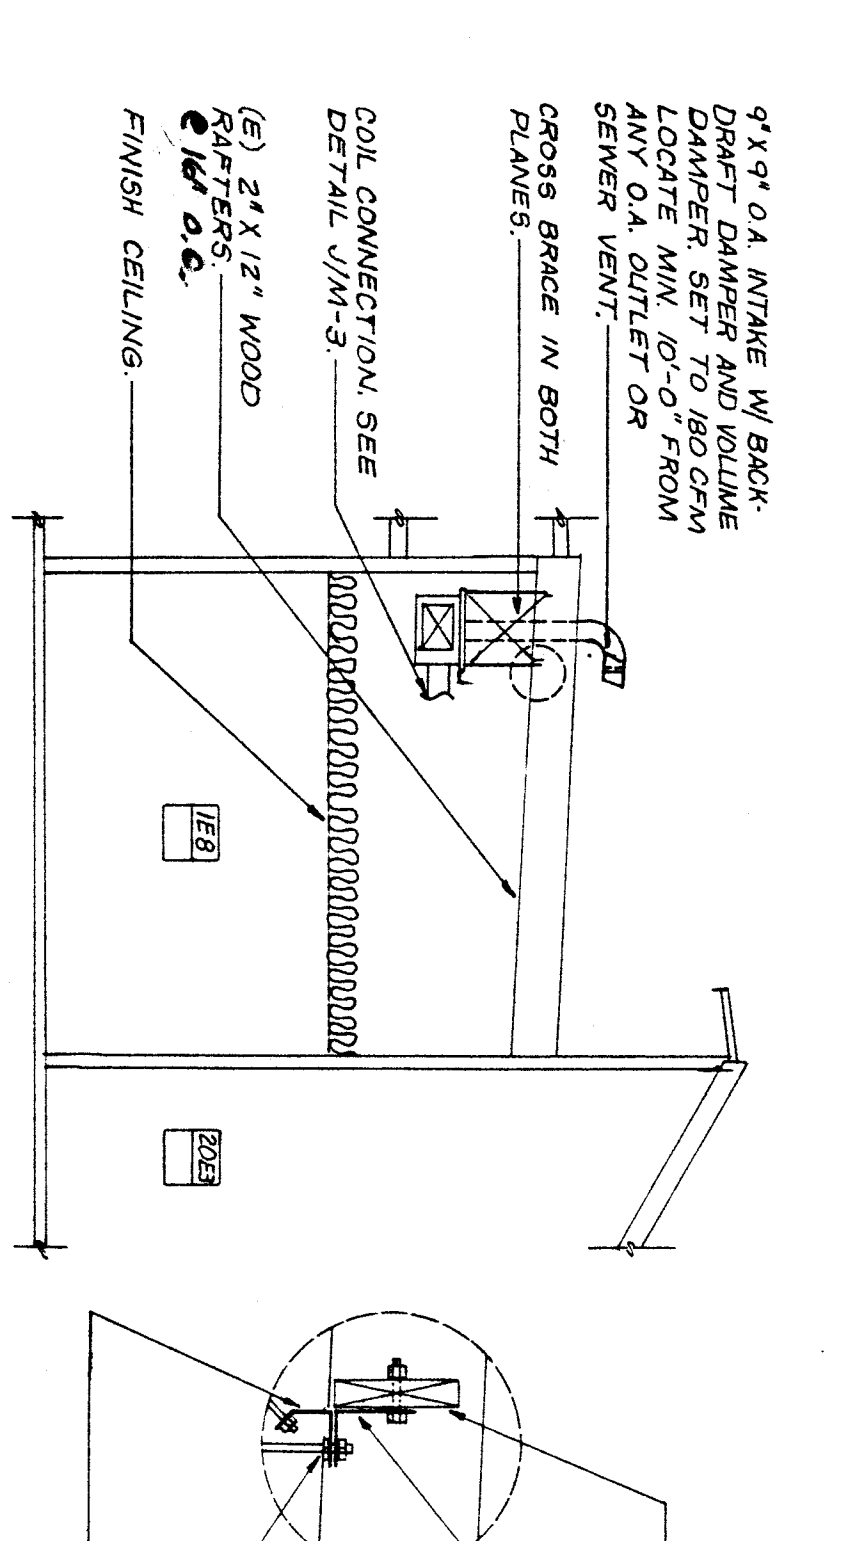

**FAN-COIL SUPPORT
DETAIL**

NO SCALE

AIR CONDITIONING PLAN
SCALE: 1/8" = 1'-0"

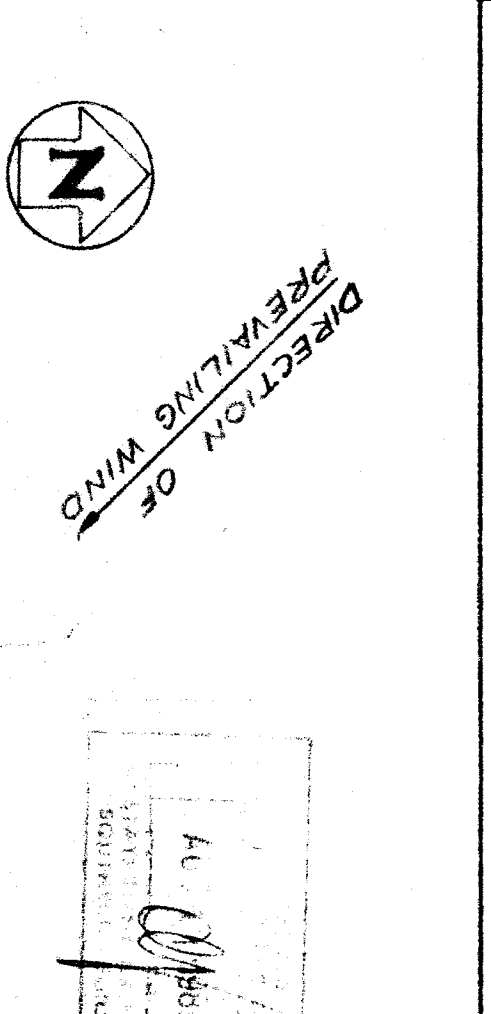

NOTE: TYPICAL NOTES FOR DEMOLITION AND NEW WORK SHEET M-5, APPLY TO BUILDINGS ON THIS SHEET.

CONDENSATE DRAIN BY SPEC. SECTION 15400, TYPICAL ALL UNIT VENTILATORS.