



SPECIFICATIONS: ROOF
 1. REMOVE ALL EXIST. ROOFING WHERE BLDG. IS TO BE LOCATED.
 2. GROUT MIX: 1 CEM. : 5 1/2 SAND (PACK AS NOTED @ FOUND. DTL'S.)

FIRE ALARM SYSTEM
 Written certification by the fire alarm equipment distributor (or vendor or manufacturer) shall be submitted to the Architect (with copies to the Electrical Engineer and the State Fire Marshal) stating that the system and its component parts are as LISTED & APPROVED by the State Fire Marshal and that the installation conforms in all respects to the requirements as set forth in Article 72, Title 19, California Administrative Code, prior to final acceptance of the project.

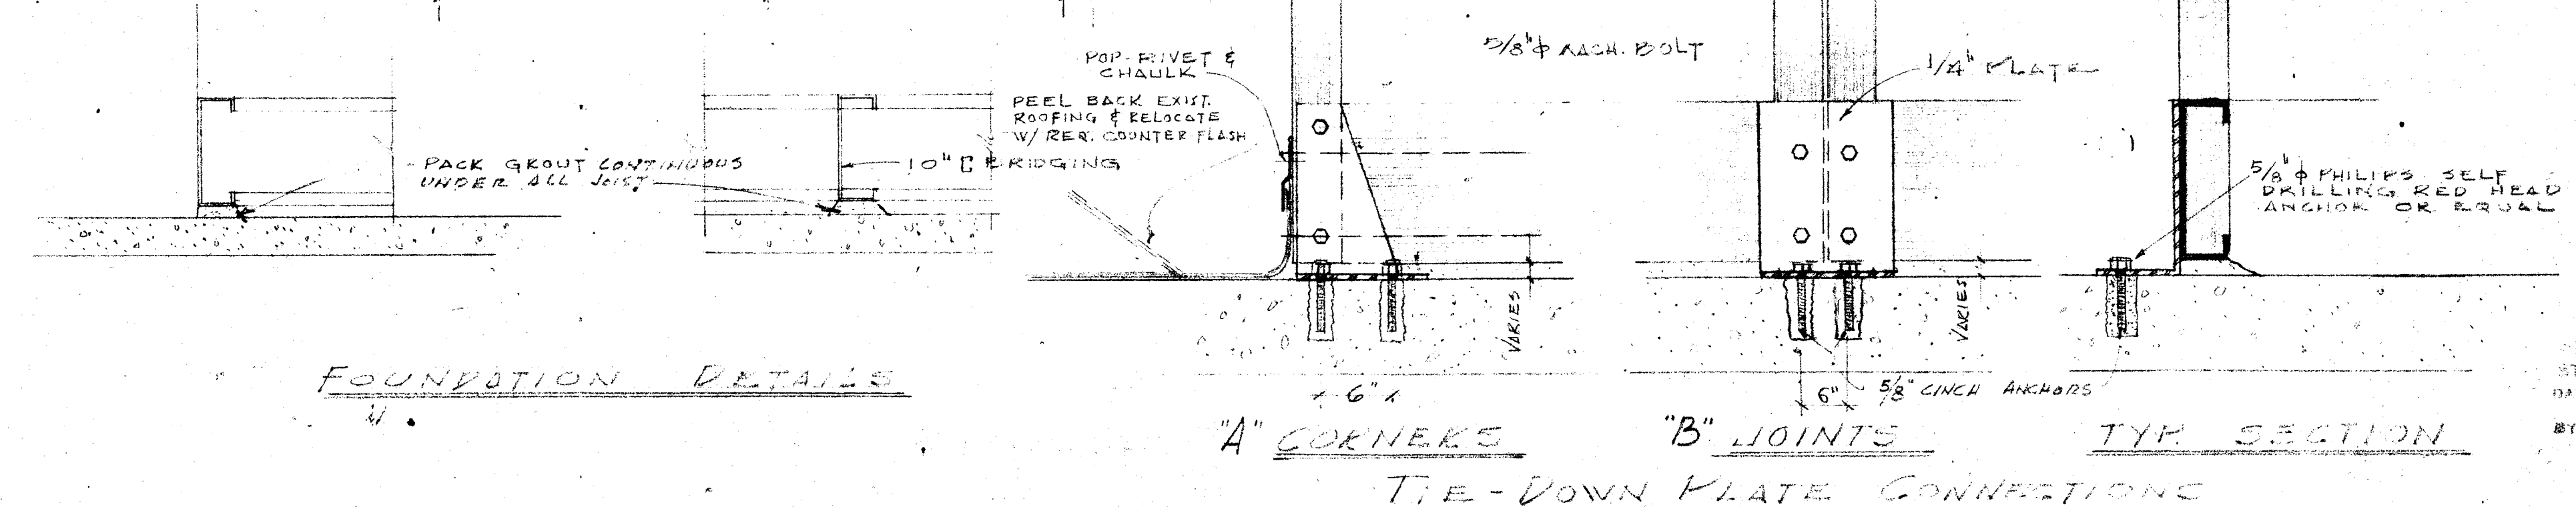

APPROVED
 STATE FIRE MARSHAL
 STATE OF CALIFORNIA
 DATE JUN 20 1966
 BY *[Signature]*

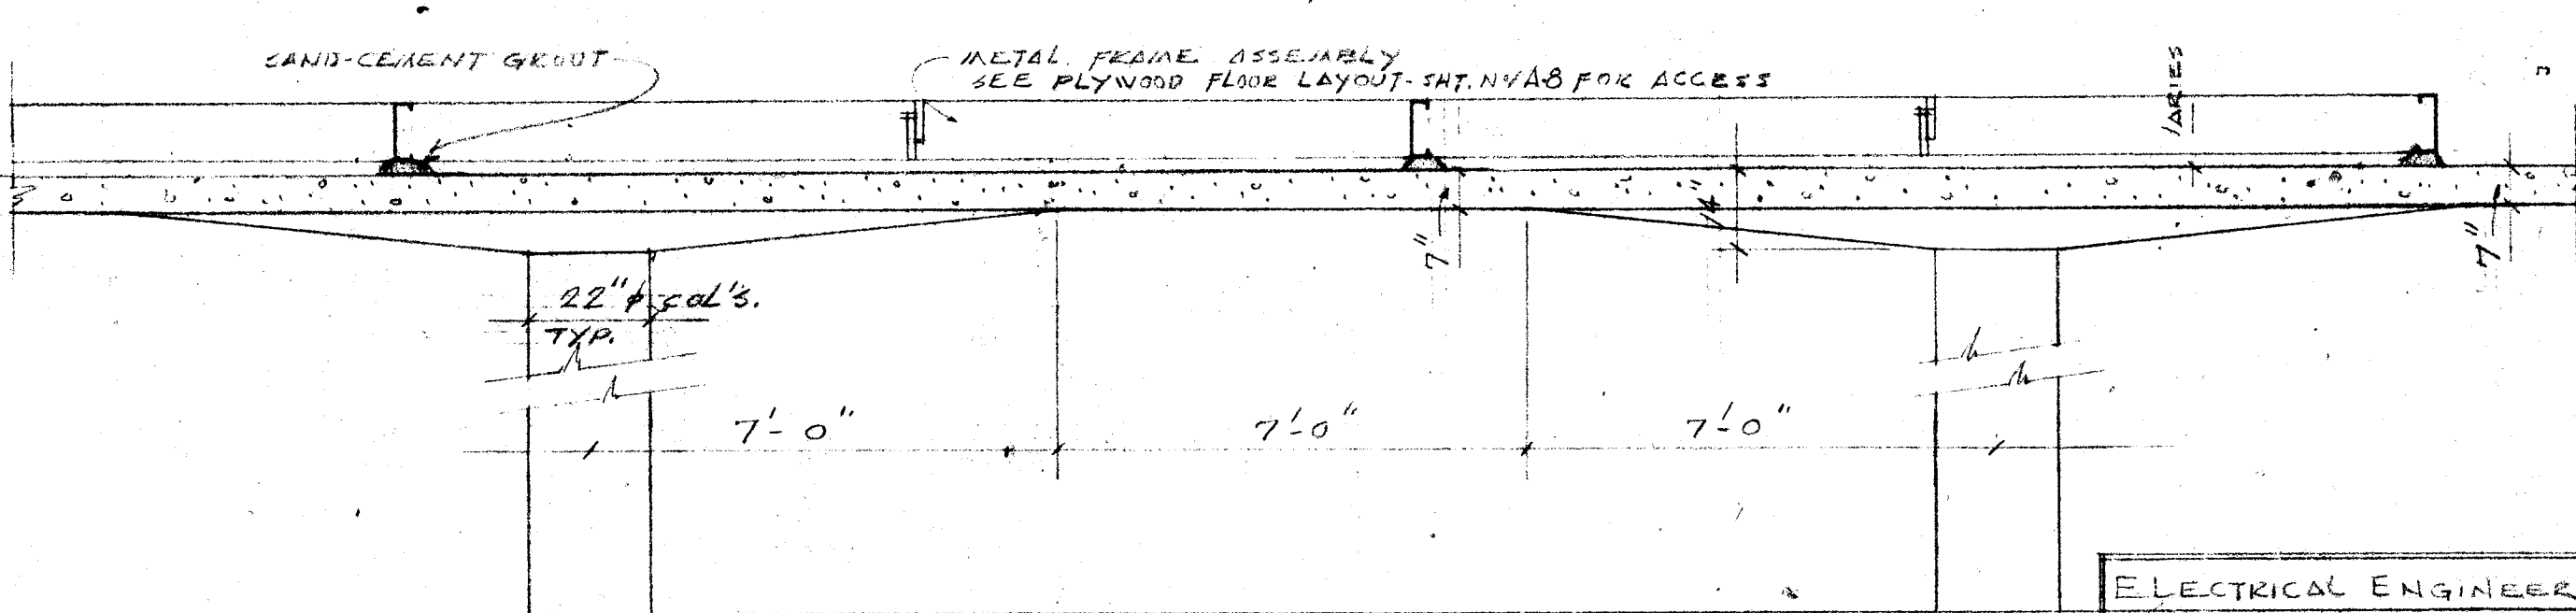

REF. EXIST. BLDG: A-14157 MAR. 30, '56		FIRE MARSHAL		DIVISION OF ARCHITECTURE STATE OF CALIFORNIA OFFICE OF ARCHITECTURE AND CONSTRUCTION	
27755		APPROVED JUN 20 1966		APPLICATOR Per <i>[Signature]</i>	
STRUCTURAL ENGINEER <i>[Signature]</i> EDWARD LINDSAY No. 778 REGISTERED PROFESSIONAL ENGINEER STATE OF CALIFORNIA		BAKERSFIELD CITY SCHOOL DISTRICT 1300 BAKER - BAKERSFIELD, CALIF. EDUCATIONAL CENTER		Job No. 753	
ELECTRICAL ENGINEER <i>[Signature]</i> 247503		SCALE: AS NOTED DATE: MAY 9, 1966		DRAWN BY J. A. REVISED	
		MOBILE RENTALS CORPORATION 2210 N. DUNSMUIR AVE. EL MONTE, CALIF.		DRAWING NUMBER 4-1 of 8	