

NOTE: WHERE PIPING CROSSES UNDER, THERE MUST BE A 6" CLEARANCE. THE PORTION OF THE NORMAL FOOTING EXCAVATED SHALL BE MADE UP TO THE FINISH GRADE WITH WAYS TO BE SET IN PLACE AT TIME OF POURING FOOTING.

RELATION OF PIPING AND TRENCHES TO CONCRETE FOOTINGS

PNEUMATIC HEATING CONTROL SYSTEM FOR MULTI-USE BUILDING-REF. SH. H-1


SYMBOL	DESCRIPTION
1	6" x 6" x 1/2" W.P. PIPE
2	4" x 4" x 1/2" W.P. PIPE
3	3" x 3" x 1/2" W.P. PIPE
4	2" x 2" x 1/2" W.P. PIPE
5	1" x 1" x 1/2" W.P. PIPE
6	1/2" x 1/2" x 1/2" W.P. PIPE
7	1/4" x 1/4" x 1/2" W.P. PIPE
8	1/8" x 1/8" x 1/2" W.P. PIPE
9	1/4" x 1/4" x 1/4" W.P. PIPE
10	1/8" x 1/8" x 1/4" W.P. PIPE
11	1/4" x 1/4" x 1/8" W.P. PIPE
12	1/8" x 1/8" x 1/8" W.P. PIPE
13	1/4" x 1/4" x 1/16" W.P. PIPE
14	1/8" x 1/8" x 1/16" W.P. PIPE
15	1/4" x 1/4" x 1/32" W.P. PIPE
16	1/8" x 1/8" x 1/32" W.P. PIPE
17	1/4" x 1/4" x 1/64" W.P. PIPE
18	1/8" x 1/8" x 1/64" W.P. PIPE
19	1/4" x 1/4" x 1/128" W.P. PIPE
20	1/8" x 1/8" x 1/128" W.P. PIPE
21	1/4" x 1/4" x 1/256" W.P. PIPE
22	1/8" x 1/8" x 1/256" W.P. PIPE
23	1/4" x 1/4" x 1/512" W.P. PIPE
24	1/8" x 1/8" x 1/512" W.P. PIPE
25	1/4" x 1/4" x 1/1024" W.P. PIPE
26	1/8" x 1/8" x 1/1024" W.P. PIPE
27	1/4" x 1/4" x 1/2048" W.P. PIPE
28	1/8" x 1/8" x 1/2048" W.P. PIPE
29	1/4" x 1/4" x 1/4096" W.P. PIPE
30	1/8" x 1/8" x 1/4096" W.P. PIPE
31	1/4" x 1/4" x 1/8192" W.P. PIPE
32	1/8" x 1/8" x 1/8192" W.P. PIPE
33	1/4" x 1/4" x 1/16384" W.P. PIPE
34	1/8" x 1/8" x 1/16384" W.P. PIPE
35	1/4" x 1/4" x 1/32768" W.P. PIPE
36	1/8" x 1/8" x 1/32768" W.P. PIPE
37	1/4" x 1/4" x 1/65536" W.P. PIPE
38	1/8" x 1/8" x 1/65536" W.P. PIPE
39	1/4" x 1/4" x 1/131072" W.P. PIPE
40	1/8" x 1/8" x 1/131072" W.P. PIPE
41	1/4" x 1/4" x 1/262144" W.P. PIPE
42	1/8" x 1/8" x 1/262144" W.P. PIPE
43	1/4" x 1/4" x 1/524288" W.P. PIPE
44	1/8" x 1/8" x 1/524288" W.P. PIPE
45	1/4" x 1/4" x 1/1048576" W.P. PIPE
46	1/8" x 1/8" x 1/1048576" W.P. PIPE
47	1/4" x 1/4" x 1/2097152" W.P. PIPE
48	1/8" x 1/8" x 1/2097152" W.P. PIPE
49	1/4" x 1/4" x 1/4194304" W.P. PIPE
50	1/8" x 1/8" x 1/4194304" W.P. PIPE
51	1/4" x 1/4" x 1/8388608" W.P. PIPE
52	1/8" x 1/8" x 1/8388608" W.P. PIPE
53	1/4" x 1/4" x 1/16777216" W.P. PIPE
54	1/8" x 1/8" x 1/16777216" W.P. PIPE
55	1/4" x 1/4" x 1/33554432" W.P. PIPE
56	1/8" x 1/8" x 1/33554432" W.P. PIPE
57	1/4" x 1/4" x 1/67108864" W.P. PIPE
58	1/8" x 1/8" x 1/67108864" W.P. PIPE
59	1/4" x 1/4" x 1/134217728" W.P. PIPE
60	1/8" x 1/8" x 1/134217728" W.P. PIPE
61	1/4" x 1/4" x 1/268435456" W.P. PIPE
62	1/8" x 1/8" x 1/268435456" W.P. PIPE
63	1/4" x 1/4" x 1/536870912" W.P. PIPE
64	1/8" x 1/8" x 1/536870912" W.P. PIPE
65	1/4" x 1/4" x 1/1073741824" W.P. PIPE
66	1/8" x 1/8" x 1/1073741824" W.P. PIPE
67	1/4" x 1/4" x 1/2147483648" W.P. PIPE
68	1/8" x 1/8" x 1/2147483648" W.P. PIPE
69	1/4" x 1/4" x 1/4294967296" W.P. PIPE
70	1/8" x 1/8" x 1/4294967296" W.P. PIPE
71	1/4" x 1/4" x 1/8589934592" W.P. PIPE
72	1/8" x 1/8" x 1/8589934592" W.P. PIPE
73	1/4" x 1/4" x 1/17179869184" W.P. PIPE
74	1/8" x 1/8" x 1/17179869184" W.P. PIPE
75	1/4" x 1/4" x 1/34359738368" W.P. PIPE
76	1/8" x 1/8" x 1/34359738368" W.P. PIPE
77	1/4" x 1/4" x 1/68719476736" W.P. PIPE
78	1/8" x 1/8" x 1/68719476736" W.P. PIPE
79	1/4" x 1/4" x 1/137438953472" W.P. PIPE
80	1/8" x 1/8" x 1/137438953472" W.P. PIPE
81	1/4" x 1/4" x 1/274877906944" W.P. PIPE
82	1/8" x 1/8" x 1/274877906944" W.P. PIPE
83	1/4" x 1/4" x 1/549755813888" W.P. PIPE
84	1/8" x 1/8" x 1/549755813888" W.P. PIPE
85	1/4" x 1/4" x 1/1099511627776" W.P. PIPE
86	1/8" x 1/8" x 1/1099511627776" W.P. PIPE
87	1/4" x 1/4" x 1/2199023255552" W.P. PIPE
88	1/8" x 1/8" x 1/2199023255552" W.P. PIPE
89	1/4" x 1/4" x 1/4398046511104" W.P. PIPE
90	1/8" x 1/8" x 1/4398046511104" W.P. PIPE
91	1/4" x 1/4" x 1/8796093022208" W.P. PIPE
92	1/8" x 1/8" x 1/8796093022208" W.P. PIPE
93	1/4" x 1/4" x 1/17592186044416" W.P. PIPE
94	1/8" x 1/8" x 1/17592186044416" W.P. PIPE
95	1/4" x 1/4" x 1/35184372088832" W.P. PIPE
96	1/8" x 1/8" x 1/35184372088832" W.P. PIPE
97	1/4" x 1/4" x 1/70368744177664" W.P. PIPE
98	1/8" x 1/8" x 1/70368744177664" W.P. PIPE
99	1/4" x 1/4" x 1/140737488355328" W.P. PIPE
100	1/8" x 1/8" x 1/140737488355328" W.P. PIPE

SPECIAL NOTES

1. PIPING SHALL BE INSTALLED ABOVE GRADE UNLESS OTHERWISE SPECIFIED.
2. PIPING SHALL BE INSTALLED IN TRENCHES UNLESS OTHERWISE SPECIFIED.
3. PIPING SHALL BE INSTALLED IN TRENCHES UNLESS OTHERWISE SPECIFIED.
4. PIPING SHALL BE INSTALLED IN TRENCHES UNLESS OTHERWISE SPECIFIED.
5. PIPING SHALL BE INSTALLED IN TRENCHES UNLESS OTHERWISE SPECIFIED.
6. PIPING SHALL BE INSTALLED IN TRENCHES UNLESS OTHERWISE SPECIFIED.
7. PIPING SHALL BE INSTALLED IN TRENCHES UNLESS OTHERWISE SPECIFIED.
8. PIPING SHALL BE INSTALLED IN TRENCHES UNLESS OTHERWISE SPECIFIED.
9. PIPING SHALL BE INSTALLED IN TRENCHES UNLESS OTHERWISE SPECIFIED.
10. PIPING SHALL BE INSTALLED IN TRENCHES UNLESS OTHERWISE SPECIFIED.

NOTES

1. ALL PIPING SHALL BE INSTALLED IN TRENCHES UNLESS OTHERWISE SPECIFIED.
2. ALL PIPING SHALL BE INSTALLED IN TRENCHES UNLESS OTHERWISE SPECIFIED.
3. ALL PIPING SHALL BE INSTALLED IN TRENCHES UNLESS OTHERWISE SPECIFIED.
4. ALL PIPING SHALL BE INSTALLED IN TRENCHES UNLESS OTHERWISE SPECIFIED.
5. ALL PIPING SHALL BE INSTALLED IN TRENCHES UNLESS OTHERWISE SPECIFIED.
6. ALL PIPING SHALL BE INSTALLED IN TRENCHES UNLESS OTHERWISE SPECIFIED.
7. ALL PIPING SHALL BE INSTALLED IN TRENCHES UNLESS OTHERWISE SPECIFIED.
8. ALL PIPING SHALL BE INSTALLED IN TRENCHES UNLESS OTHERWISE SPECIFIED.
9. ALL PIPING SHALL BE INSTALLED IN TRENCHES UNLESS OTHERWISE SPECIFIED.
10. ALL PIPING SHALL BE INSTALLED IN TRENCHES UNLESS OTHERWISE SPECIFIED.

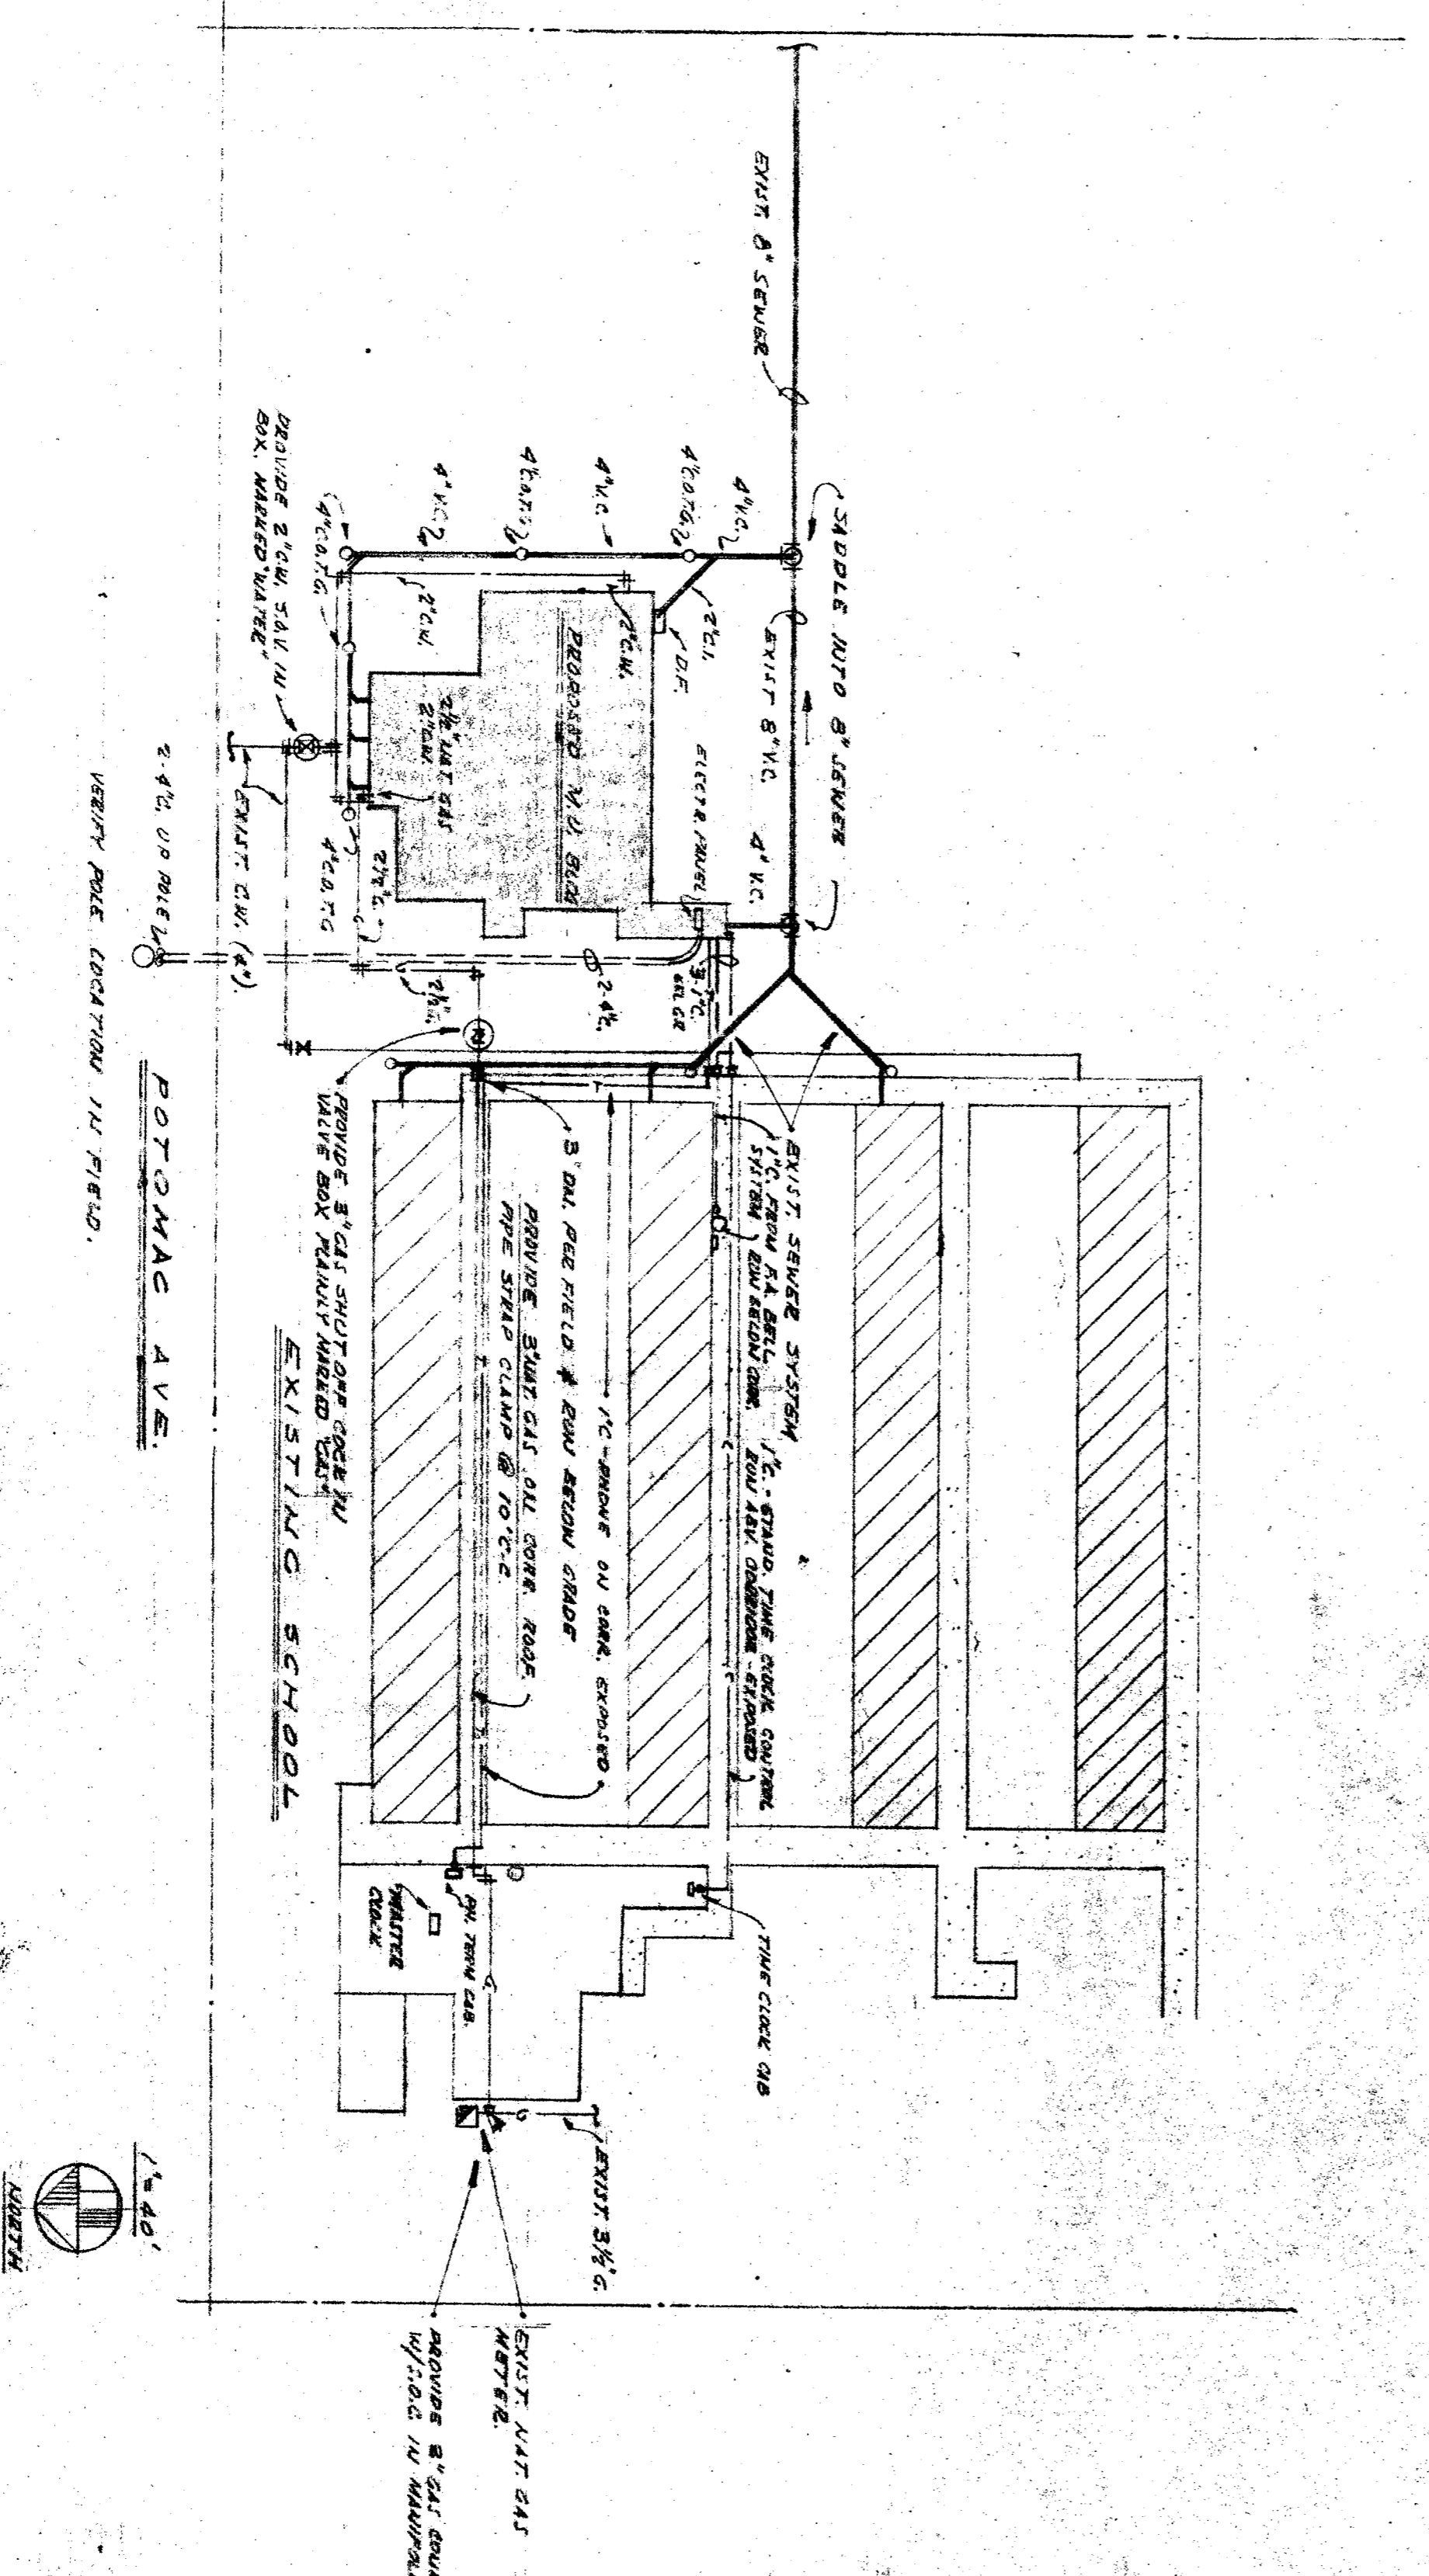

APPROVED BY
BOARD OF EDUCATION
BARKERSFIELD CITY SCHOOL DISTRICT
DATE: 10/15/59
BY: [Signature]

DATE OF EXAMINATION: 10/15/59
DRAWING NO.: 10177
APPROVED: [Signature]

MECHANICAL PLAN & CONTROLS
MULTI-PURPOSE SCHOOL
MT. VERNON SCHOOL
BARKERSFIELD CITY SCHOOL DISTRICT

C. Barton Alford
A. R. C. H. I. T. E. C. T.
1816 CALIFORNIA AVENUE
BARKERSFIELD, CALIFORNIA