

date
6/23/89
revisions
2/23/90

MUNSEY SCHOOL MODERNIZATION
BAKERSFIELD CITY SCHOOL DISTRICT
BAKERSFIELD, CALIFORNIA

APPROVED
Department of Education
Office of the State Architect
ACCESS COMPLIANCE SECTION
5/24/21 FEB 27 90
APPLICATION PER W. AND B.S.
J.L.R.

ONLY
FEB 27 90

5/24/21 FEB 27 90
APPLICATION PER W. AND B.S.
J.L.R.

TITLE 24 & 1979 JCB
FR 27
524-L PM/LA
Kendrick
Design
Group
architects • planners

2115 19th street • bakersfield, ca 93301 • (805) 322-1863

job number
8712


sheet number
A-4

KEY NOTES #712.TYP
NOTES LISTED IN THIS COLUMN WHICH ARE NOT INDICATED ON THIS SHEET SHALL BE DISREGARDED. COMPLETE PATCH AND REPAIR OF AREAS AND ADJACENT AREAS WHERE REMOVAL, DEMOLITION OR MODIFICATIONS ARE MADE ARE A PART OF THIS WORK. FIELD VERIFICATION FOR ACTUAL EXISTING CONDITIONS PRIOR TO BIDDING, FABRICATION, INSTALLATION OR CONSTRUCTION IS A PART OF THIS WORK. NOTES ARE TYPICAL UNLESS OTHERWISE INDICATED.


LEGEND
(N) = NEW
(E) = EXISTING
(D) = DEMOLITION
AS S.D.S.S. = AS SHOWN, DETAILED, SCHEDULED, OR SPECIFIED.

- NEW WORK**
- (N) UPPER CABINETS AND APPURTENANT ITEMS TO BE PROVIDED & INSTALLED AS S.D.S.S.
 - (N) LOWER CABINETS AND APPURTENANT ITEMS TO BE PROVIDED & INSTALLED AS S.D.S.S.
 - (N) FULL HEIGHT CABINETS AND APPURTENANT ITEMS TO BE PROVIDED & INSTALLED AS S.D.S.S.
 - (N) COUNTERTOPS, SPLASH AND APPURTENANT ITEMS TO BE PROVIDED & INSTALLED AS S.D.S.S.
 - (N) CABINETS, CASEWORK, AND/OR SHELVING AND APPURTENANT ITEMS TO BE PROVIDED AND INSTALLED AS S.D.S.S.
 - (N) TRIM, MILLWORK OR OTHER ITEMS AND APPURTENANT WORK TO BE PROVIDED & INSTALLED AS S.D.S.S.
 - (N) LAY-IN BATT INSULATION TO BE PROVIDED & INSTALLED OVER (N) T-BAR CEILING AS S.D.S.S.
 - (N) DOOR AND/OR HARDWARE AND APPURTENANT ITEMS TO BE PROVIDED & INSTALLED AS S.D.S.S.
 - (N) PAINT OVER (E) PLASTER WALL FINISH.
 - (N) T-BAR ACOUSTICAL CEILING WITH ALL APPURTENANT ITEMS TO BE PROVIDED & INSTALLED AS S.D.S.S.
 - (N) BASE AND APPURTENANT ITEMS TO BE PROVIDED & INSTALLED AS S.D.S.S.
 - (N) CHALKBOARD, TRIM & APPURTENANT ITEMS TO BE PROVIDED & INSTALLED AS S.D.S.S.
 - (N) TACKBOARD, TRIM & APPURTENANT ITEMS TO BE PROVIDED & INSTALLED AS S.D.S.S.
 - (N) TOILET PARTITIONS & APPURTENANT ITEMS TO BE PROVIDED & INSTALLED AS S.D.S.S.
 - (N) MIRROR & APPURTENANT ITEMS TO BE PROVIDED & INSTALLED AS S.D.S.S.
 - (N) DARKENING DRAPES AND APPURTENANT ITEMS TO BE PROVIDED & INSTALLED AS S.D.S.S.
 - (N) HANDICAPPED GRAB BAR AND APPURTENANT ITEMS TO BE PROVIDED & INSTALLED AS S.D.S.S.
 - (N) RELOCATED CLOCK. (REFER TO ELECTRICAL)
 - (N) ACCESSORY & APPURTENANT ITEMS TO BE PROVIDED AND INSTALLED AS S.D.S.S.
 - (N) PLUMBING FIXTURE. (REFER TO PLUMBING DRAWINGS AND SPECIFICATIONS.)
 - (N) HANDICAPPED TOILET SEAT AS S.D.S.S. (REFER TO PLUMBING DRAWINGS & SPECIFICATIONS.)
 - (N) HANDICAPPED PLUMBING FIXTURE AS S.D.S.S. (REFER TO PLUMBING DRAWING & SPECIFICATIONS.)
 - (N) MECHANICAL UNIT AND/OR ITEMS. (REFER TO MECHANICAL DRAWINGS AND SPECIFICATIONS.)
 - (N) ELECTRICAL ITEM. (REFER TO ELECTRICAL DRAWINGS AND SPECIFICATIONS.)
 - (N) SHELF & POLE AS S.D.S.S.
 - (N) FLOORING TO BE PROVIDED & INSTALLED AS S.D.S.S.
 - (N) HANDICAPPED CHAIR LIFT.
 - (N) CONCRETE PAD @ SHADED AREA.
 - (N) SURFACE AT (E) EASEL TO BE PROVIDED AND INSTALLED AS S.D.S.S.
 - (N) 2 X 4 STUD WALL W/ 1/2" GYP. BD. W/ VENEER PLASTER MATCH EXISTING.
 - (E) OPENING TO BE FILLED IN AS S.D.S.S.
 - REVERSE SWING OF (E) DOOR AS S.D.S.S. DEMO & PROVIDE (N) JAMB & APPURTENANT WORK AS REQ'D.

- (E) CASEWORK TO REMAIN.
- (E) UPPER CABINETS AND APPURTENANT ITEMS TO BE REMOVED.
- (E) LOWER CABINETS AND APPURTENANT ITEMS TO BE REMOVED.
- (E) FULL HEIGHT CABINETS AND APPURTENANT ITEMS TO BE REMOVED.
- (E) COUNTERTOPS, SPLASH AND APPURTENANT ITEMS TO BE REMOVED.
- (E) CABINETS, COUNTERTOPS, SPLASH AND APPURTENANT ITEMS TO BE REMOVED.
- (E) SHELVING AND APPURTENANT ITEMS TO BE REMOVED.
- (E) SHELVING & APPURTENANT ITEMS TO REMAIN.
- (E) TRIM, MILL WORK OR OTHER ITEMS AND APPURTENANT WORK TO BE REMOVED.
- (E) FURRED PLUMBING WALL TO REMAIN.
- (E) DOOR AND/OR HARDWARE AND APPURTENANT ITEMS TO BE REMOVED.
- (E) ACOUSTIC TILE CEILING TO REMAIN. DEMO AS REQUIRED FOR T-BAR INSTALLATION.
- (E) BASE AND APPURTENANT ITEMS TO REMAIN.
- (E) BASE AND APPURTENANT ITEMS TO BE REMOVED.
- (E) CERAMIC TILE TO BE REMOVED.
- (E) CERAMIC TILE AT WALL/BASE TO REMAIN.
- (E) CHALKBOARD, TRIM AND APPURTENANT ITEMS TO BE REMOVED.
- (E) TACKBOARD, TRIM & APPURTENANT ITEMS TO BE REMOVED.
- (E) TOILET PARTITIONS AND ALL APPURTENANT ITEMS TO BE REMOVED.
- (E) MIRROR AND ALL APPURTENANT ITEMS TO BE REMOVED.
- (E) DARKENING DRAPE AND APPURTENANT ITEMS TO BE REMOVED.
- (E) DARKENING DRAPE & APPURTENANT ITEMS TO REMAIN.
- (E) CLOCK. (REFER TO ELECTRICAL)
- (E) ACCESSORY & APPURTENANT ITEMS TO BE REMOVED.
- (E) ACCESSORY & APPURTENANT ITEMS TO REMAIN.
- (E) PLUMBING FIXTURE, ITEM AND/OR APPURTENANT WORK (REFER TO PLUMBING DRAWINGS AND SPECIFICATIONS.)
- (E) MECHANICAL UNIT, ITEM AND/OR APPURTENANT WORK (REFER TO MECHANICAL DRAWINGS AND SPECIFICATIONS.)
- (E) ELECTRICAL DRAWINGS AND APPURTENANT WORK (REFER TO ELECTRICAL DRAWINGS AND SPECIFICATIONS.)
- (E) ITEM AND APPURTENANT WORK TO BE REMOVED. (FIELD VERIFY.)
- (E) ITEM AND APPURTENANT WORK TO REMAIN.
- (E) FLOORING TO BE REMOVED.
- (E) FLOORING TO REMAIN.
- (E) EASEL SURFACE TO BE REMOVED.
- (E) STAIRS TO BE CUT BACK TO ACCEPT (N) HANDICAPPED CHAIR LIFT. PROVIDE AND INSTALL IN STAIR END RISER AND ALL APPURTENANT ITEMS TO MATCH (E).
- (E) GLAZING AND/OR DOOR TO REMAIN.
- (E) WALL TO BE DEMOLISHED AS S.D.S.S.

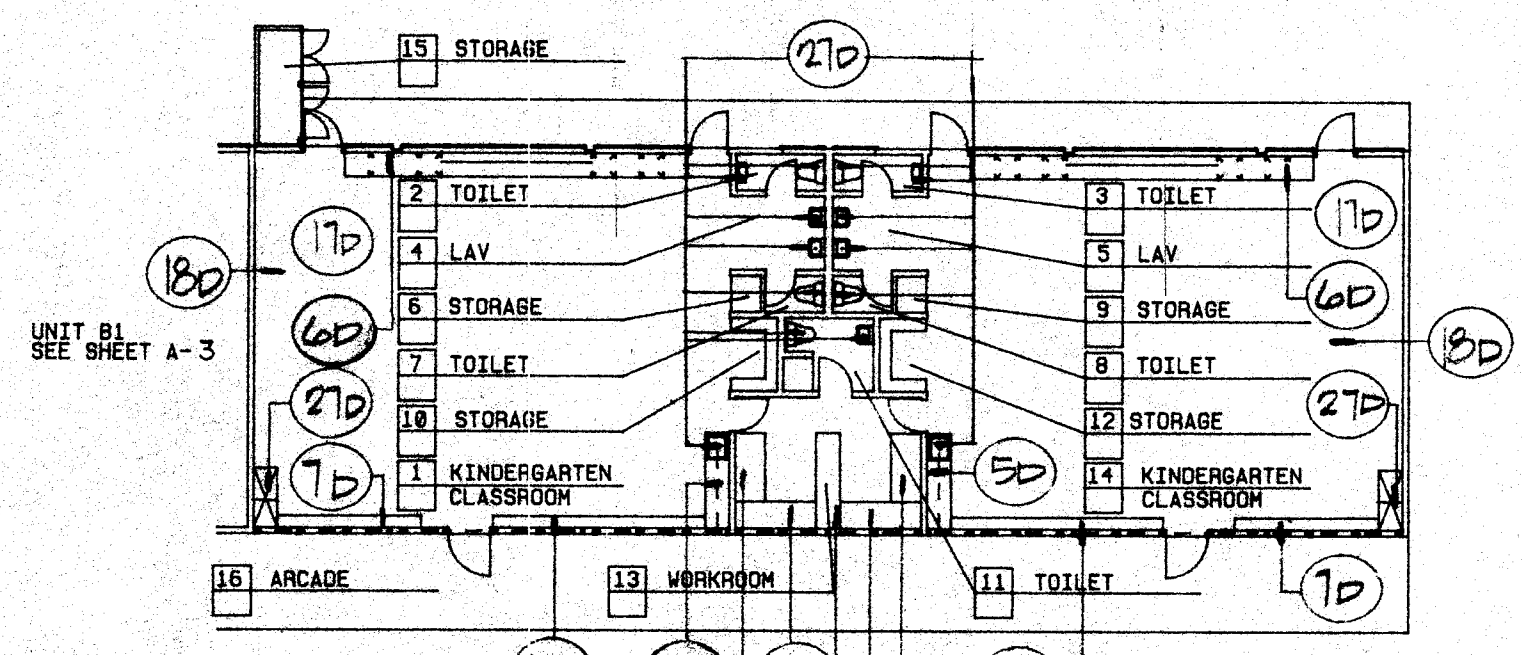

FLOOR PLAN - UNIT 82
(DEMOLITION/EXISTING PLAN)
1/8" = 1'-0"

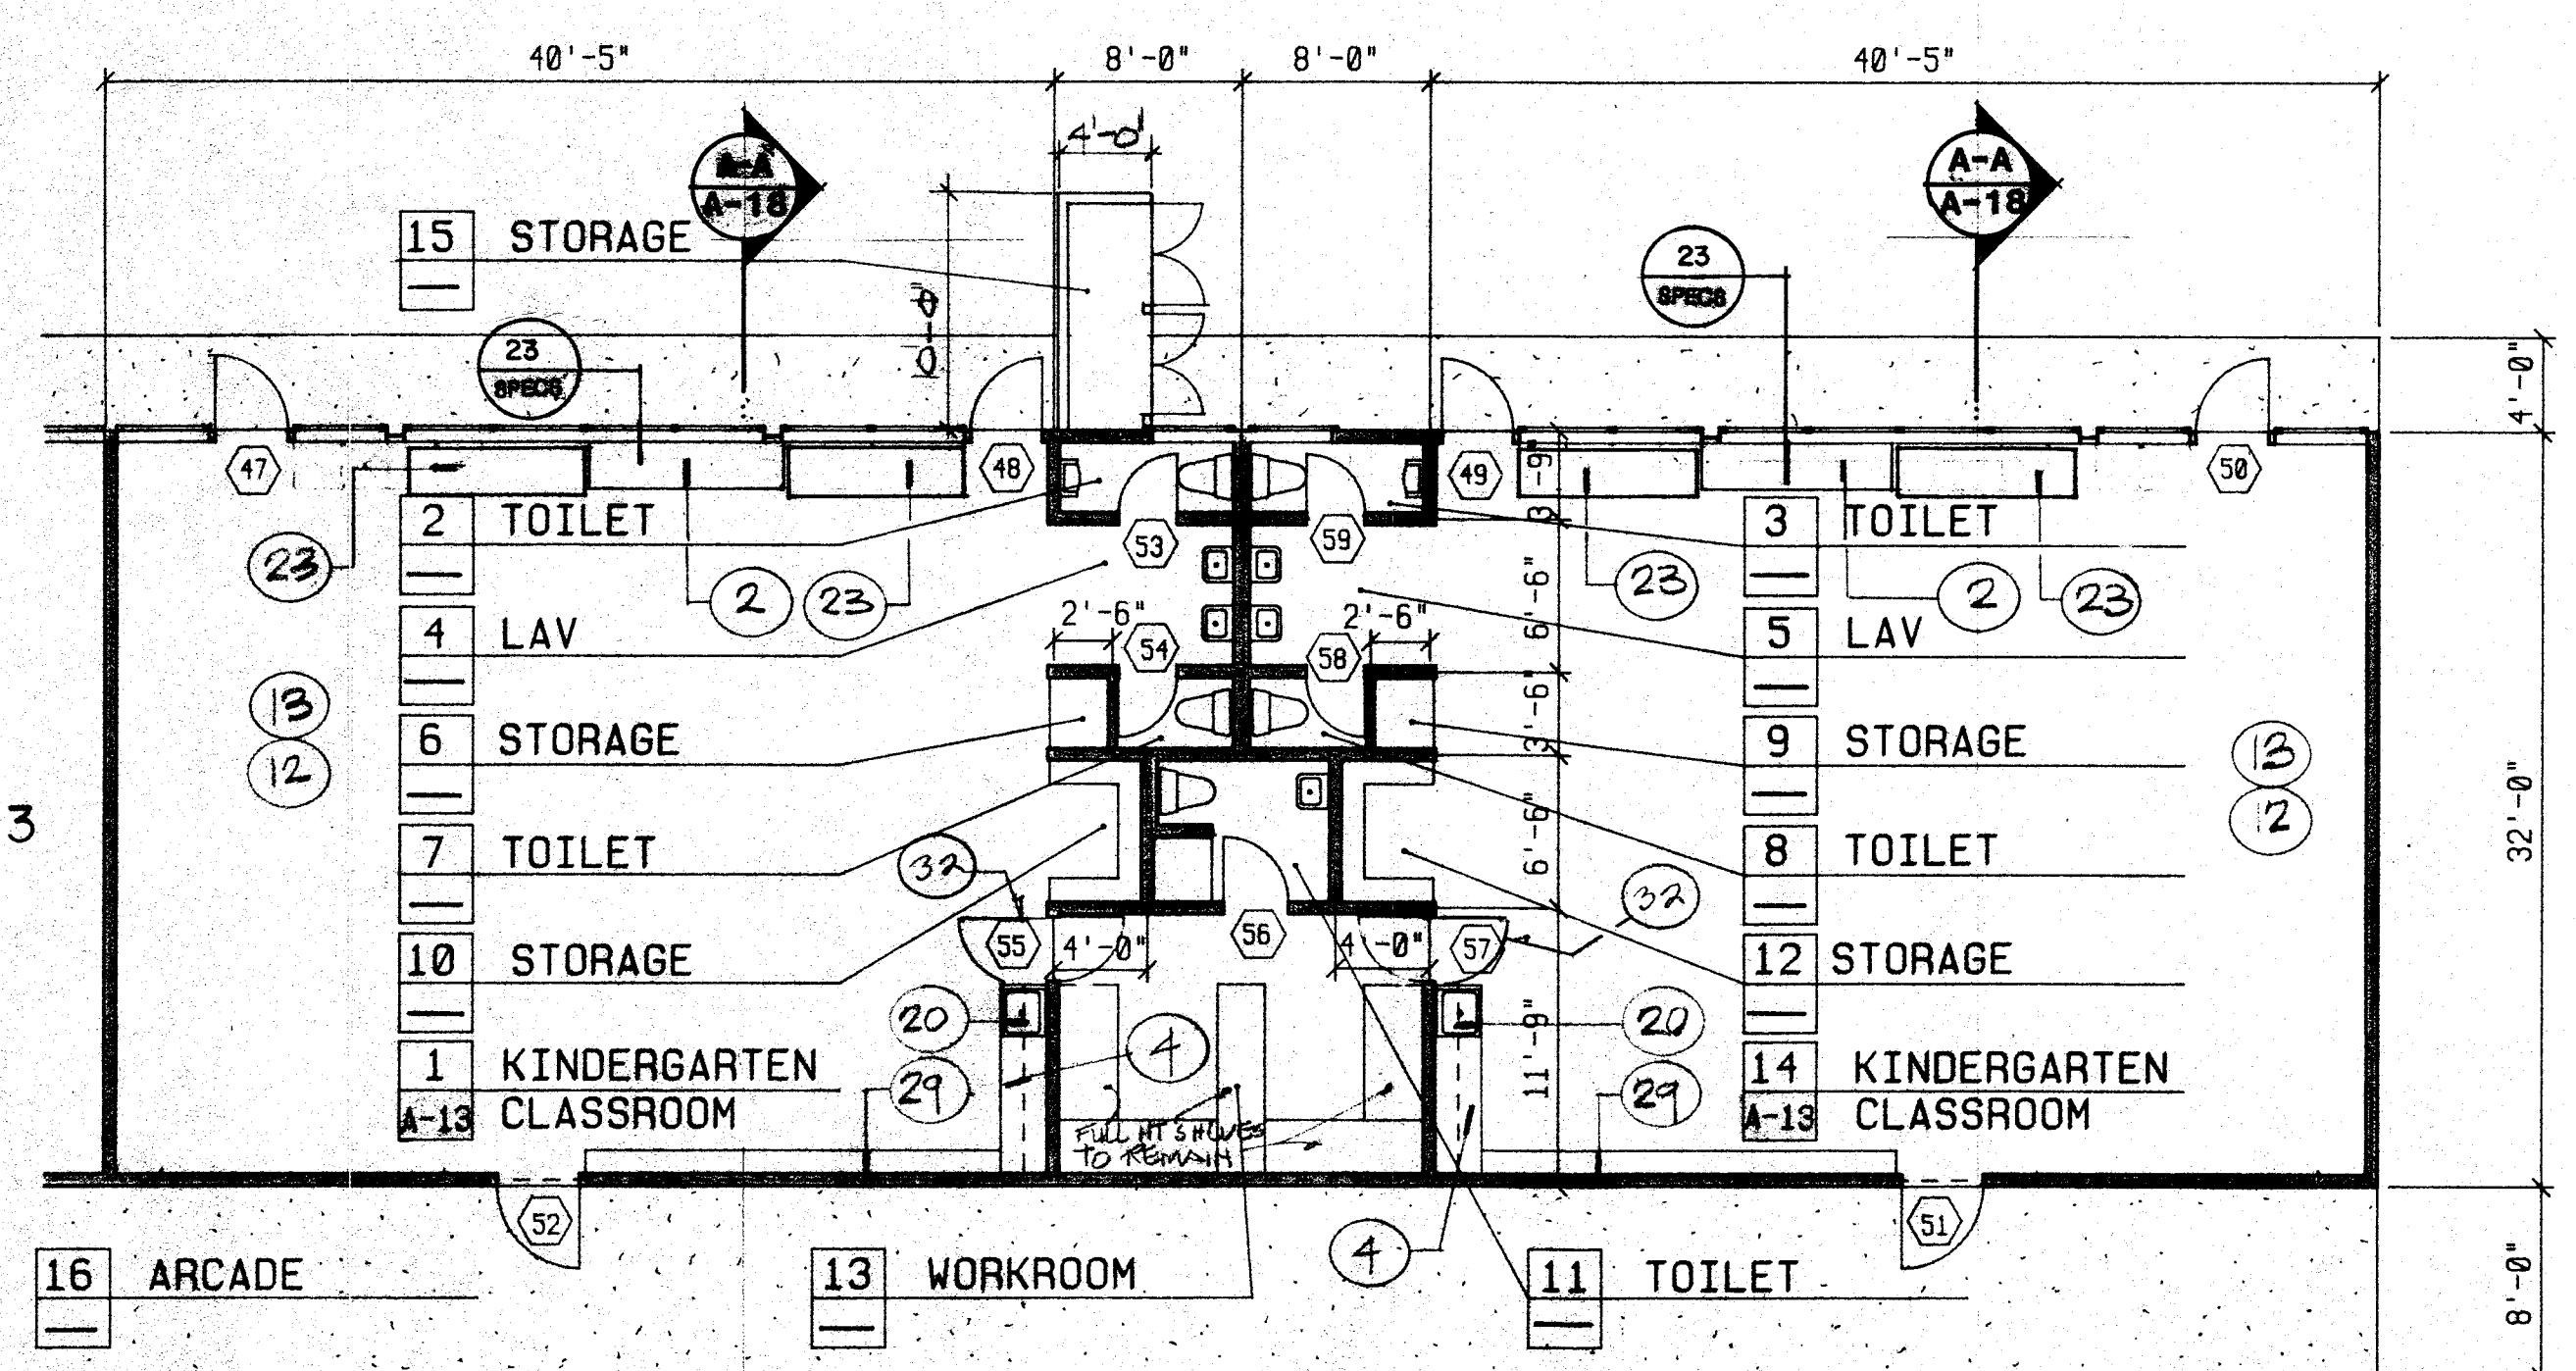

FLOOR PLAN - UNIT 82
(NEW)
NOTE
1. FOR DOOR/HARDWARE INFORMATION REFER TO DOOR SCHEDULE.
2. FOR FINISH INFORMATION REFER TO FINISH SCHEDULE.
1/8" = 1'-0"

UNIT B1
SEE SHEET A-3

UNIT B1
SEE SHEET A-3