

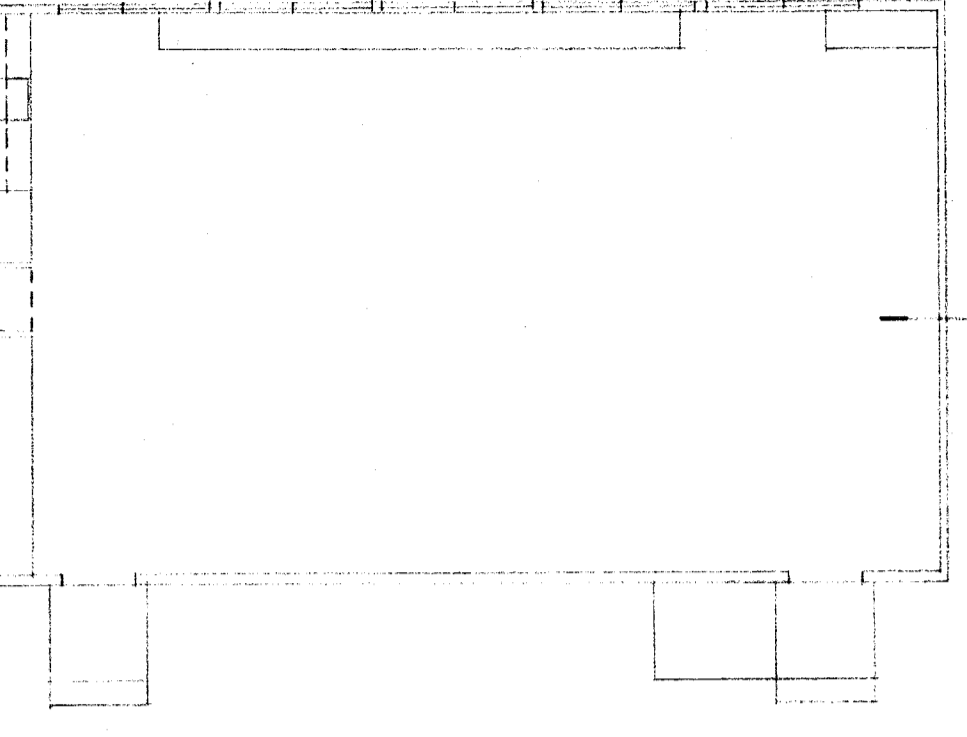


PLUMBING FLOOR PLAN UNIT R1
SCALE: 1/8" = 1'-0"

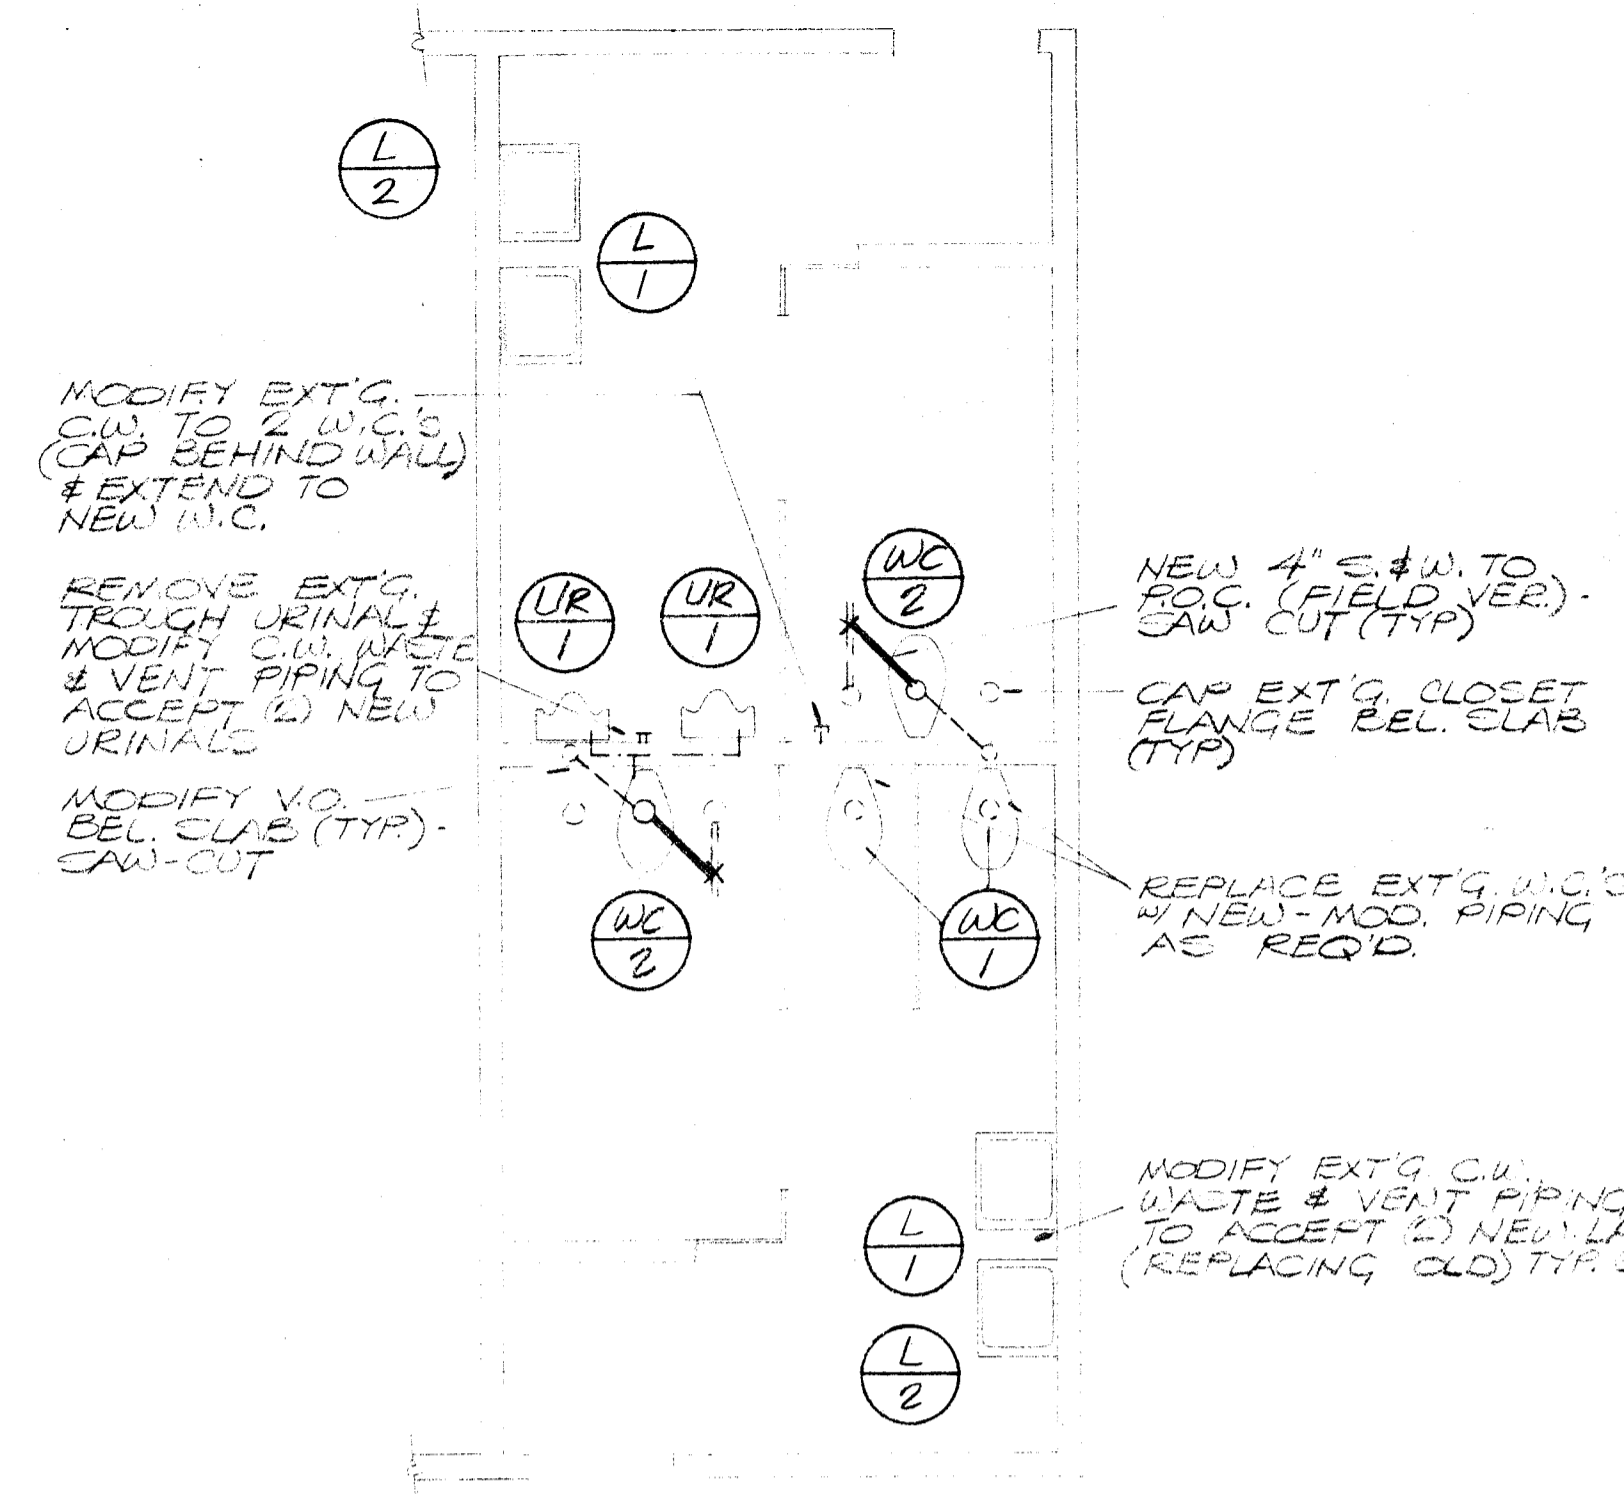

FLOOR PLAN UNIT R2
SCALE: 1/8" = 1'-0"

PLUMBING PLAN
SCALE: 1/4" = 1'-0"

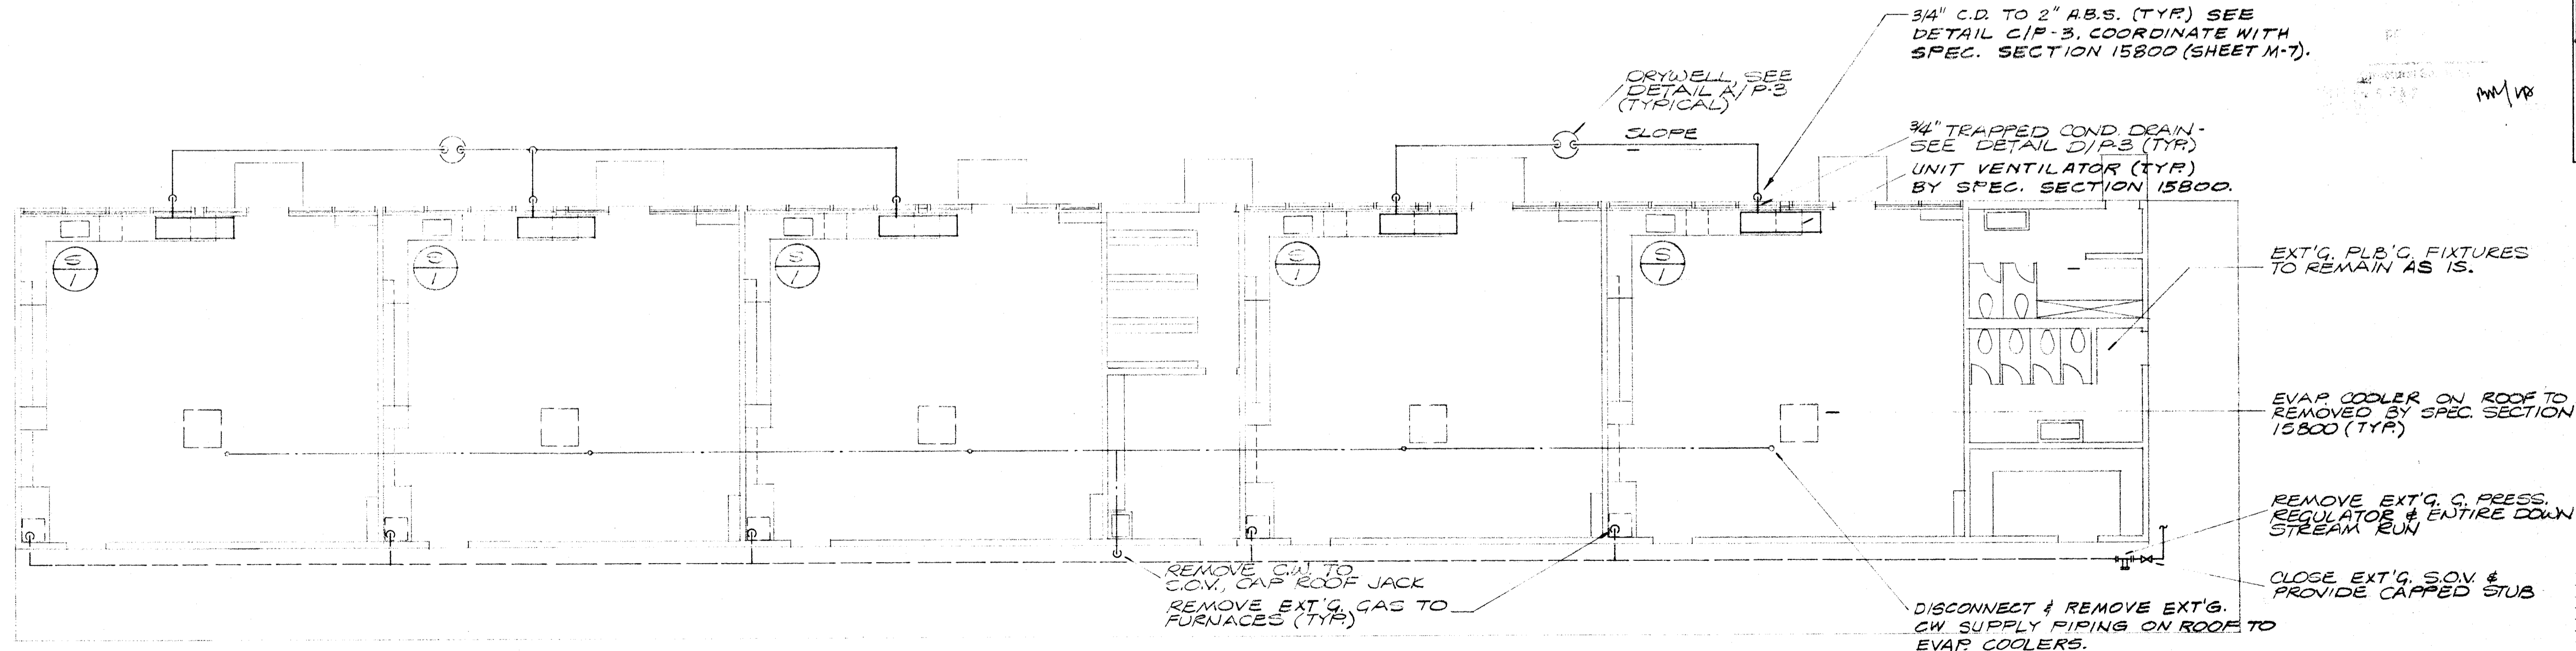

PLUMBING FLOOR PLAN UNIT E
SCALE: 1/8" = 1'-0"