




PLAN - HEATER UNIT
TYPICAL CLASSROOM
SCALE 1/2" = 1'-0"

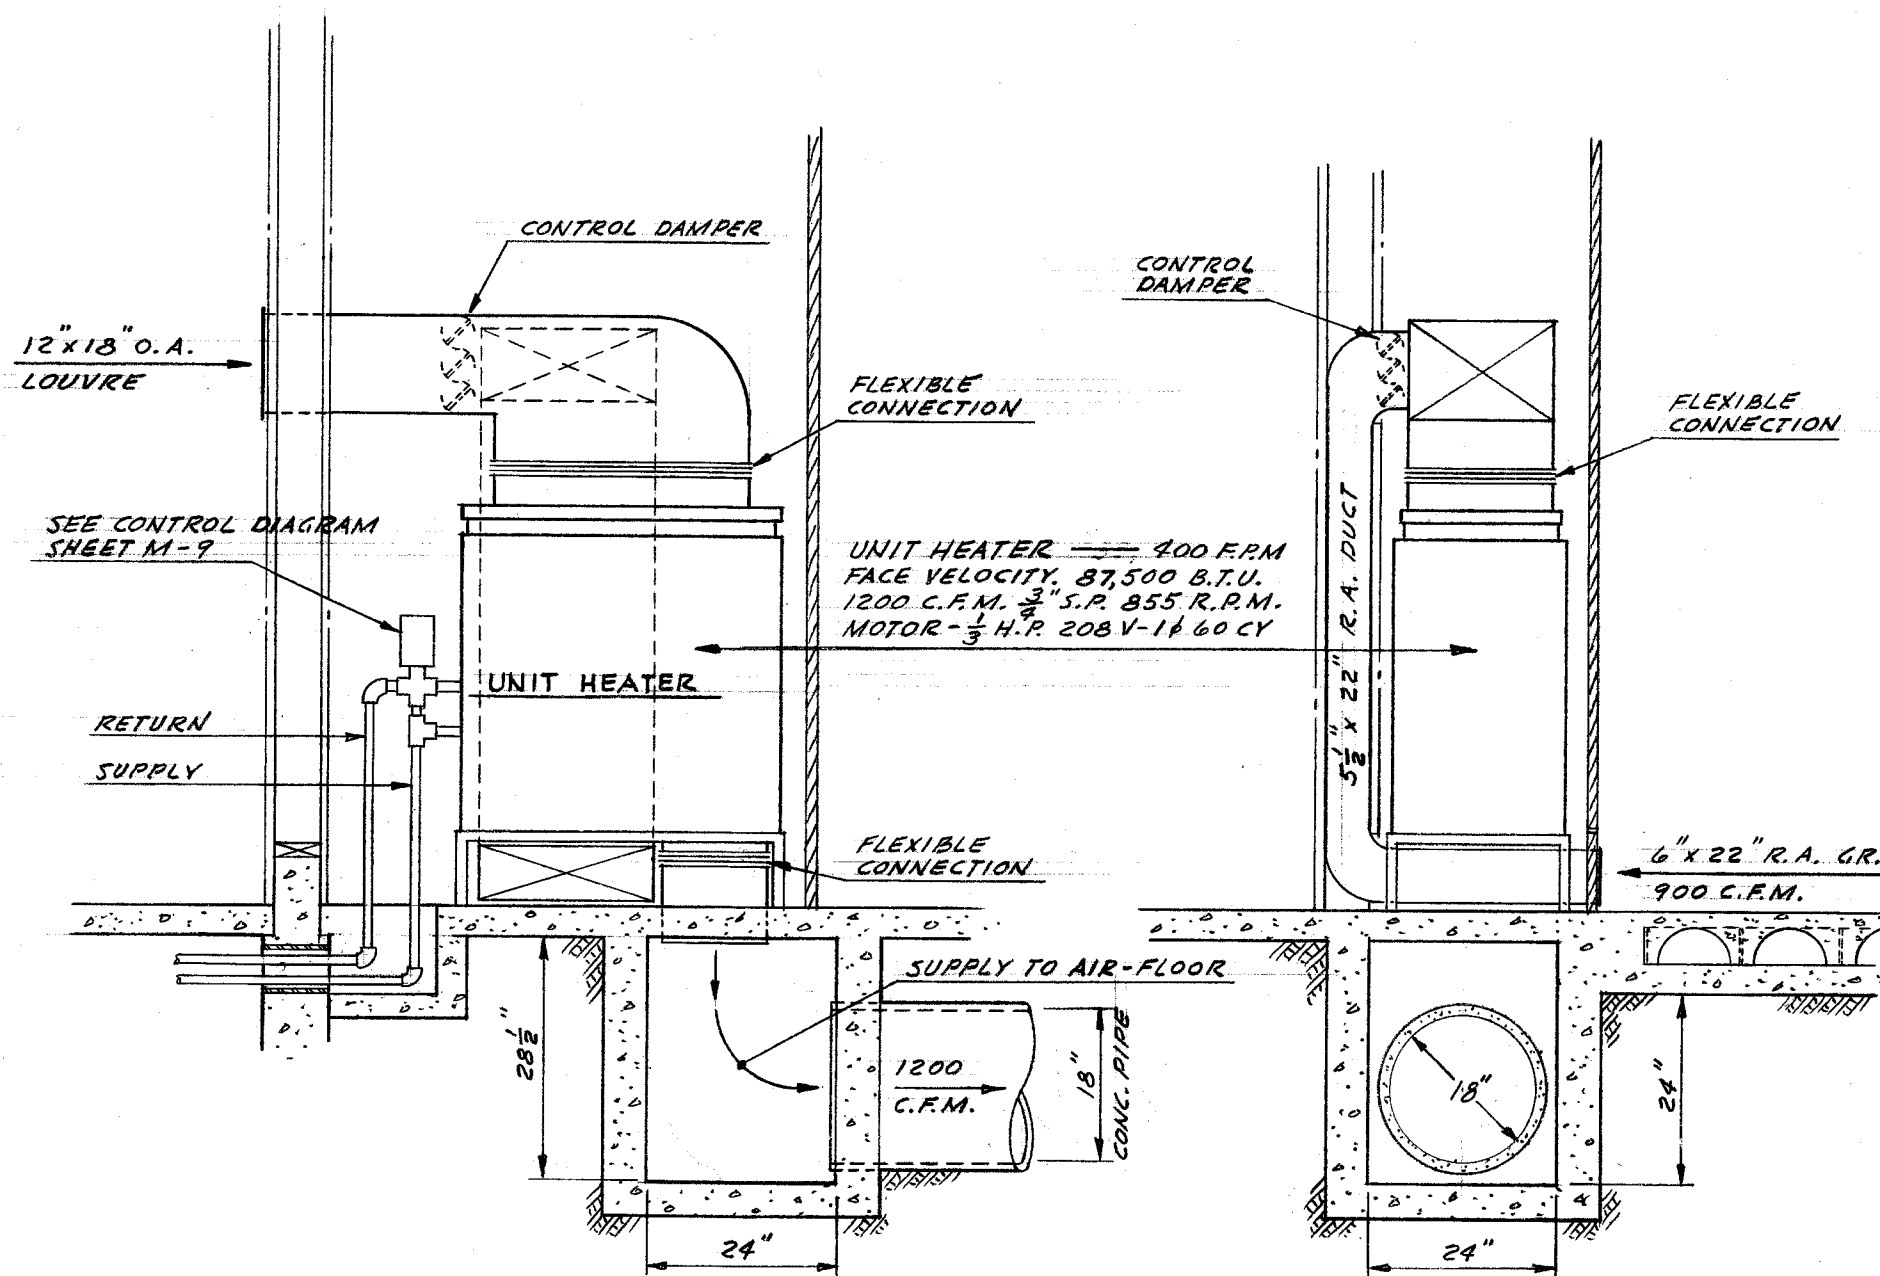


SECTION - "A" - "A"
SECTION - "B" - "B"
SCALE 1/2" = 1'-0"

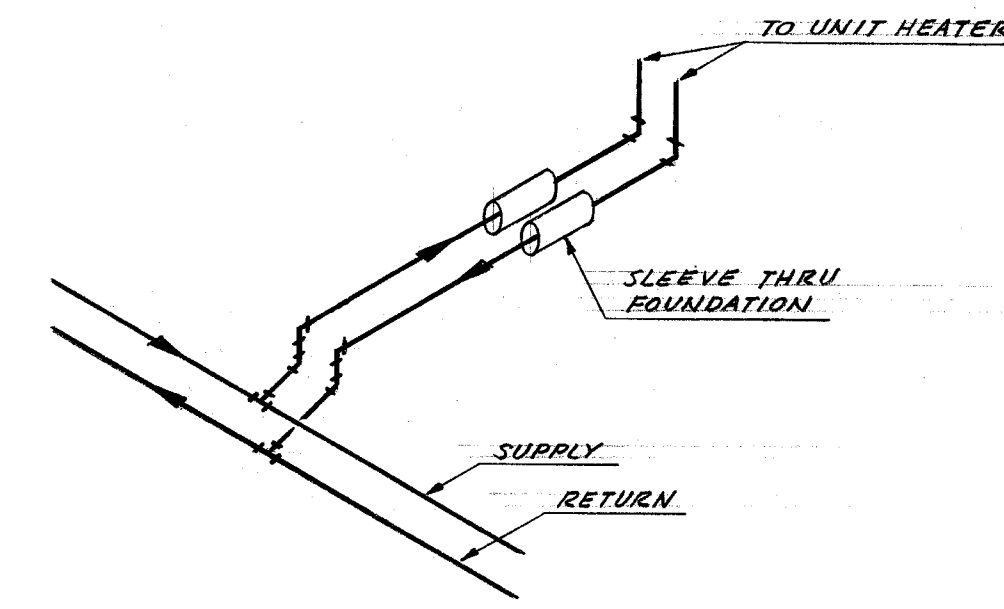


ISOMETRIC SHOWING TYPICAL PIPE CONNECTIONS @ UNIT HEATERS

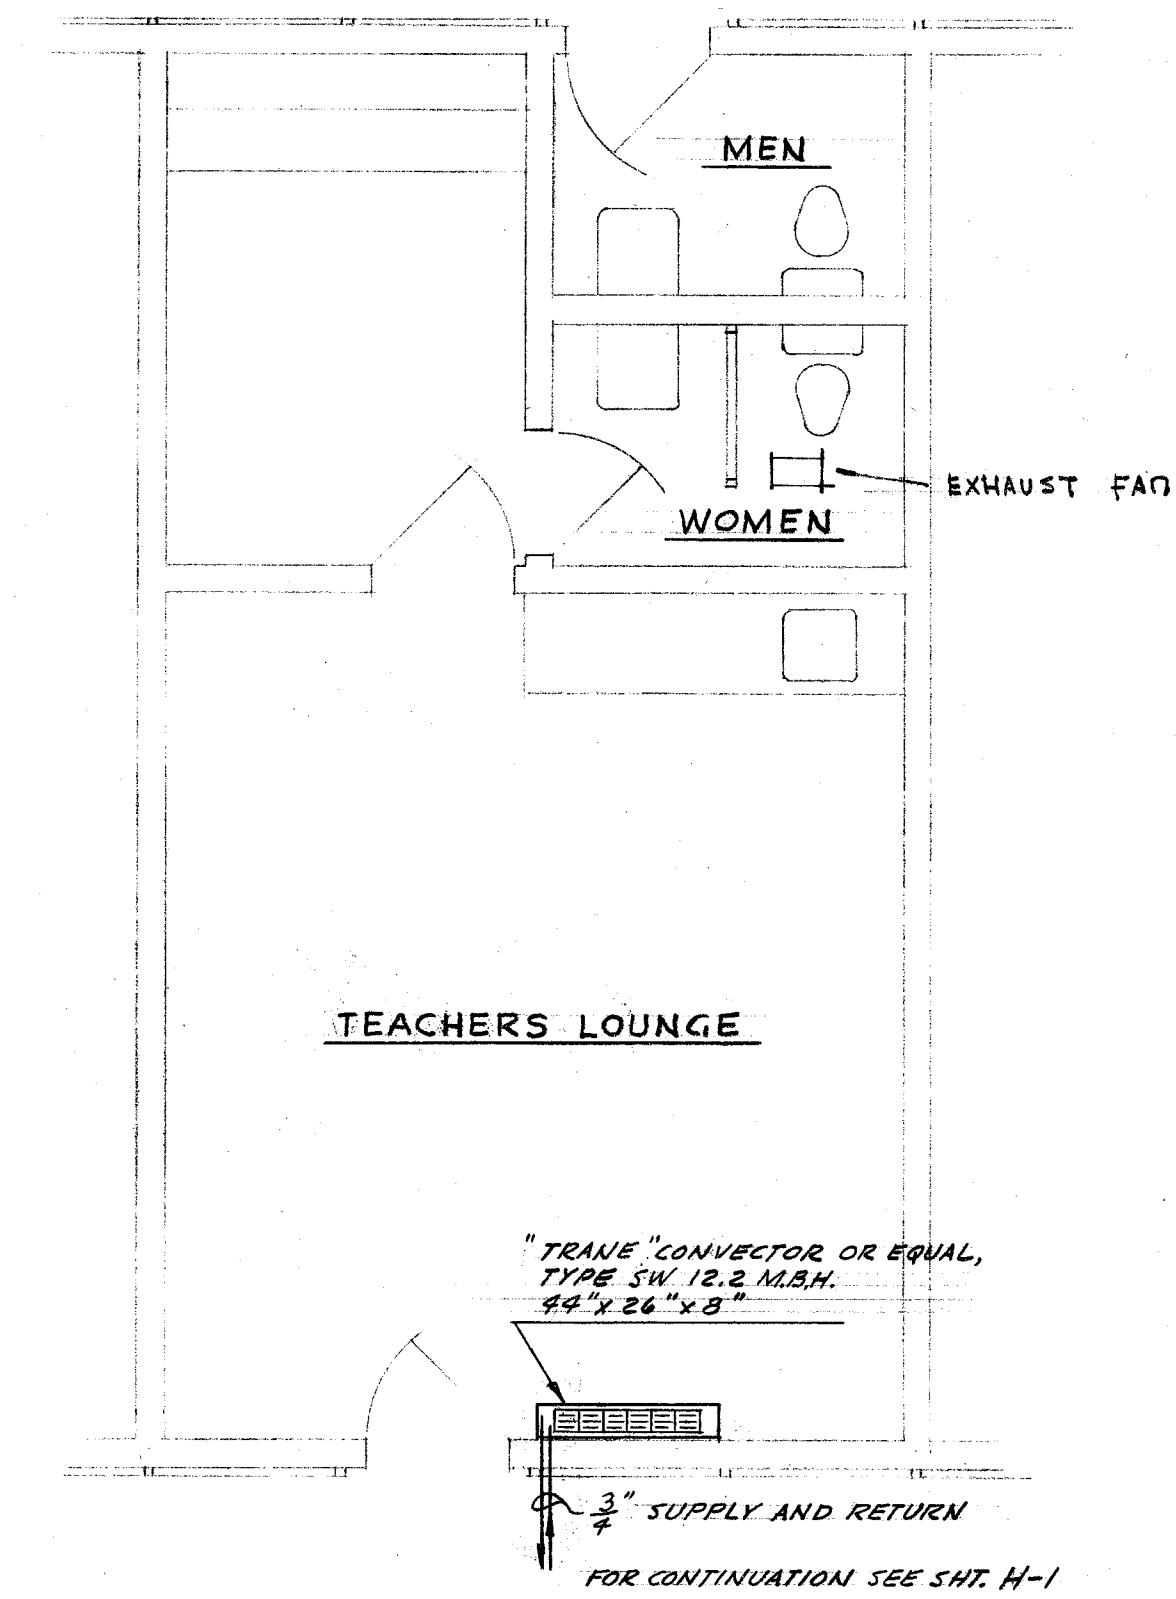


PLAN AT UNIT FOUR
SCALE 1/4" = 1'-0"

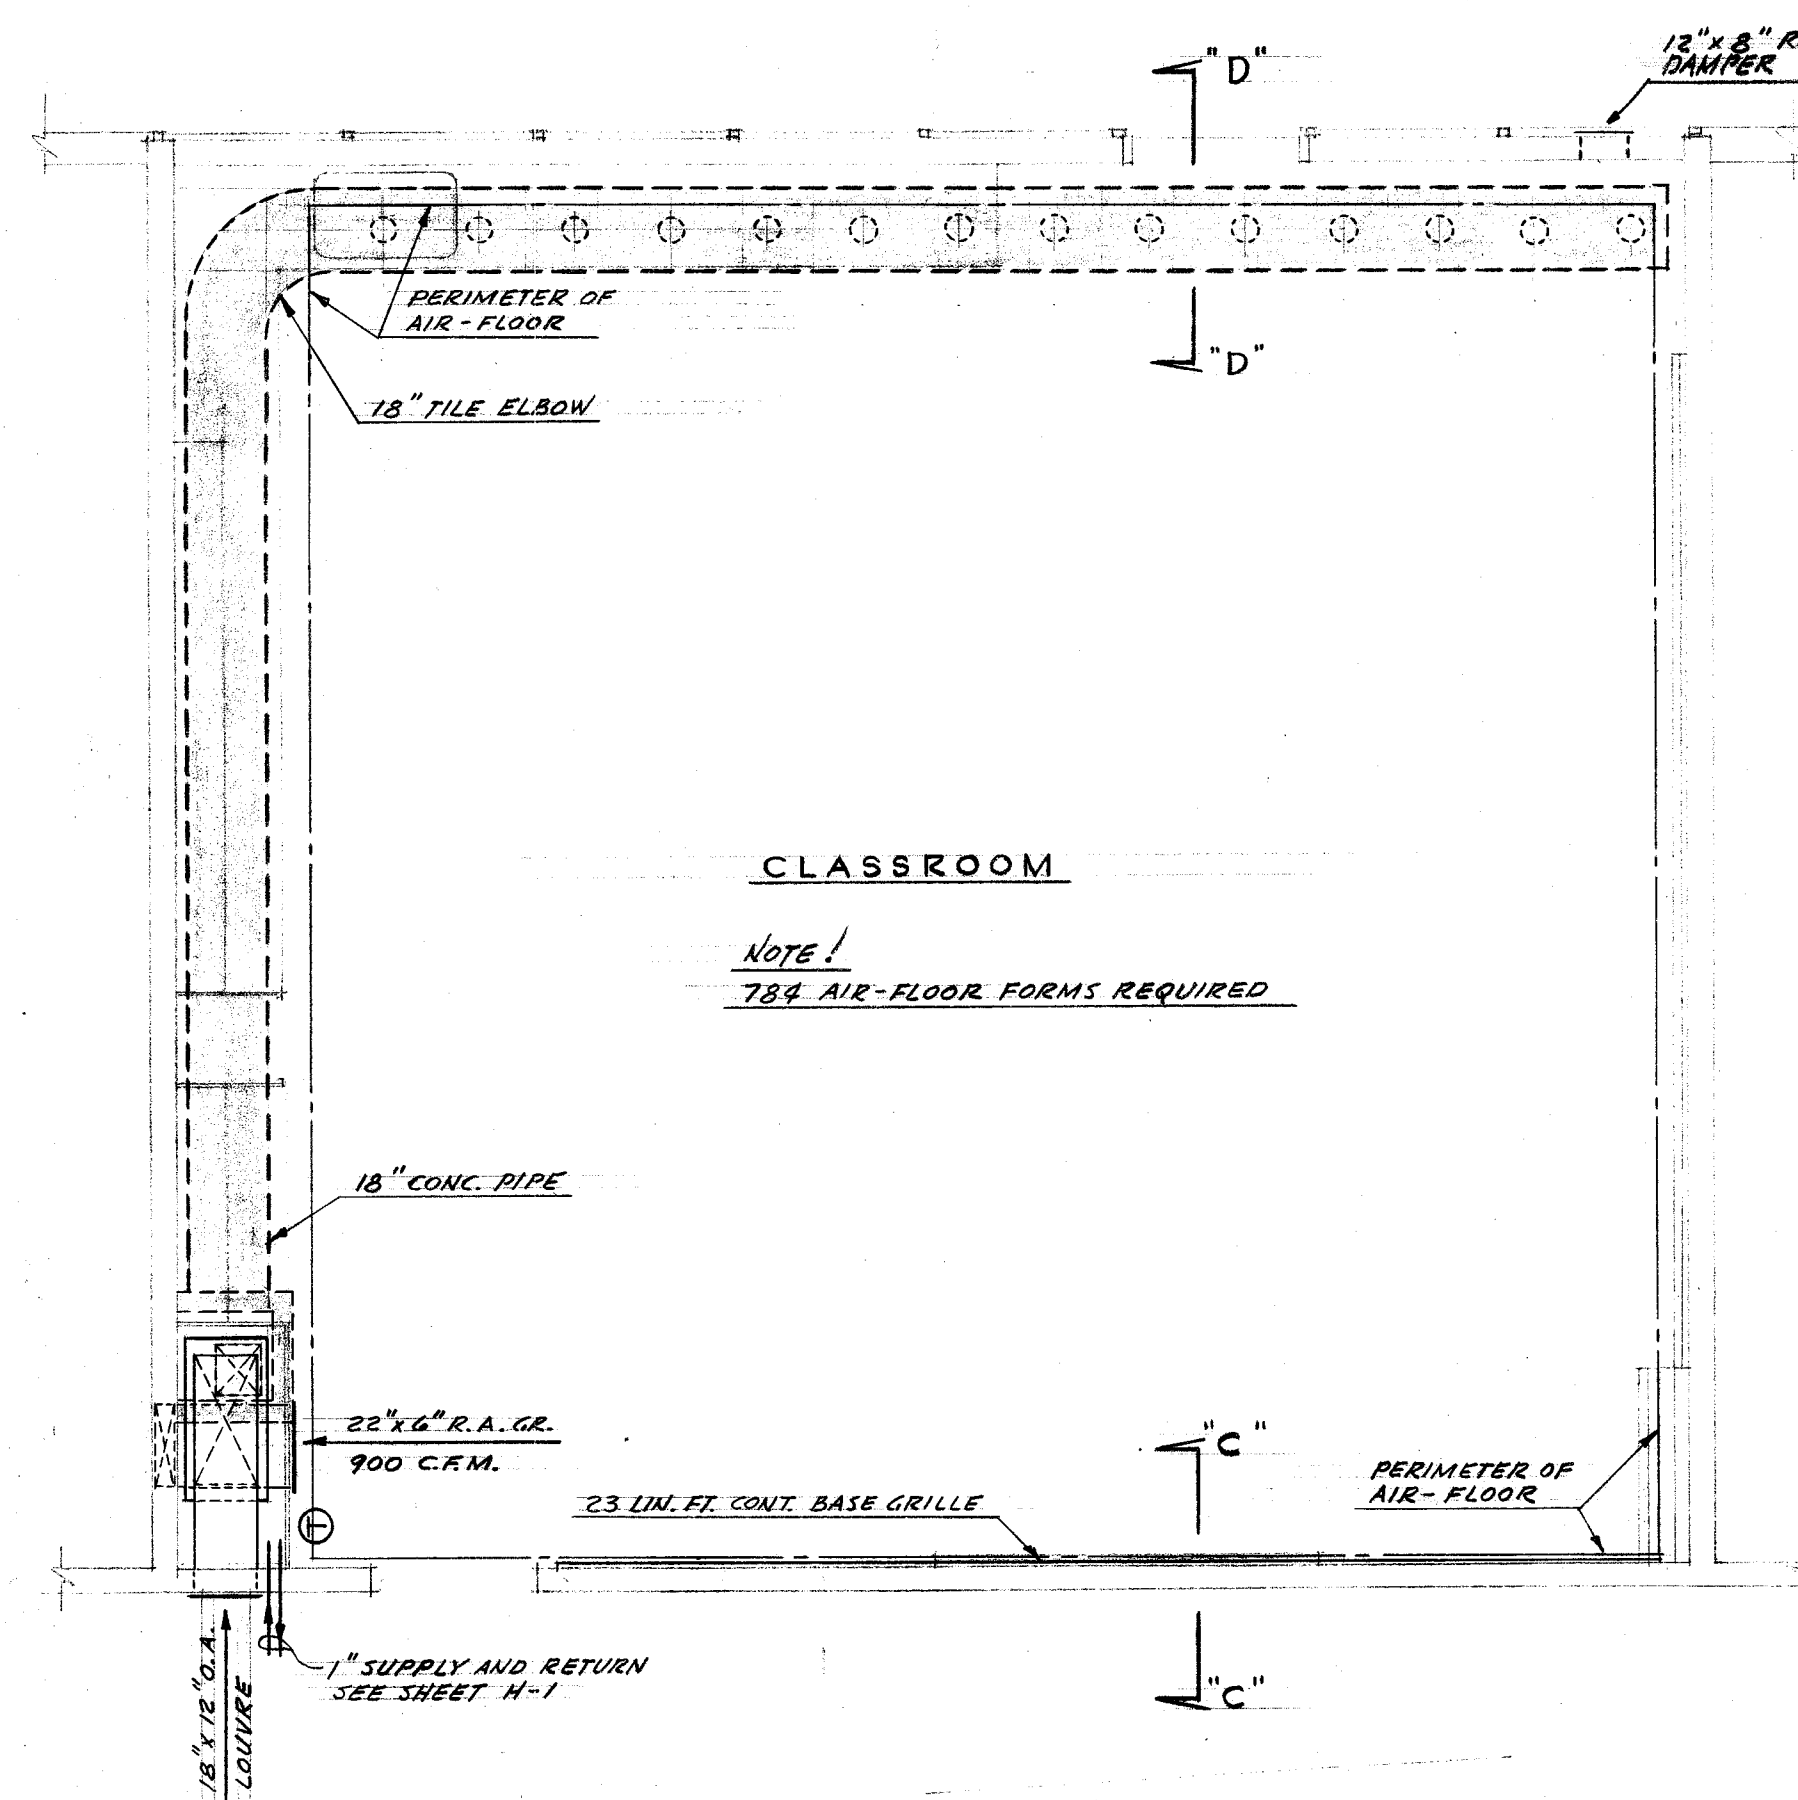


TYPICAL PLAN-PRIMARY GRADES
SCALE 1/4" = 1'-0"

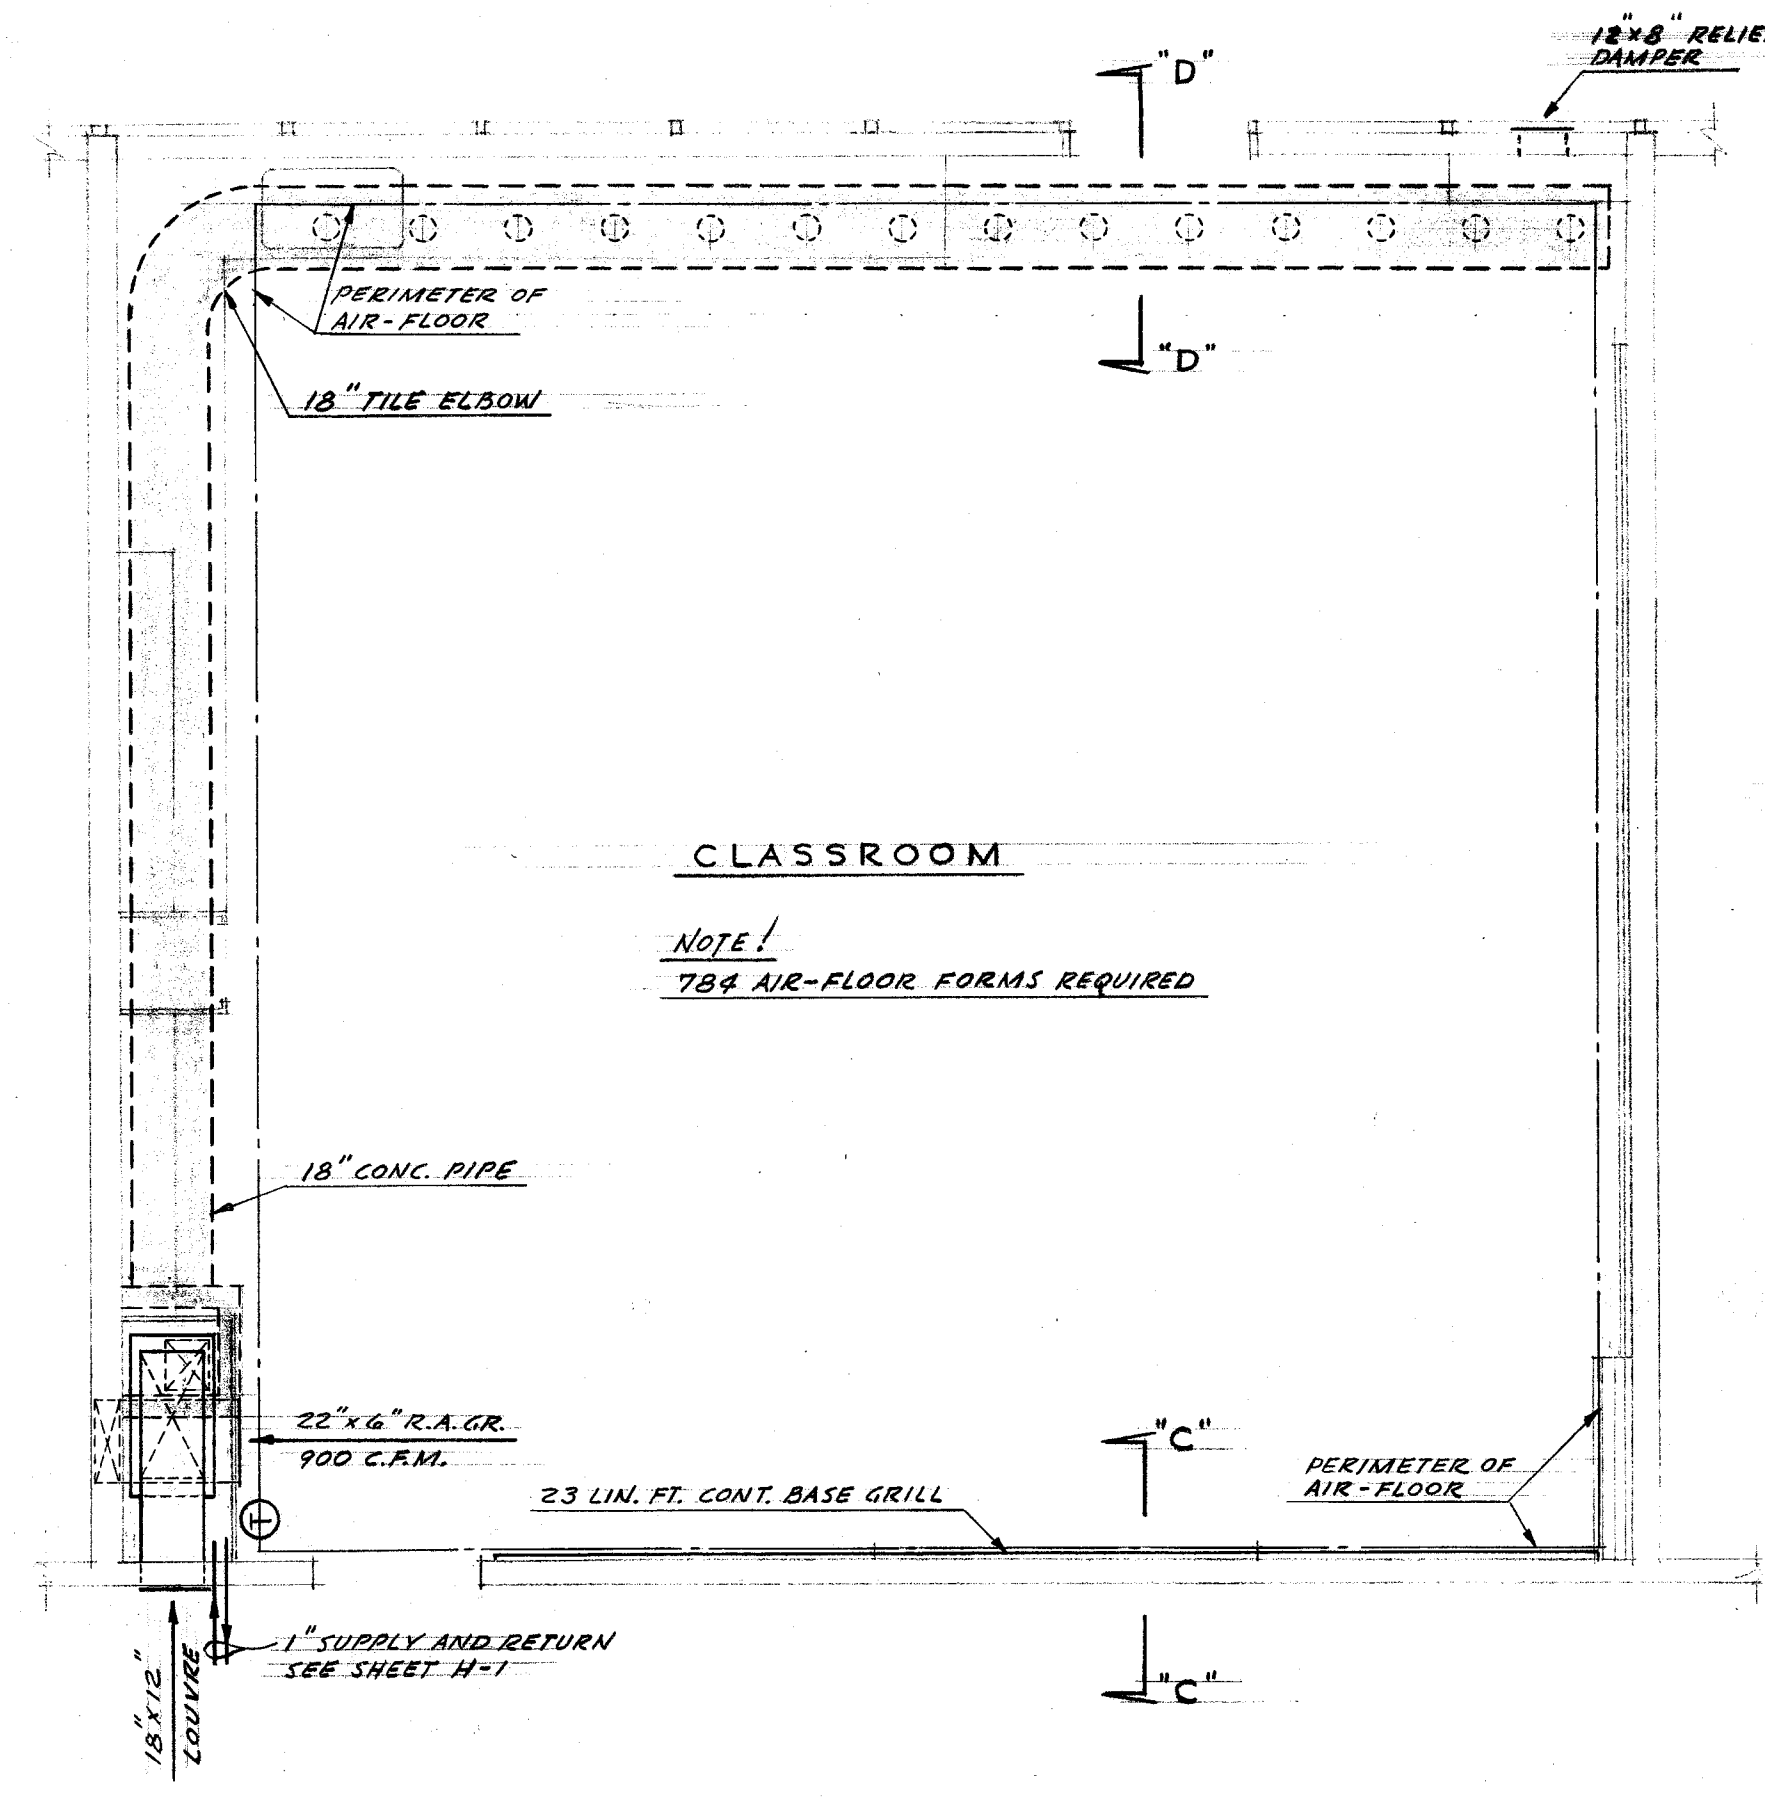

TYPICAL PLAN-INTERMEDIATE GRADES
SCALE 1/4" = 1'-0"

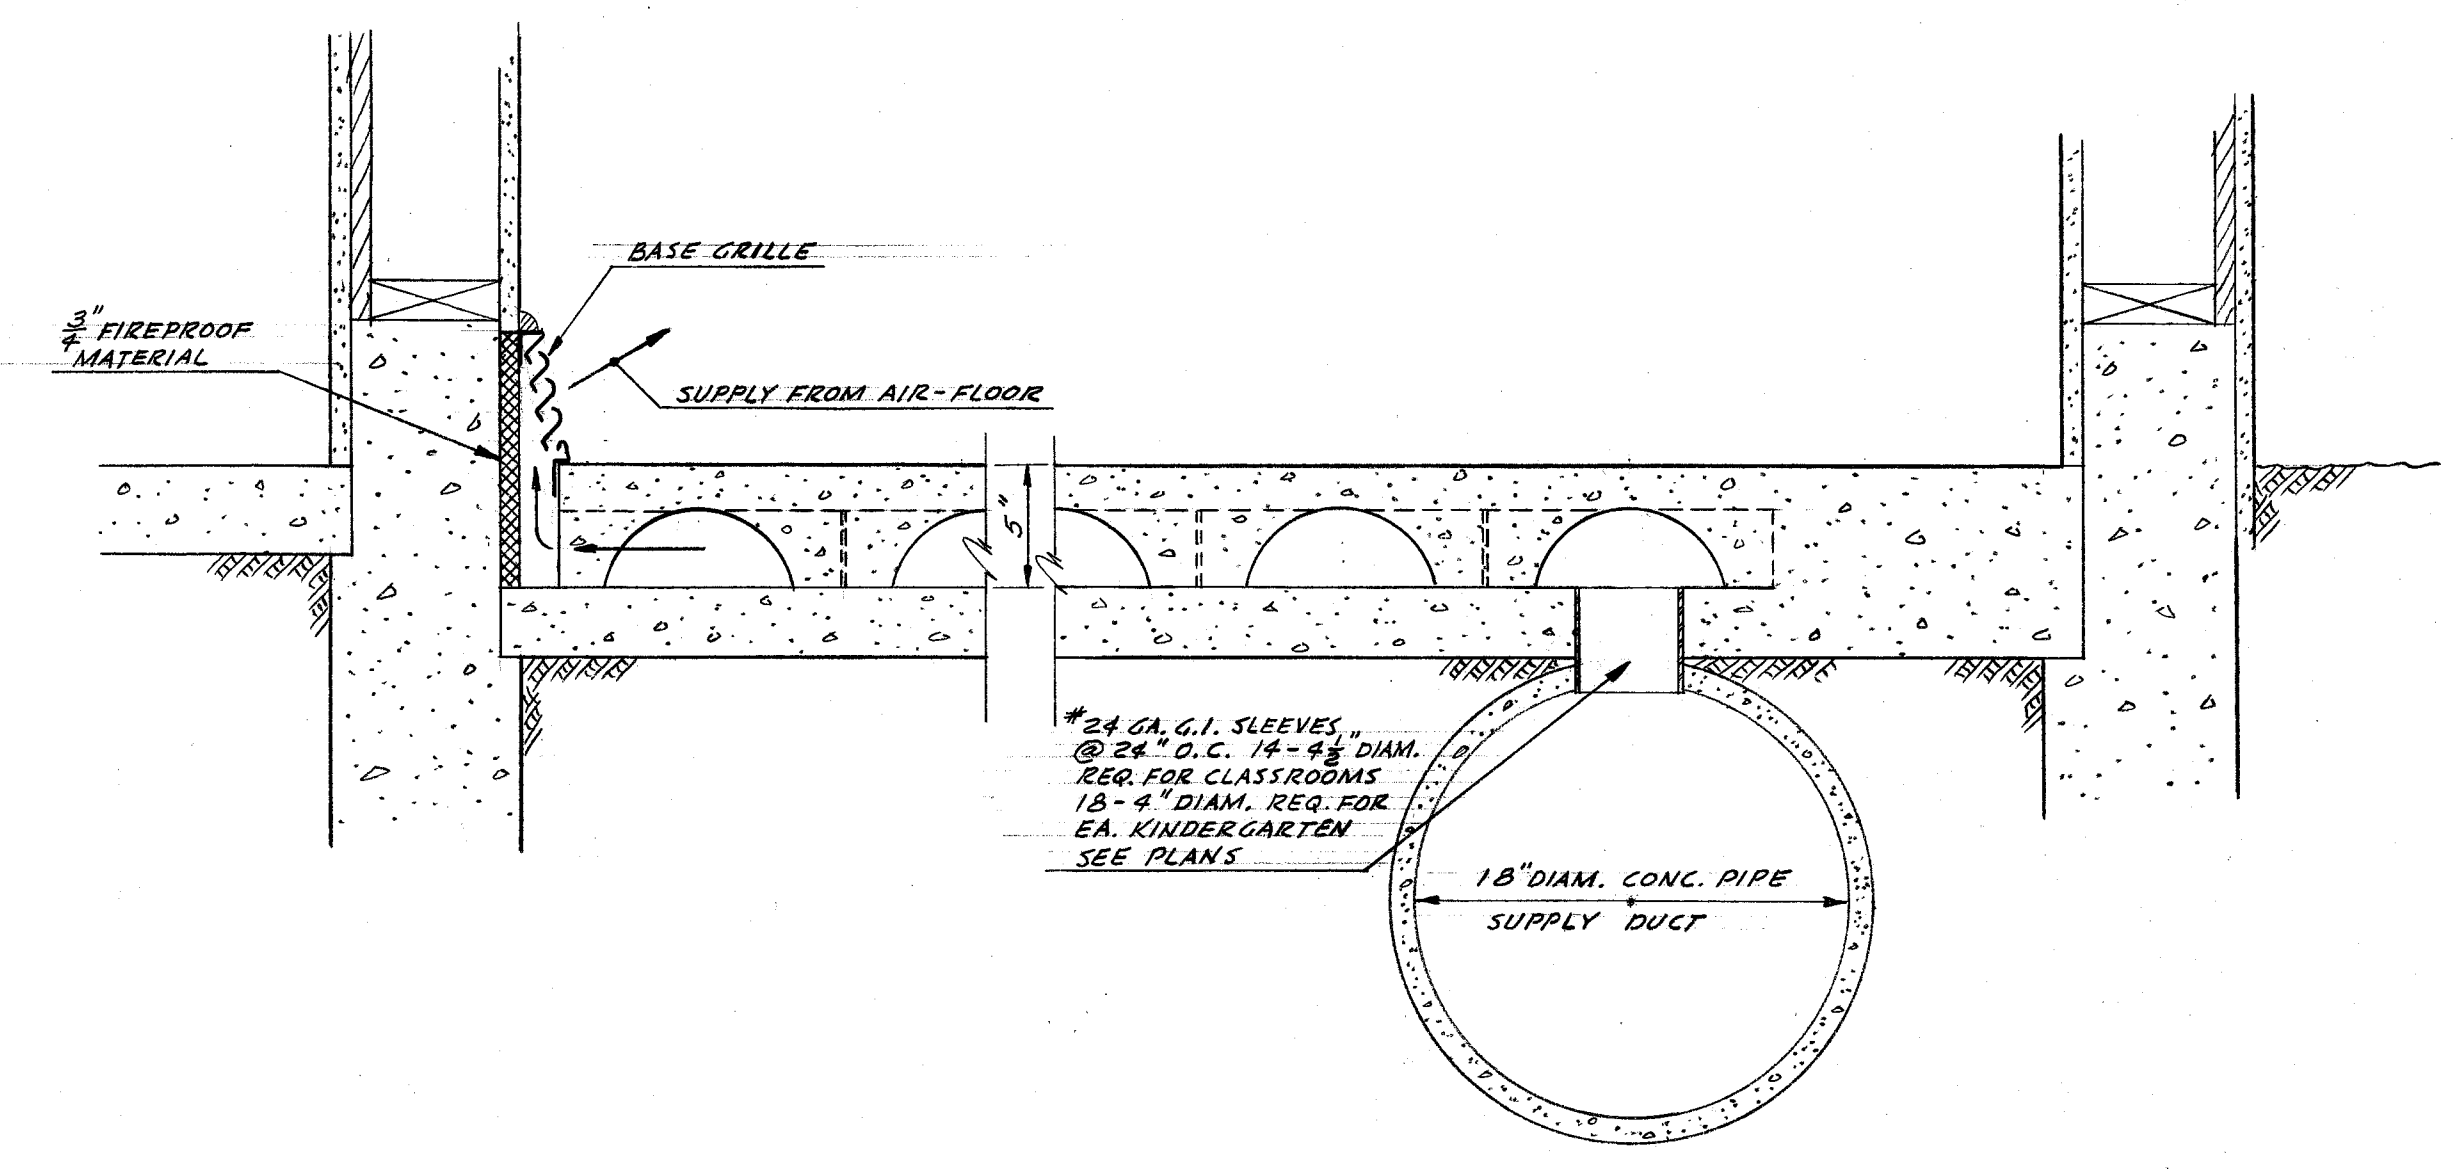

SECTION - "C" - "C"
SECTION - "D" - "D"
SCALE 1/2" = 1'-0"

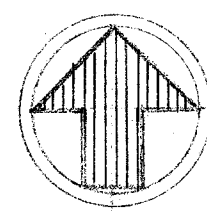

DIVISION OF ARCHITECTURE
STATE OF CALIFORNIA - DEPARTMENT OF PUBLIC WORKS
OFFICE OF ARCHITECTURE
11305 APPROVED OCT - 7 1953
W.A. Stains

W. A. STAINS
CONSULTING ENGINEER
1603 CALIFORNIA AVENUE
BAKERSFIELD, CALIFORNIA
MECHANICAL 5305 ELECTRICAL 4205

BOARD OF EDUCATION
PRES. Virginia C. Bellinger
SEC.

HEATING & VENTILATING
FLOOR PLAN - CLASSROOMS
UNITS-THREE, FOUR & FIVE
REAL ROAD SCHOOL
BAKERSFIELD CALIFORNIA

Whitney Biggar
WHITNEY BIGGAR ARCHITECT
MEMBER AMERICAN INSTITUTE OF ARCHITECTS
3601 STOCKDALE HIGHWAY
BAKERSFIELD, CALIFORNIA
29285 REGISTRATION C-1128

PROJECT NO: 6-53
DRAWN BY:
CHECKED BY:
DATE: 9/4/53
SHEET M-12
OF 56