

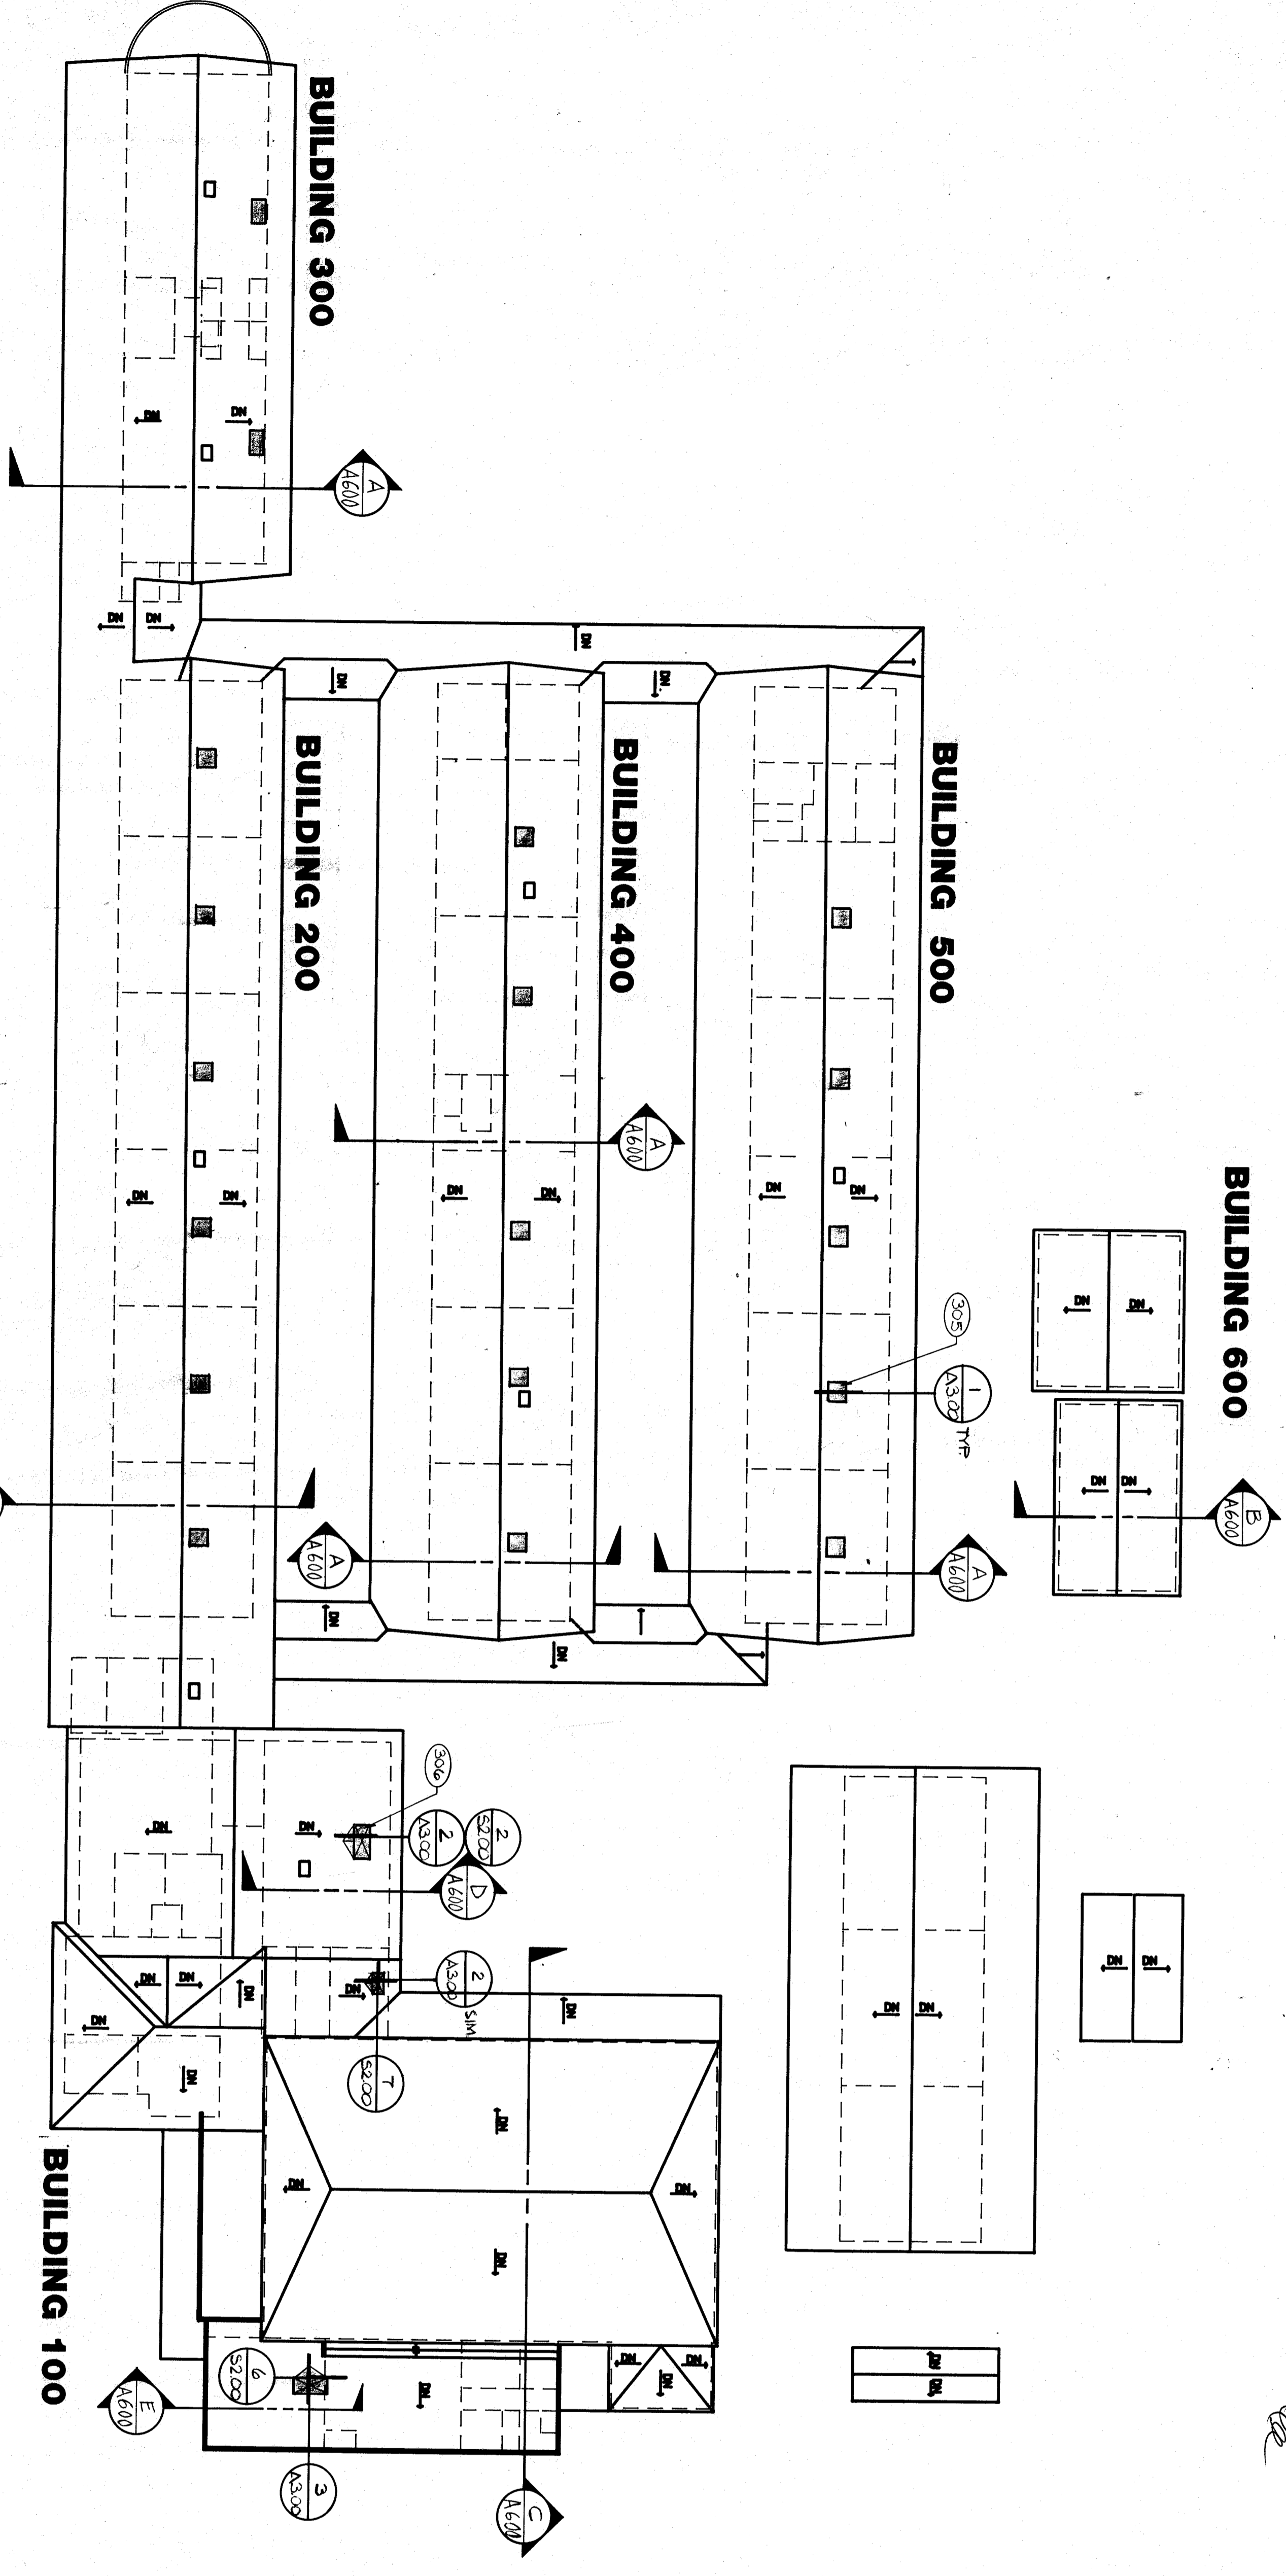
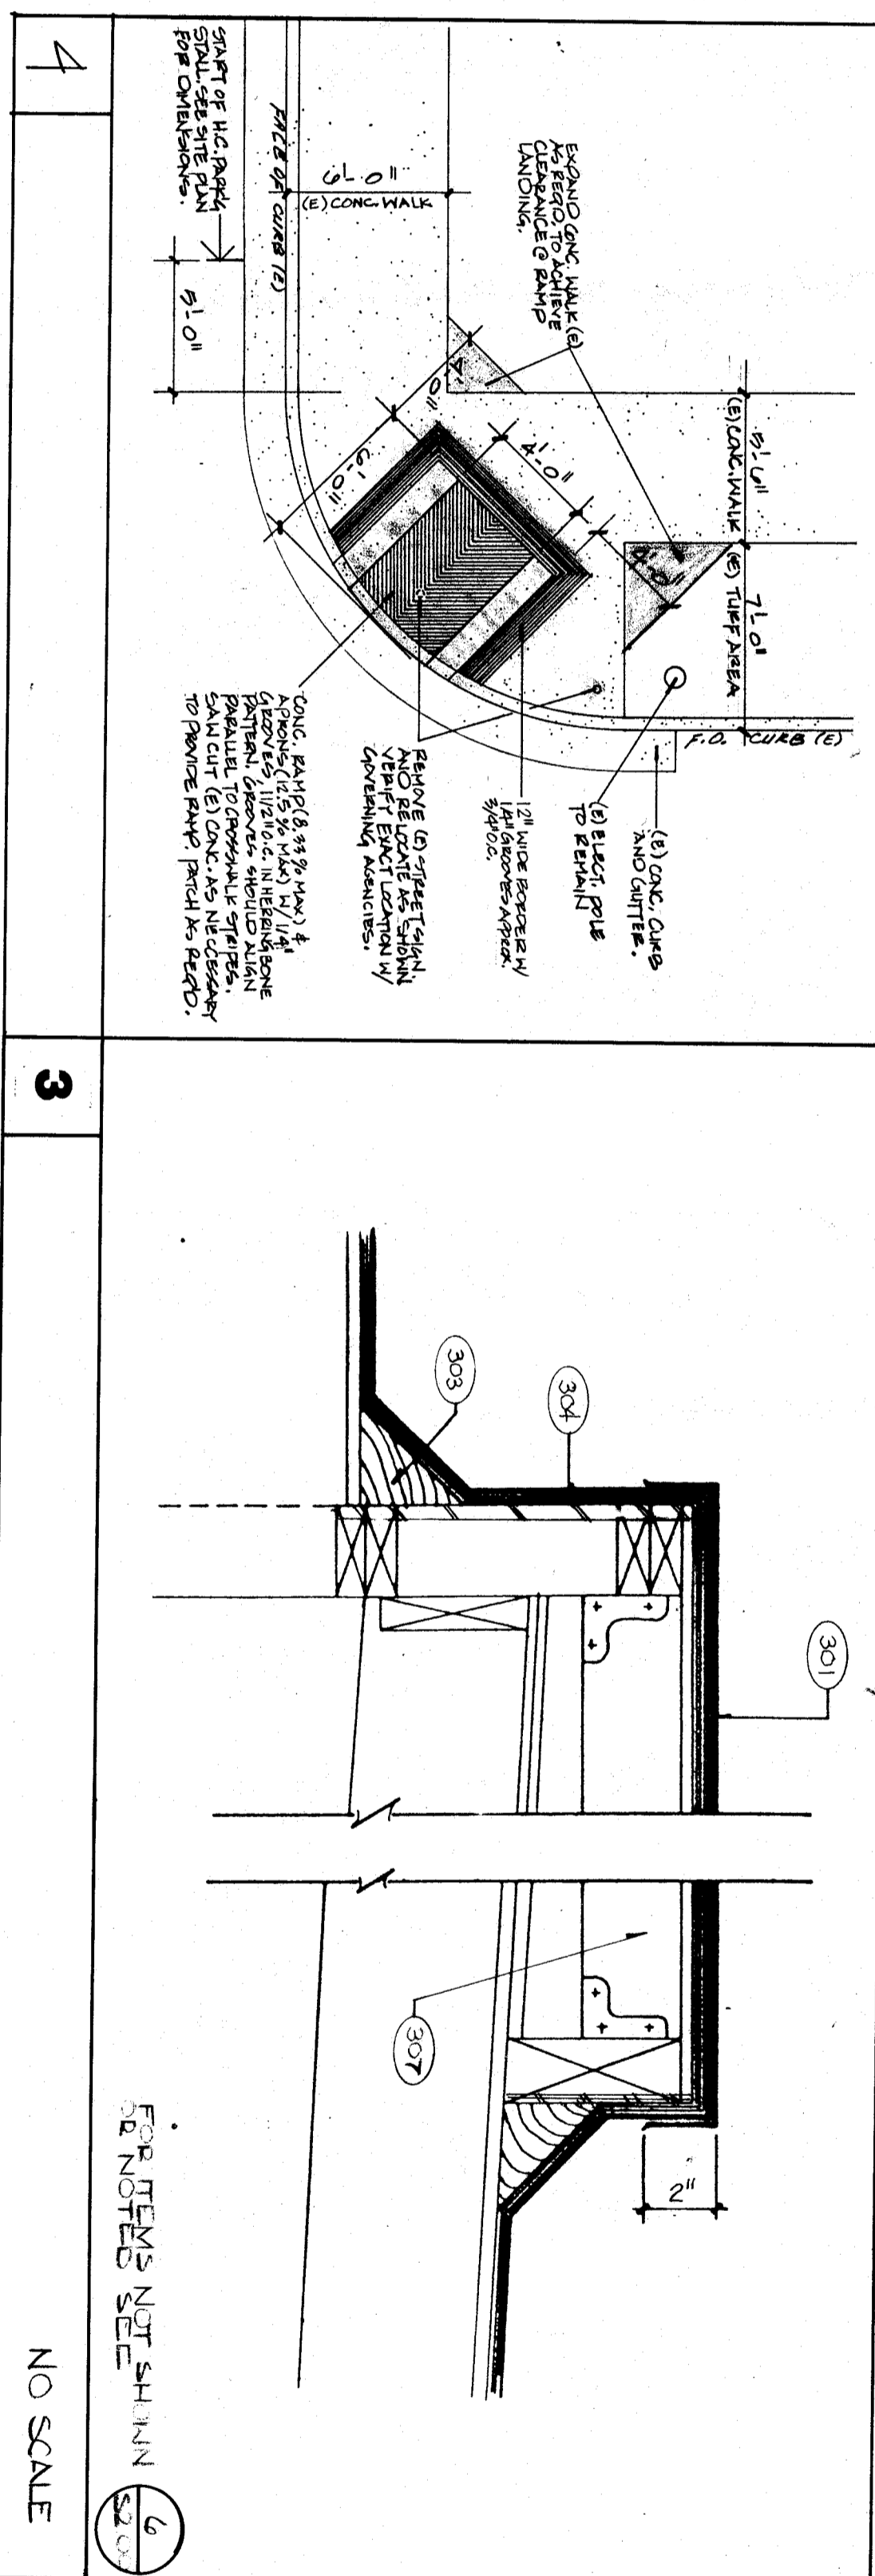


- KEY NOTES**
- 301 SHEET METAL GAB FLASHING
 - 302 SHUT UP ROOFING
 - 303 GABT STRIP
 - 304 SHEET METAL FLASHING OVER PLYWOOD
 - 305 REMOVE (E) MECHANICAL UNIT ON ROOF CAP LINES PER MECHANICAL DRAWINGS INTILL (E) TOP OF TD
 - 306 SEE MECHANICAL DRAWINGS UNIT ON CURB FOR STRUCURAL DRAWINGS
 - 307 FOR INFORMATION ON CONSTRUCTION MEMBERS SEE STRUCTURAL DRAWINGS

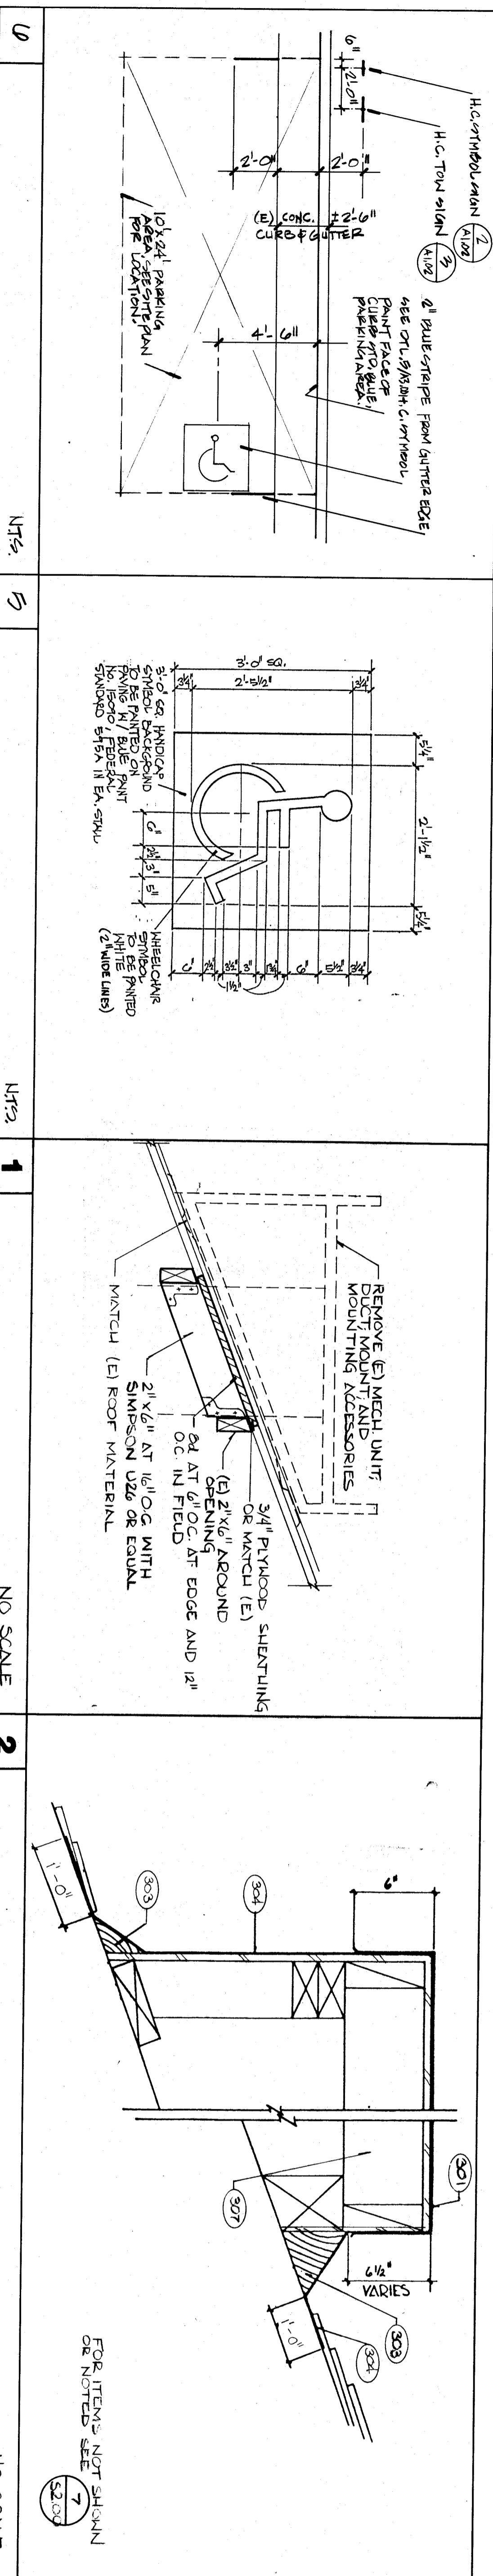

ROOF PLAN

1" = 20'

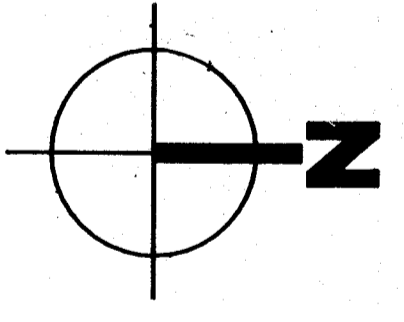

Job no. 88-142
 date 20 JAN 1989
 drawn by T. WARREN
 checked by SCOTT
 copyright 1989

bfgc architects planners inc.
 P.O. Box 8988 Bakersfield California 93398-8988
 31 south real road 93309 (805) 832 8122

DR. GENTH

C-3132 *C-8564 C-8021 C-8702

ROOSEVELT SCHOOL MODERNIZATION

FOR
 BAKERSFIELD CITY SCHOOL DISTRICT

ROOF PLAN DETAILS

