


PLUMBING PLAN - DEMO
BLDG-C, ROOM 108 - BOYS
BLDG-C, ROOM 109 - GIRLS



A

SCALE: 1/4"=1'-0"

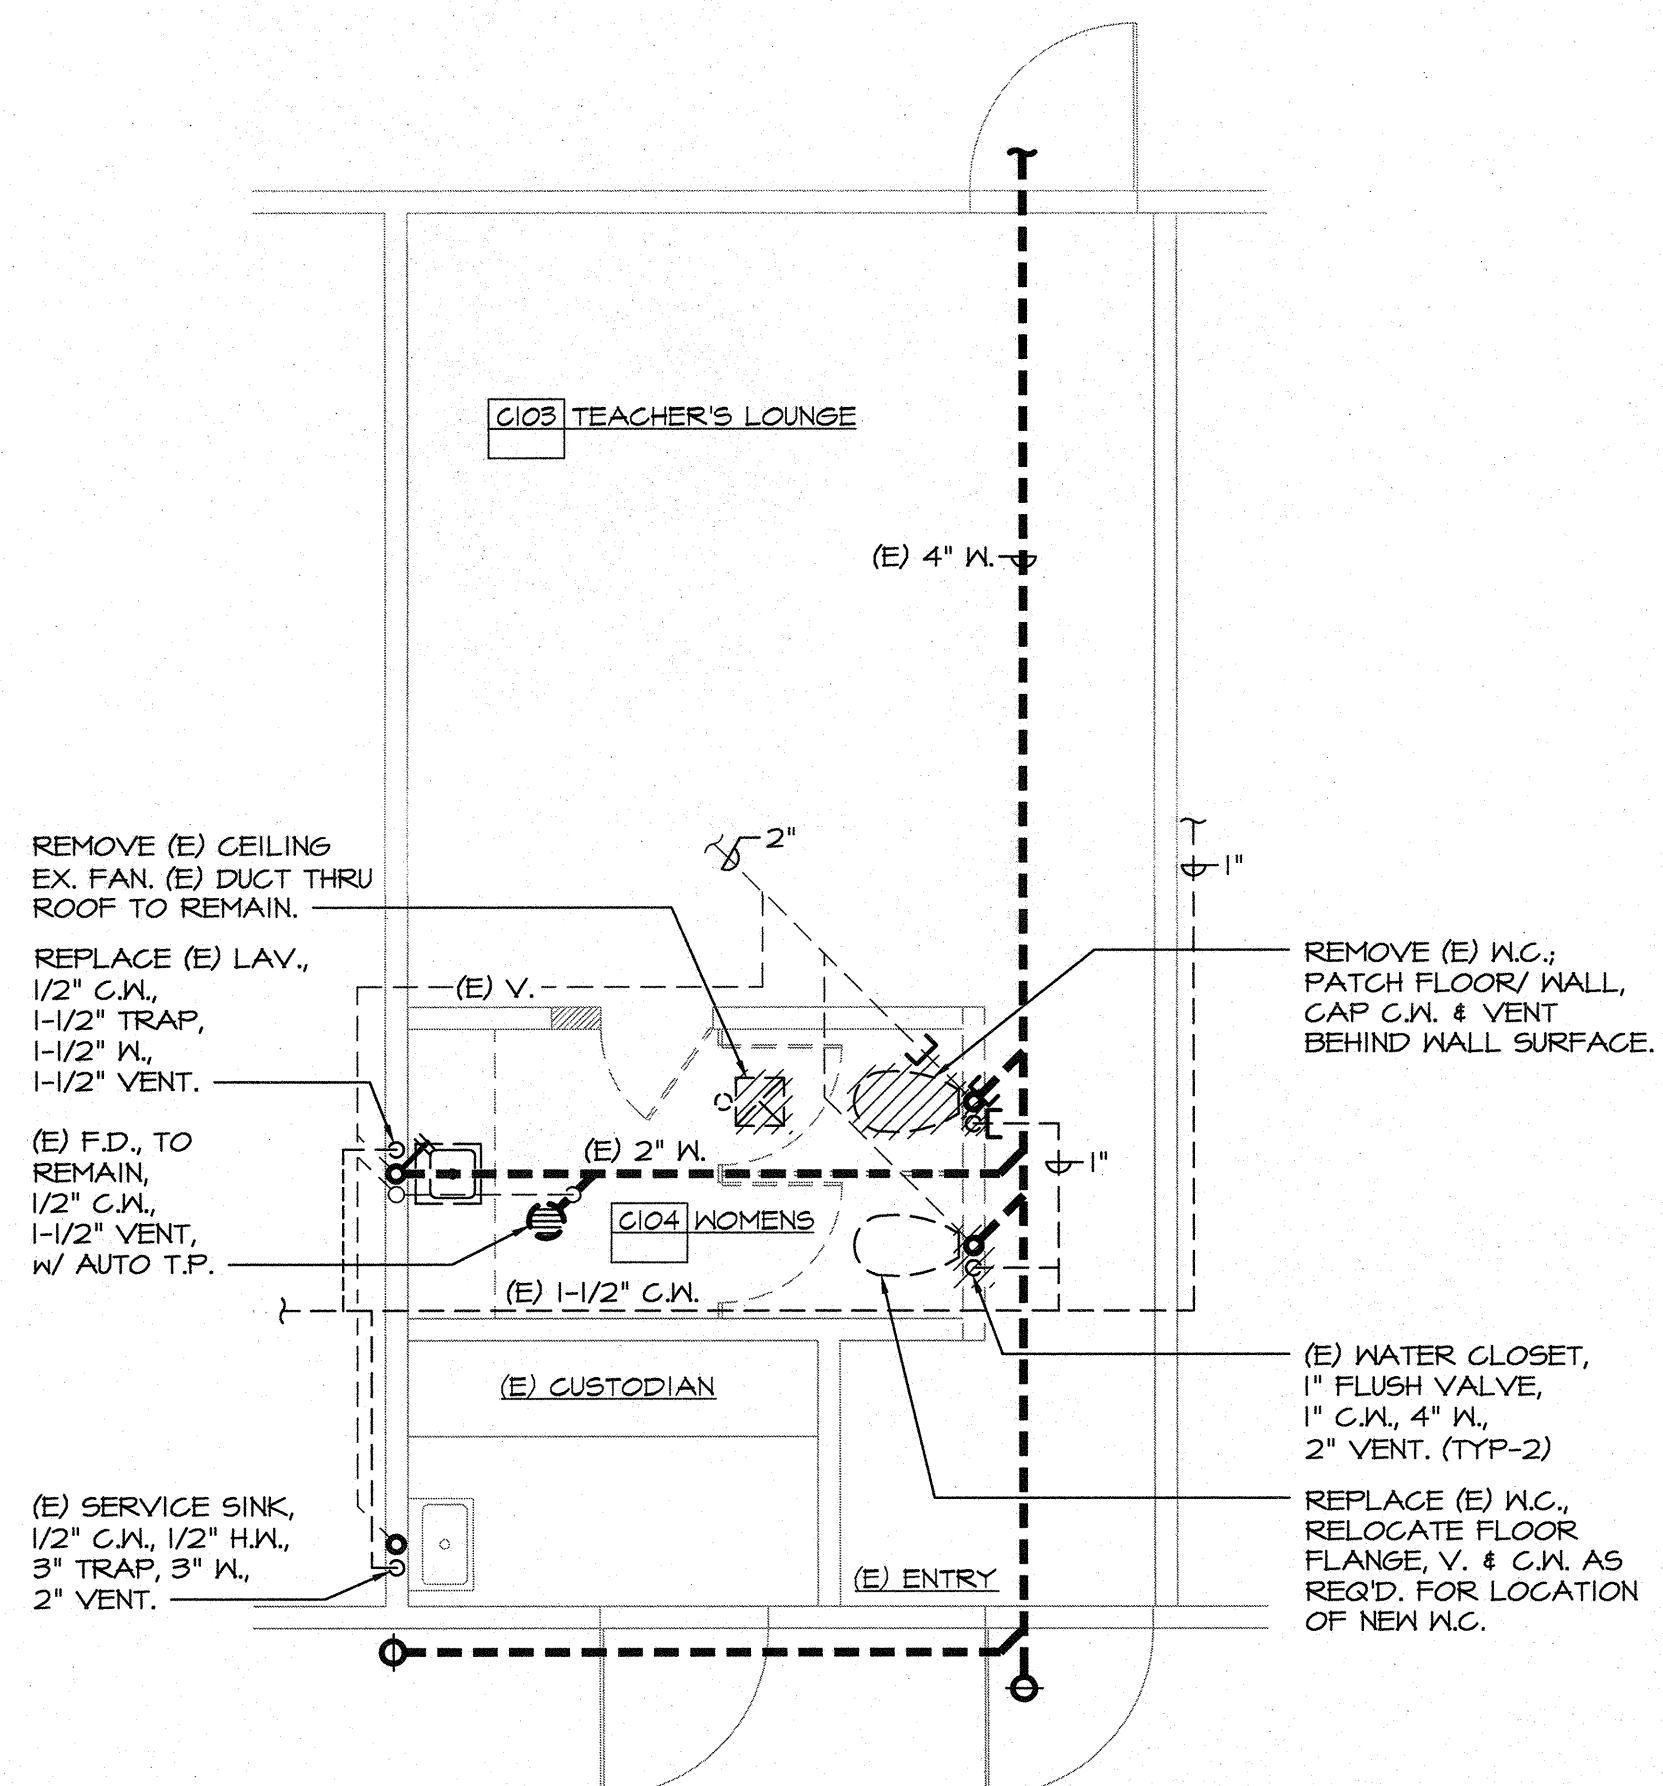


MECHANICAL/PLUMBING PLAN - DEMO
BLDG-C, ROOM 103 - WOMEN



B

SCALE: 1/4"=1'-0"

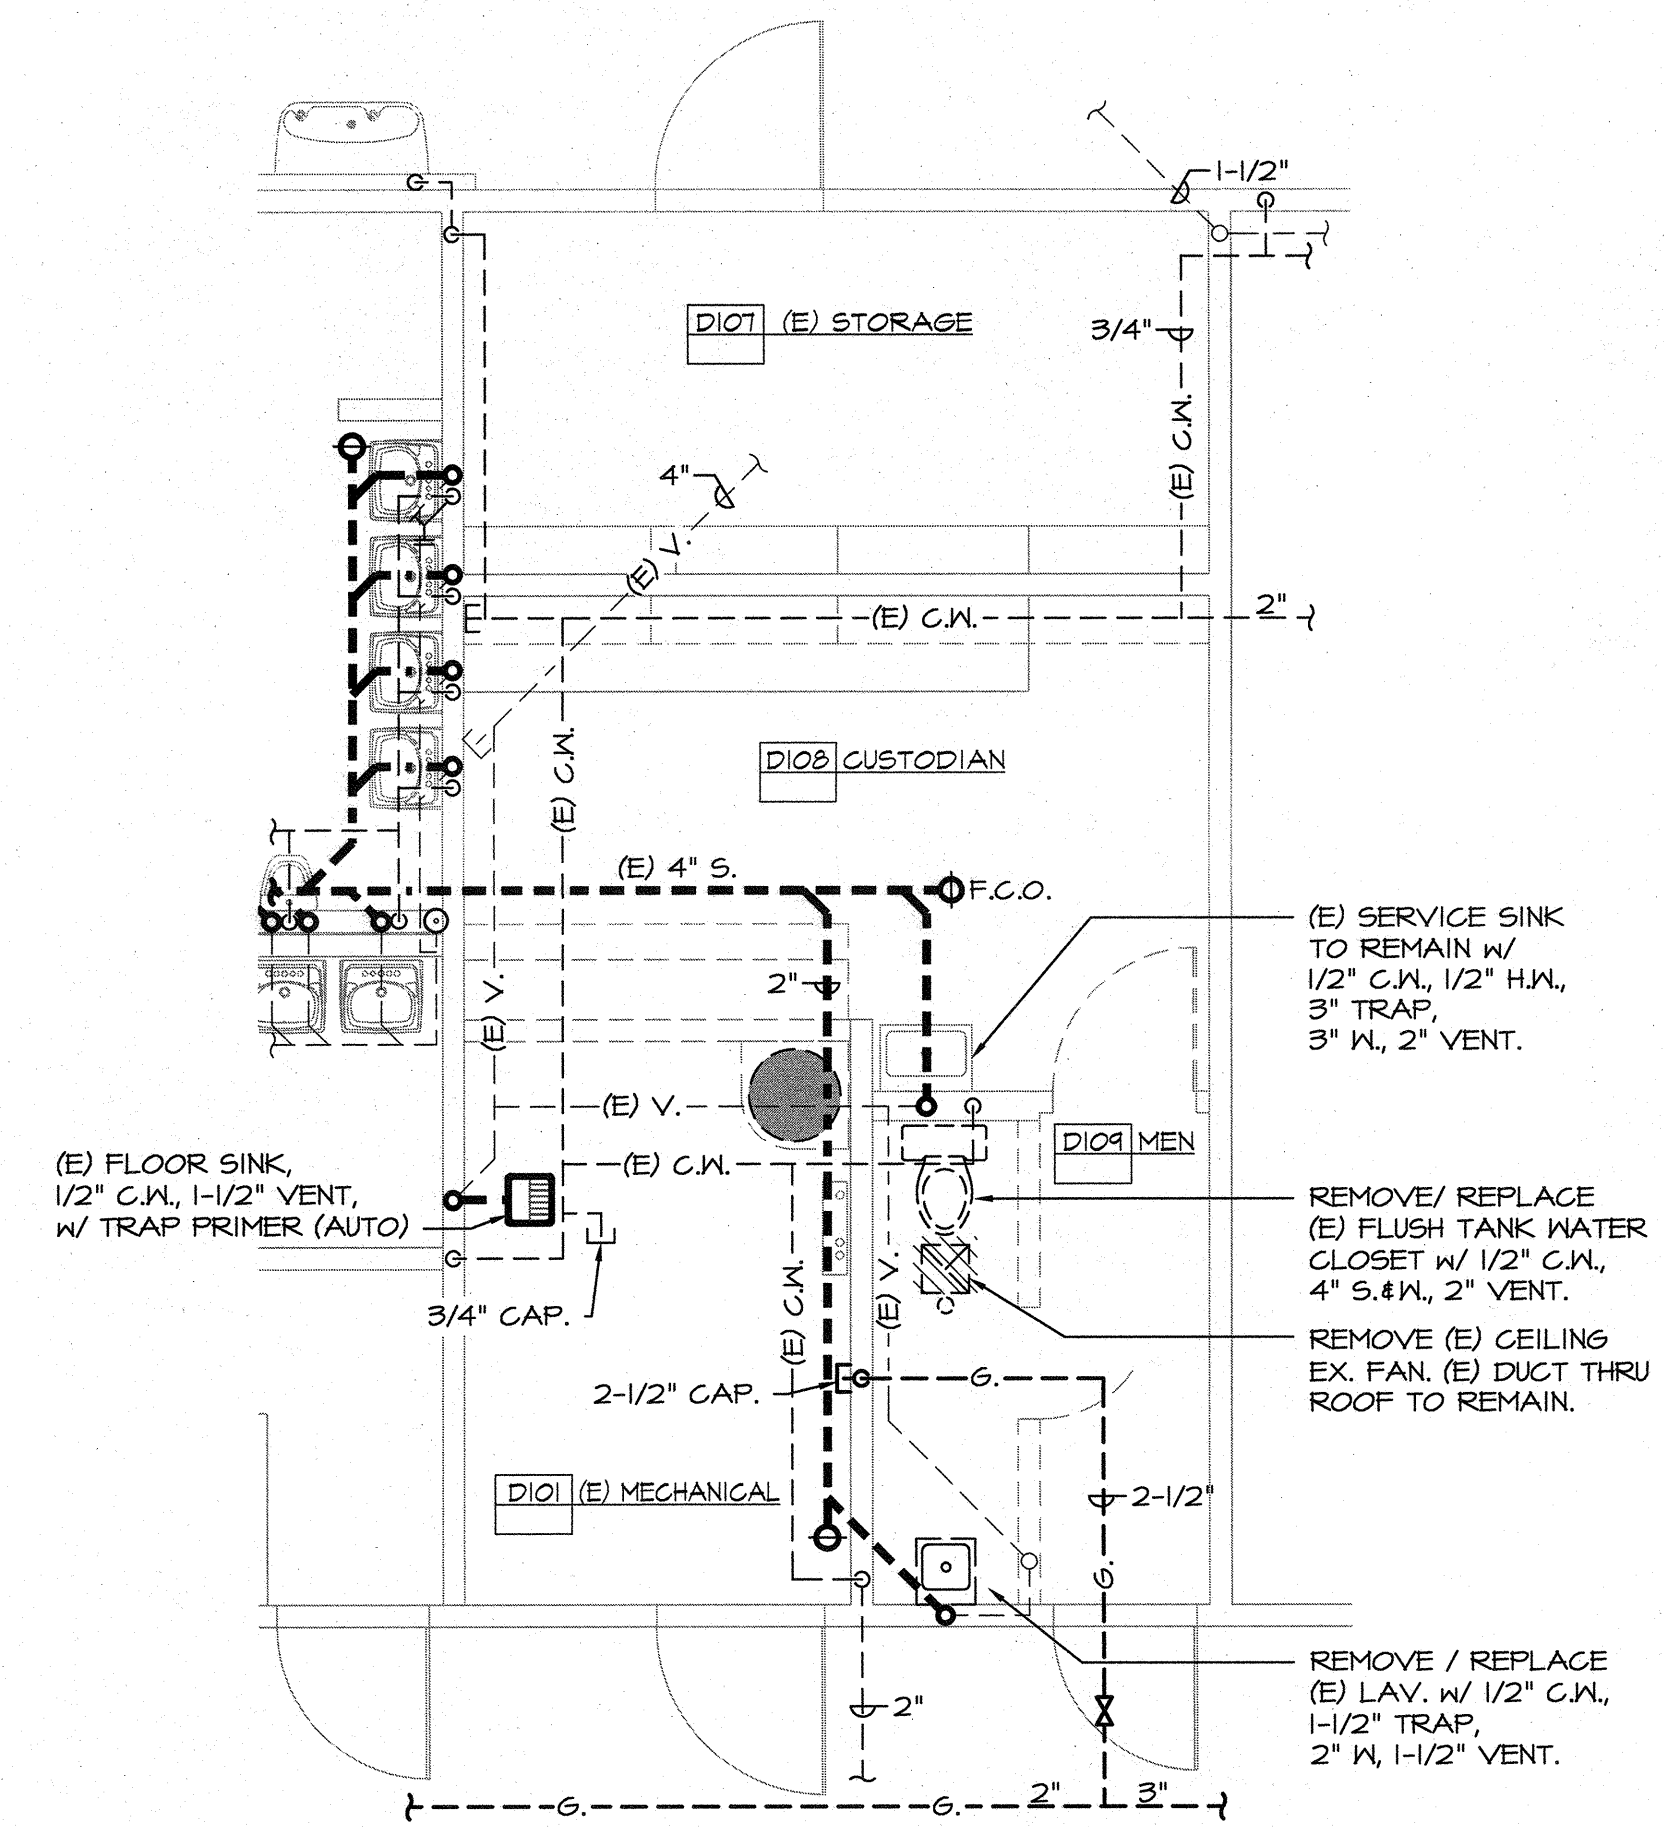


MECHANICAL/PLUMBING PLAN - DEMO
BLDG-D, ROOM 104 - MEN



C

SCALE: 1/4"=1'-0"

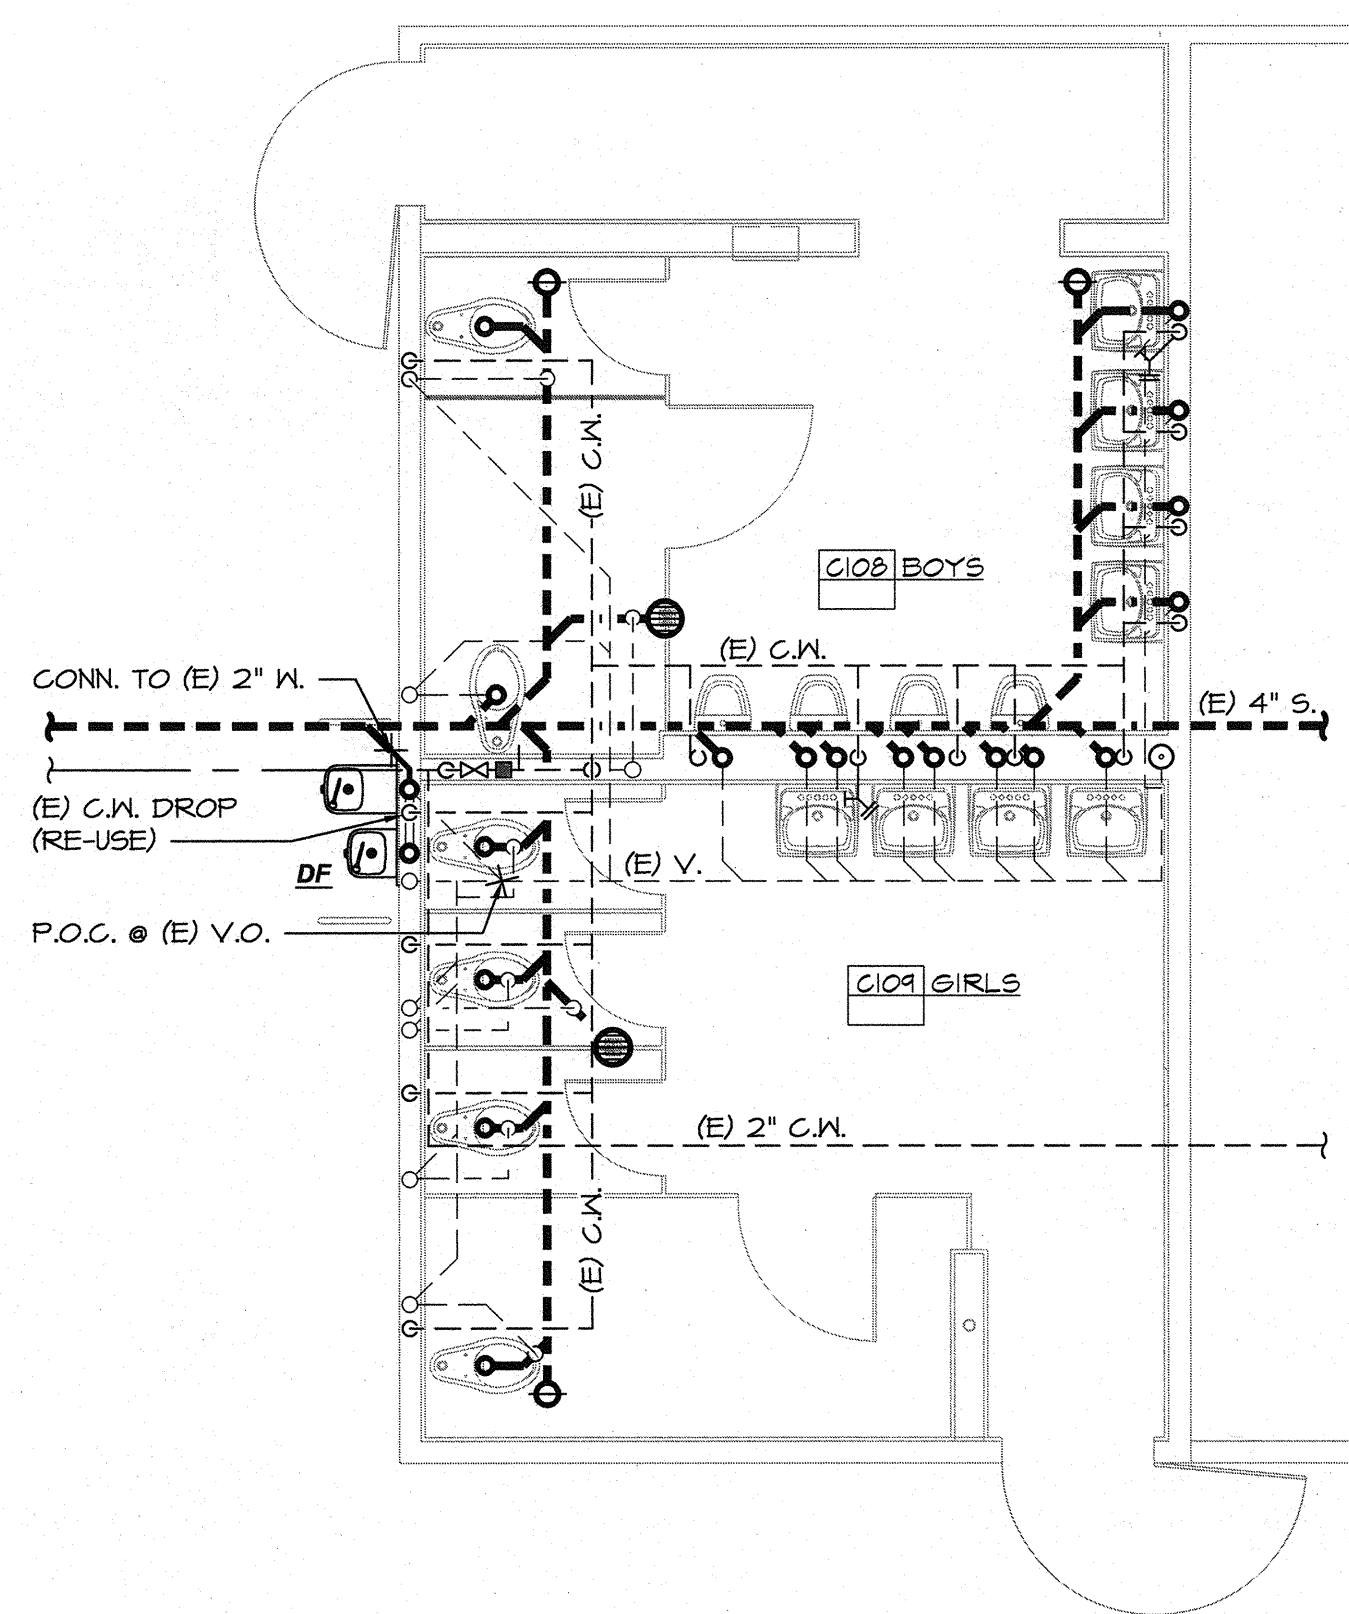


PLUMBING PLAN - REMODEL
BLDG-C, ROOM 108 - BOYS
BLDG-C, ROOM 109 - GIRLS



D

SCALE: 1/4"=1'-0"

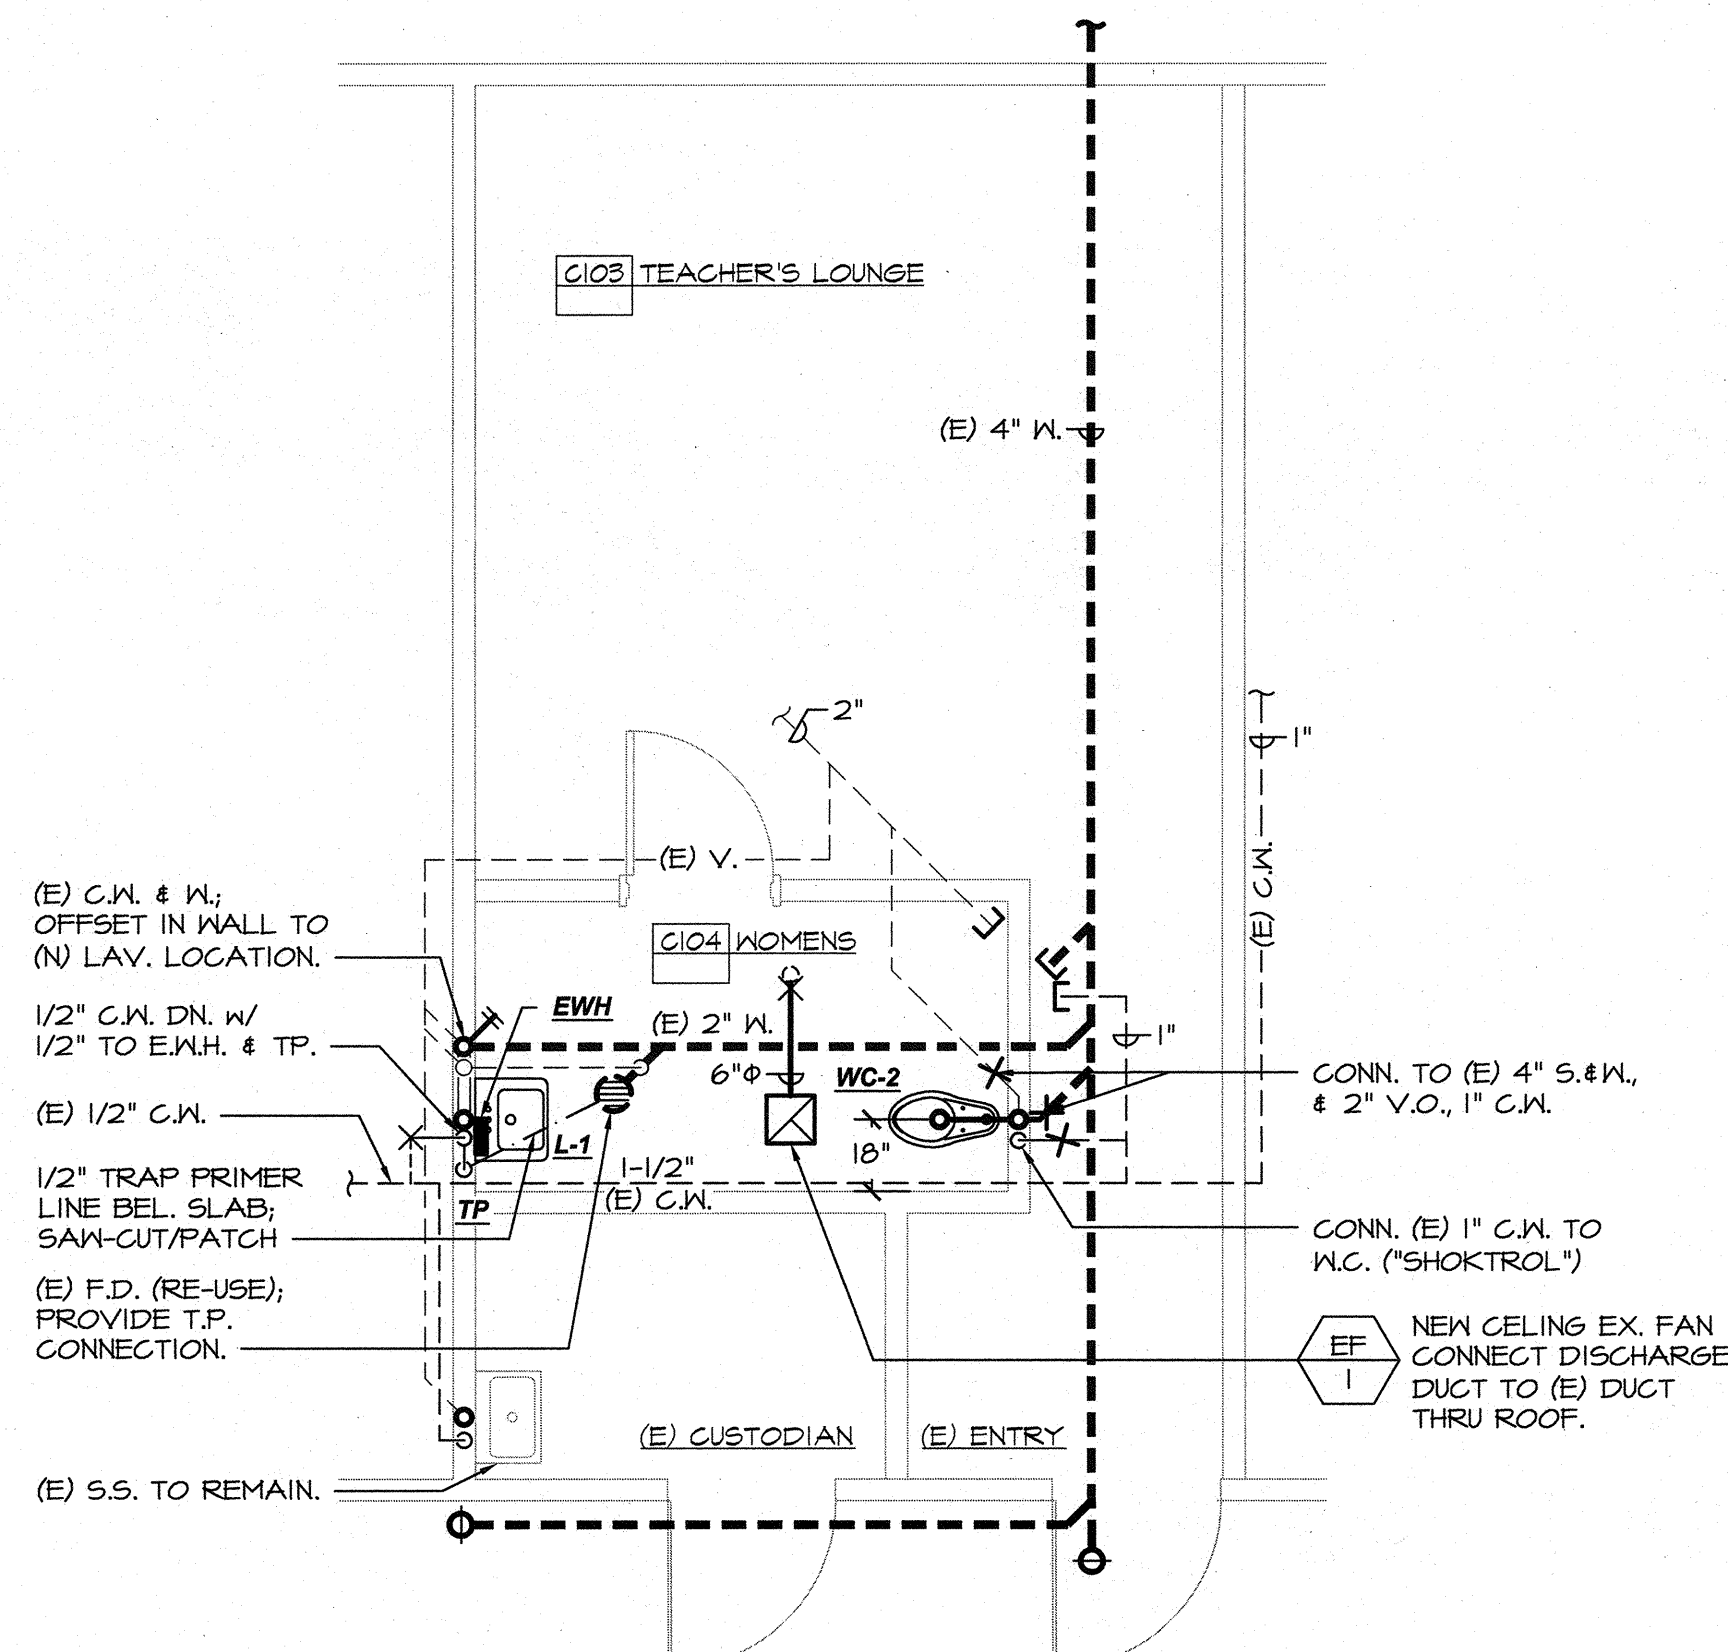


MECHANICAL/PLUMBING PLAN - REMODEL
BLDG-C, ROOM 103 - WOMEN



E

SCALE: 1/4"=1'-0"

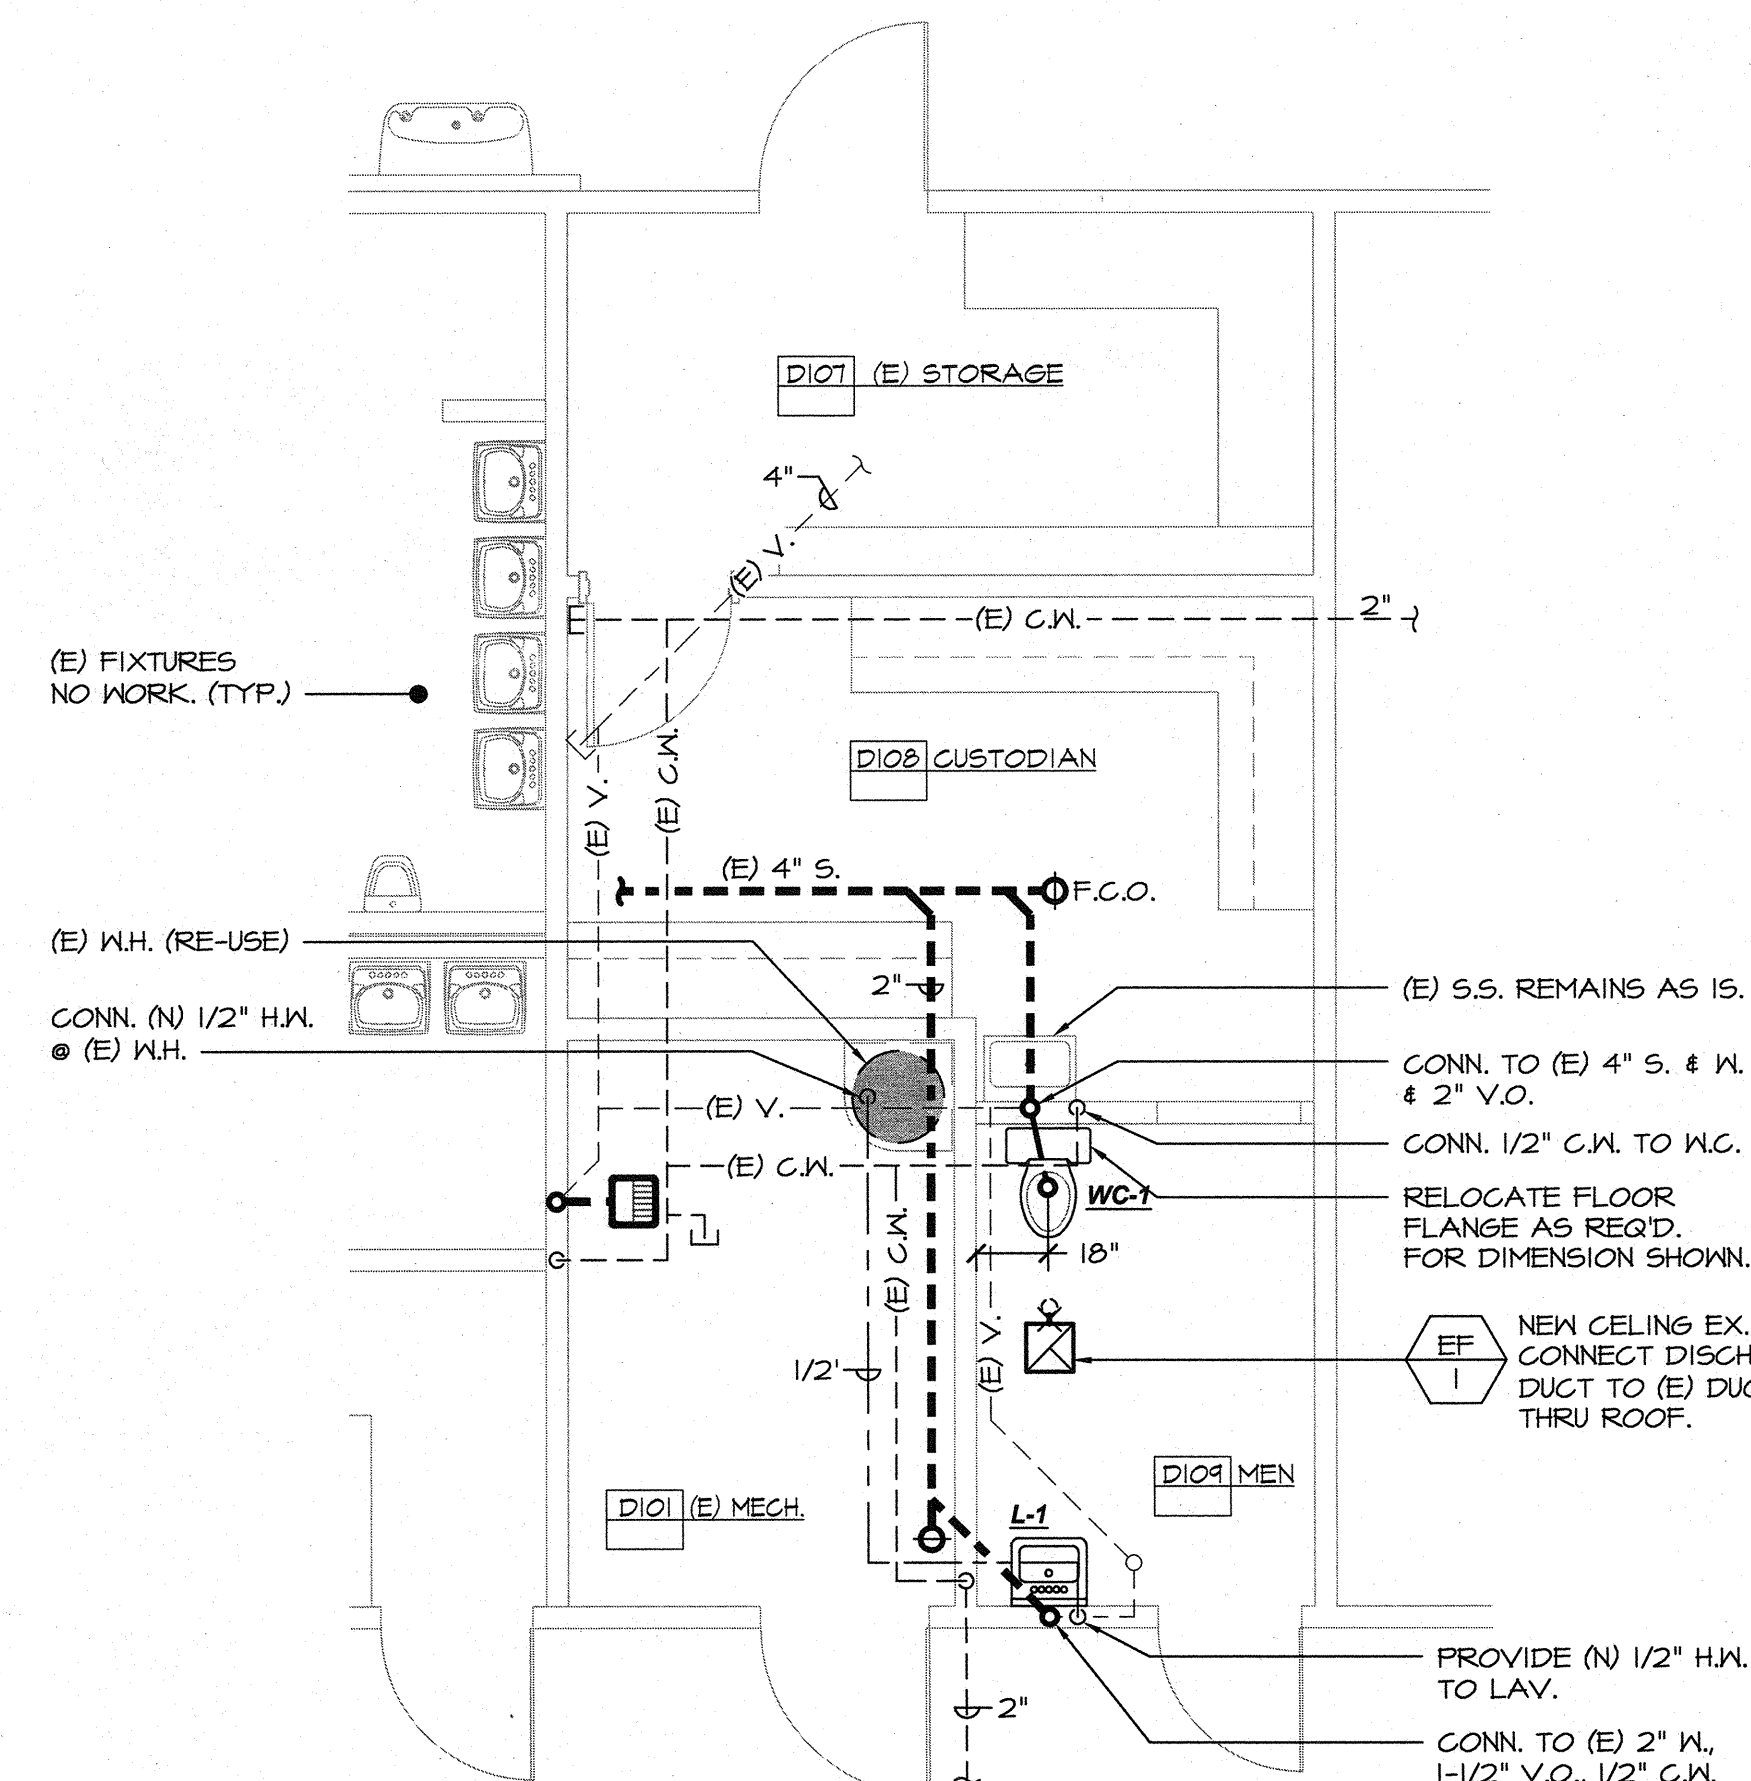

MECHANICAL/PLUMBING PLAN - REMODEL
BLDG-D, ROOM 104 - MEN



F

SCALE: 1/4"=1'-0"

MARK	DATE	REVISIONS
△		
△		
△		



CHECK AND VERIFY ALL DIMENSIONS BEFORE PROCEEDING WITH THE WORK. REPORT DISCREPANCIES TO THE ARCHITECT. ALL CONSTRUCTION SHALL CONFORM TO THE C.B.C.

ROOSEVELT ELEMENTARY SCHOOL
SITE IMPROVEMENTS FOR MODULAR CLASSROOMS
 2324 VERDE STREET, BAKERSFIELD, CALIFORNIA
 FOR
BAKERSFIELD CITY SCHOOL DISTRICT
 BAKERSFIELD, KERN COUNTY, CALIFORNIA, 93304

IDENTIFICATION STAMP DIV. OF THE STATE ARCHITECT OFFICE OF REGULATION SERVICES APR 03 11 07 77 FILE 15-6 AC WY PLS RY SS BY DATE 4/15/16 PTN: 000000-00
--



1601 NEW STINE ROAD, SUITE 280
 BAKERSFIELD, CA 93309
 PH: (661) 397-4377
 FAX: (661) 397-4378
 WWW.SCARCHITECT.COM

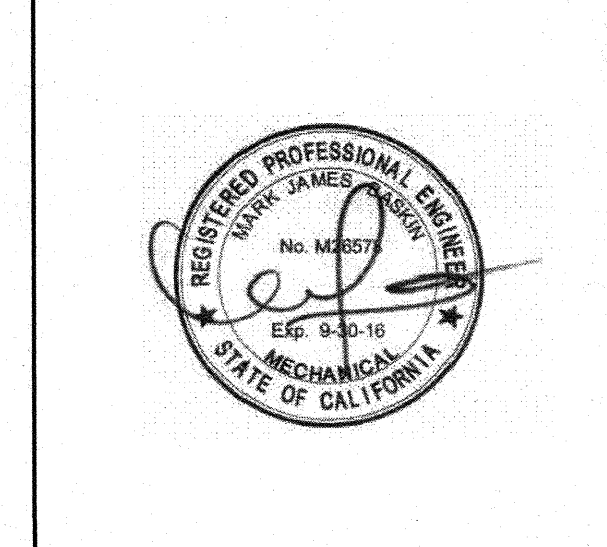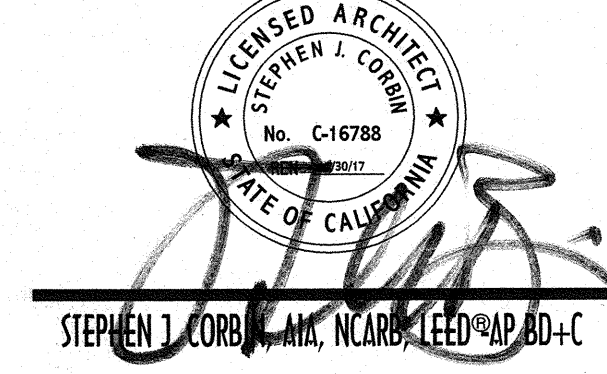

PLUMBING
DEMOLITION PLANS &
REMODEL PLANS

JOB NO. 1216	MP 2.0 OF SHEETS
DRAWN: A.V.	
CHECKED: R.B.	
DATE: 2-4-16	

bme BASKIN MECHANICAL ENGINEERS
 175 Fulton Street
 Fresno, CA 93721
 Tel: (559) 237-0376
 Job: 15125
 Plt: 4-6-16