


THE ABOVE DRAWING AND SPECIFICATIONS AND SHALL BE OBSERVED AND THE CONTRACTOR SHALL BE RESPONSIBLE FOR OBTAINING ALL NECESSARY PERMITS AND APPROVALS FROM THE AFFECTED AGENCIES AND AUTHORITIES. THE CONTRACTOR SHALL BE RESPONSIBLE FOR VERIFYING THE EXISTING CONDITIONS AND SHALL BE RESPONSIBLE FOR OBTAINING ALL NECESSARY PERMITS AND APPROVALS FROM THE AFFECTED AGENCIES AND AUTHORITIES. THE CONTRACTOR SHALL BE RESPONSIBLE FOR OBTAINING ALL NECESSARY PERMITS AND APPROVALS FROM THE AFFECTED AGENCIES AND AUTHORITIES.

KEY PLAN

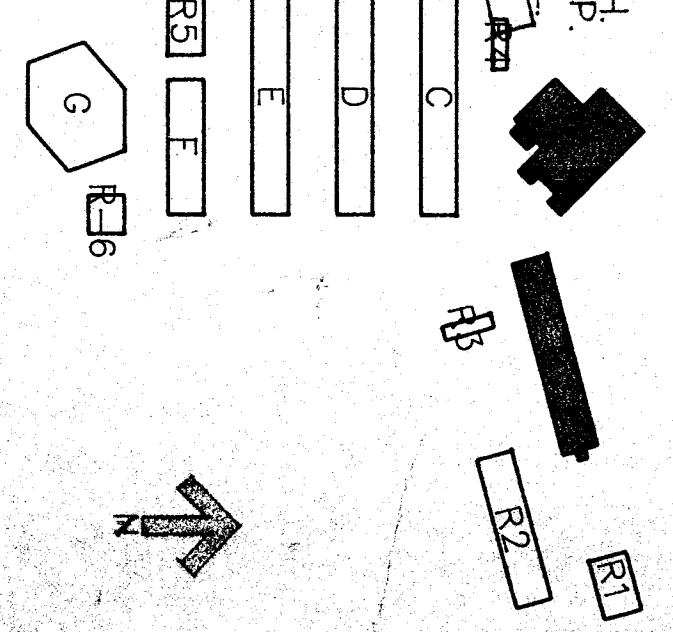


**BAKERSFIELD CITY SCHOOL DISTRICT
BOARD OF EDUCATION**

DATE	APPROVED
DATE	ISSUED FOR
DATE	REVISIONS

PLUMBING FLOOR PLANS


APPROVED ARCHITECT
DRAWN BY
CHECKED JFM
PROJECT NO. 96-287M

SHEET NUMBER **P-2**
OF 5 SHEETS

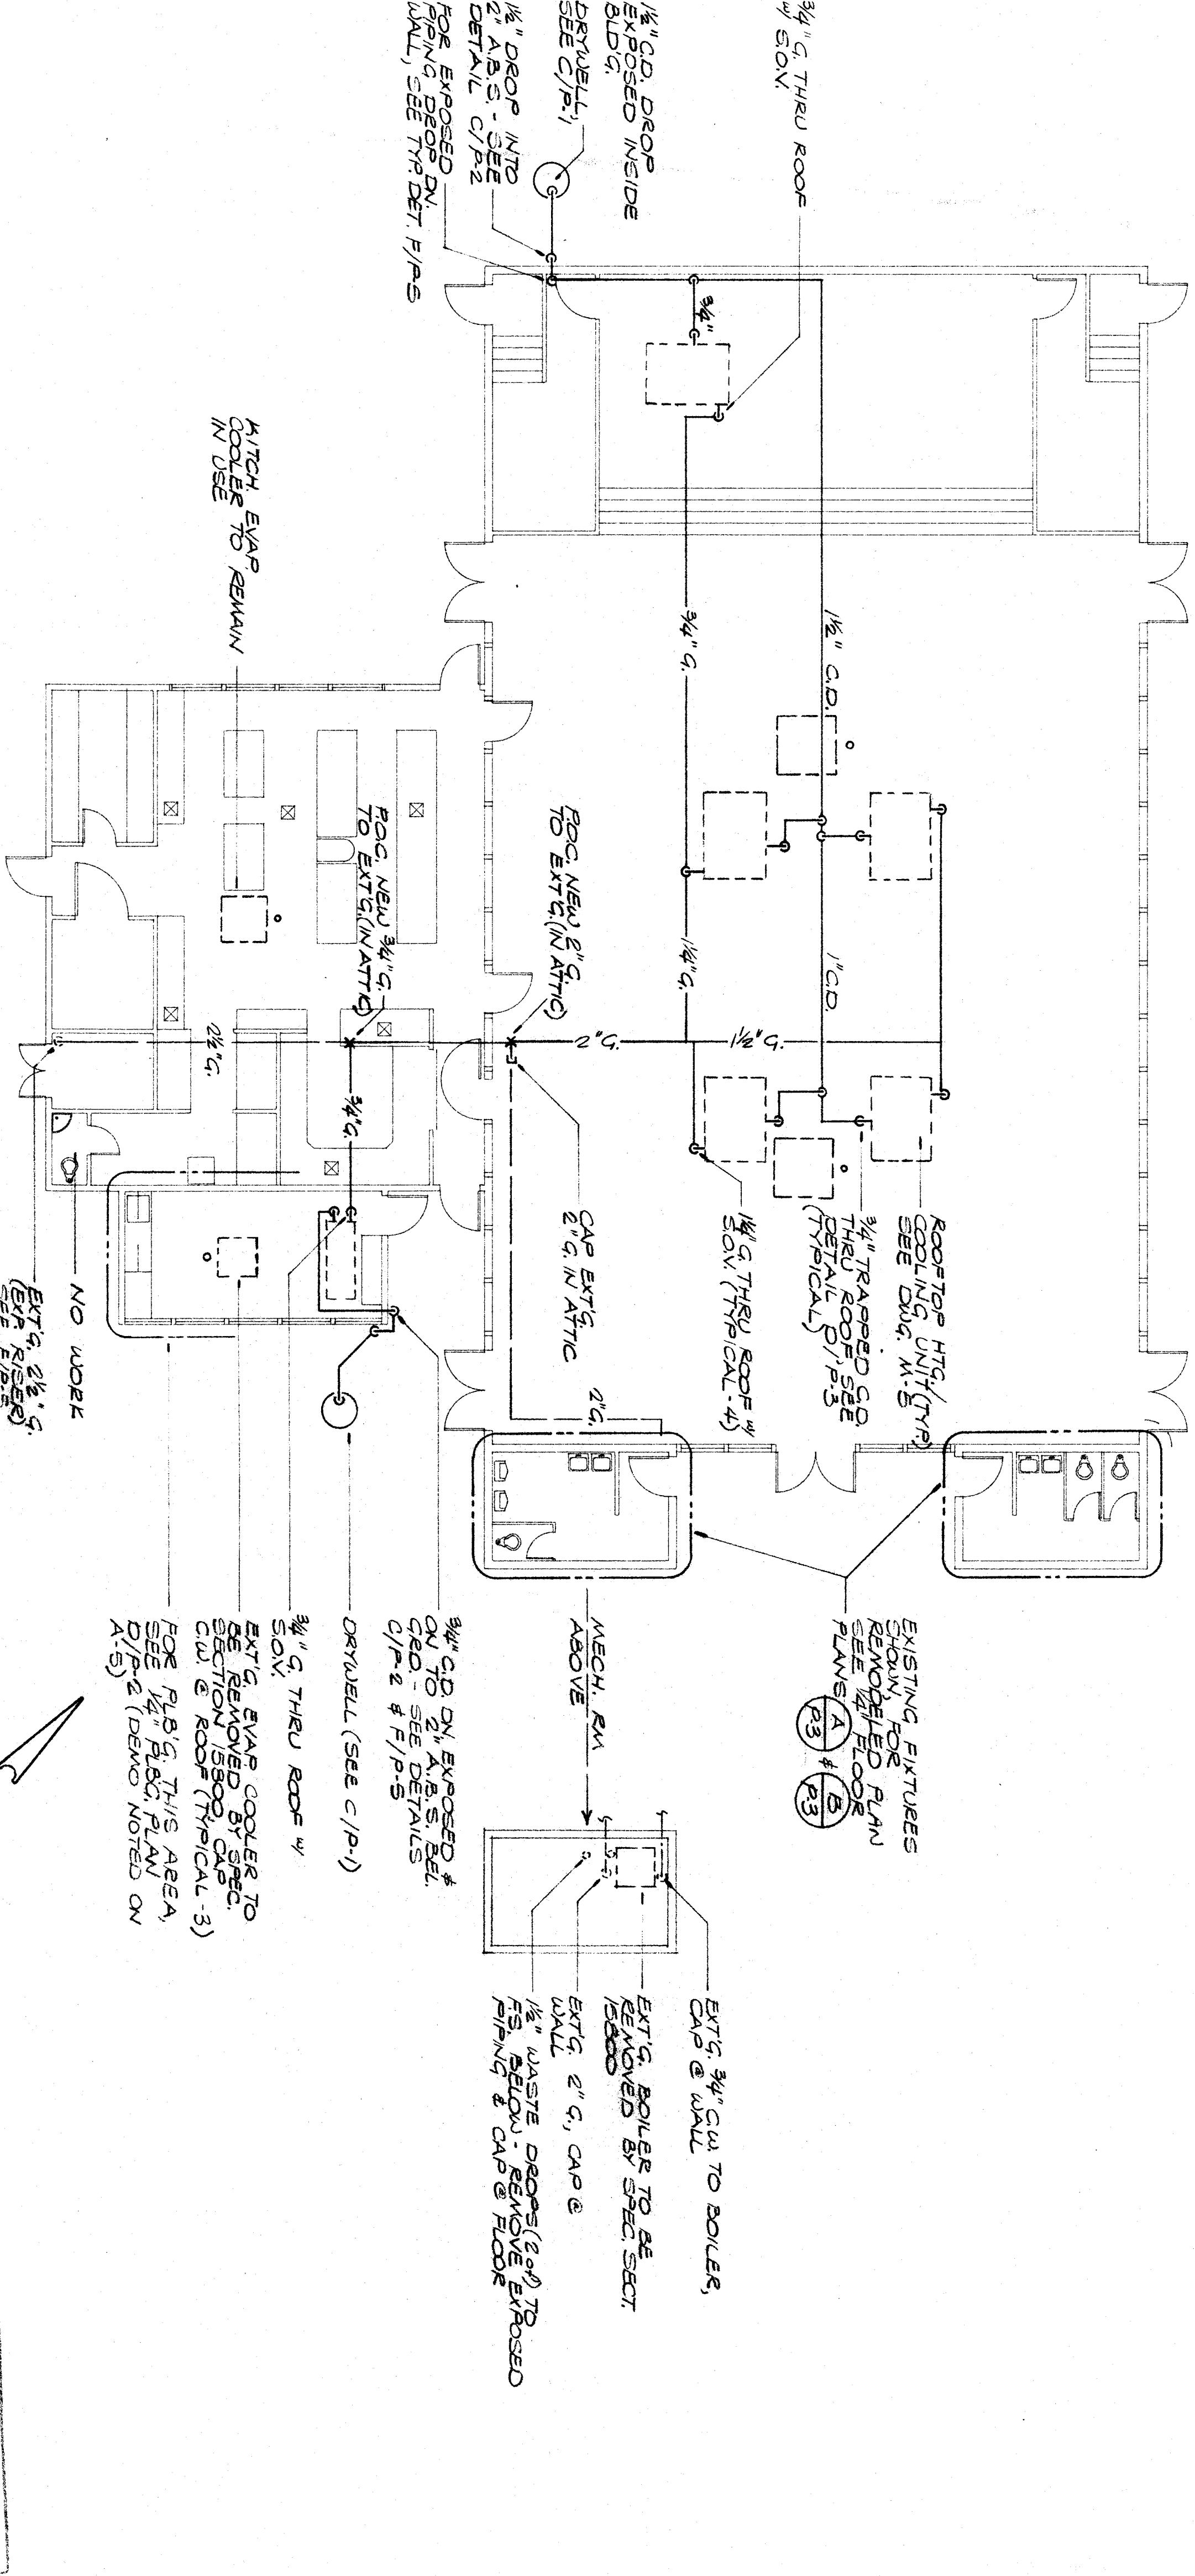


BUILDING A (PLUMBING FLOOR PLAN)
SCALE: 1/8" = 1'-0"


INFORMATION STAMP
Professional Seal
Date: 12/1/88
No. 45155 0

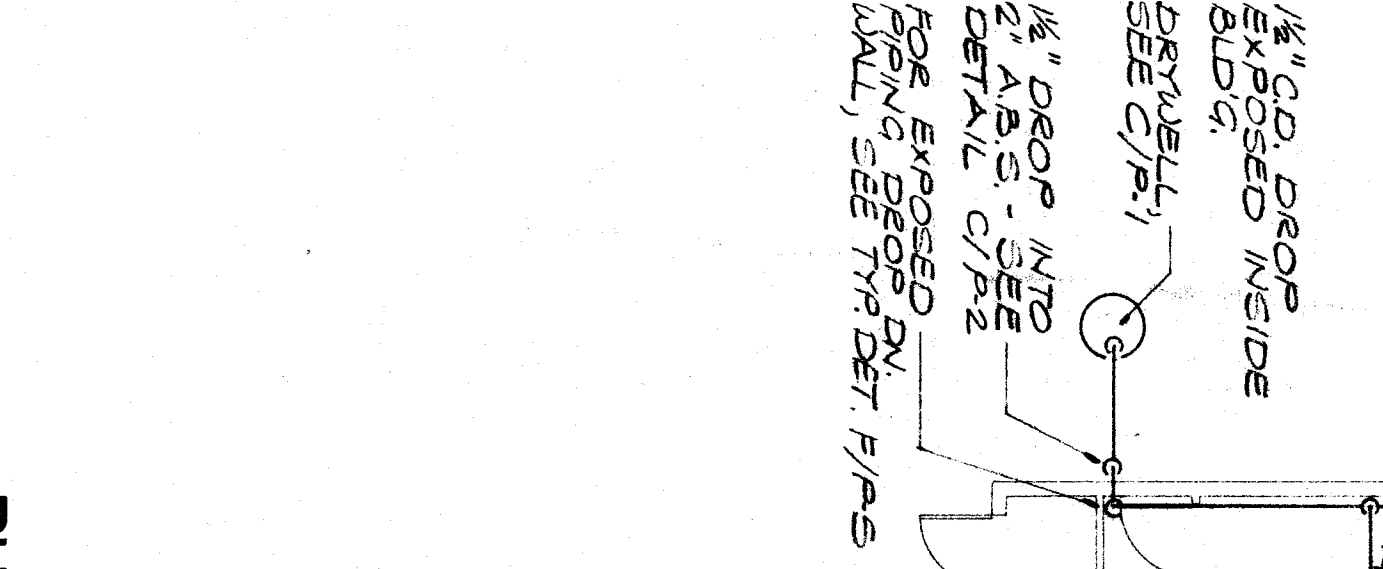

PARTIAL PIPING PLAN
SCALE: 1/4" = 1'-0"

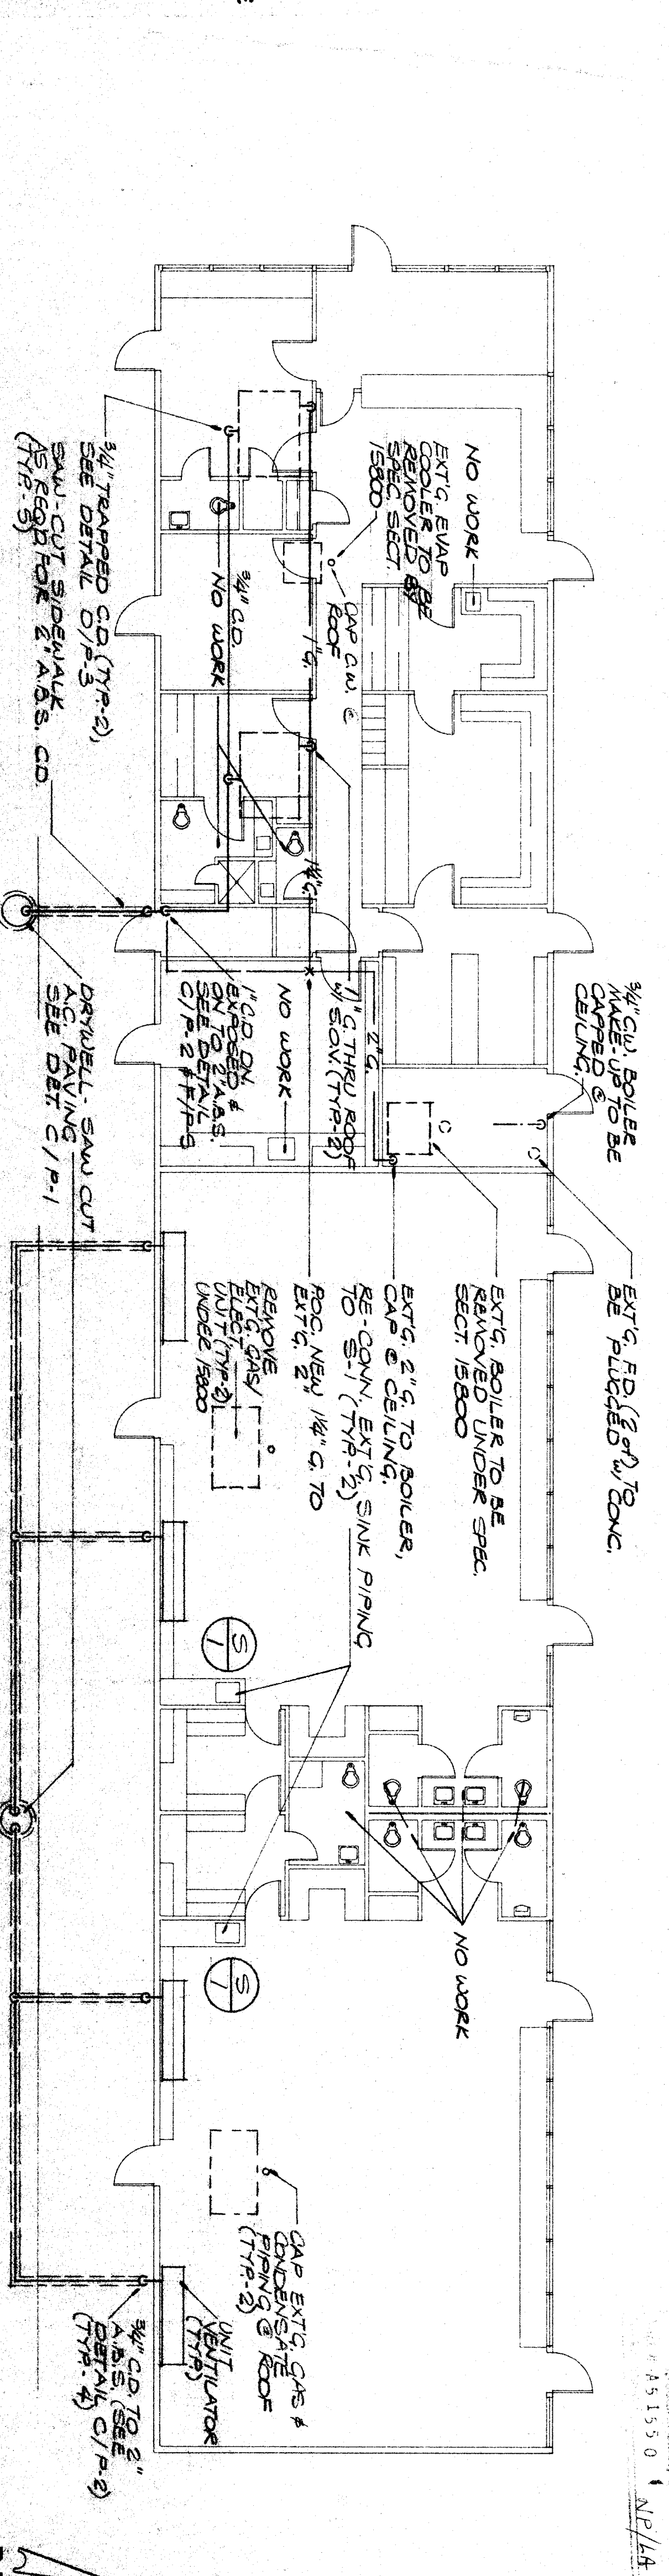

BUILDING B (PLUMBING FLOOR PLAN)
SCALE: 1/8" = 1'-0"

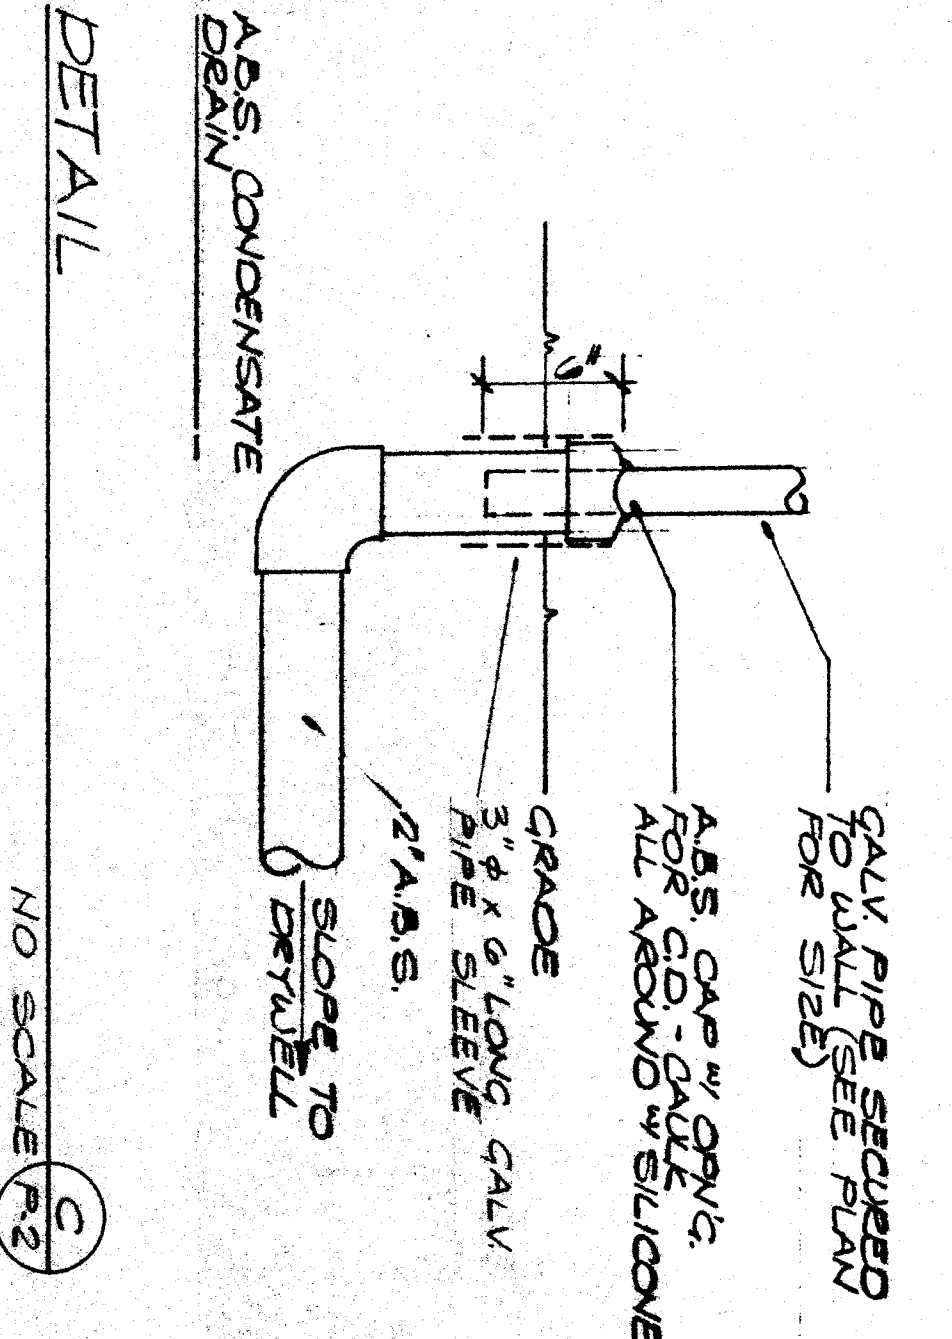

DETAIL
NO SCALE