


WING "A"

WING "D"

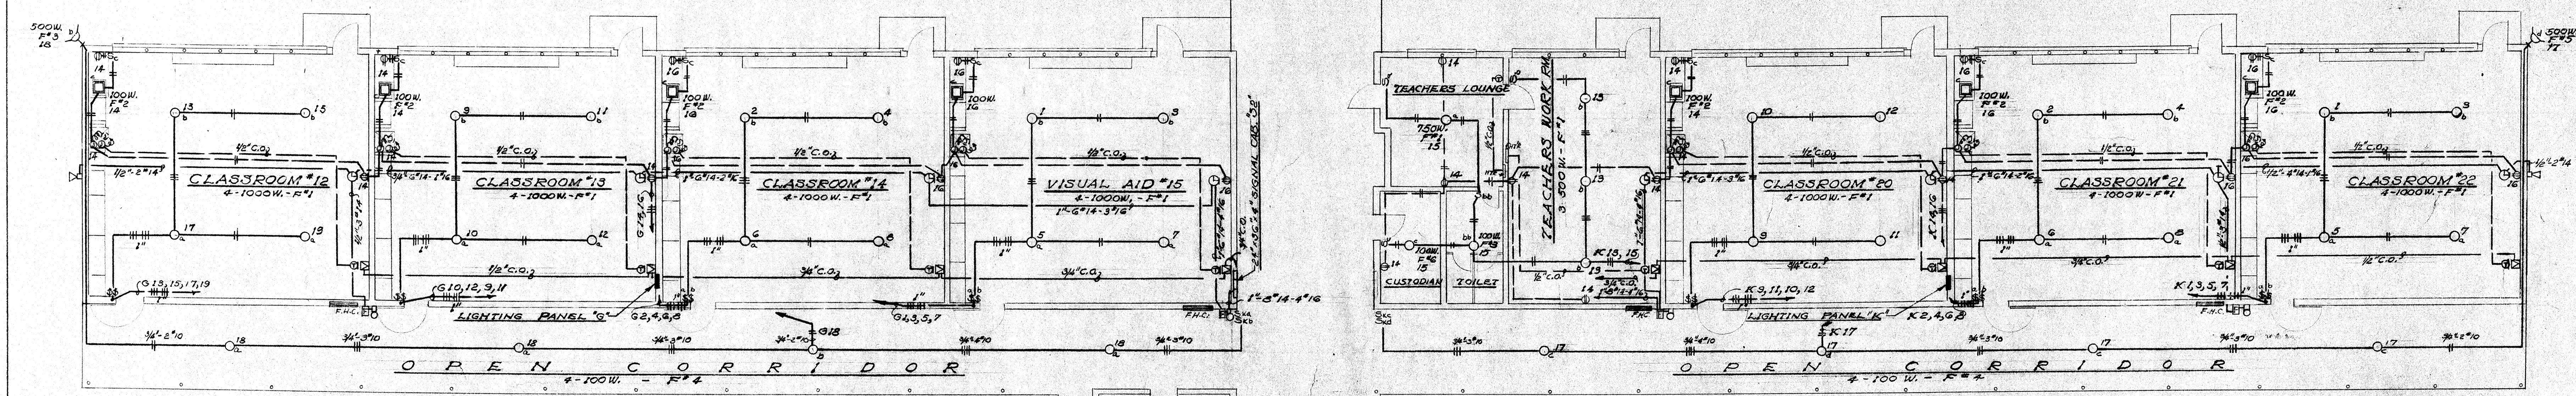

WING "B"

WING "E"

FLOOR PLAN
SCALE: 1/8" = 1'-0"

-ELECTRICAL-

HILBURG, BYLER & HENGSTLER
MECHANICAL AND ELECTRICAL ENGINEERS
257 SOUTH SPRING STREET
LOS ANGELES 12, CALIFORNIA

STATE OF CALIFORNIA
DEPARTMENT OF PUBLIC WORKS
DIVISION OF ARCHITECTURE
APPROVED 7-22-48
5742 Harry W. Boyle

BAKERSFIELD CITY SCHOOLS
1600 K. ST. BAKERSFIELD CAL.
BOARD OF EDUCATION
APPROVED 7/20 1948
PRESIDENT SECRETARY

ELEMENTARY SCHOOL
BAKERSFIELD CITY SCHOOL DIST.
PIONEER DRIVE
BAKERSFIELD CALIFORNIA
ERNEST L. MC COY A.I.A.
ARCHITECT
102-19th ST. CALIFORNIA

DATE 7/15/48
DRAWN BY
CHECKED BY
SH. NO.
OF SHEET
E-3
OF 54 A

